


**CONTIGUOUS ELEVATION C**  
- Scale 1:300



As agreed with South Dublin County Council in the pre-application consultation meeting the final finishes, including cladding materials and colour codes, will be agreed with the Council post planning through planning condition. Greener Ideas Limited will ensure only Council approved finishes are applied on site.

Rev	Date	Description	By	Chkd.
B	23.05.22	CFI ISSUE	MIN	LB
A	02.03.22	PLANNING ISSUE	MIN	MIMC

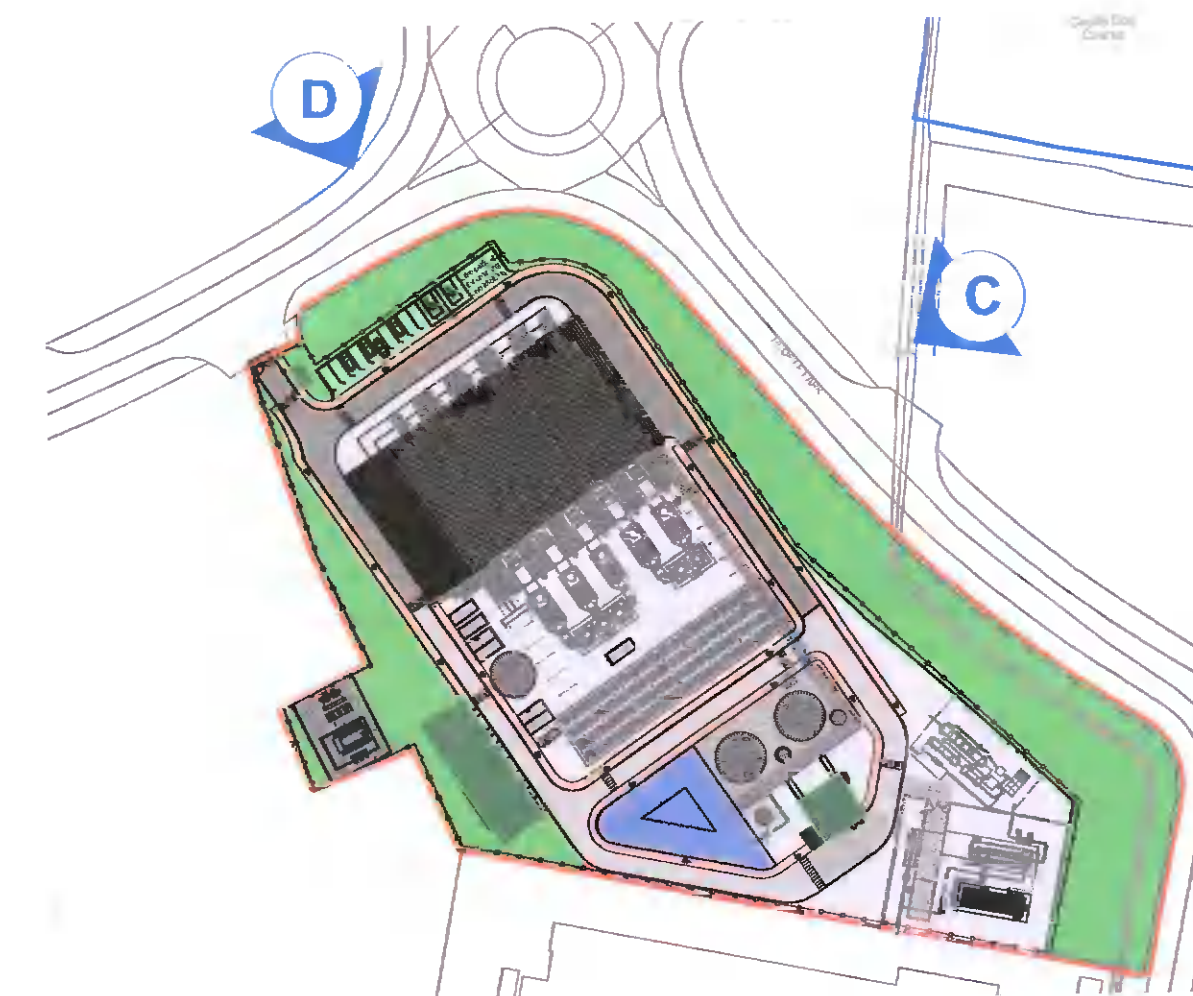


Project:  
**PROFILE PARK POWER PLANT**

Title:  
**CONTIGUOUS ELEVATION Sheet 2 of 3**

Scale @ A1: 1:300  
 Prepared by: M. Nolan  
 Checked: M. McCarthy  
 Date: March 2022  
 Project Director: S. Tinnelly  
 Drawing Status: Planning

**TOBIN**  
CONSULTING ENGINEERS  
 Block 10-4, Blanchardstown Corporate Park,  
 Dublin 15, Ireland.  
 tel: +353-(0)1-8030406  
 fax: +353-(0)1-8030409  
 e-mail: dublin@tobin.ie  
 www.tobin.ie

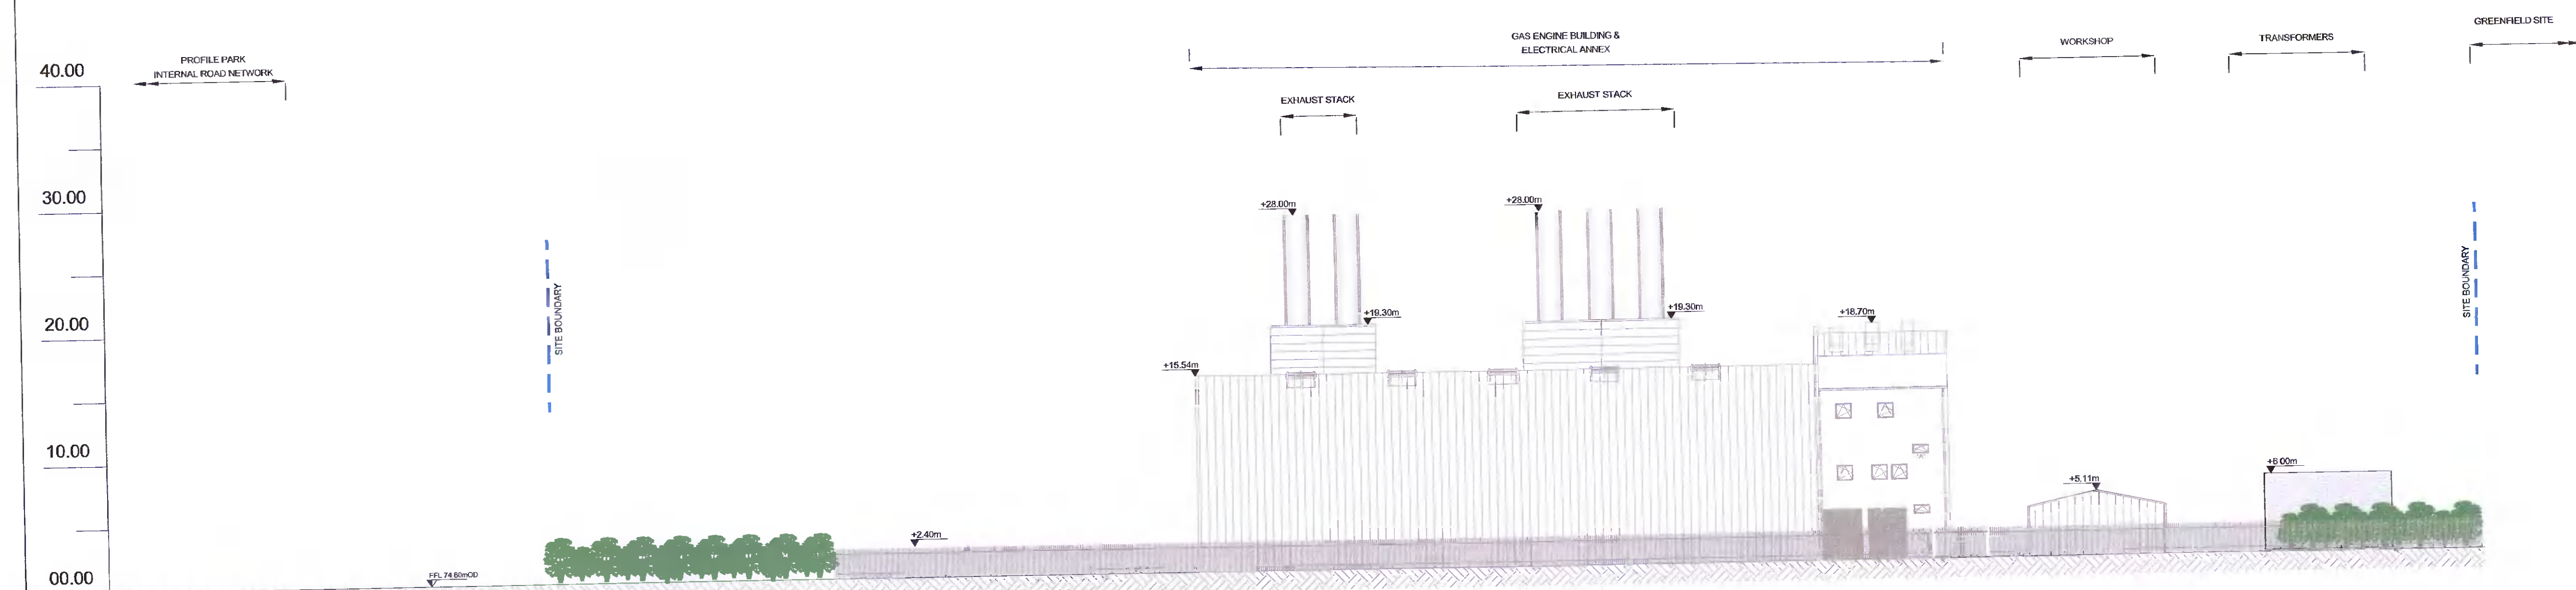

**CONTIGUOUS ELEVATION D**  
- Scale 1:300

Drawing No.: 11069-2060

Revision: **B**