


LEGEND	
	1 Bed 2 People
	2 Bed 3 People
	2 Bed 4 People
	3 Bed 5 People
	2 Bed Duplex
	Stuido - Work Unit
	2 Bed - Work Unit
	Commercial
	Amenity
	Bike parking
	Car parking
	Bin storage
	District Heating Plant Room
	Incoming Telco's Room
	Service/Riser
	Circulation

1 Section 01
1 : 200

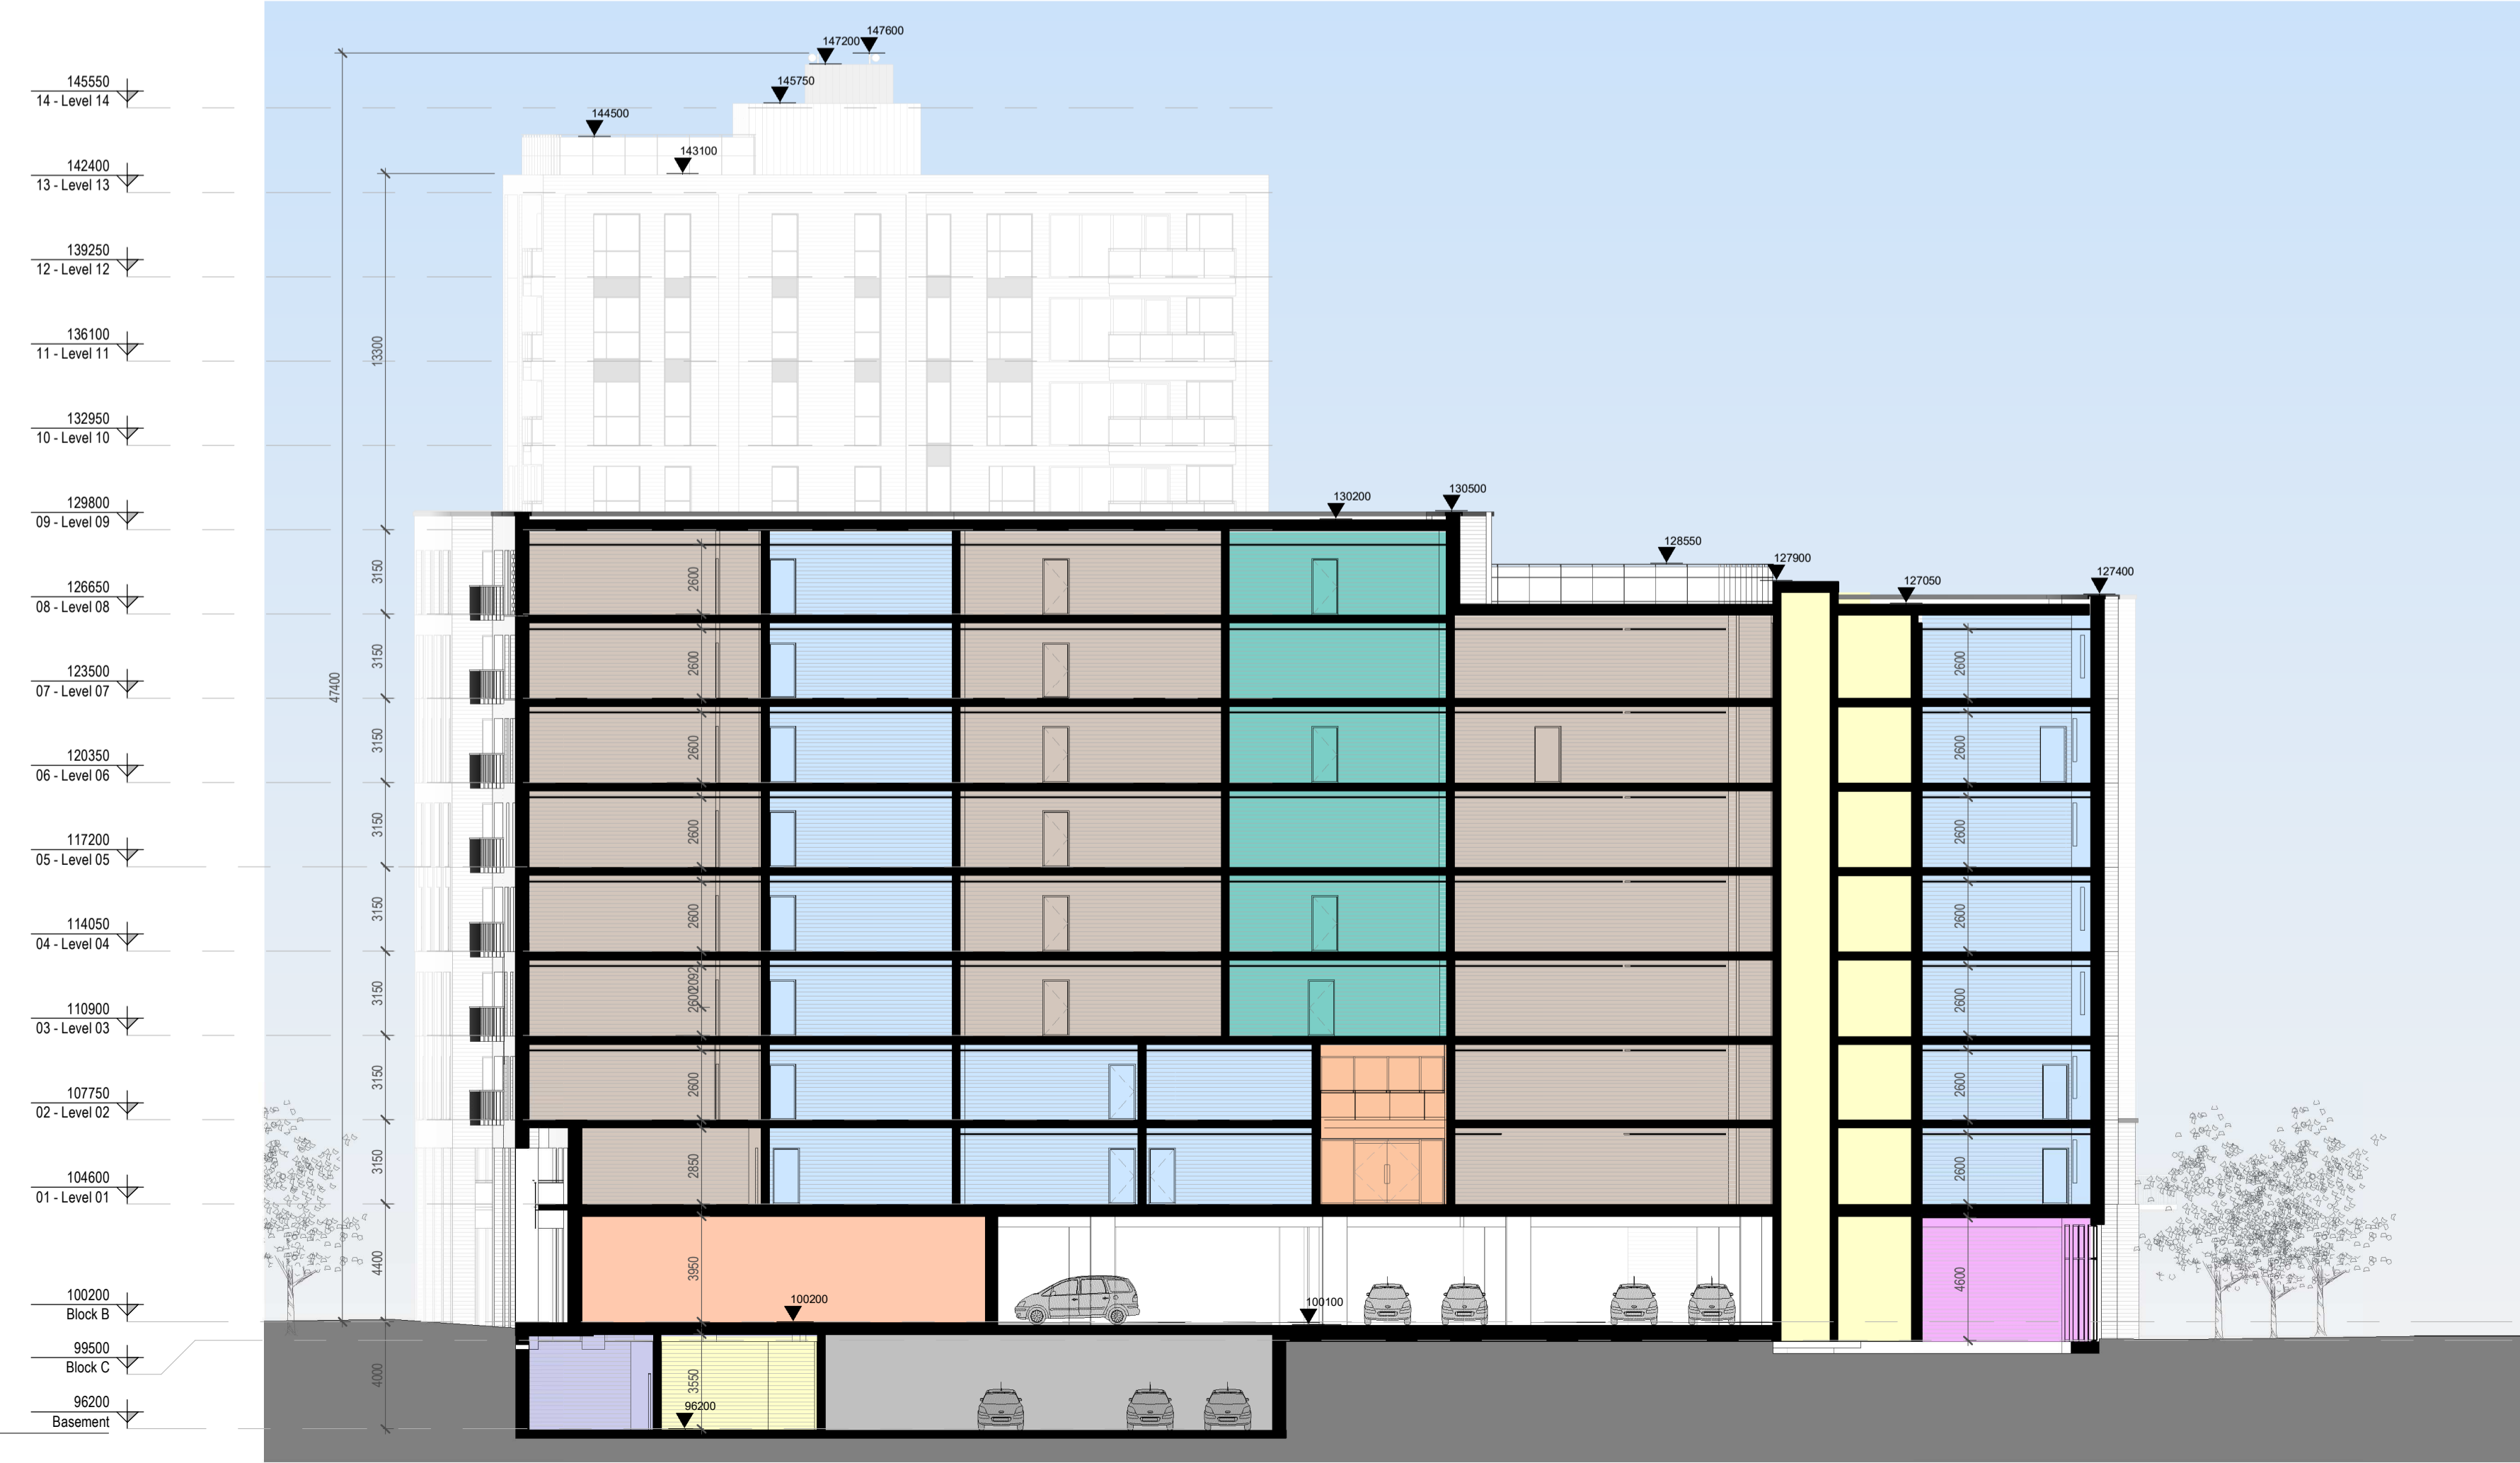

2 Section 02
1 : 200



REV	DATE	SIGNED	NOTES
P01	12/05/2022	SOD	Issued for SHD Application

Project Stage

SHD Application

Client

Landmarque Property Group Ltd

Project

Belgard Rd, Tallaght

Drawing Title

SECTIONS - 01 & 02

Drawn	Checked	Scale @ A1	As	Date
AB	SOD	As indicated		01/06/21

Project No.	Drawing No.
19-150	2301

Drawing BIM Name:
PE19150-CWO-XX-XX-DR-A-2301

CDE Area	Suitability Code	BIM Revision
		P01



1 Sarsfield Quay, Arbour Hill, Dublin 7
t: 01 518 0170 e: admin@cwoarchitects.ie
Dublin | London | Warwick | Manchester
www.cwoarchitects.ie