



LEGEND	
■	1 Bed 2 People
■	2 Bed 3 People
■	2 Bed 4 People
■	3 Bed 5 People
■	2 Bed Duplex
■	Stuido - Work Unit
■	2 Bed - Work Unit
■	Commercial
■	Amenity
■	Bike parking
■	Car parking
■	Bin storage
■	District Heating Plant Room
■	Incoming Telco's Room
■	Service/Riser
■	Circulation

1 Section 03
1: 200

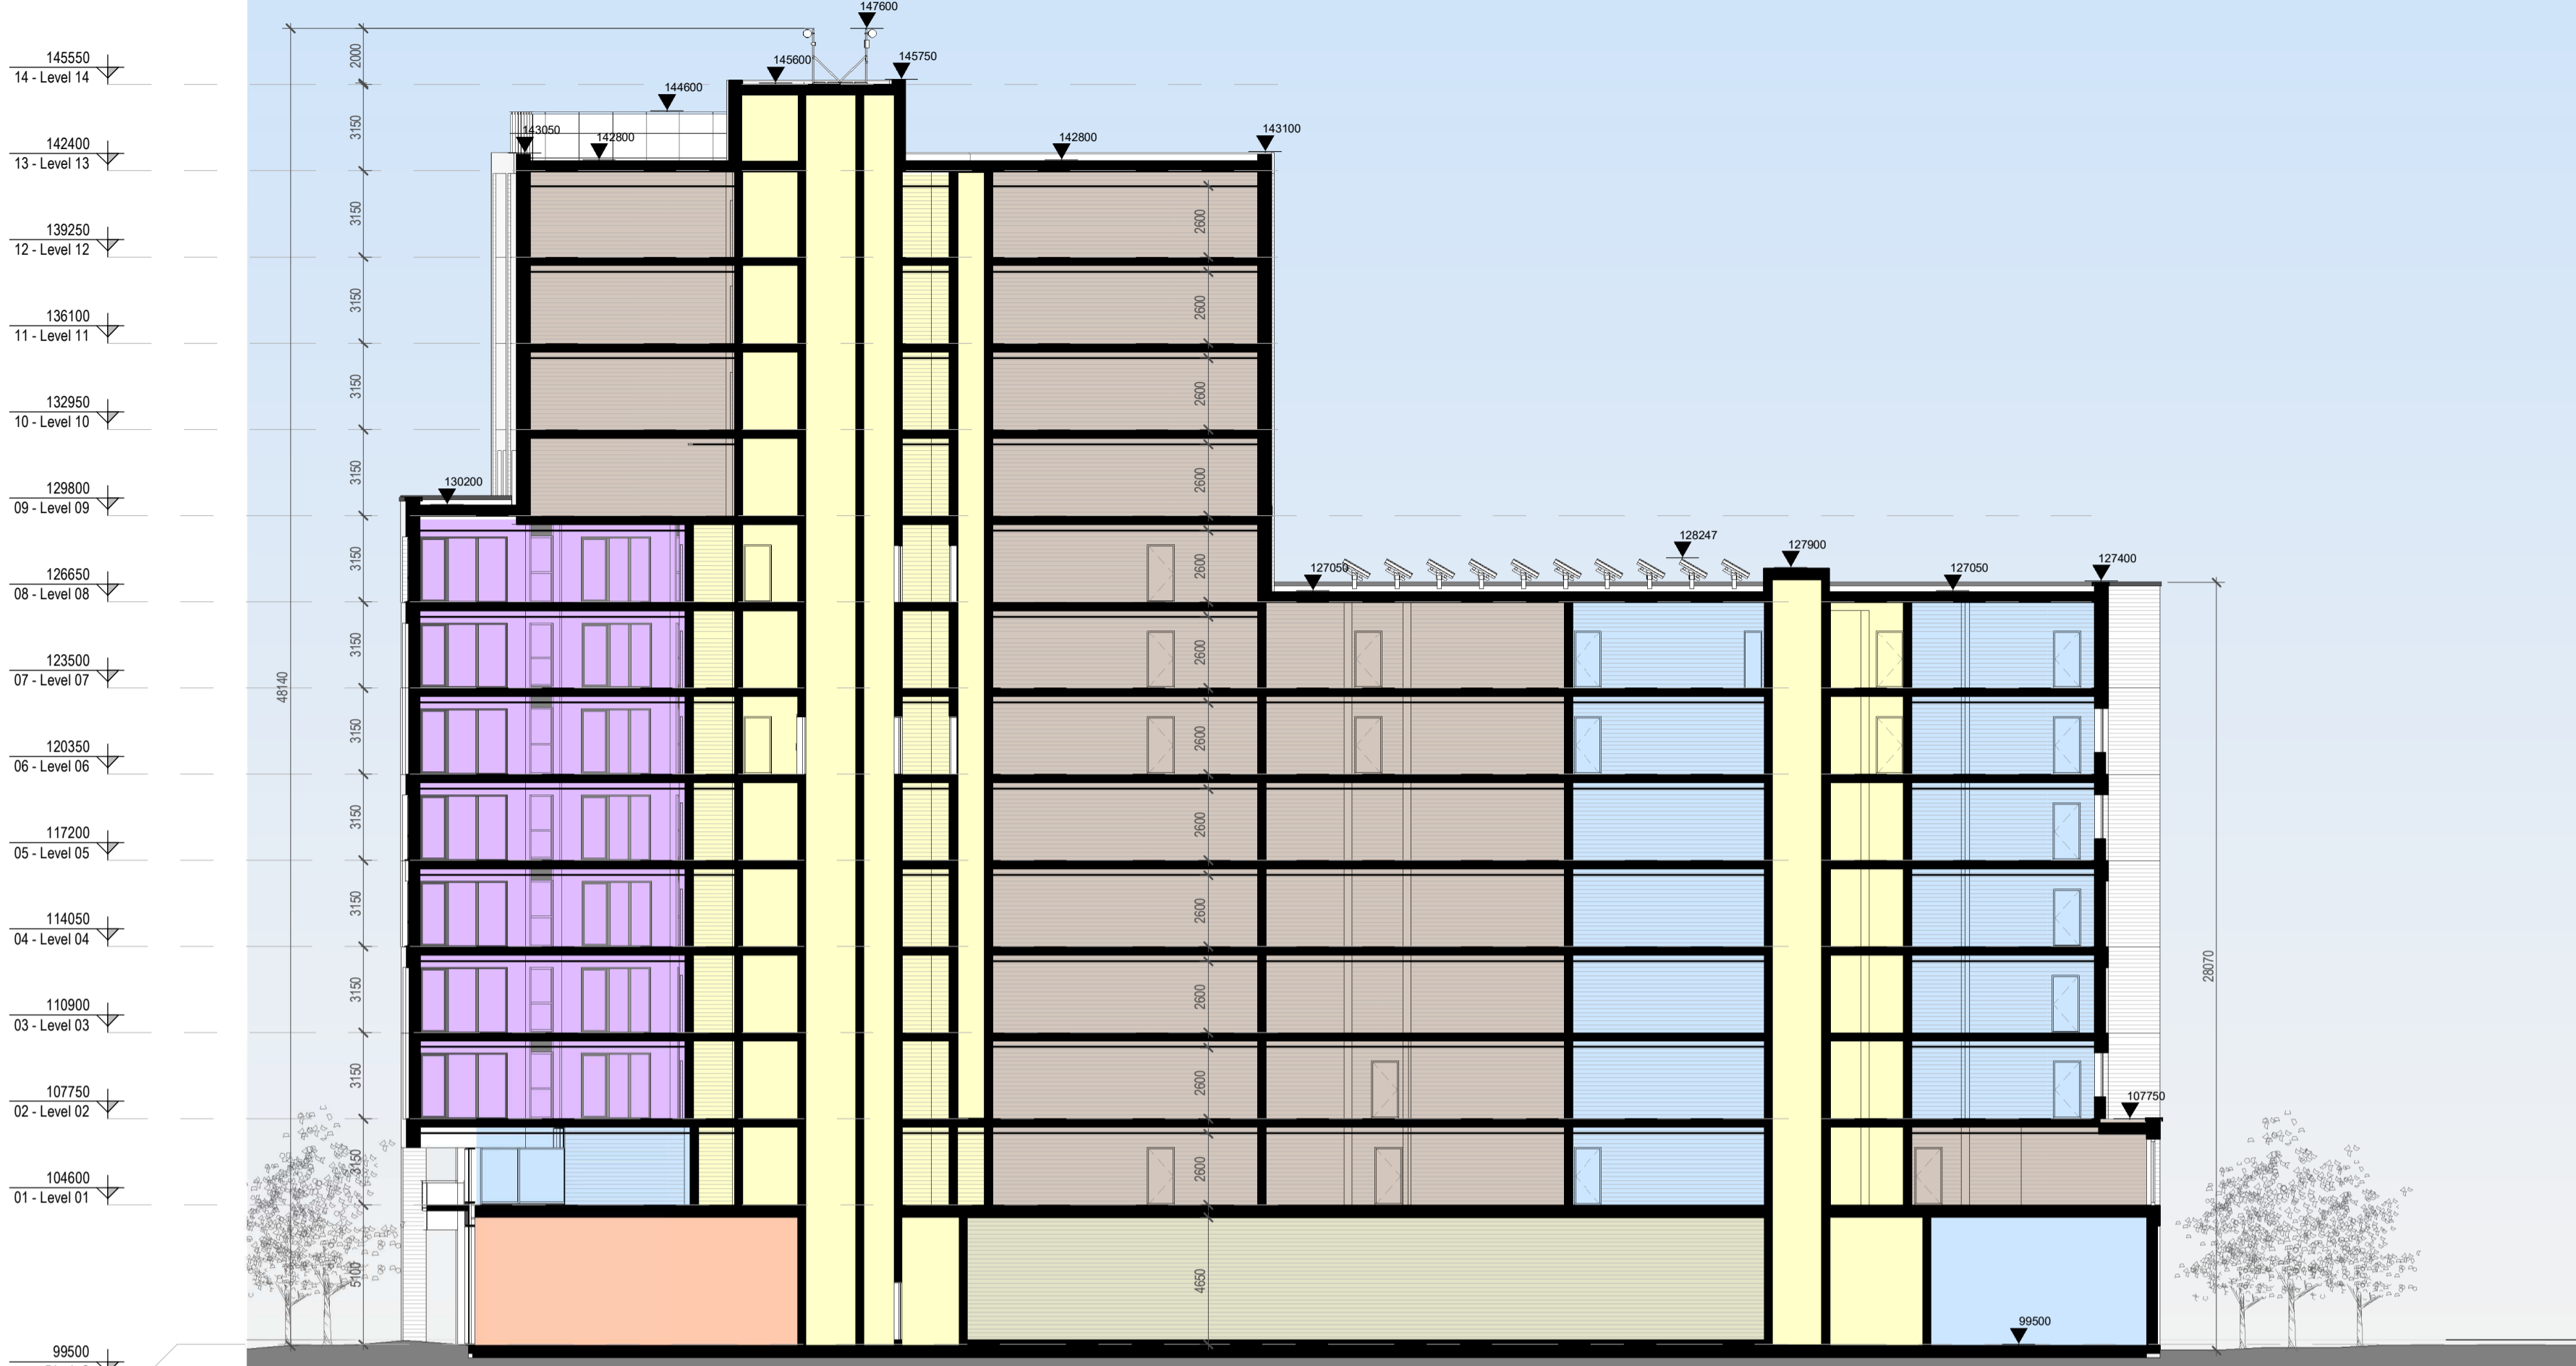

2 Section 04
1: 200

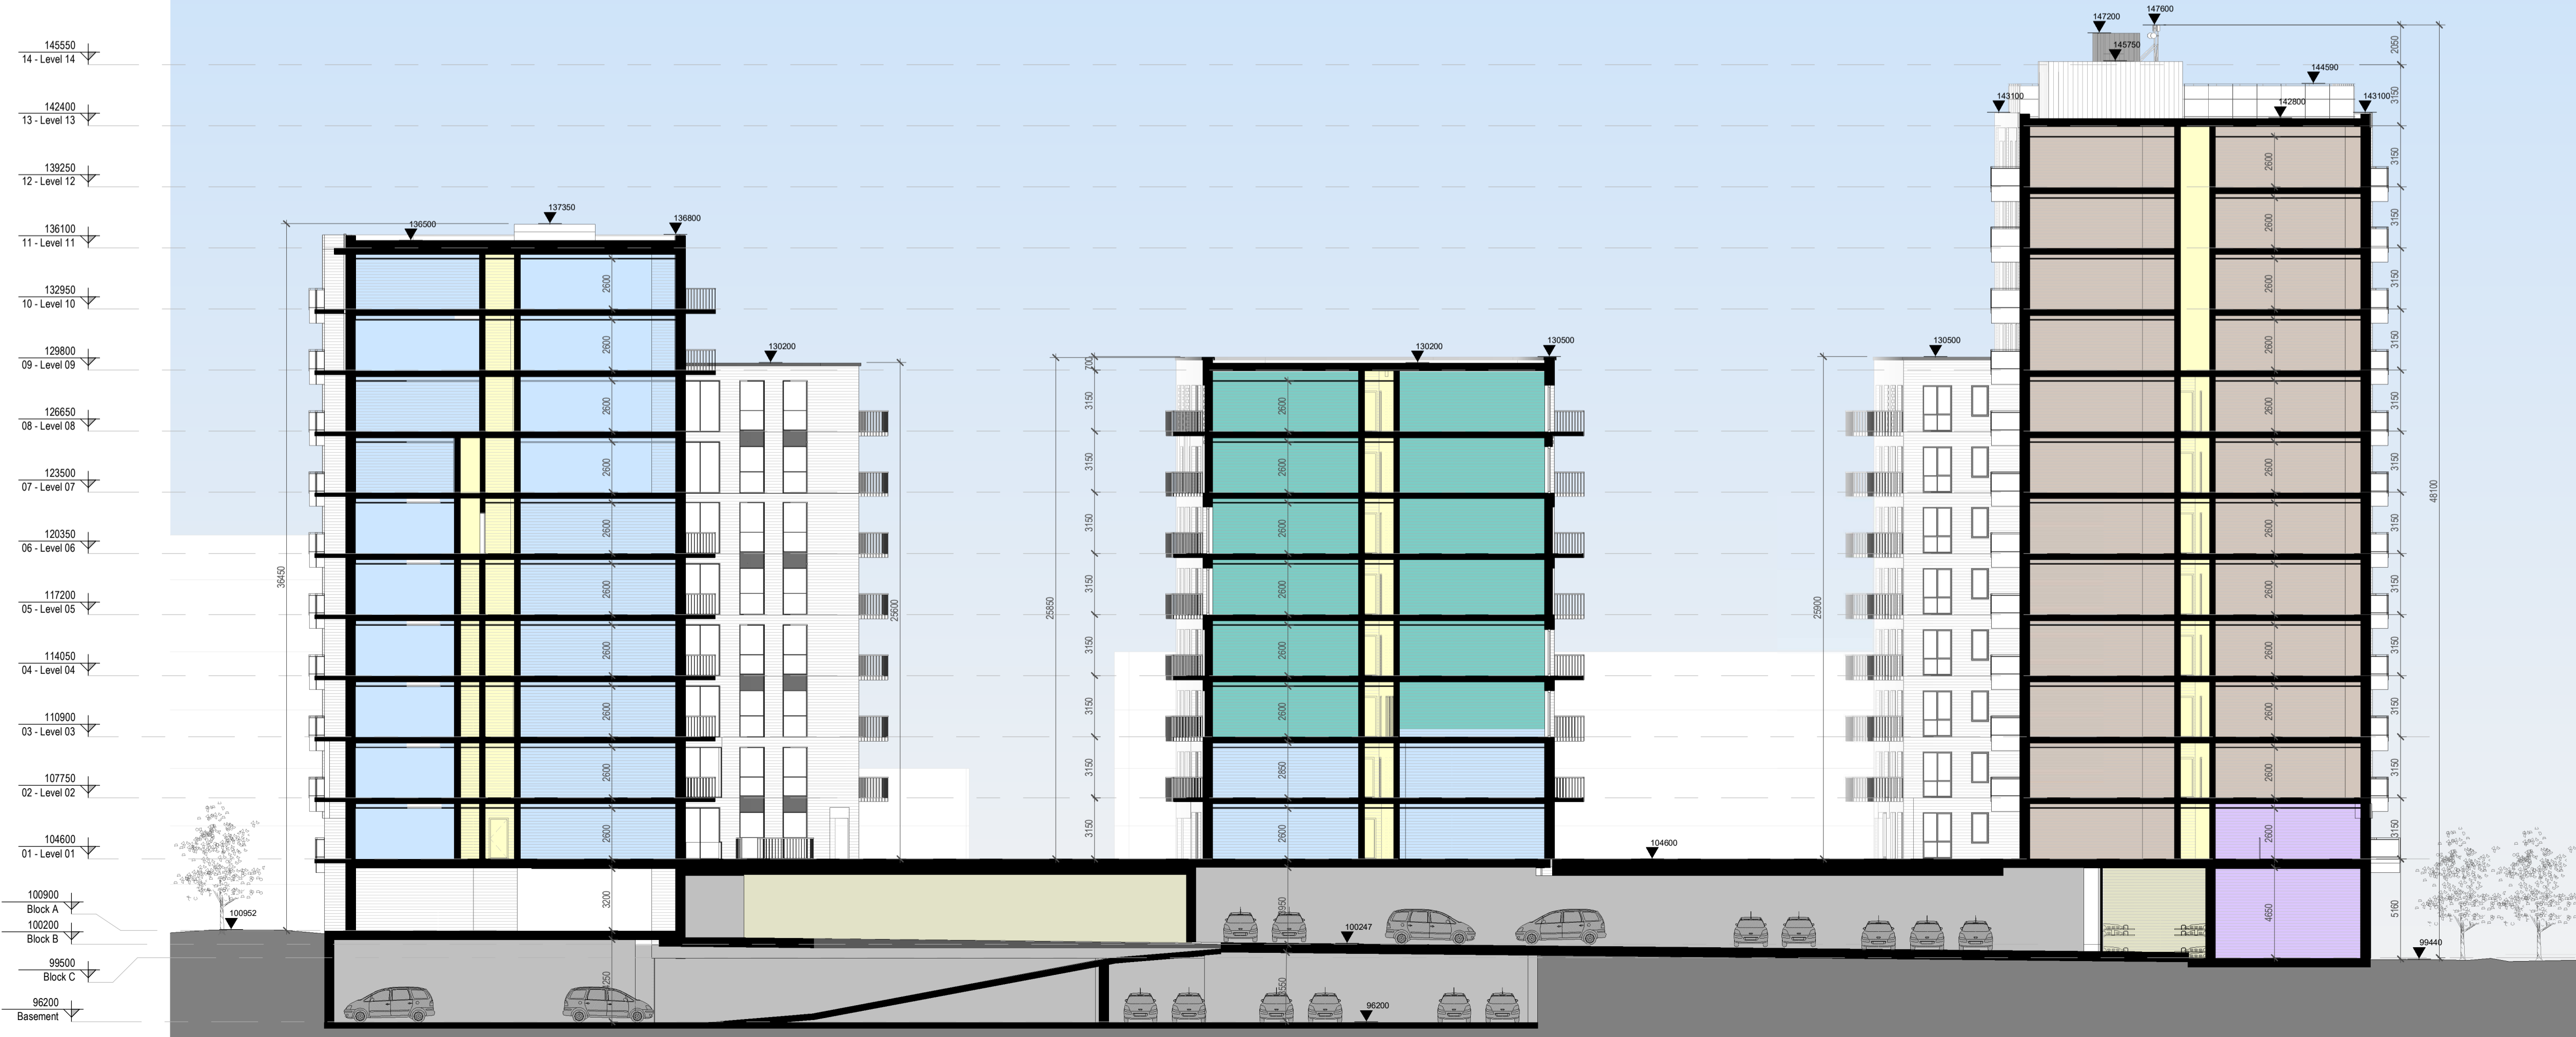

REV	DATE	SIGNED	NOTES
P01	12/05/2022	SOD	Issued for SHD Application

Project Stage			
SHD Application			
Client			
Landmarque Property Group Ltd			
Project			
Belgard Rd, Tallaght			
Drawing Title			
SECTIONS - 03 & 04			
Drawn	Checked	Scale @ A1	As Date
AB	SOD	indicated	01/06/21
Project No.	Drawing No.		
19-150	2302		
Drawing BIM Name:			
PE19150-CWO-XX-XX-DR-A-2302			
CDE Area	Suitability Code	BIM Revision	
		P01	