




DRAINAGE LAYOUT
SCALE 1:125

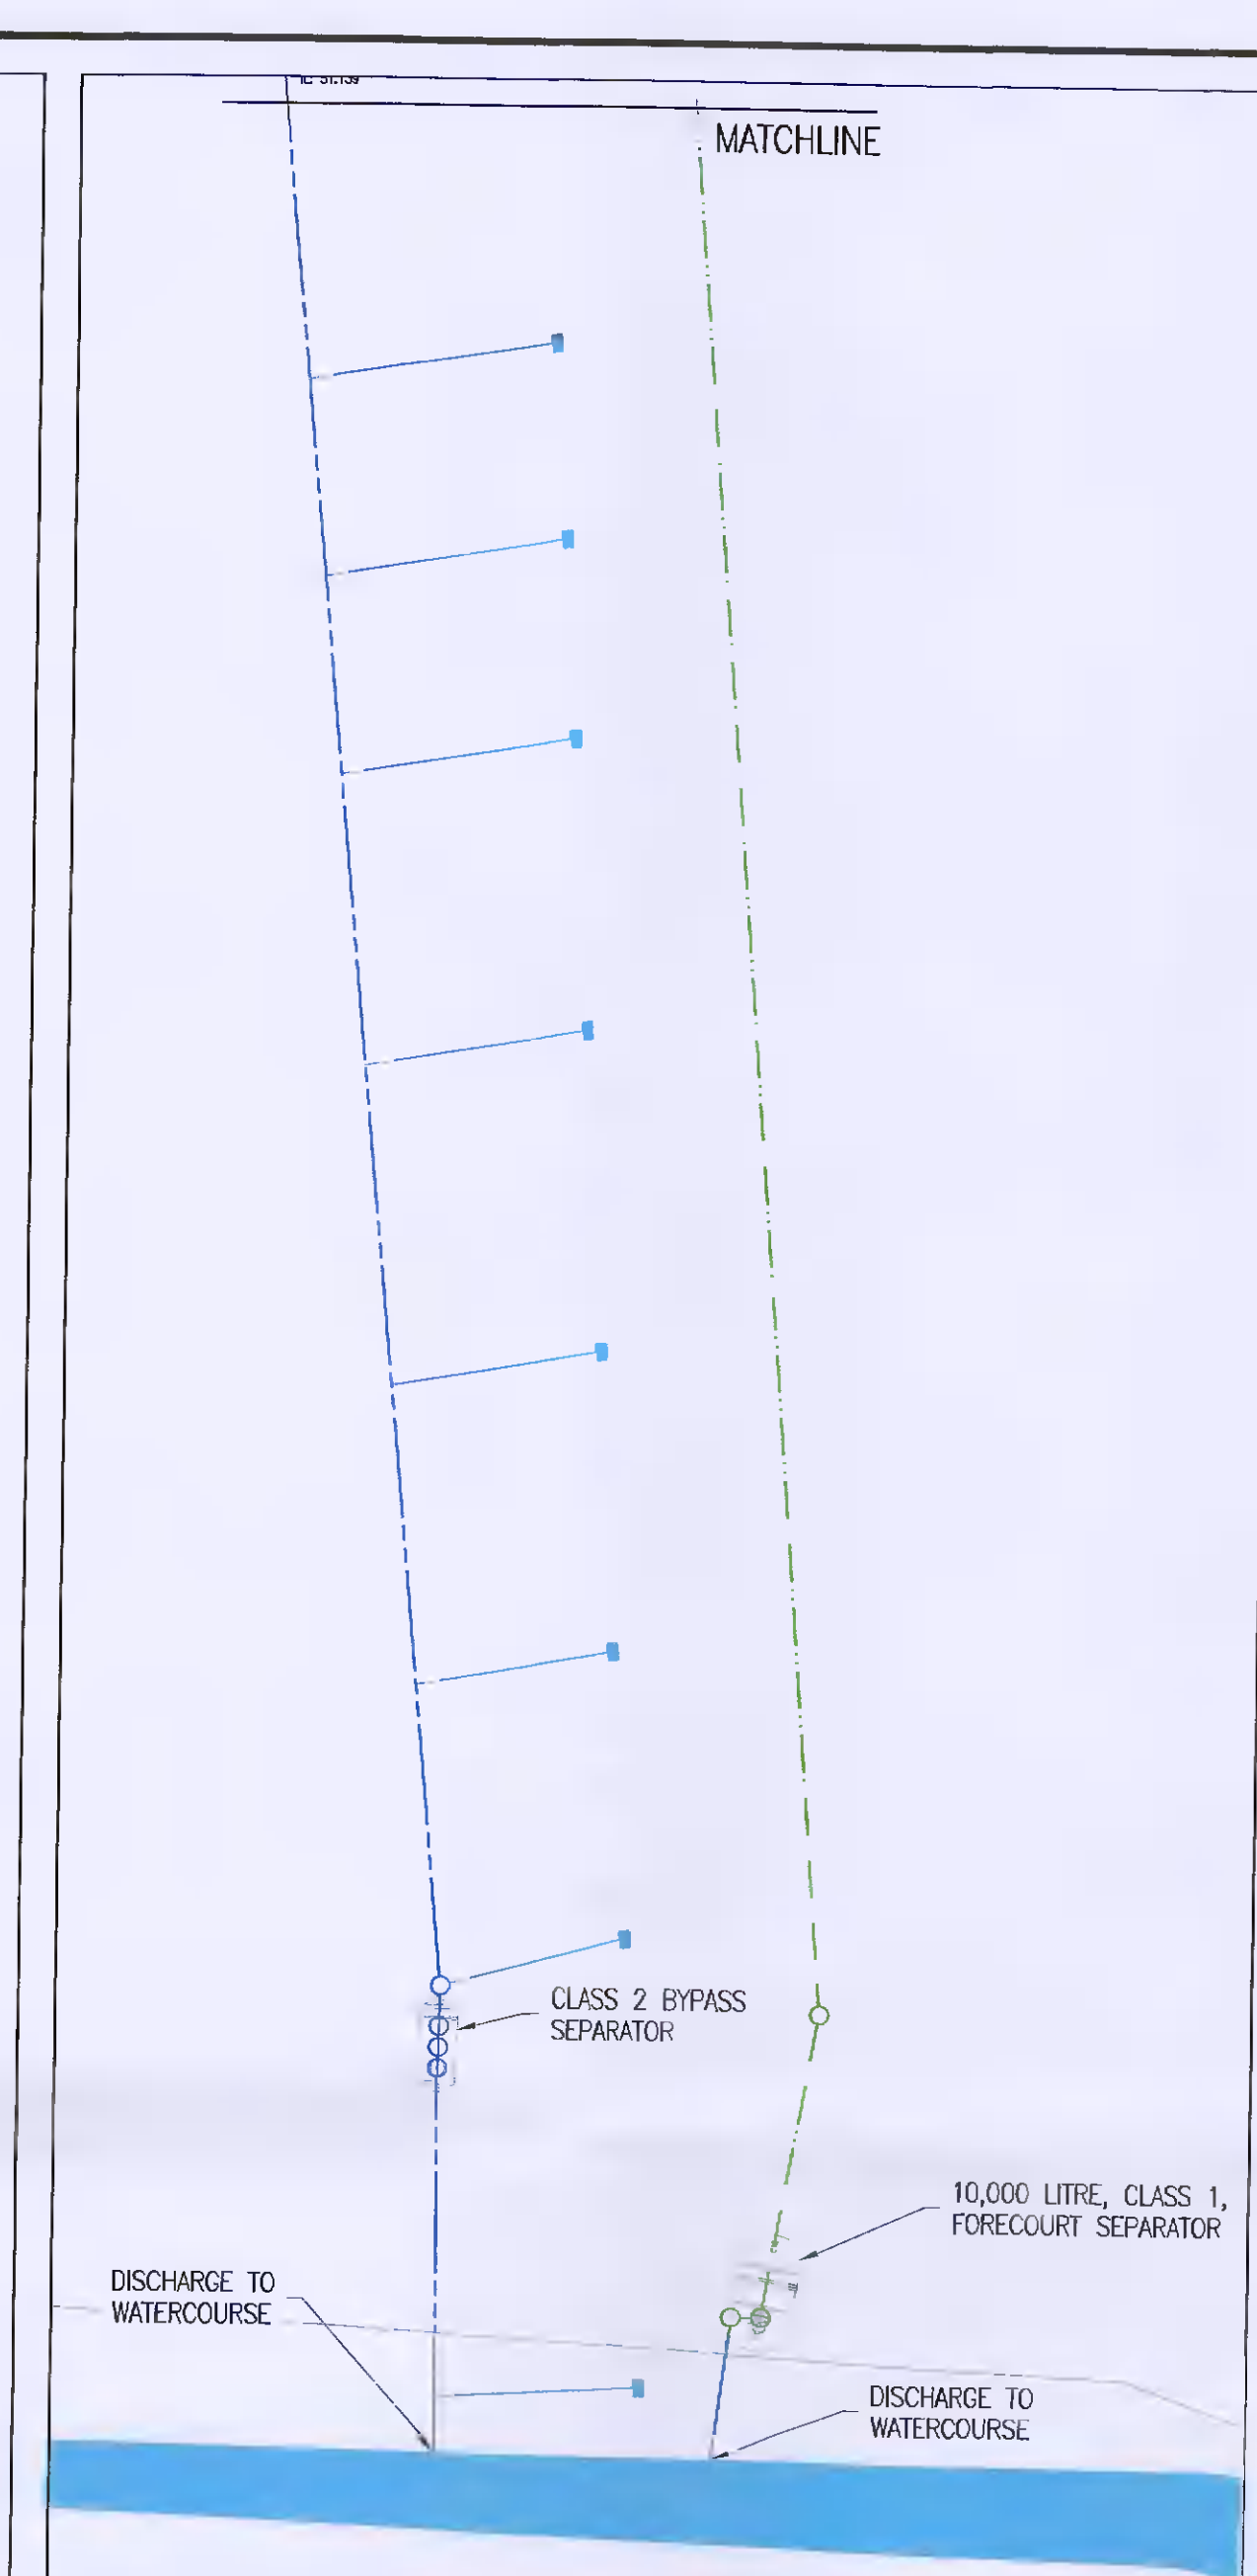

INTERCEPTOR AND DISCHARGE TO WATERCOURSE
SCALE 1:250



KEY PLAN
SCALE 1:1000

NOTES:
THIS DRAWING IN WHOLE OR IN PART SHALL NOT BE COPIED WITHOUT THE PRIOR PERMISSION OF McArdle DOYLE LTD.
ALL WORKS TO COMPLY WITH THE CURRENT BUILDING REGULATIONS.
DO NOT SCALE.
ORDNANCE SURVEY IRELAND LICENCE No. AR 0105719
© ORDNANCE SURVEY IRELAND / GOVERNMENT OF IRELAND

LEGEND:

- EXISTING STORM SEWER
- EXISTING CONTAMINATED STORM SEWER
- EXISTING FOUW SEWER
- EXISTING CONCRETE CHANNEL DRAIN (STORM)
- EXISTING CONCRETE CHANNEL DRAIN (STORM - CONTAMINATED)
- PROPOSED STORM SEWER

Rev.	Description	By	Date
1	ISSUED FOR PLANNING COMPLIANCE	GR	02.06.22

McArdle Doyle
Second Floor
Exchange Building
The Long Walk
Dundalk, Co. Louth

Chartered Engineers
Architectural Services
& Project Managers
mail@mcdoyle.ie
+353(0) 42 942 9032

PROJECT:
RETENTION OF DEVELOPMENT AT
12 CRAIG AVENUE, CLONDALKIN
INDUSTRIAL ESTATE

CLIENT:
EMO OIL LTD.

DRAWING TITLE:
DRAINAGE LAYOUT

Date	Drawn	Checked	Approved
02/06/22	GR	RMCA	RMCA

Scale of A1 AS SHOWN Drawing Number P1922.COM.C03 Status Rev. PC -