





HAZARD IDENTIFICATION (if none state none relevant)	CONTROL AND MITIGATION MEASURES

NOTE:
 Hazards listed above are only those considered significant risks and:
 a) not likely to be obvious to a competent contractor or other designers,
 b) unusual, or
 c) likely to be difficult to manage effectively


- LEGEND:**
- SITE BOUNDARY - AREA SUBJECT TO THIS PLANNING APPLICATION
 - AREA IN OWNERSHIP OF THE CLIENT - PERMITTED UNDER PLANNING REG REF: SD231A/0186
 - OUTLINE OF DB8 AS PREVIOUSLY PERMITTED - AREA OF DB8 AS PREVIOUS PLANNING APPLICATION
 - OUTLINE OF PROPOSED GENERATOR COMPOUND - AREA OF GENERATOR COMPOUND

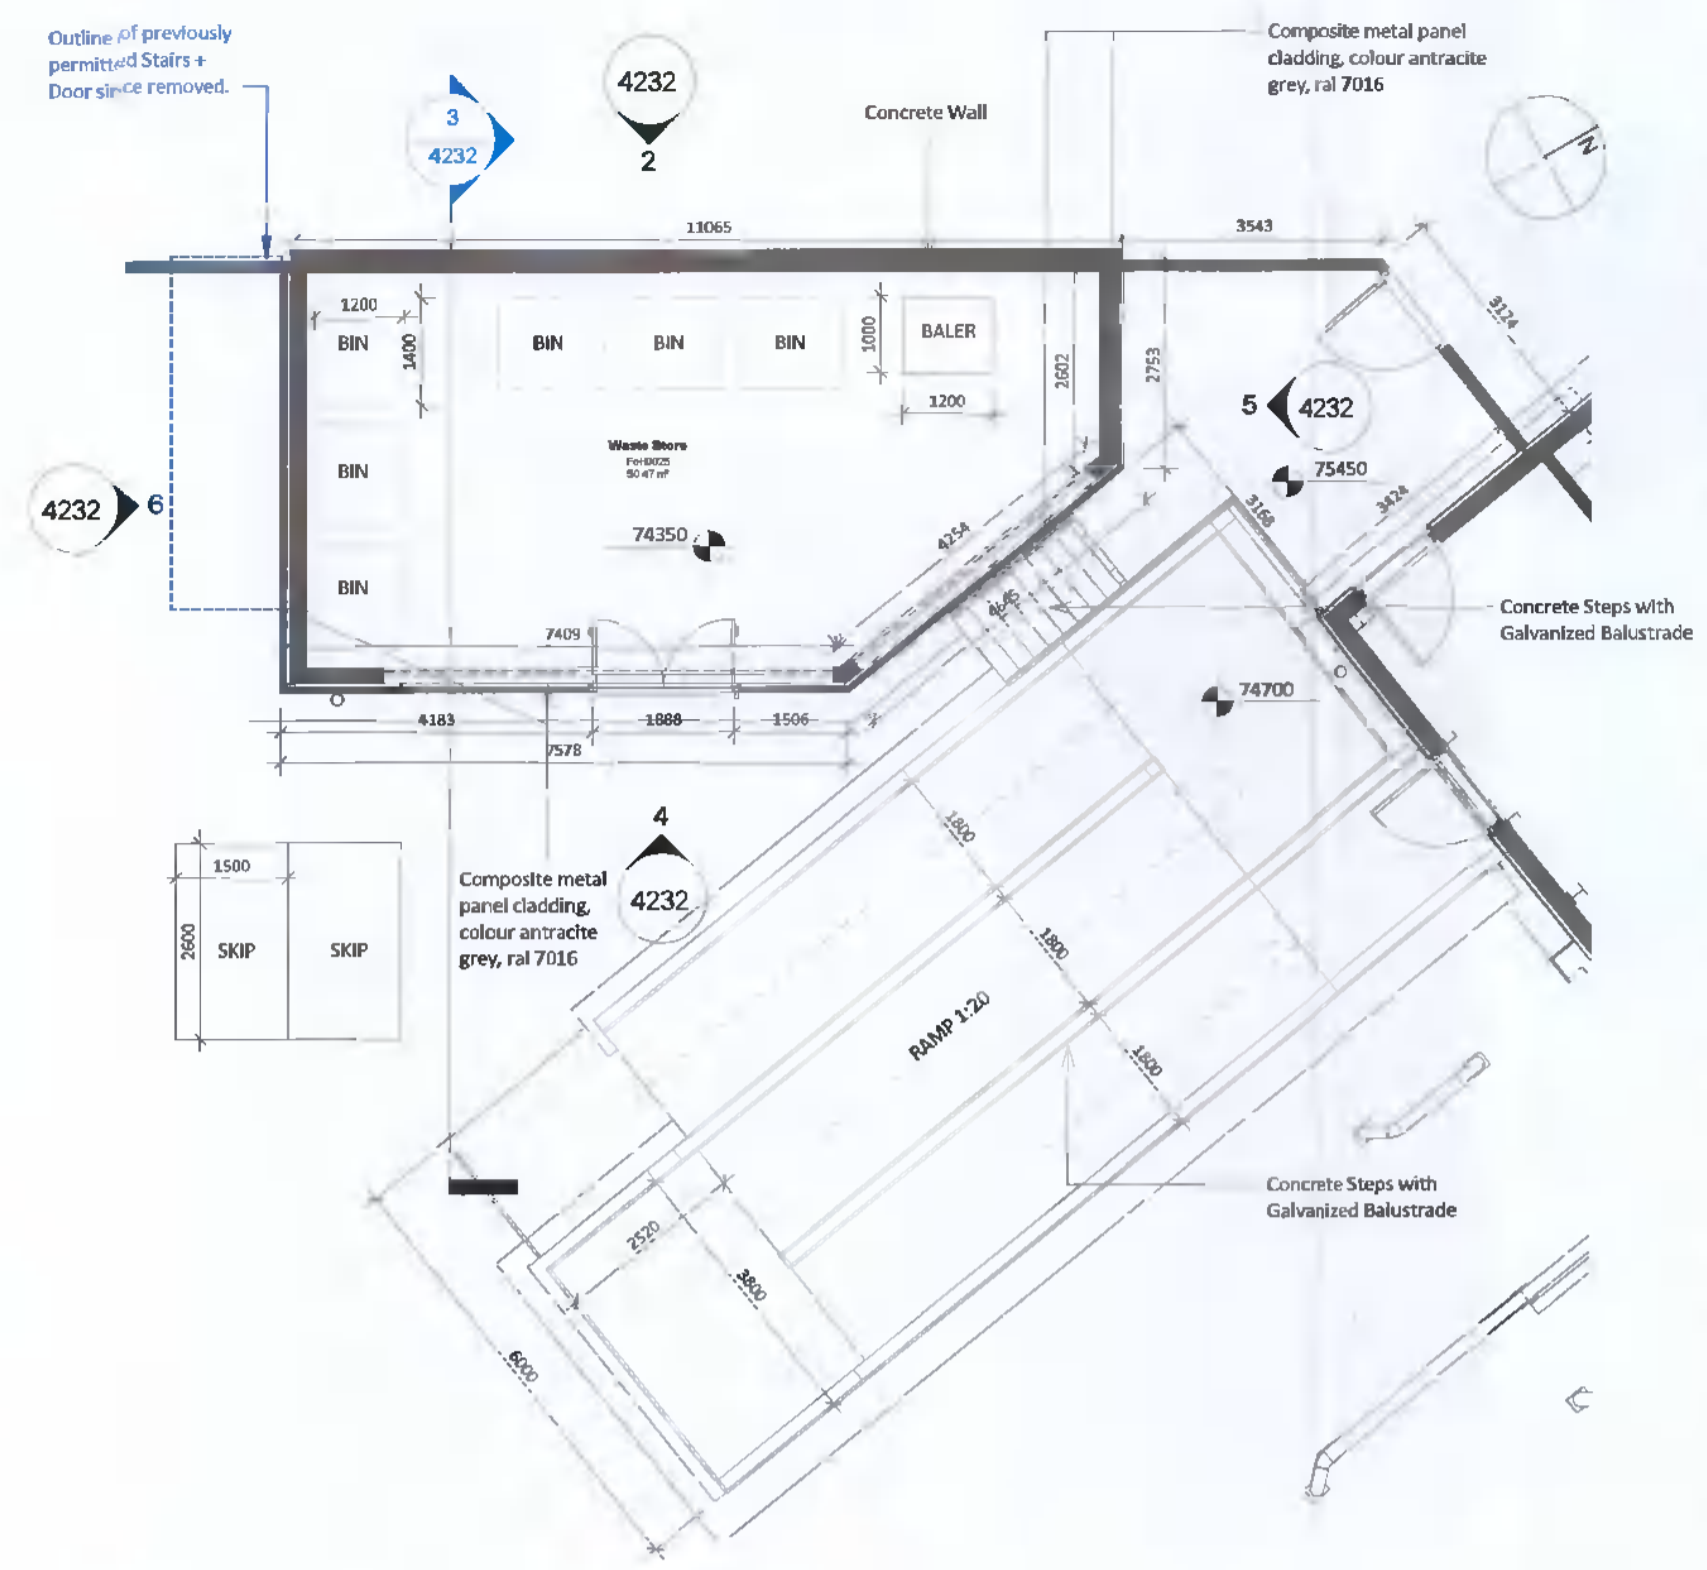


1 Waste Compound Plan
1 : 100

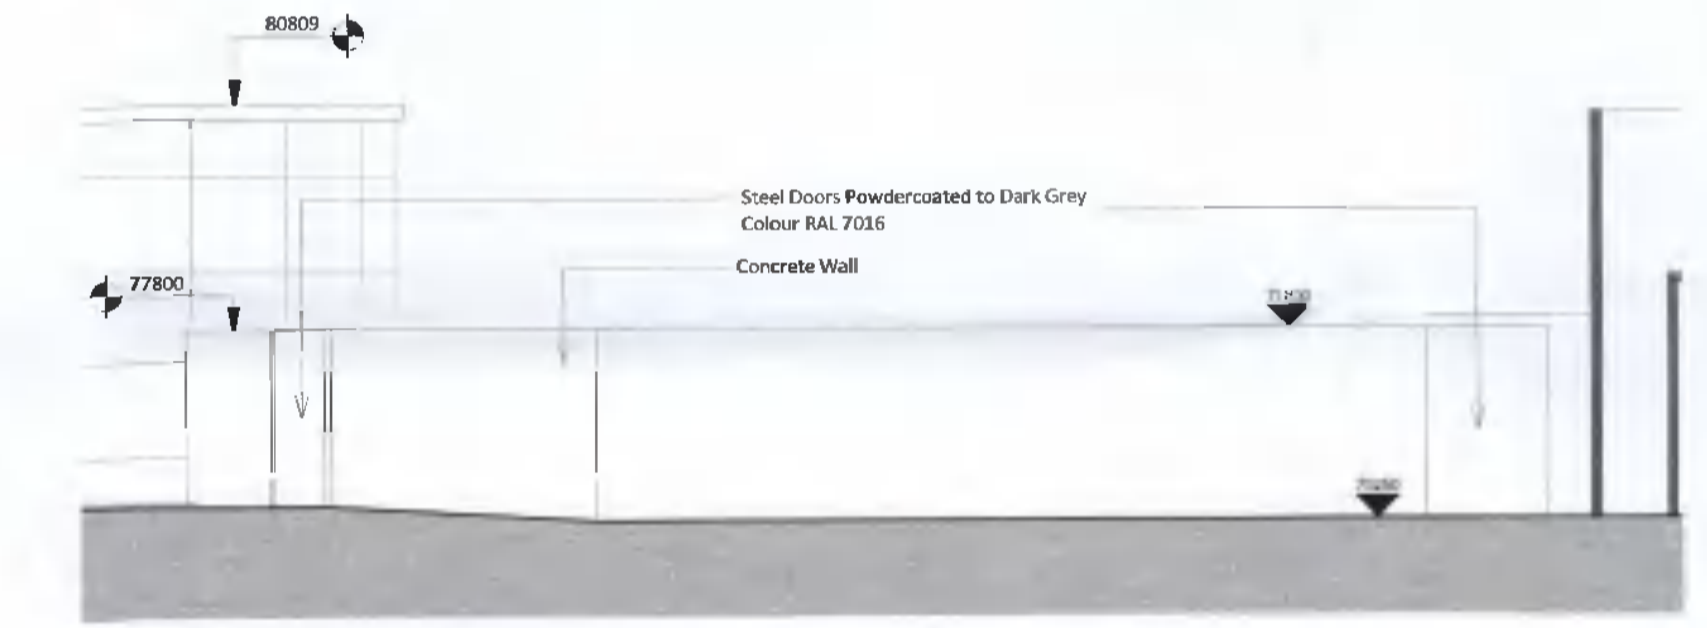


2 Waste Compound - North Elevation
1 : 100

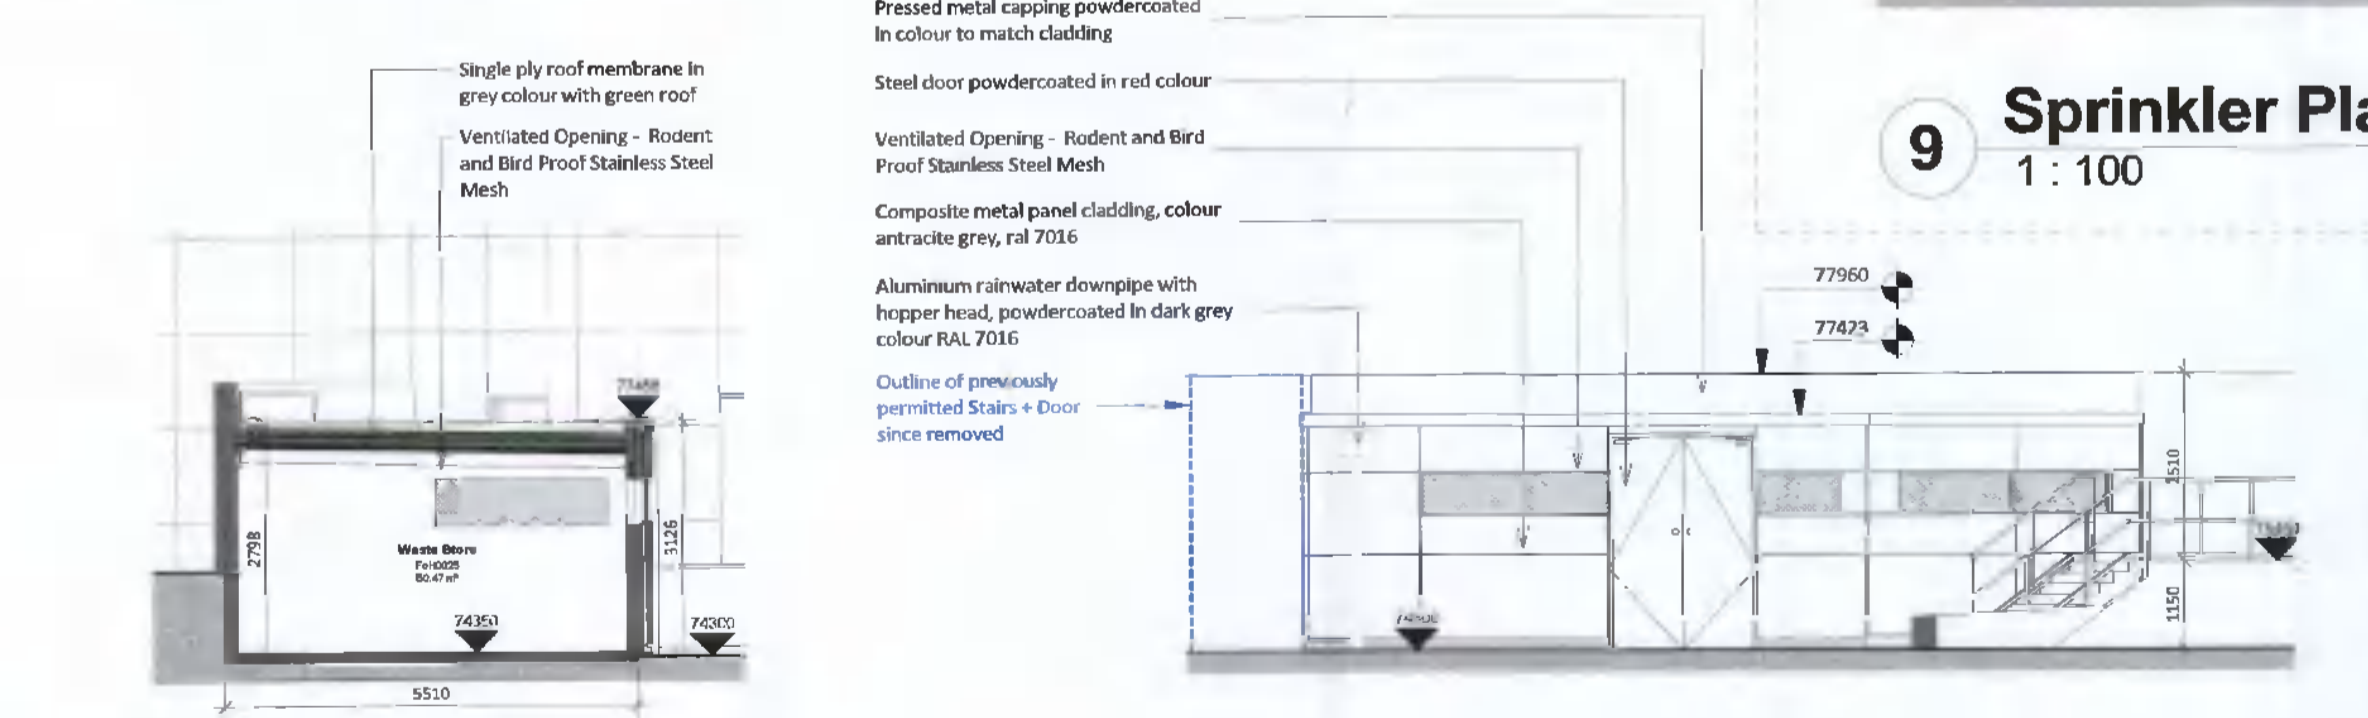


3 Waste Compound Section
1 : 100

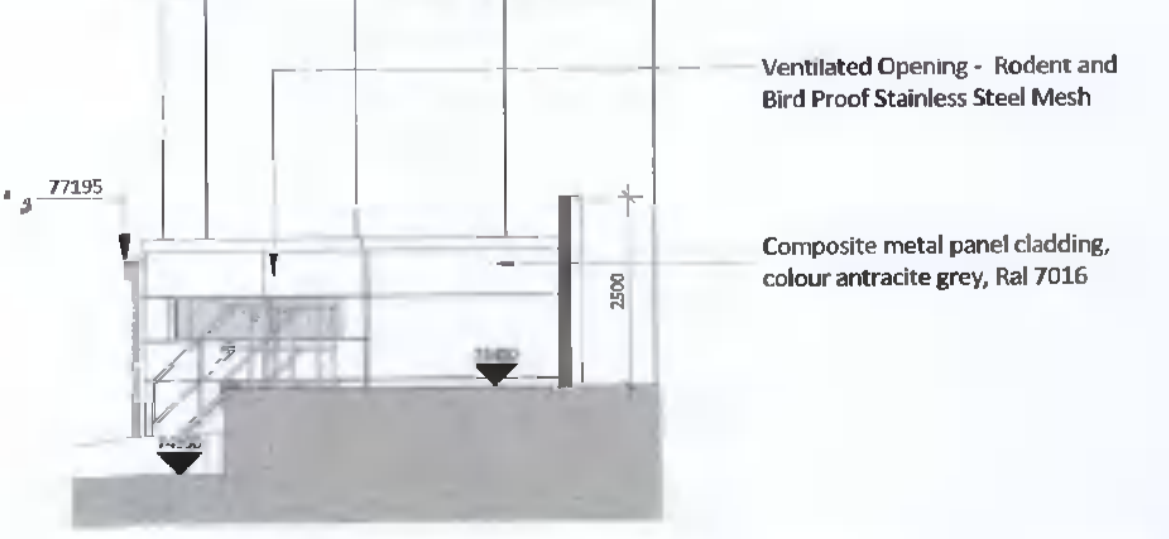


5 Waste Compound - East Elevation
1 : 100

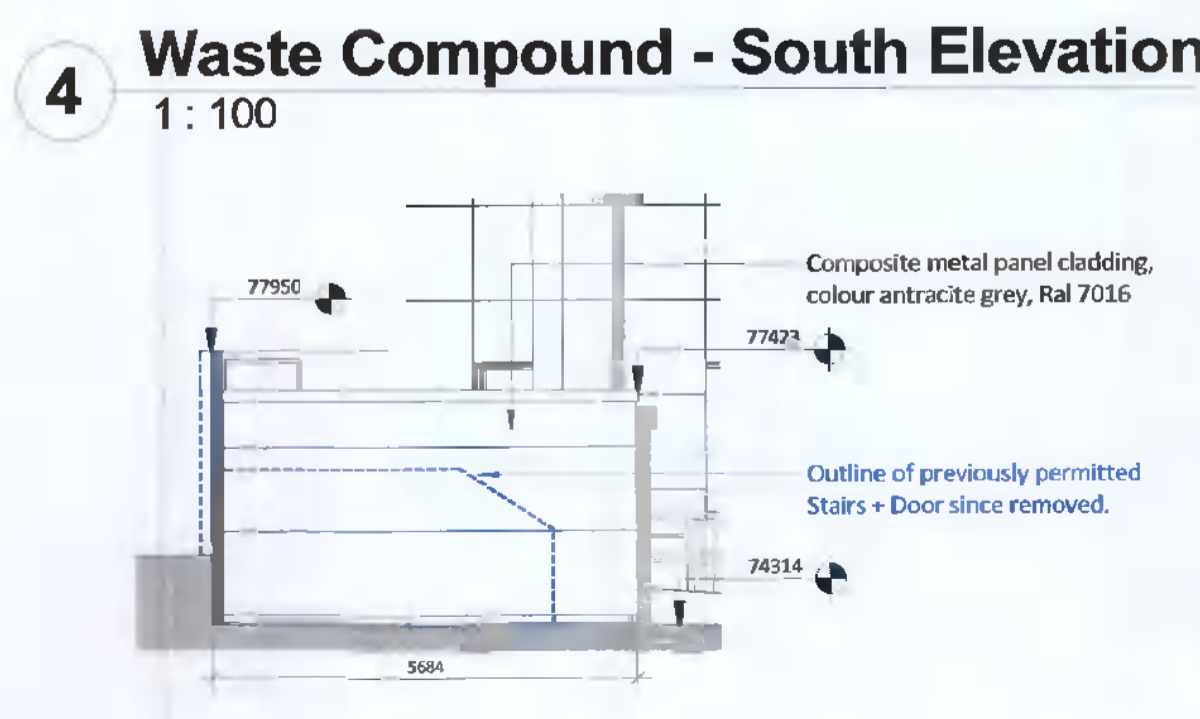


6 Waste Compound - South Elevation
1 : 100

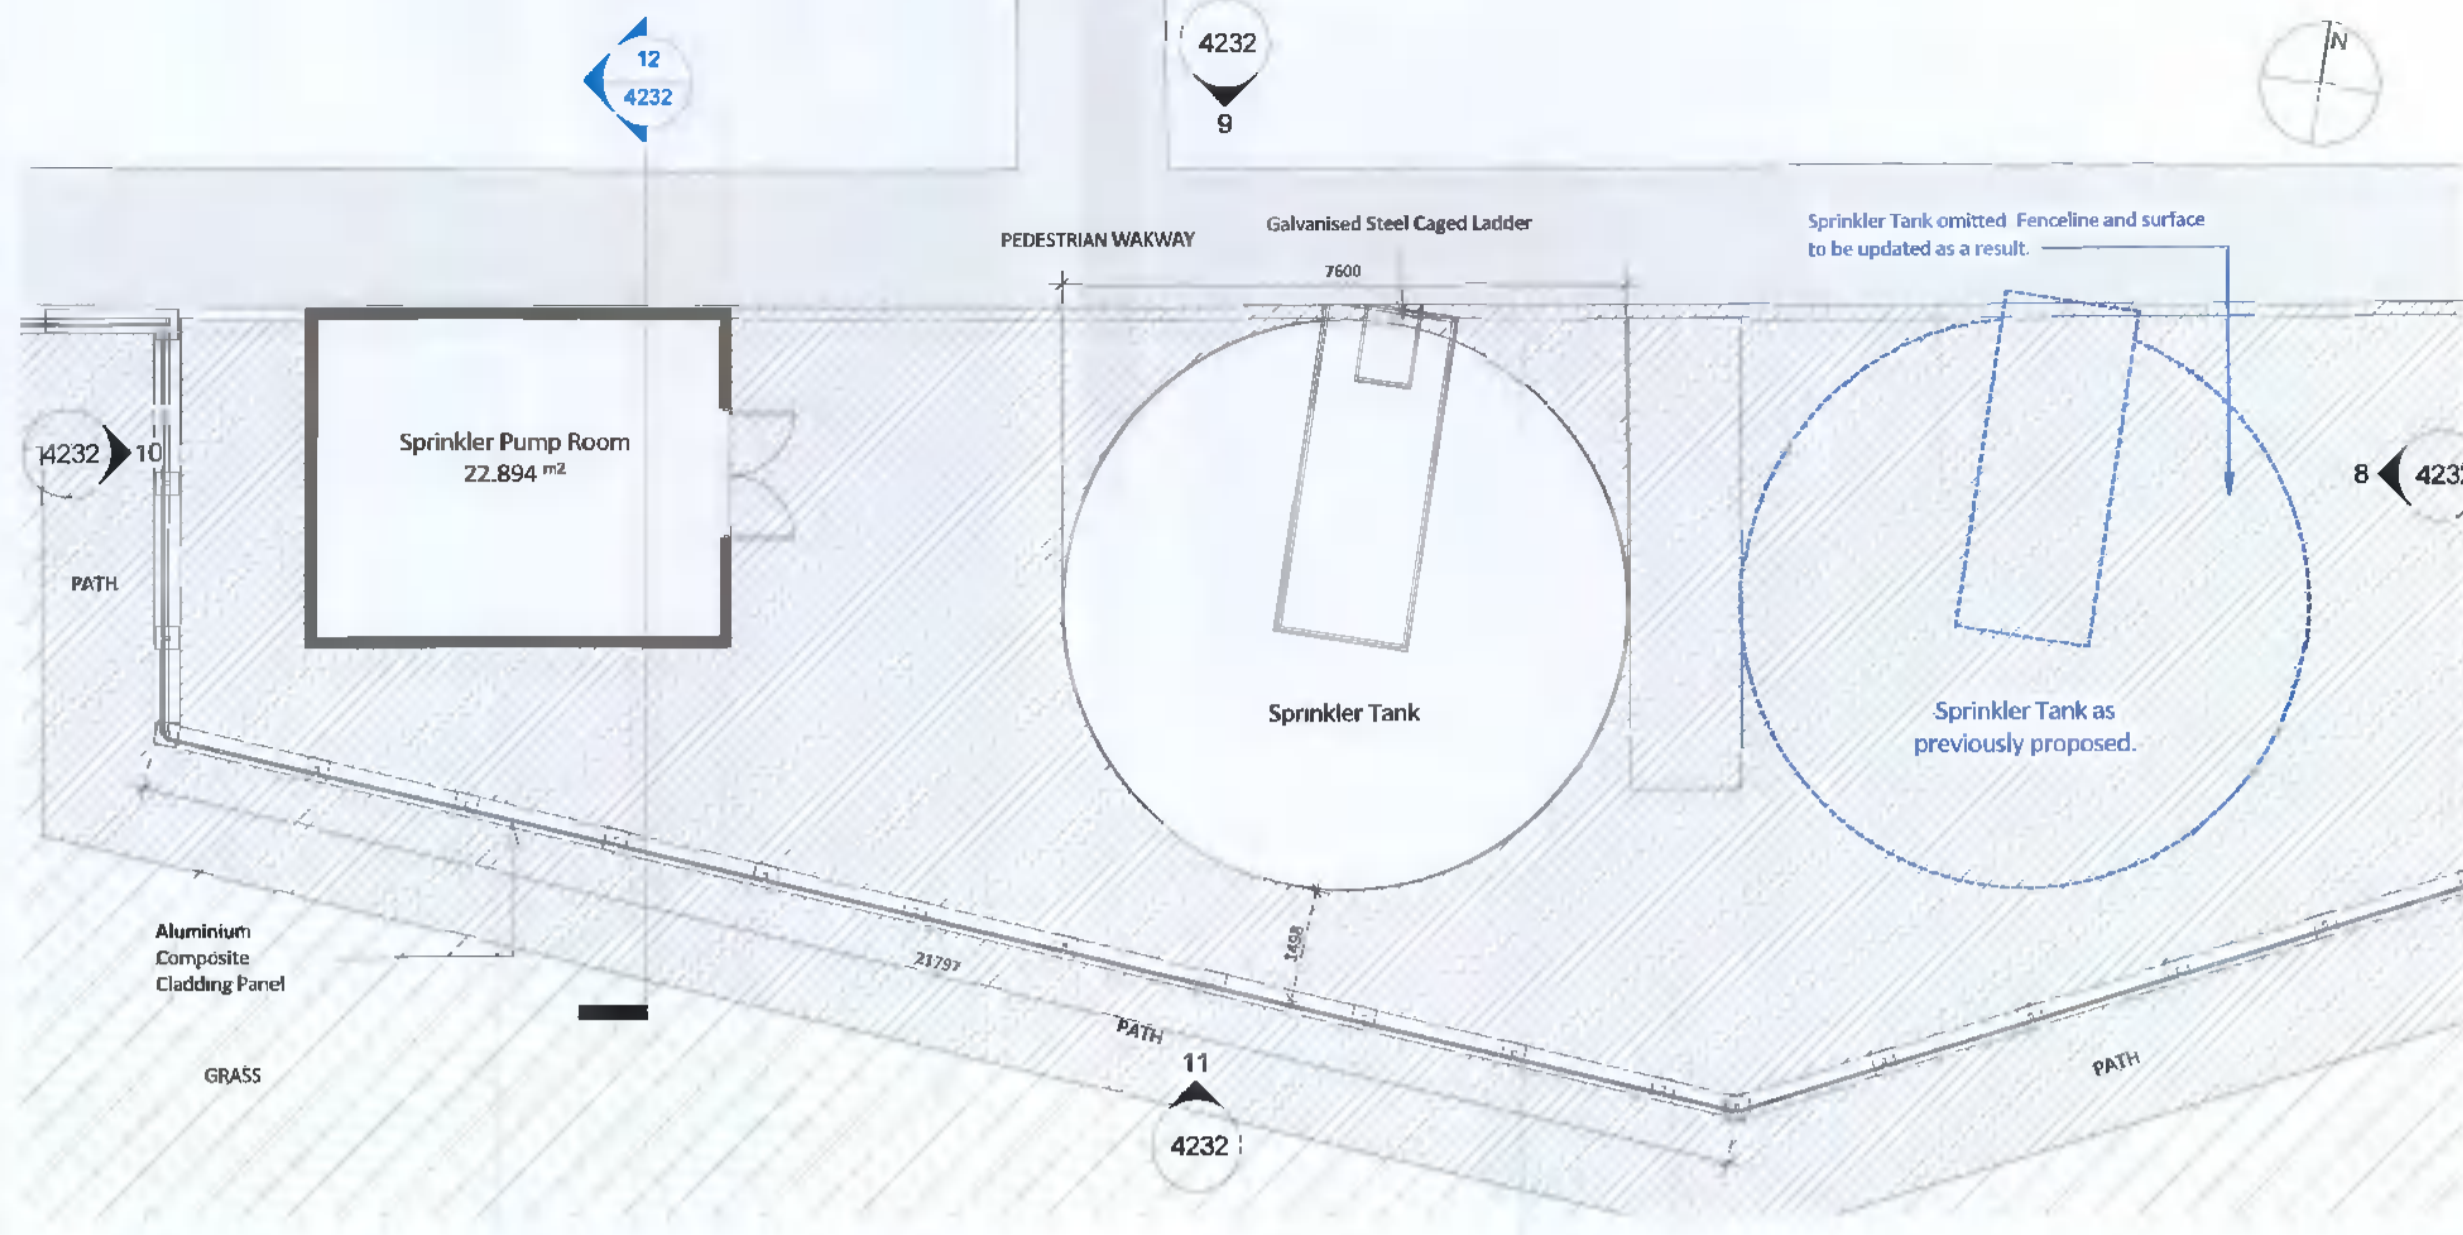


7 Sprinkler Pump Room Plan
1 : 100

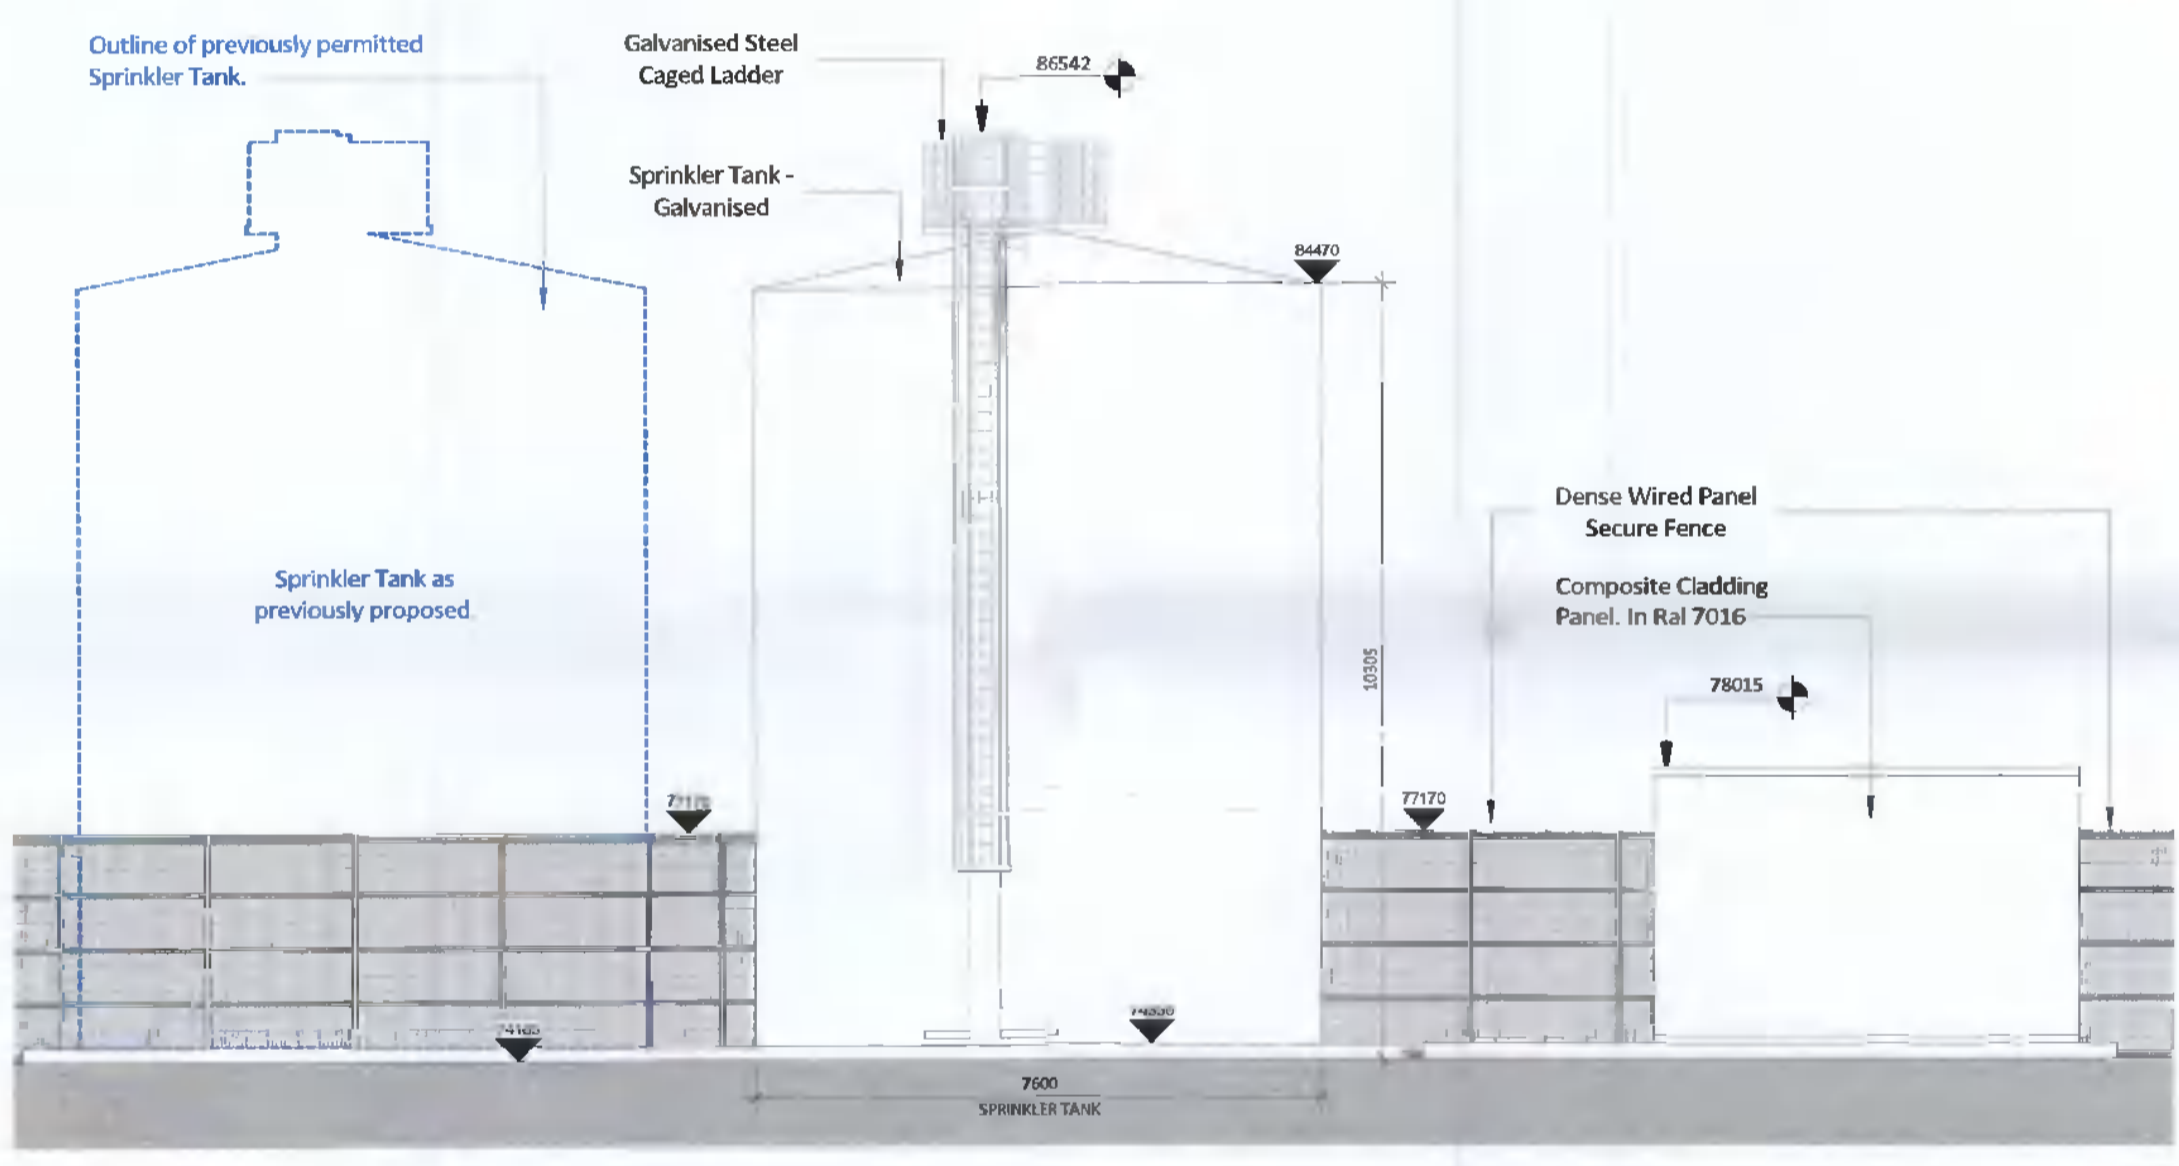


9 Sprinkler Plant - North Elevation
1 : 100

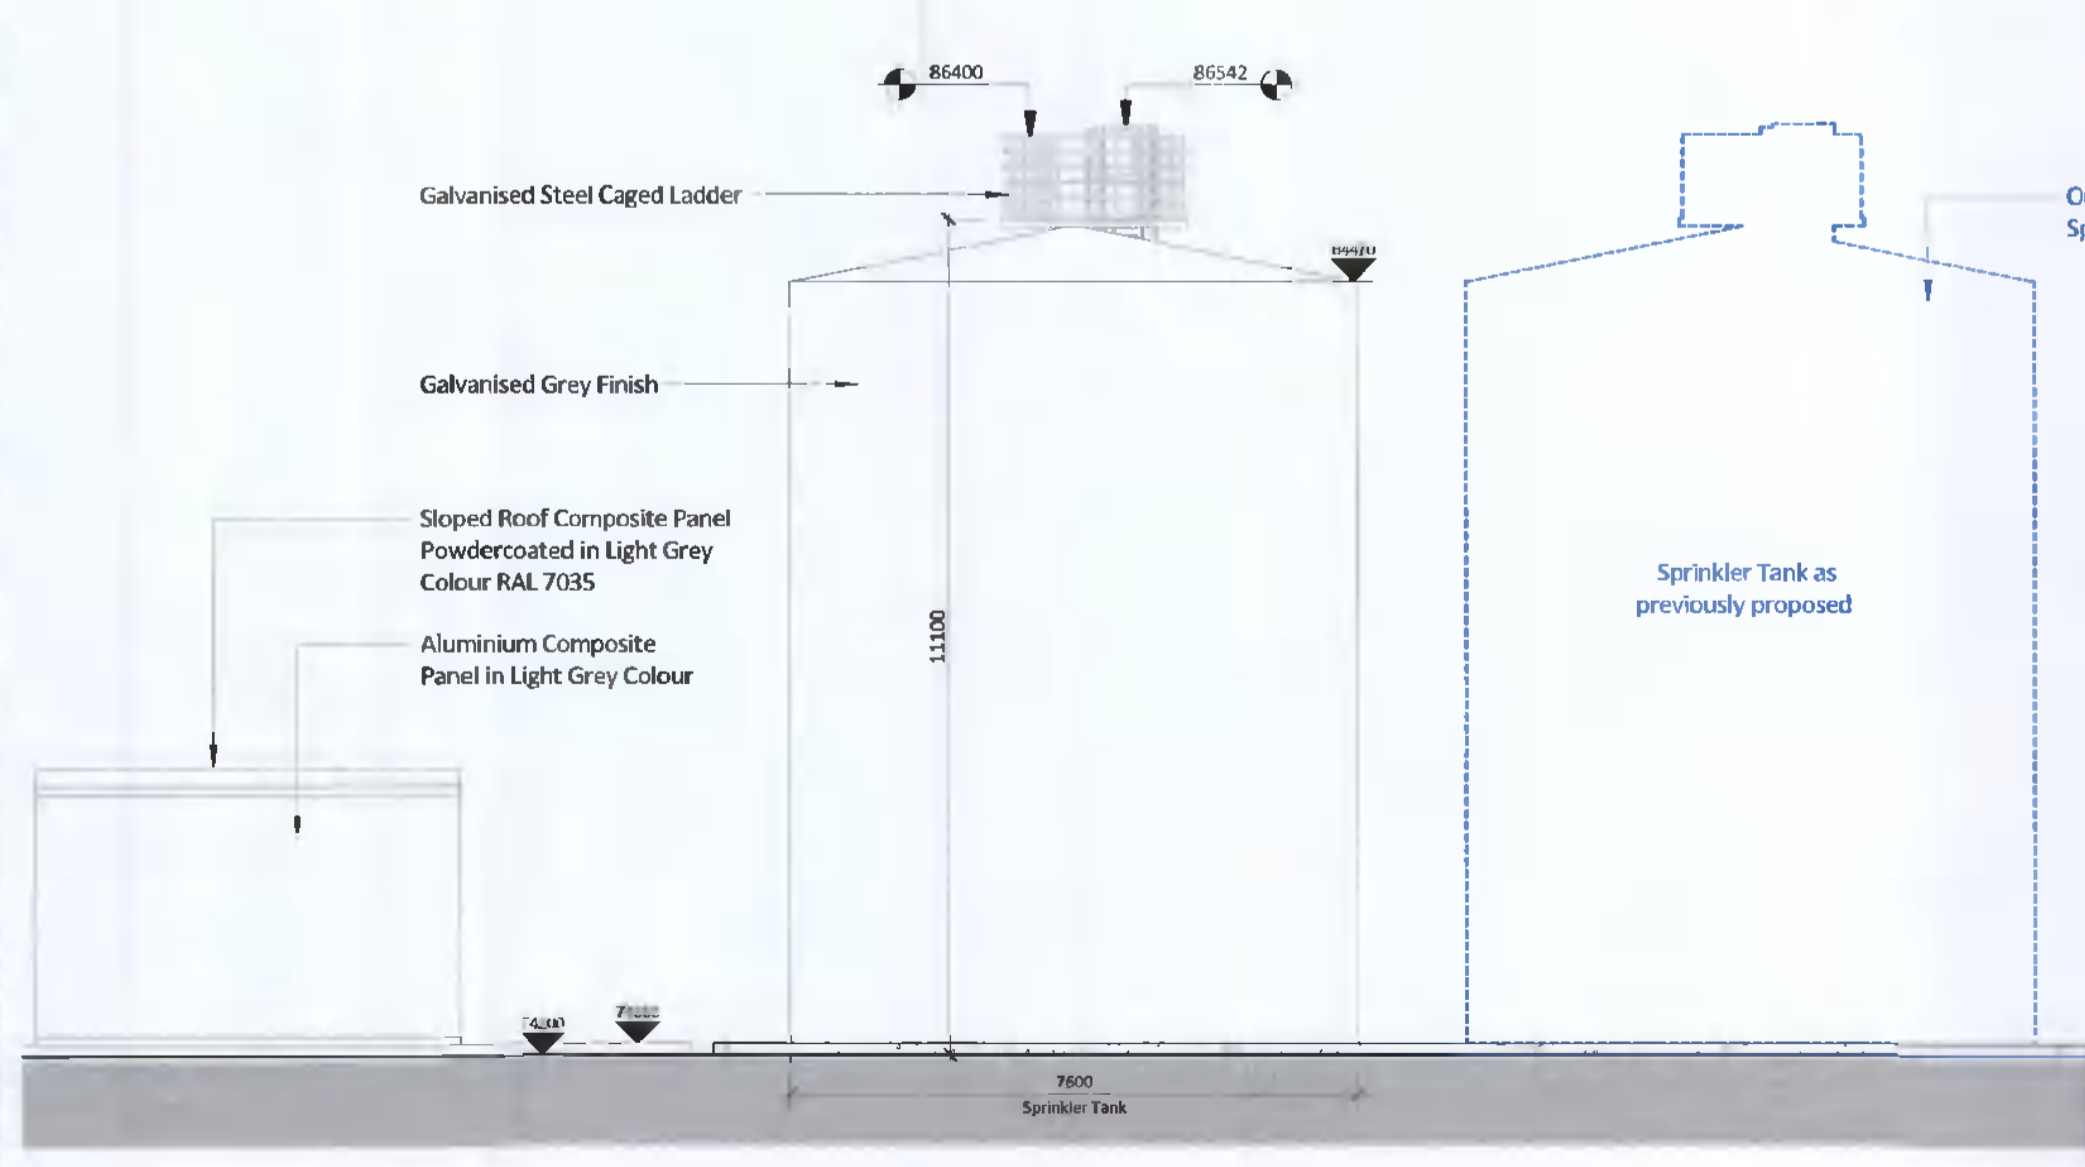


11 Sprinkler Plant - South Elevation
1 : 100

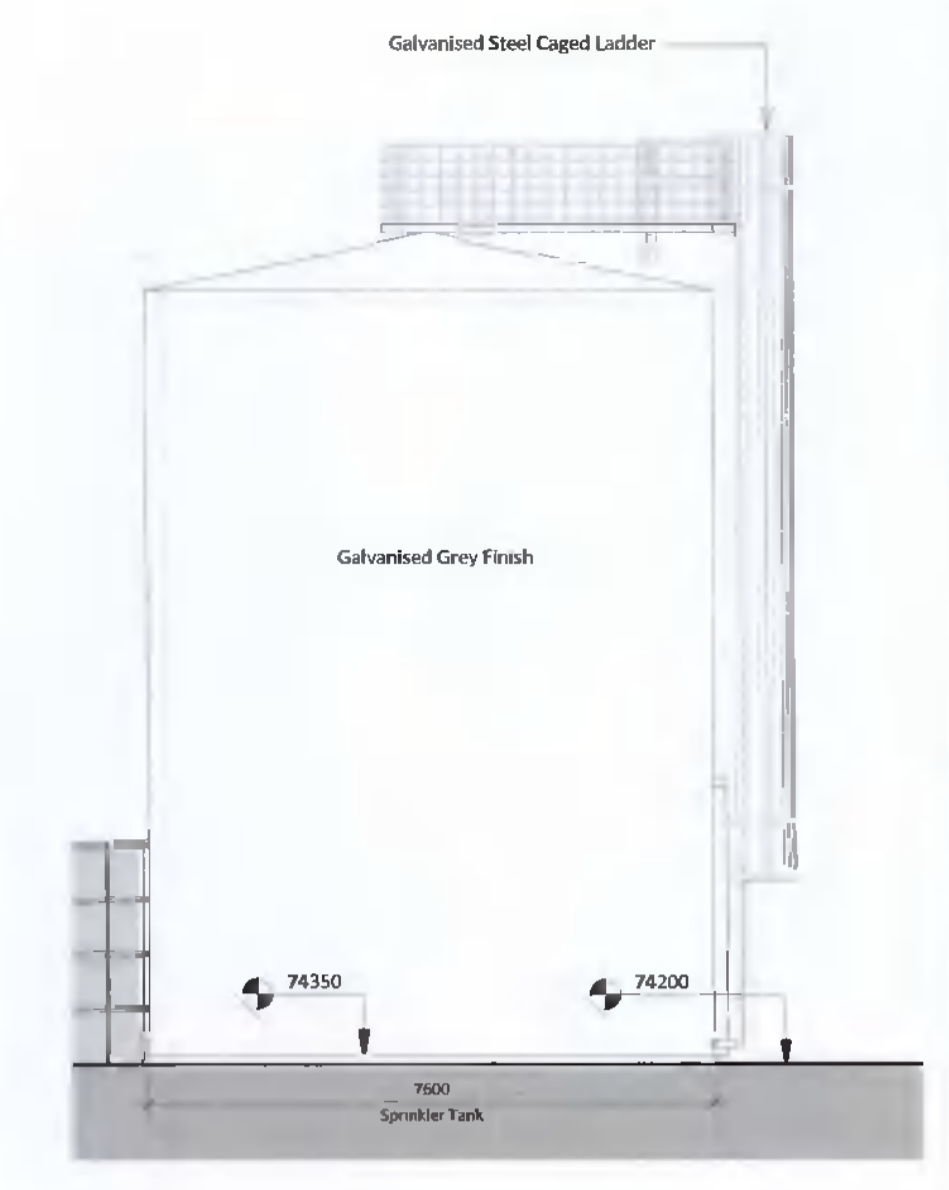

8 Sprinkler Plant - East Elevation
1 : 100

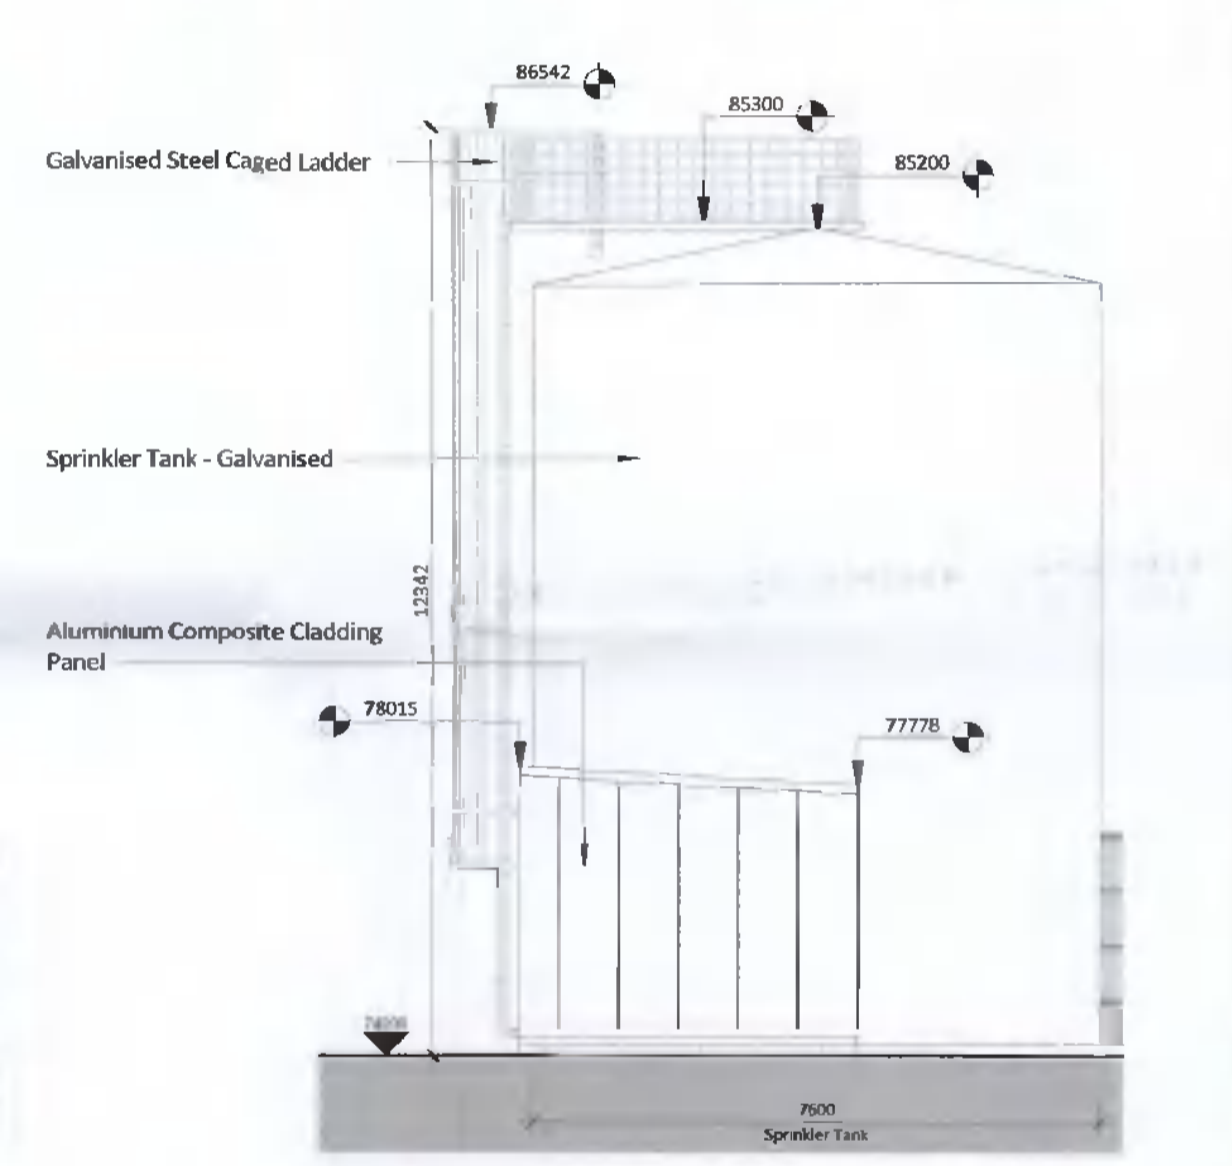

10 Sprinkler Plant - West Elevation
1 : 100

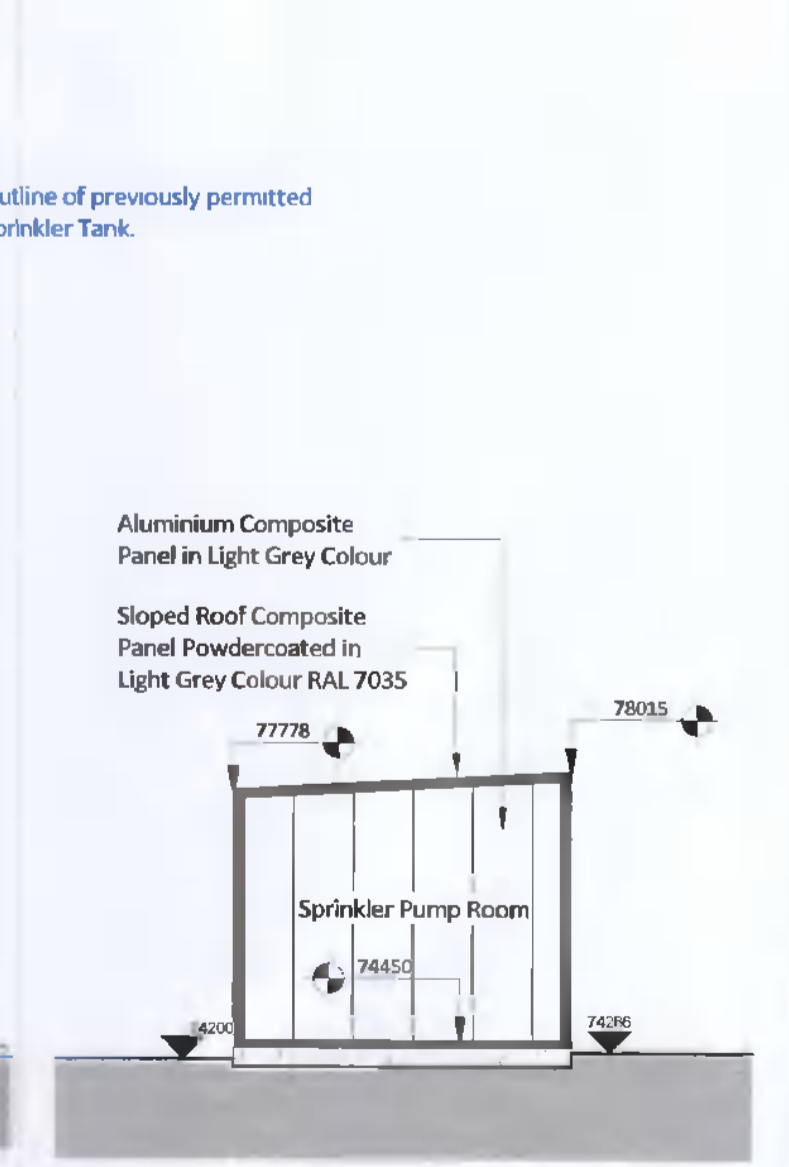

12 Sprinkler Plant - Section
1 : 100

REV	DATE	DESCRIPTION	DWN	CHK	APP
P02	2022-05-25	Revised Issue for Planning	KOH	MB	JS
P01	2021-06-16	Issued for Planning	NC	MB	JS

Key:

Project:
 Equinix DB081
 Drawing Title:
 Proposed Ancillary Buildings - Waste Compound, Sprinkler Water Compound - Pump Room

Drawing Number:
 DB080 -RKD -ZZ -XX -DR -A -ZZZZ -4232
 Scale: 1:100 Paper Size: A1 Purpose: S4 Revision: P02



59 Northumberland Rd Ballsbridge, Dublin 4 D04 WP89, Ireland
 +353 1 668 1055
 mail@rkd.ie
 rkd.ie