


NOTE  
 ALL DIMENSIONS TO BE CHECKED FROM SITE  
 NO DIMENSIONS TO BE SCALED FROM THIS DRAWING  
 THIS DRAWING IS TO BE READ IN CONJUNCTION WITH  
 RELEVANT CONSULTANTS DRAWINGS



**LEGEND:**

- Planning application site boundary
- Location of site notice
- Extent of Planning Application

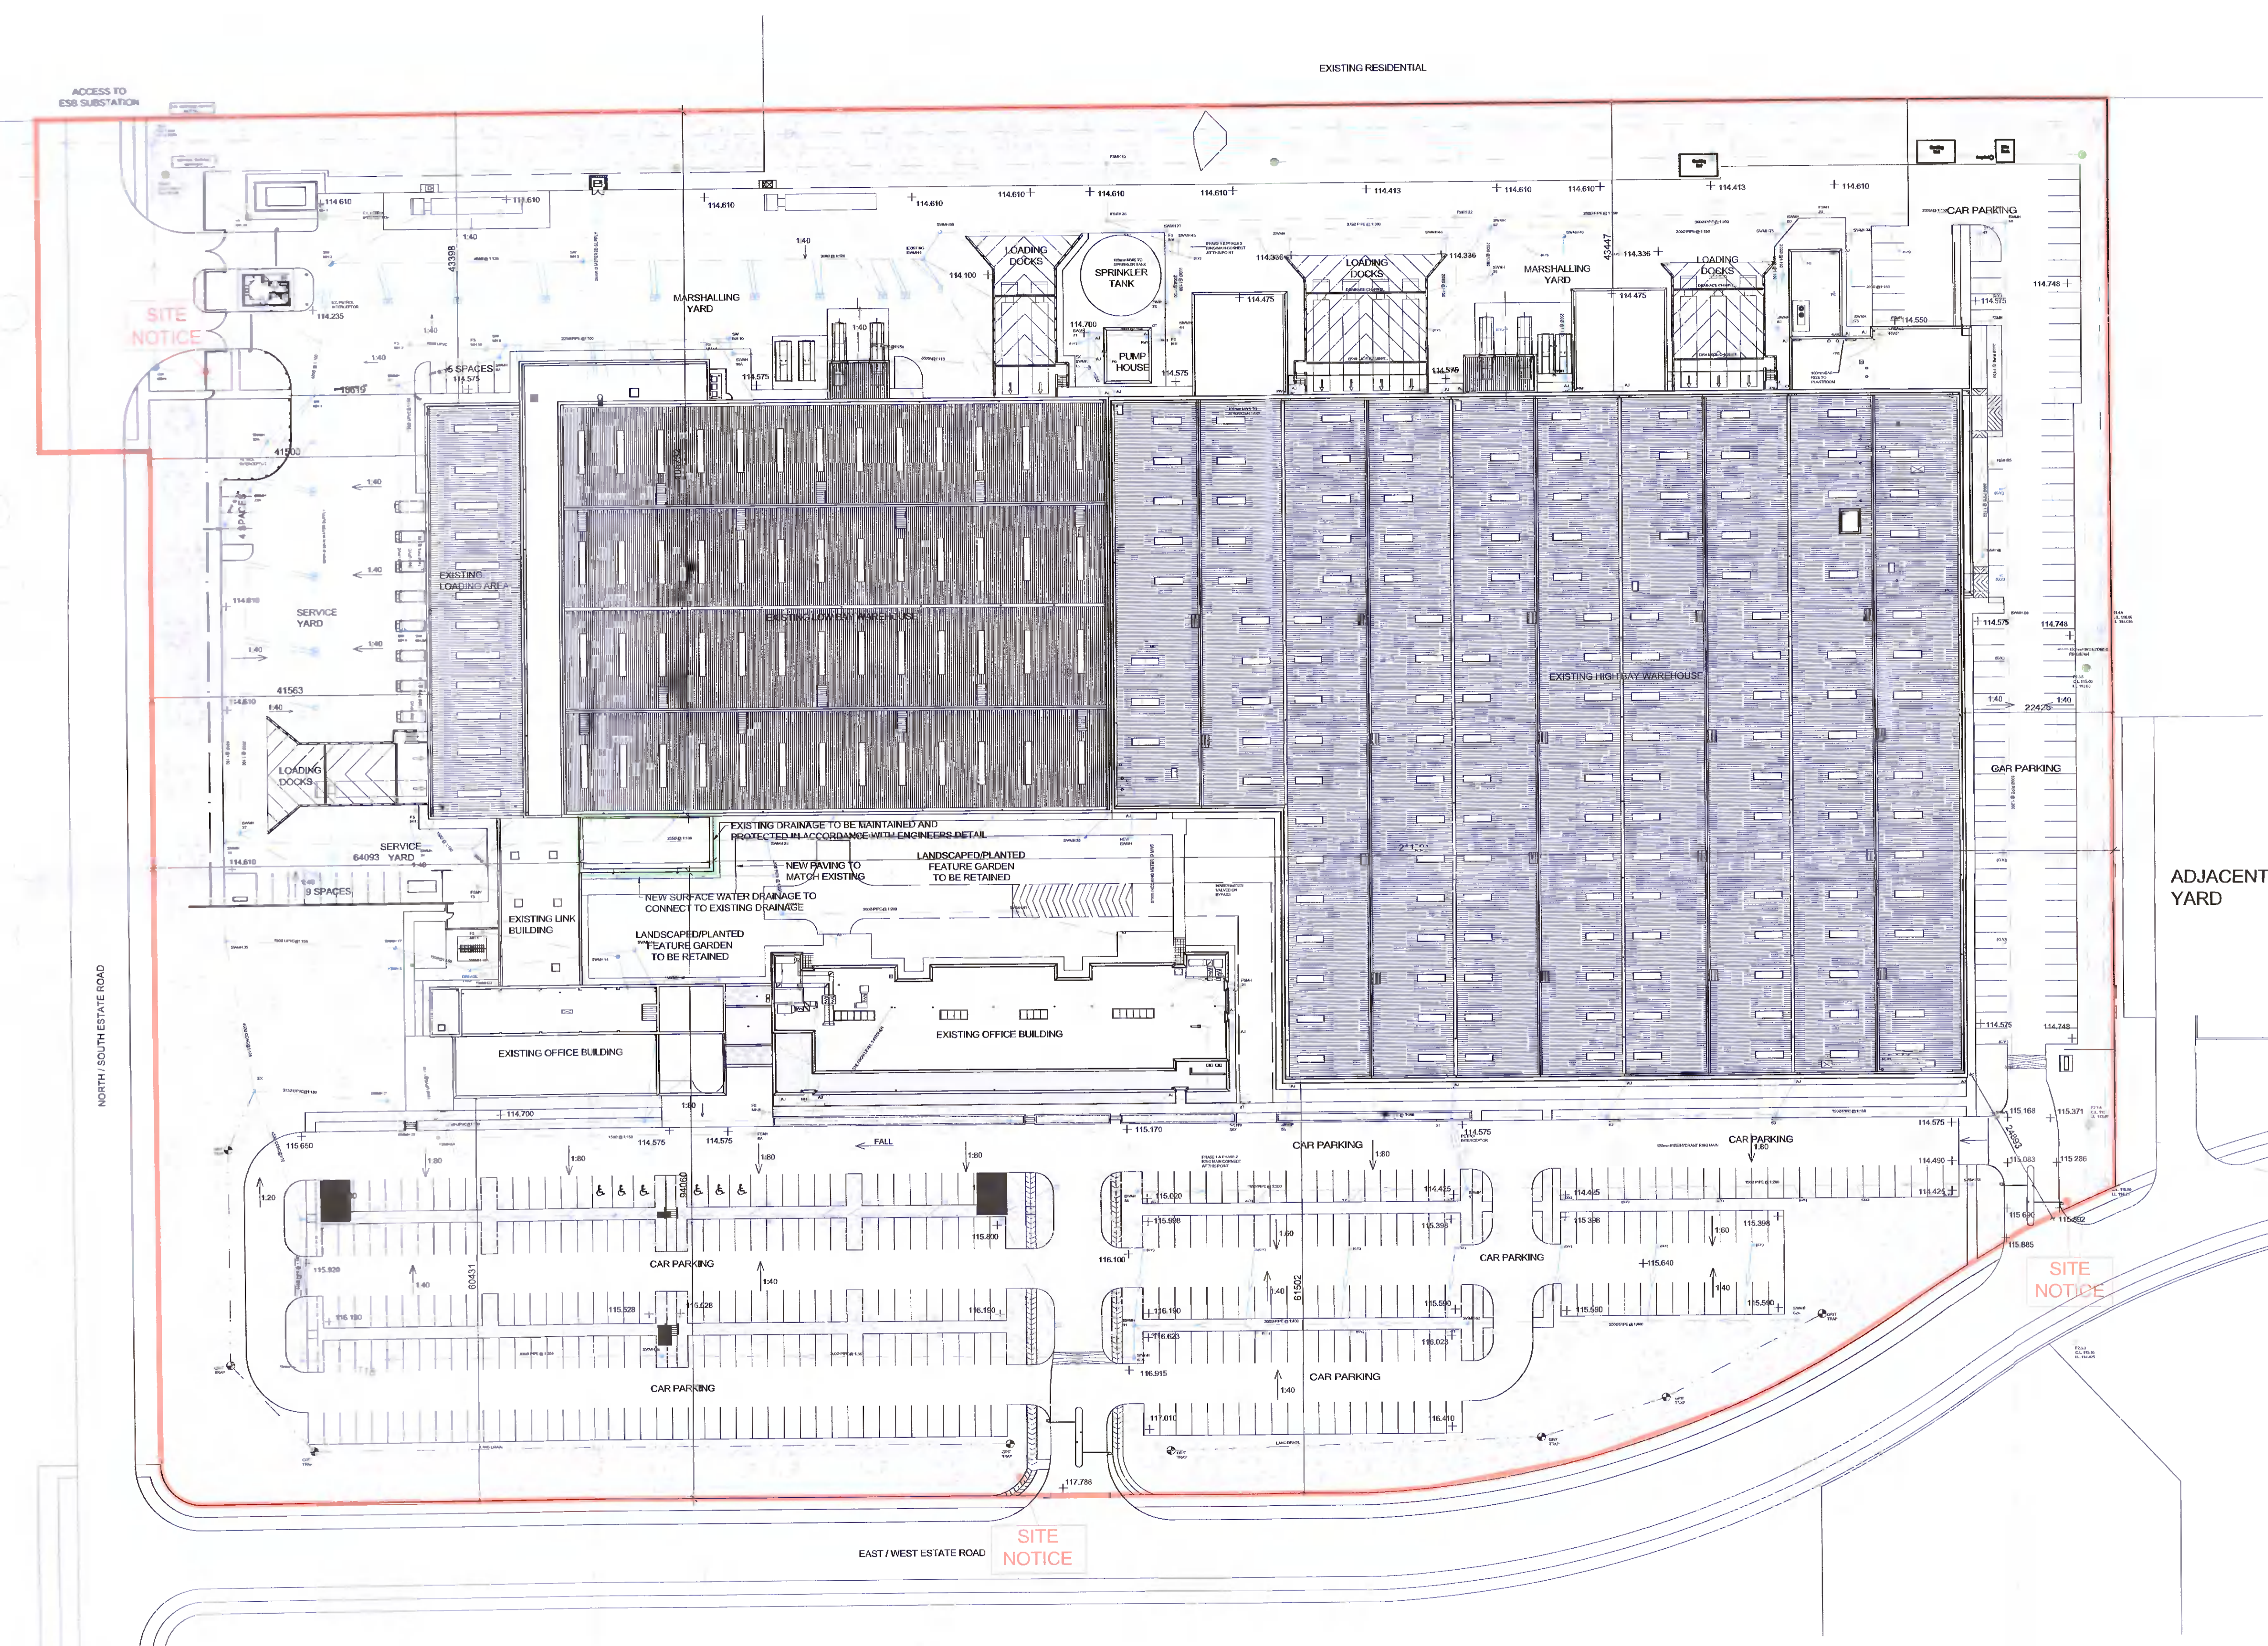

ADJACENT YARD

REV	DATE	DESCRIPTION	CHKD	DRN
P01	23.05.2022	Issued for planning	MD	ED

**PLANNING**

**Henry J Lyons**

Architecture • Interiors 4353 1 888 3333 51-54 Pearse Street  
 henryjlyons.com h@henryjlyons.com Dublin D02 XA66

CLIENT  
**UNITED DRUG (WHOLESALE) LTD.**

PROJECT  
**WAREHOUSE EXTENSION AT  
 UNITED DRUG, MAGNA PARK**

JOB NUMBER:	950026
DATE:	09.05.2022
SCALE:	1:500 @A1
DRAWN:	ED
CHECKED:	MD
FILE NAME:	950026 P0003 Proposed Site Plan

DRAWING  
**PROPOSED SITE LAYOUT PLAN  
 DRAINAGE LAYOUT**

STATUS	DRAWING NUMBER	REVISION
	P0003	P01

COPYRIGHT

**PROPOSED SITE PLAN**  
 SCALE 1:500