



Existing Rear Elevation

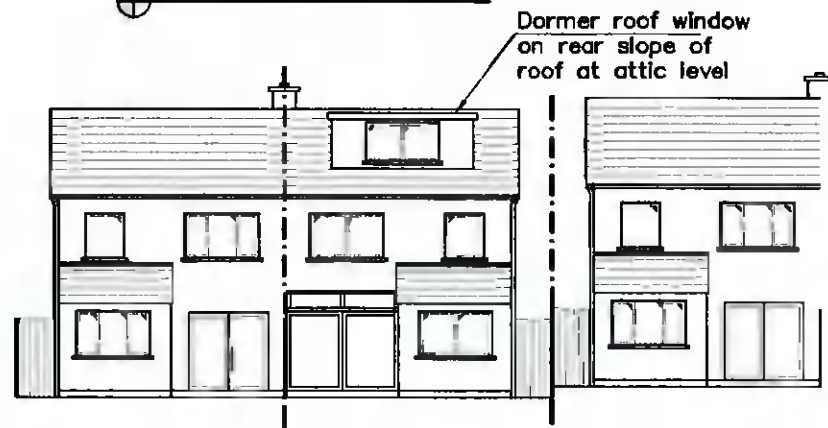


Proposed Rear Elevation

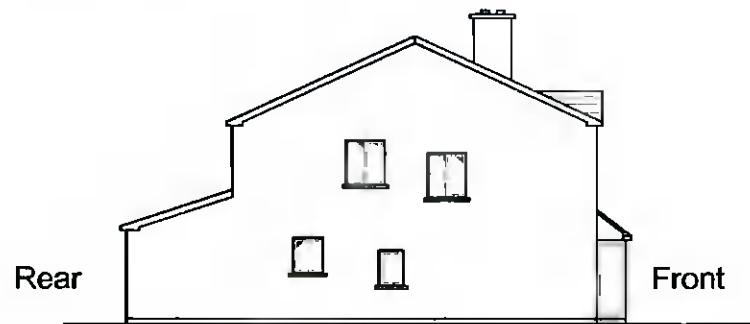


Existing Gable Elevation

DRAINAGE LEGEND


	EXISTING SURFACE WATER PIPE
	EXISTING FOUL SEWER PIPE

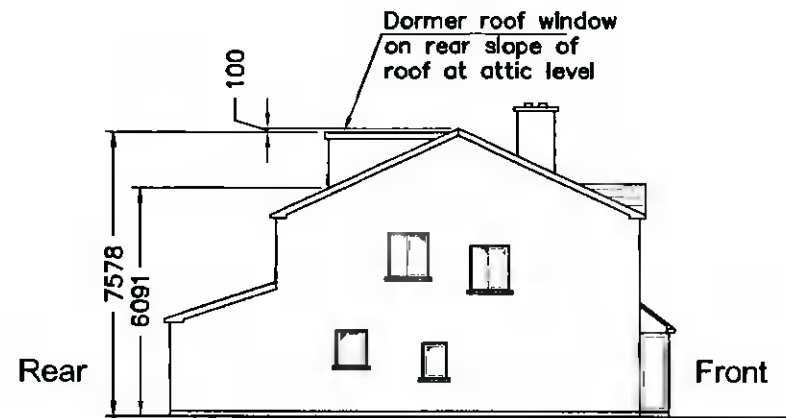

Proposed Gable Elevation

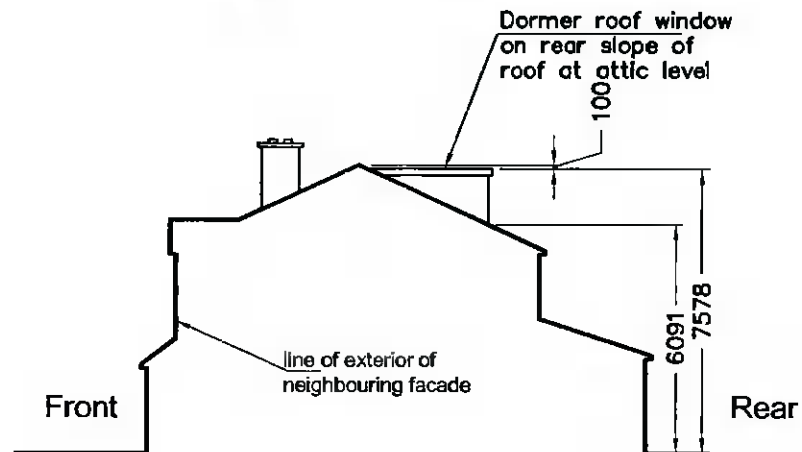

Proposed Dormer Side Elevation

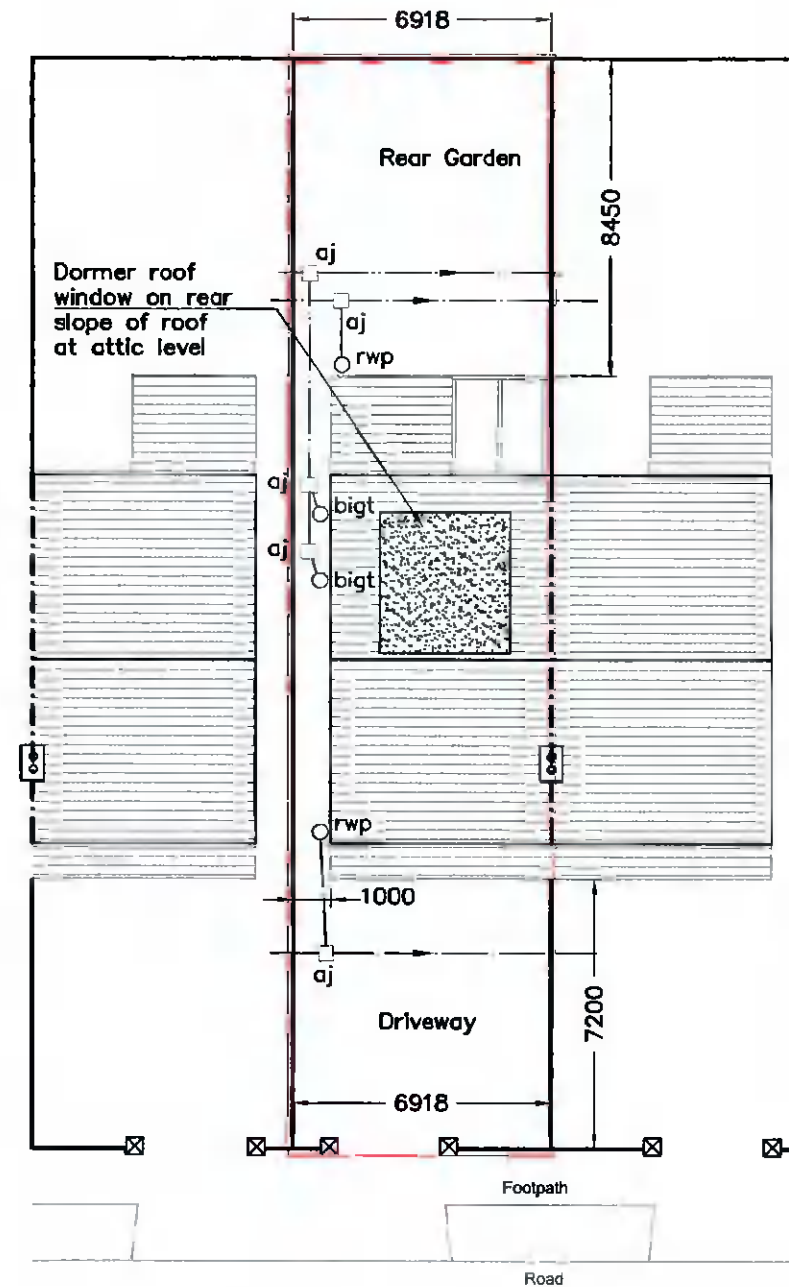

Proposed Block Plan & Drainage Layout
SCALE 1:200

P	ISSUED FOR PLANNING	TW	JUNE 2022
REV:	REVISION TITLE:	DRN:	CHD: DATE:

Architectural Planning

4 CARRIGMORE CLOSE, AYLESBURY,
Dublin 24 - Ph: 01 4148358

CLIENT: **Denis Mesko**

JOB TITLE: **Proposed Works at 12 Corbally Park, Saggart, Dublin 24**

TITLE: **Elevations, Proposed Block Plan & Drainage Layout**

SCALE: 1:200	INITIALS: TW	DATE: May 2022
JOB No: S478	DRAWING No: 003	REV: P

THIS DRAWING IS ISSUED FOR PLANNING PERMISSION ONLY, AND IS NOT A CONSTRUCTION DRAWING

NOTES:
This drawing is to be read in conjunction with all relevant Engineers drawings.
Do not scale use figured dimensions ONLY.
All dimensions in millimeters unless otherwise stated.
All dimensions to be checked on site.
All building works to comply with current building regulations & in accordance with Homebond Standards.