


Soakaway shall be designed and constructed in accordance with BRE Digest 365

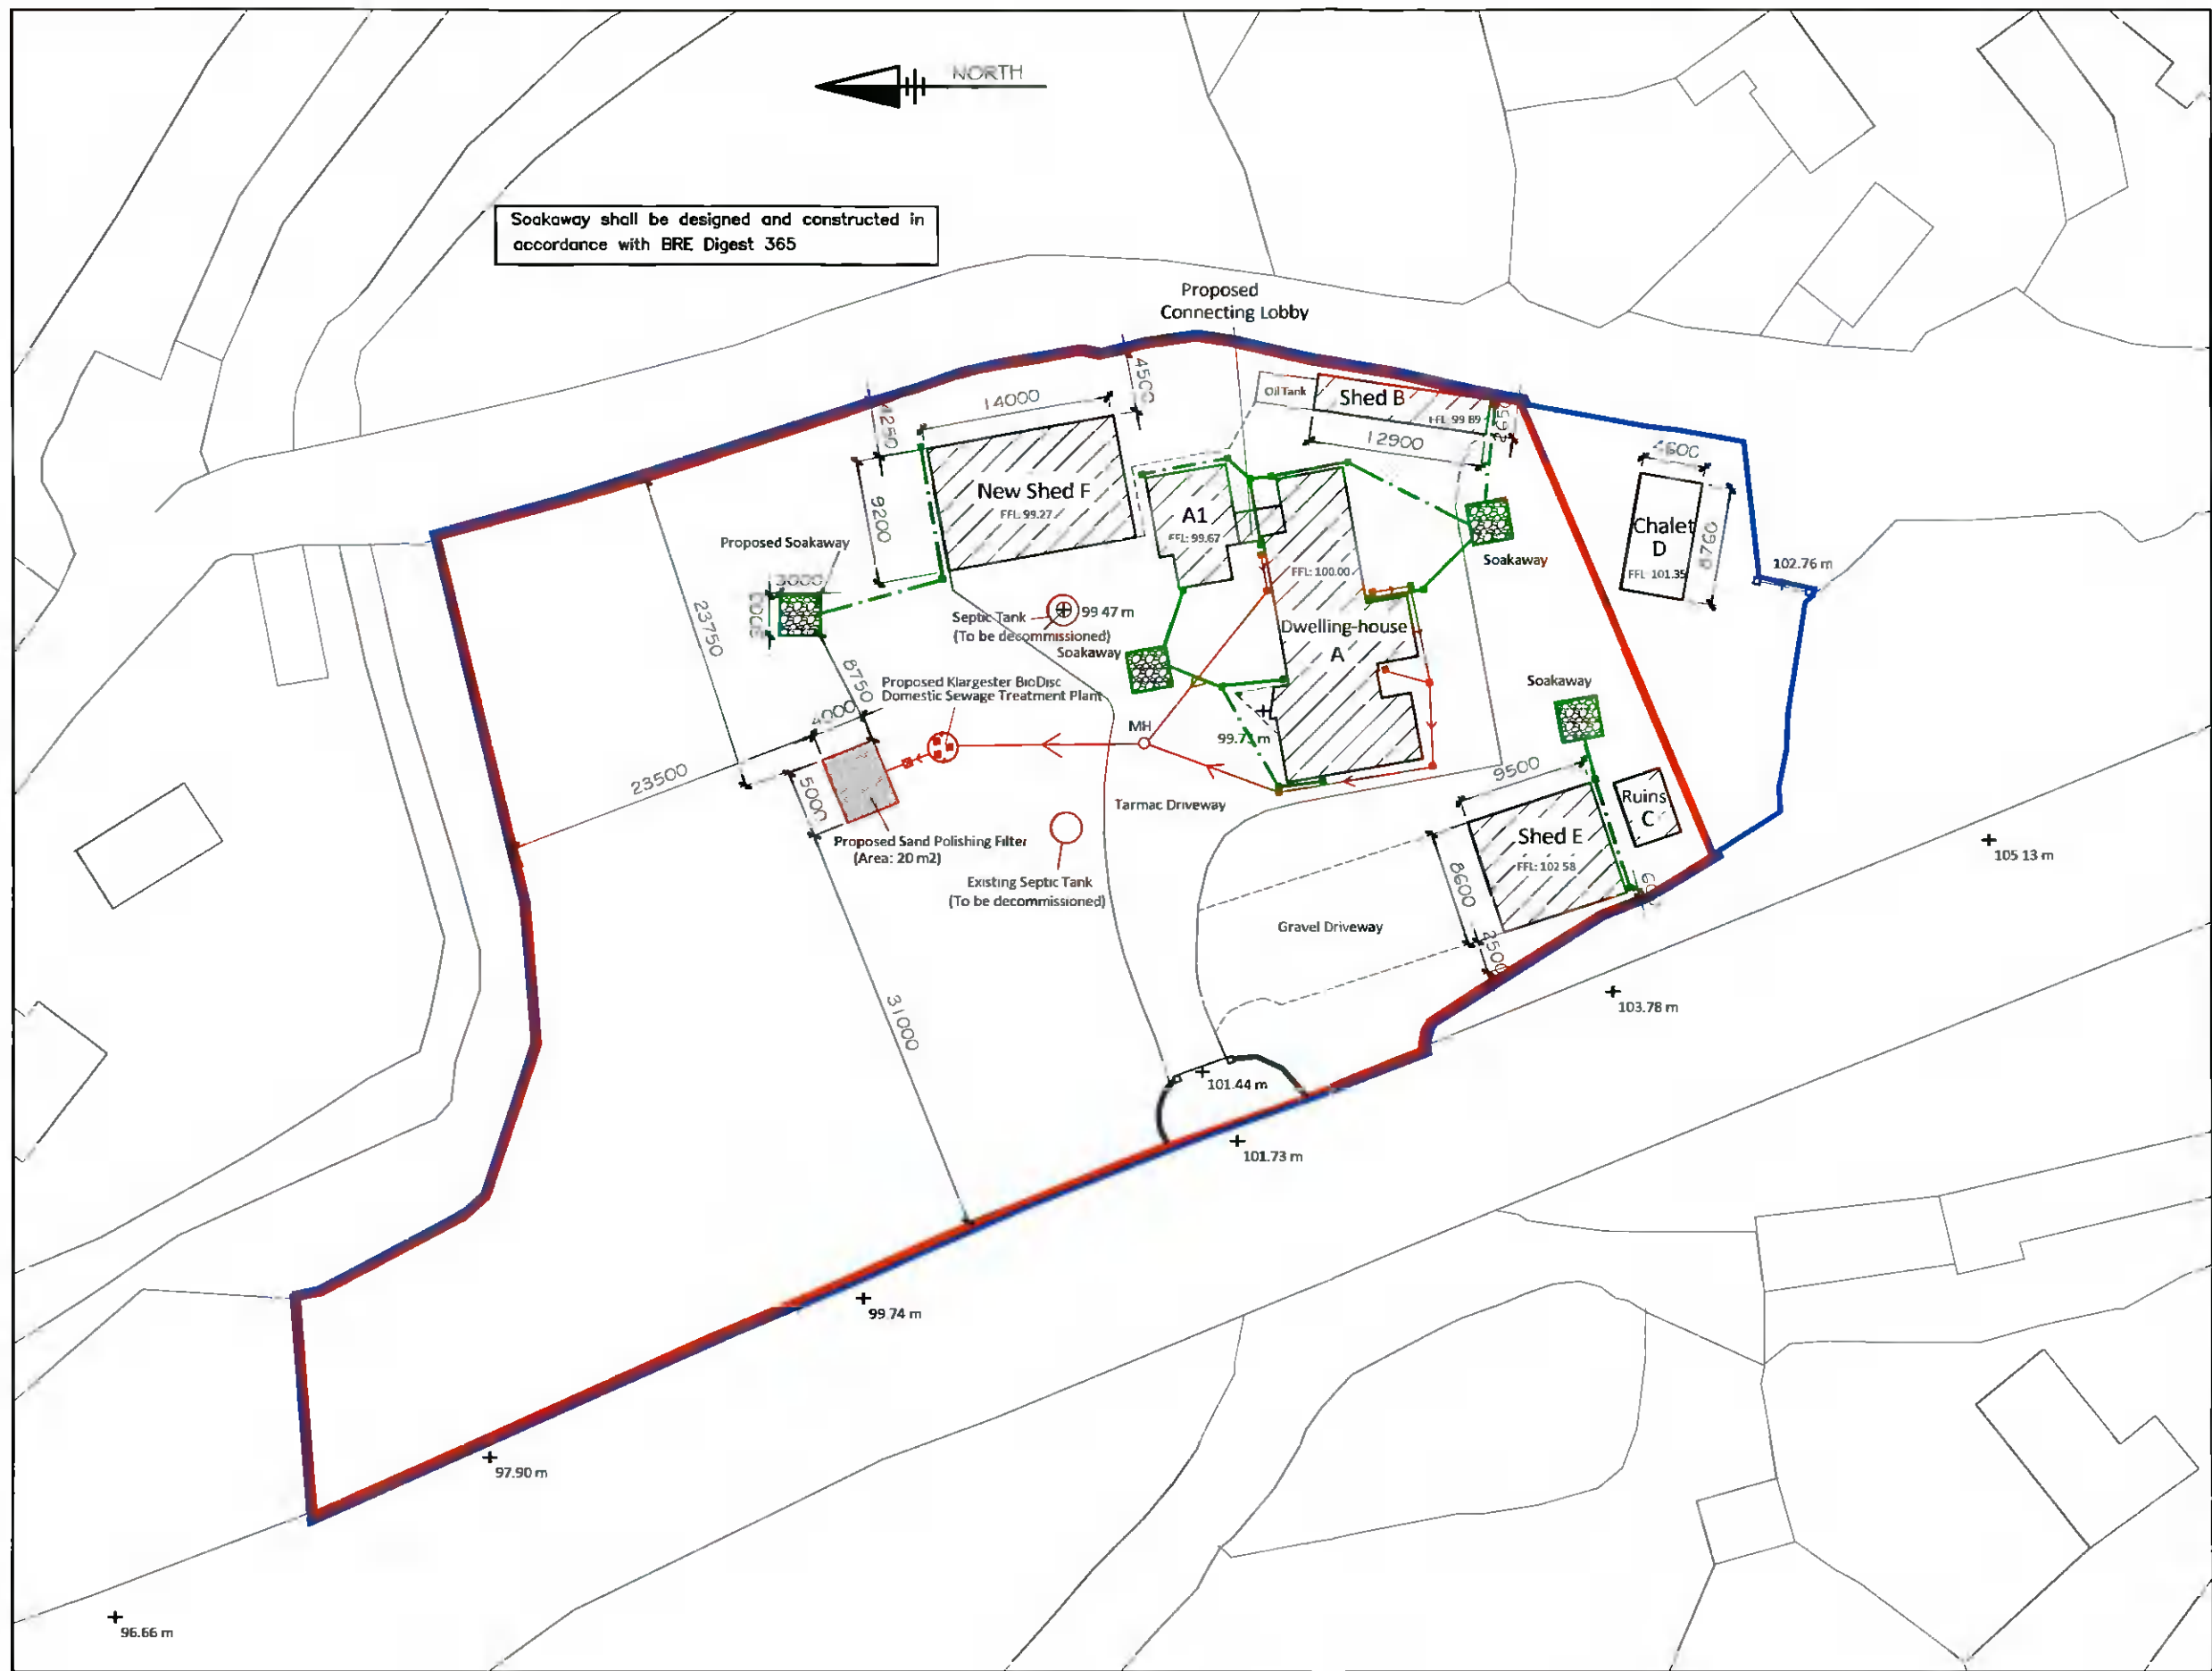

MCGILLEN DESIGN SERVICES
 PLANNING AND PROJECT MANAGEMENT

BURGAGE, T: (045) 891 468
 BLESSINGTON, M: (087) 646 9079
 CO. WICKLOW, E: petermcgillen@hotmail.com

1	ISSUED FOR PLANNING PERMISSION PURPOSES	DATE	SCALE	BY
2	ISSUED FOR PLANNING PERMISSION PURPOSES	DATE	SCALE	BY
3	ISSUED FOR APPROVAL	DATE	SCALE	BY
4	ISSUED FOR APPROVAL	DATE	SCALE	BY
5	ISSUED FOR APPROVAL	DATE	SCALE	BY
6	ISSUED FOR APPROVAL	DATE	SCALE	BY
7	ISSUED FOR APPROVAL	DATE	SCALE	BY
8	ISSUED FOR APPROVAL	DATE	SCALE	BY
9	ISSUED FOR APPROVAL	DATE	SCALE	BY
10	ISSUED FOR APPROVAL	DATE	SCALE	BY

CLIENT: **MR. GARY McKEON**

PROJECT: **EXISTING DEVELOPMENT AT GLASSAMUCKY, BOHERNABREENA, DUBLIN 24**

TITLE: **PROPOSED DRAINAGE LAYOUT PLAN**

PATRICK JOYCE ASSOCIATES
 CONSULTING ENGINEERS

2 Prospect Grove, Telephone: (0) 1 454 6745
 Rathfarnham, E-Mail: patrickjoyceassociates@gmail.com
 Dublin 14

DESIGNED	P.J.	CHECKED	P.J.	APPROVED	P.J.
DRAWN	P.J.	DATE	JULY-2021	SCALE	1:500
DRG.No.		PP/22/02		E	

PROPOSED SITE LAYOUT PLAN SCALE 1:500 (A3)

ISSUED FOR PLANNING PERMISSION PURPOSES ONLY