




SURFACE WATER NETWORK: S1.000 - S1.008

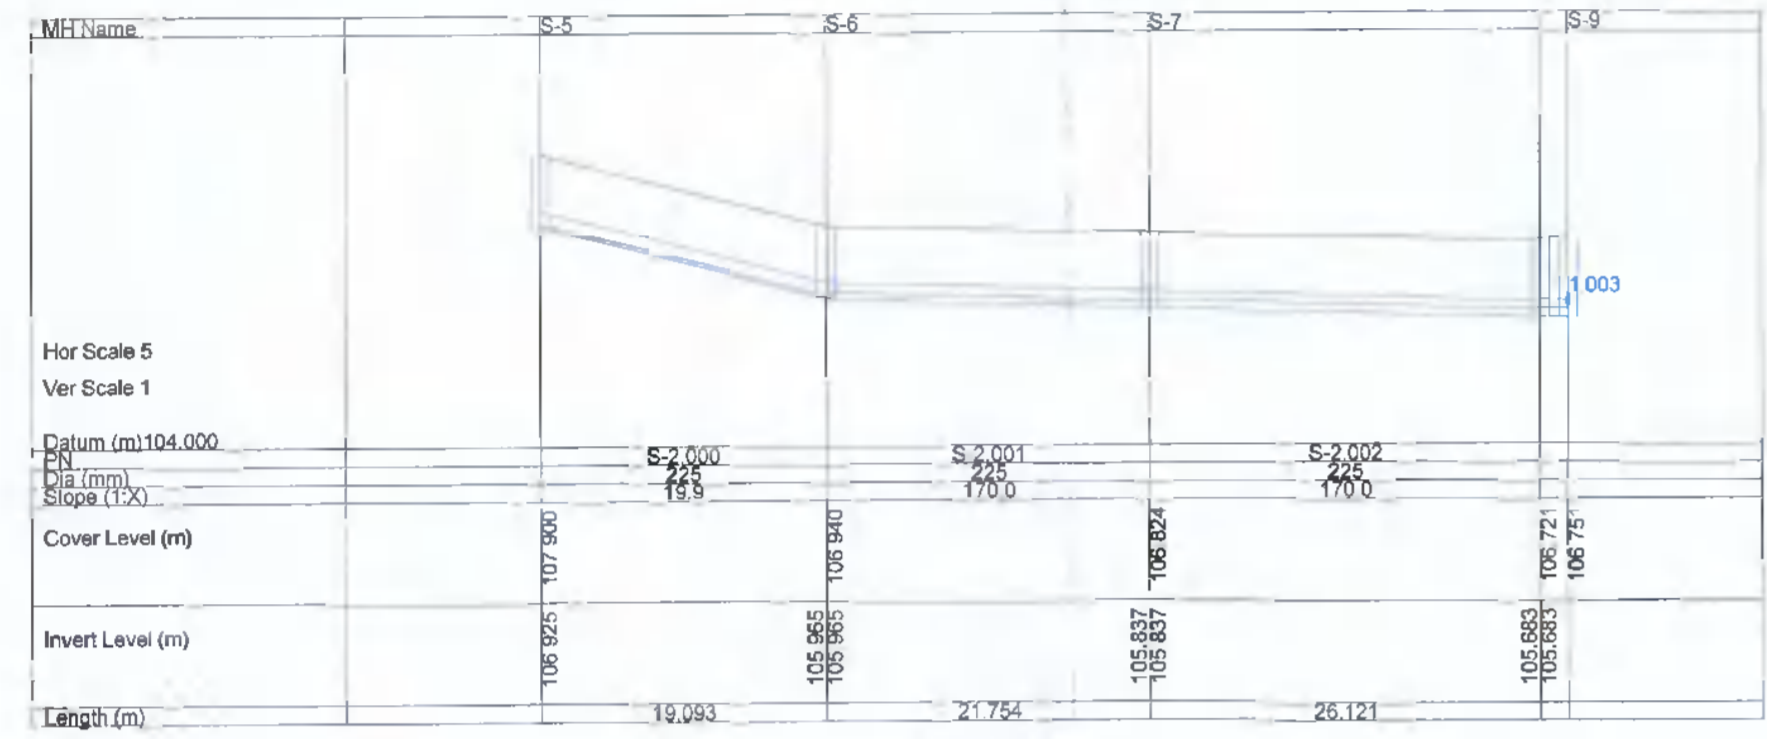


SURFACE WATER NETWORK: S2.000 - S2.002

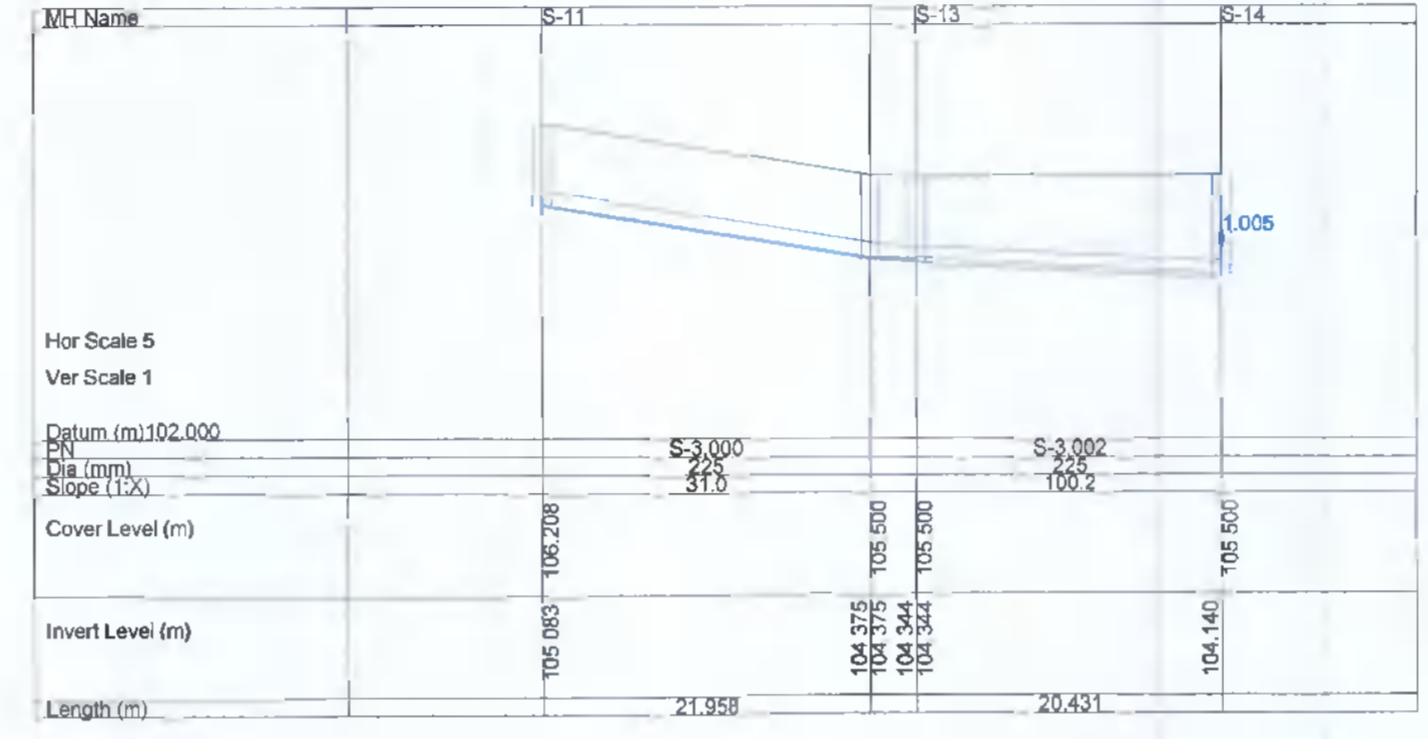

SURFACE WATER NETWORK: S3.000 - S3.002

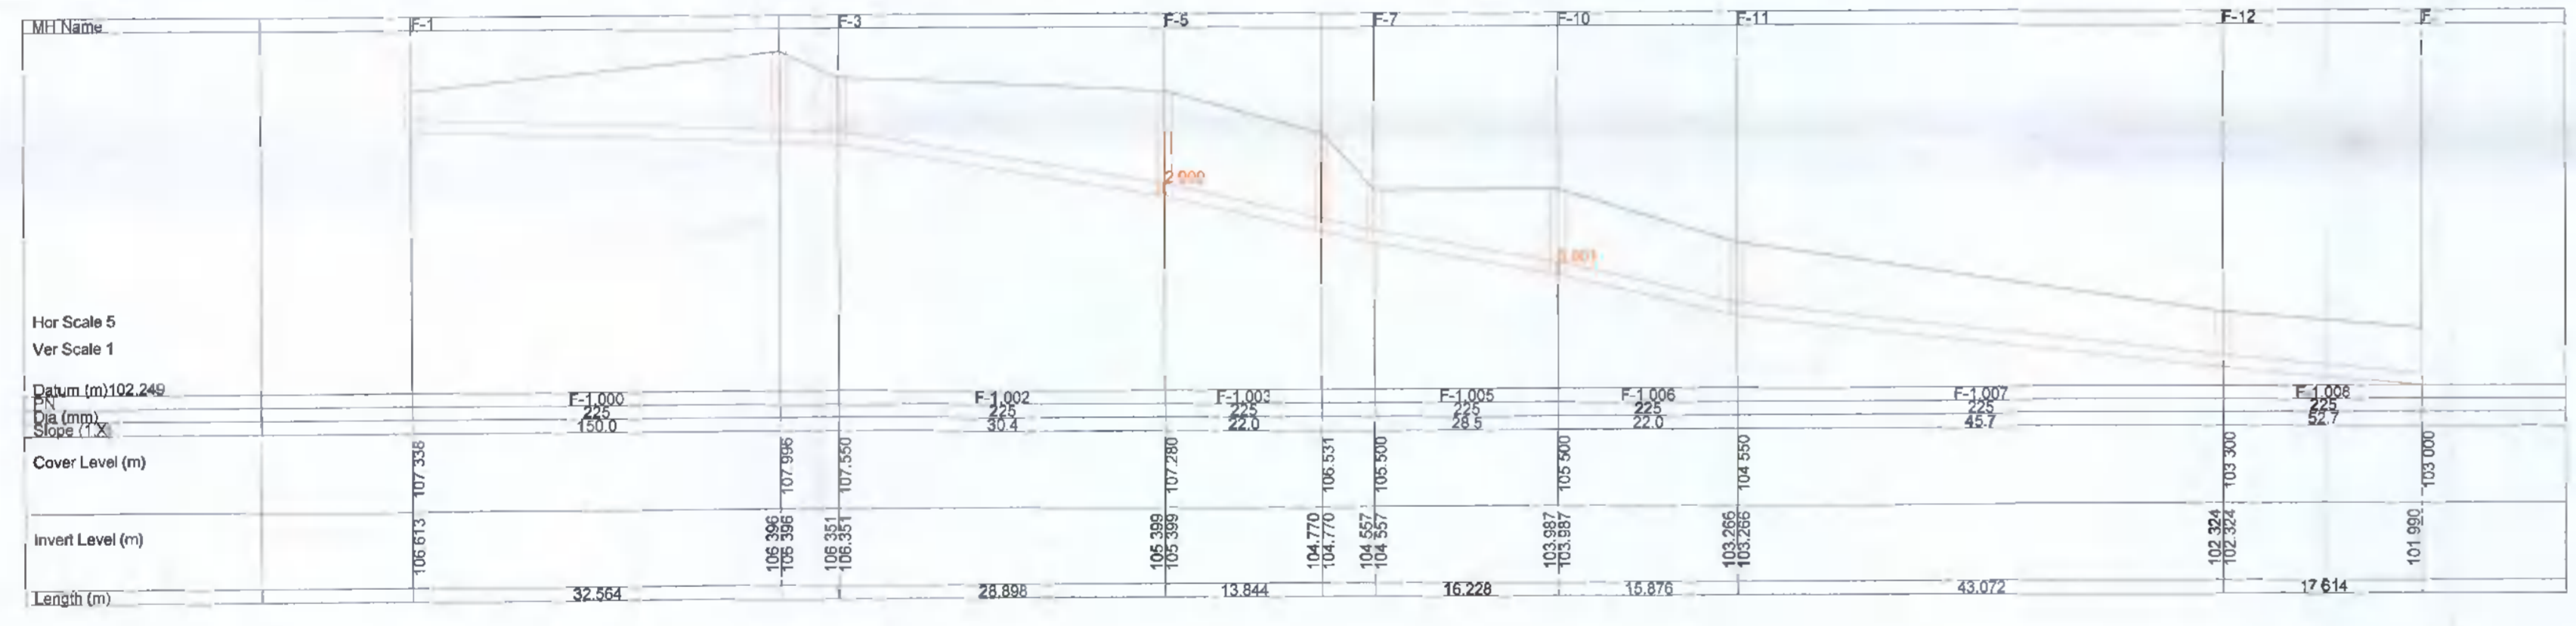


WASTEWATER NETWORK: F1.000 - F1.007

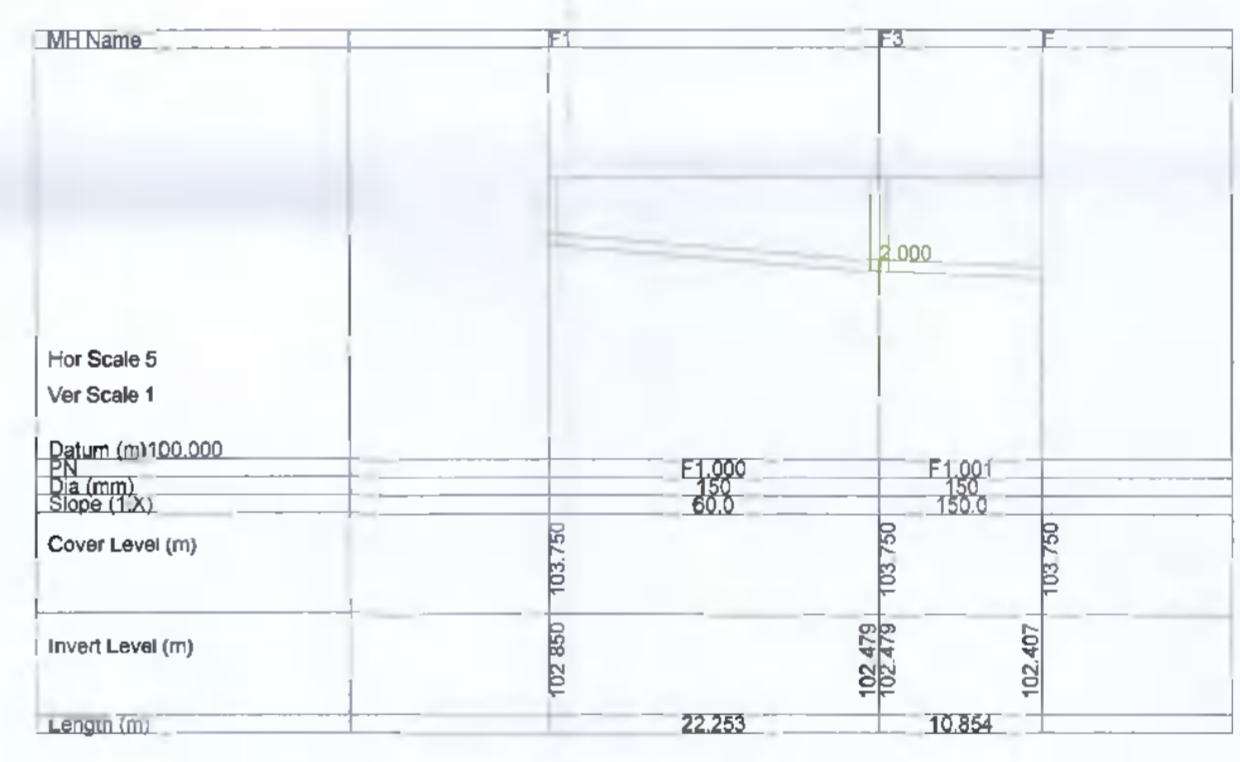


BASEMENT NETWORK: F1.000 - F1.002



WASTEWATER NETWORK: F2.000

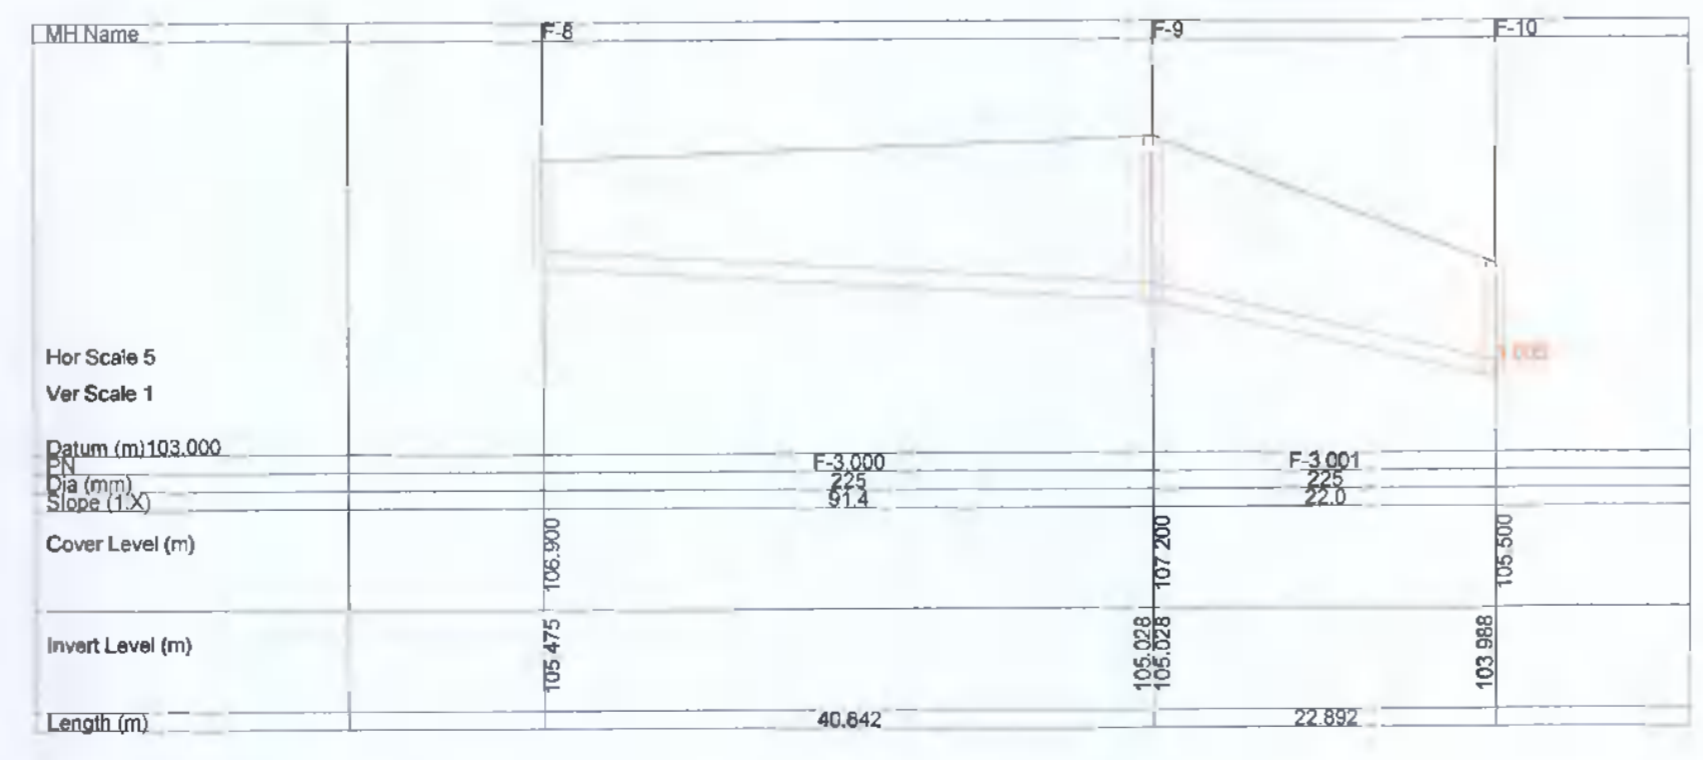

WASTEWATER NETWORK: F3.000 - F3.001

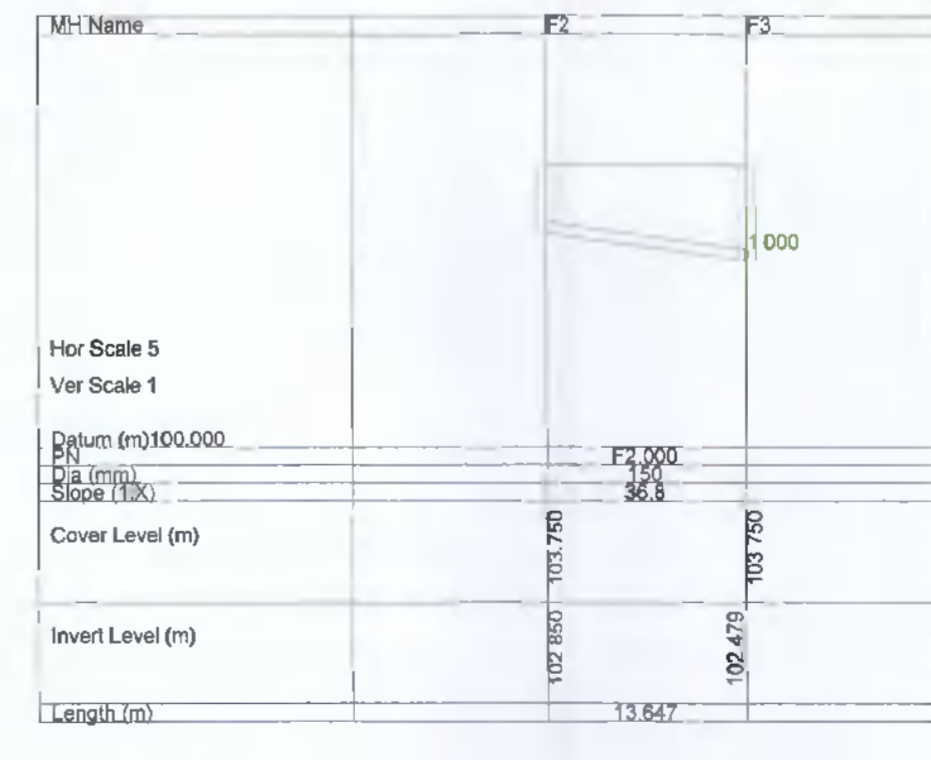

BASEMENT NETWORK: F2.000

NOTES

- ALL WASTEWATER INFRASTRUCTURE TO BE INSTALLED IN ACCORDANCE WITH IRISH WATER CODE OF PRACTICE FOR WASTEWATER INFRASTRUCTURE AND STANDARD DETAILS
- ALL SURFACE WATER INFRASTRUCTURE TO BE INSTALLED IN ACCORDANCE WITH THE GSDS AND THE GREATER DUBLIN REGION CODE OF FOR DRAINAGE WORKS.

REFERENCE NOTE

REFER TO DWG. NO. S627-OCSC-XX-XX-DR-C-0500 FOR DRAINAGE LAYOUT

PLANNING DRAWING.
NOT FOR CONSTRUCTION.
ALL LEVELS GIVEN ARE RELATIVE TO ORDNANCE DATUM.
THIS DRAWING HAS BEEN ISSUED FOR INFORMATION PURPOSES ONLY AND MUST NOT BE USED FOR CONSTRUCTION UNDER ANY CIRCUMSTANCES

- FOR SETTING OUT REFER TO ARCHITECT'S DRAWINGS.
- THIS DRAWING TO BE READ IN CONJUNCTION WITH ALL OTHER ARCHITECTURAL AND ENGINEERING DRAWINGS AND ALL OTHER RELEVANT DRAWINGS AND SPECIFICATIONS.
- DO NOT SCALE THIS DRAWING. USE FIGURED DIMENSIONS ONLY.
- NO PART OF THIS DOCUMENT MAY BE REPRODUCED OR TRANSMITTED IN ANY FORM OR STORED IN ANY RETRIEVAL SYSTEM OF ANY NATURE WITHOUT THE WRITTEN PERMISSION OF O'CONNOR SUTTON CRONIN AS COPYRIGHT HOLDER EXCEPT AS AGREED FOR USE ON THE PROJECT FOR WHICH THE DOCUMENT WAS ORIGINALLY ISSUED.

Rev No.	Date	Revision Note	Drn by	Chkd by	Rev No.	Date	Revision Note	Drn by	Chkd by
PD1	06.05.22	SUITABLE FOR PLANNING	EH	MK					
P02	20.05.22	SUITABLE FOR PLANNING	EH	MK					



Head Office,
9 Prussia Street,
Dublin 7,
D07 KT57

TEL +353 (0)1 8682000

e: contactus@ocsc.ie
w: www.ocsc.ie

Dublin London Belfast Galway Cork Birmingham

Client: MSJA LTD
Project: PROSPECT HOUSE, STOCKING LANE RATHFARNHAM
Title: DRAINAGE LONGSECTIONS

Code | Originator | Zone | Level | Type | Role | Number | Status | Revision
S627 - OCSC - XX - ZZ - DR - C - 0510 | S4 | P02

Date: MAY 22 Scale: N/A @ A1 Drn by:EH Chkd by:MK Aprvd by:MOR