



GENERAL NOTES

1. ALL DIMENSIONS ARE IN METERS UNLESS NOTED OTHERWISE
2. ONLY WRITTEN DIMENSIONS SHALL BE USED. NO DIMENSIONS SHALL BE SCALED FROM THE DRAWINGS
3. ALL LEVELS ARE IN METERS AND ARE TO MAIN ROAD DATUM
4. ALL COORDINATES ARE IN METERS AND ARE TO MAIN ROAD DATUM
5. THE SPECIFICATION


SPECIFIC NOTES:

1. THE FOUL WATER DRAINAGE NETWORKS TO BE DESIGNED AND CONSTRUCTED IN COMPLIANCE WITH THE DETAILED REQUIREMENTS FOR HOUSING AND DEVELOPMENT WORKS FOR HOUSING AREAS AND ARE TO BE DESIGNED IN ACCORDANCE WITH THE REQUIREMENTS OF THE SUDAS ACT 2009 AND THE SUDAS REGULATIONS 2010. ALL FOUL WATER IS TO BE DISCHARGED INTO THE STORM SEWER SYSTEM UNDER ANY CIRCUMSTANCES. CONTRACTOR TO CONFIRM AS-BUILT LEVELS ON SITE PRIOR TO CONSTRUCTION.
2. SEE ARCHITECTS' MADE DRAWINGS FOR FOUL TIE IN POINTS TO THE BUILDING AND INTERNAL DRAINAGE.

KEY PLAN 1:10000

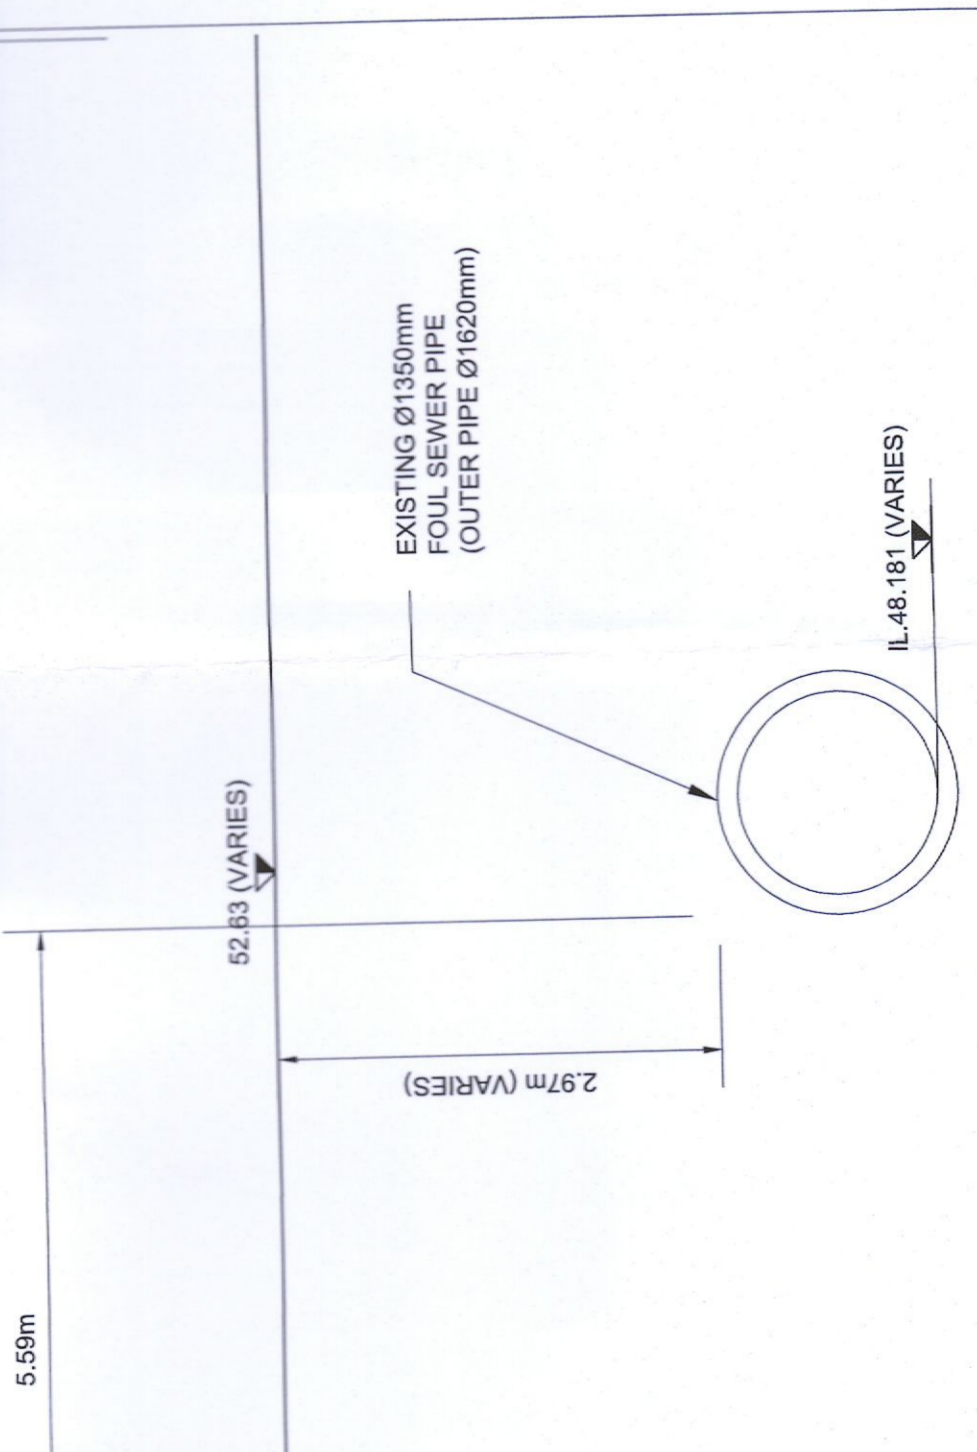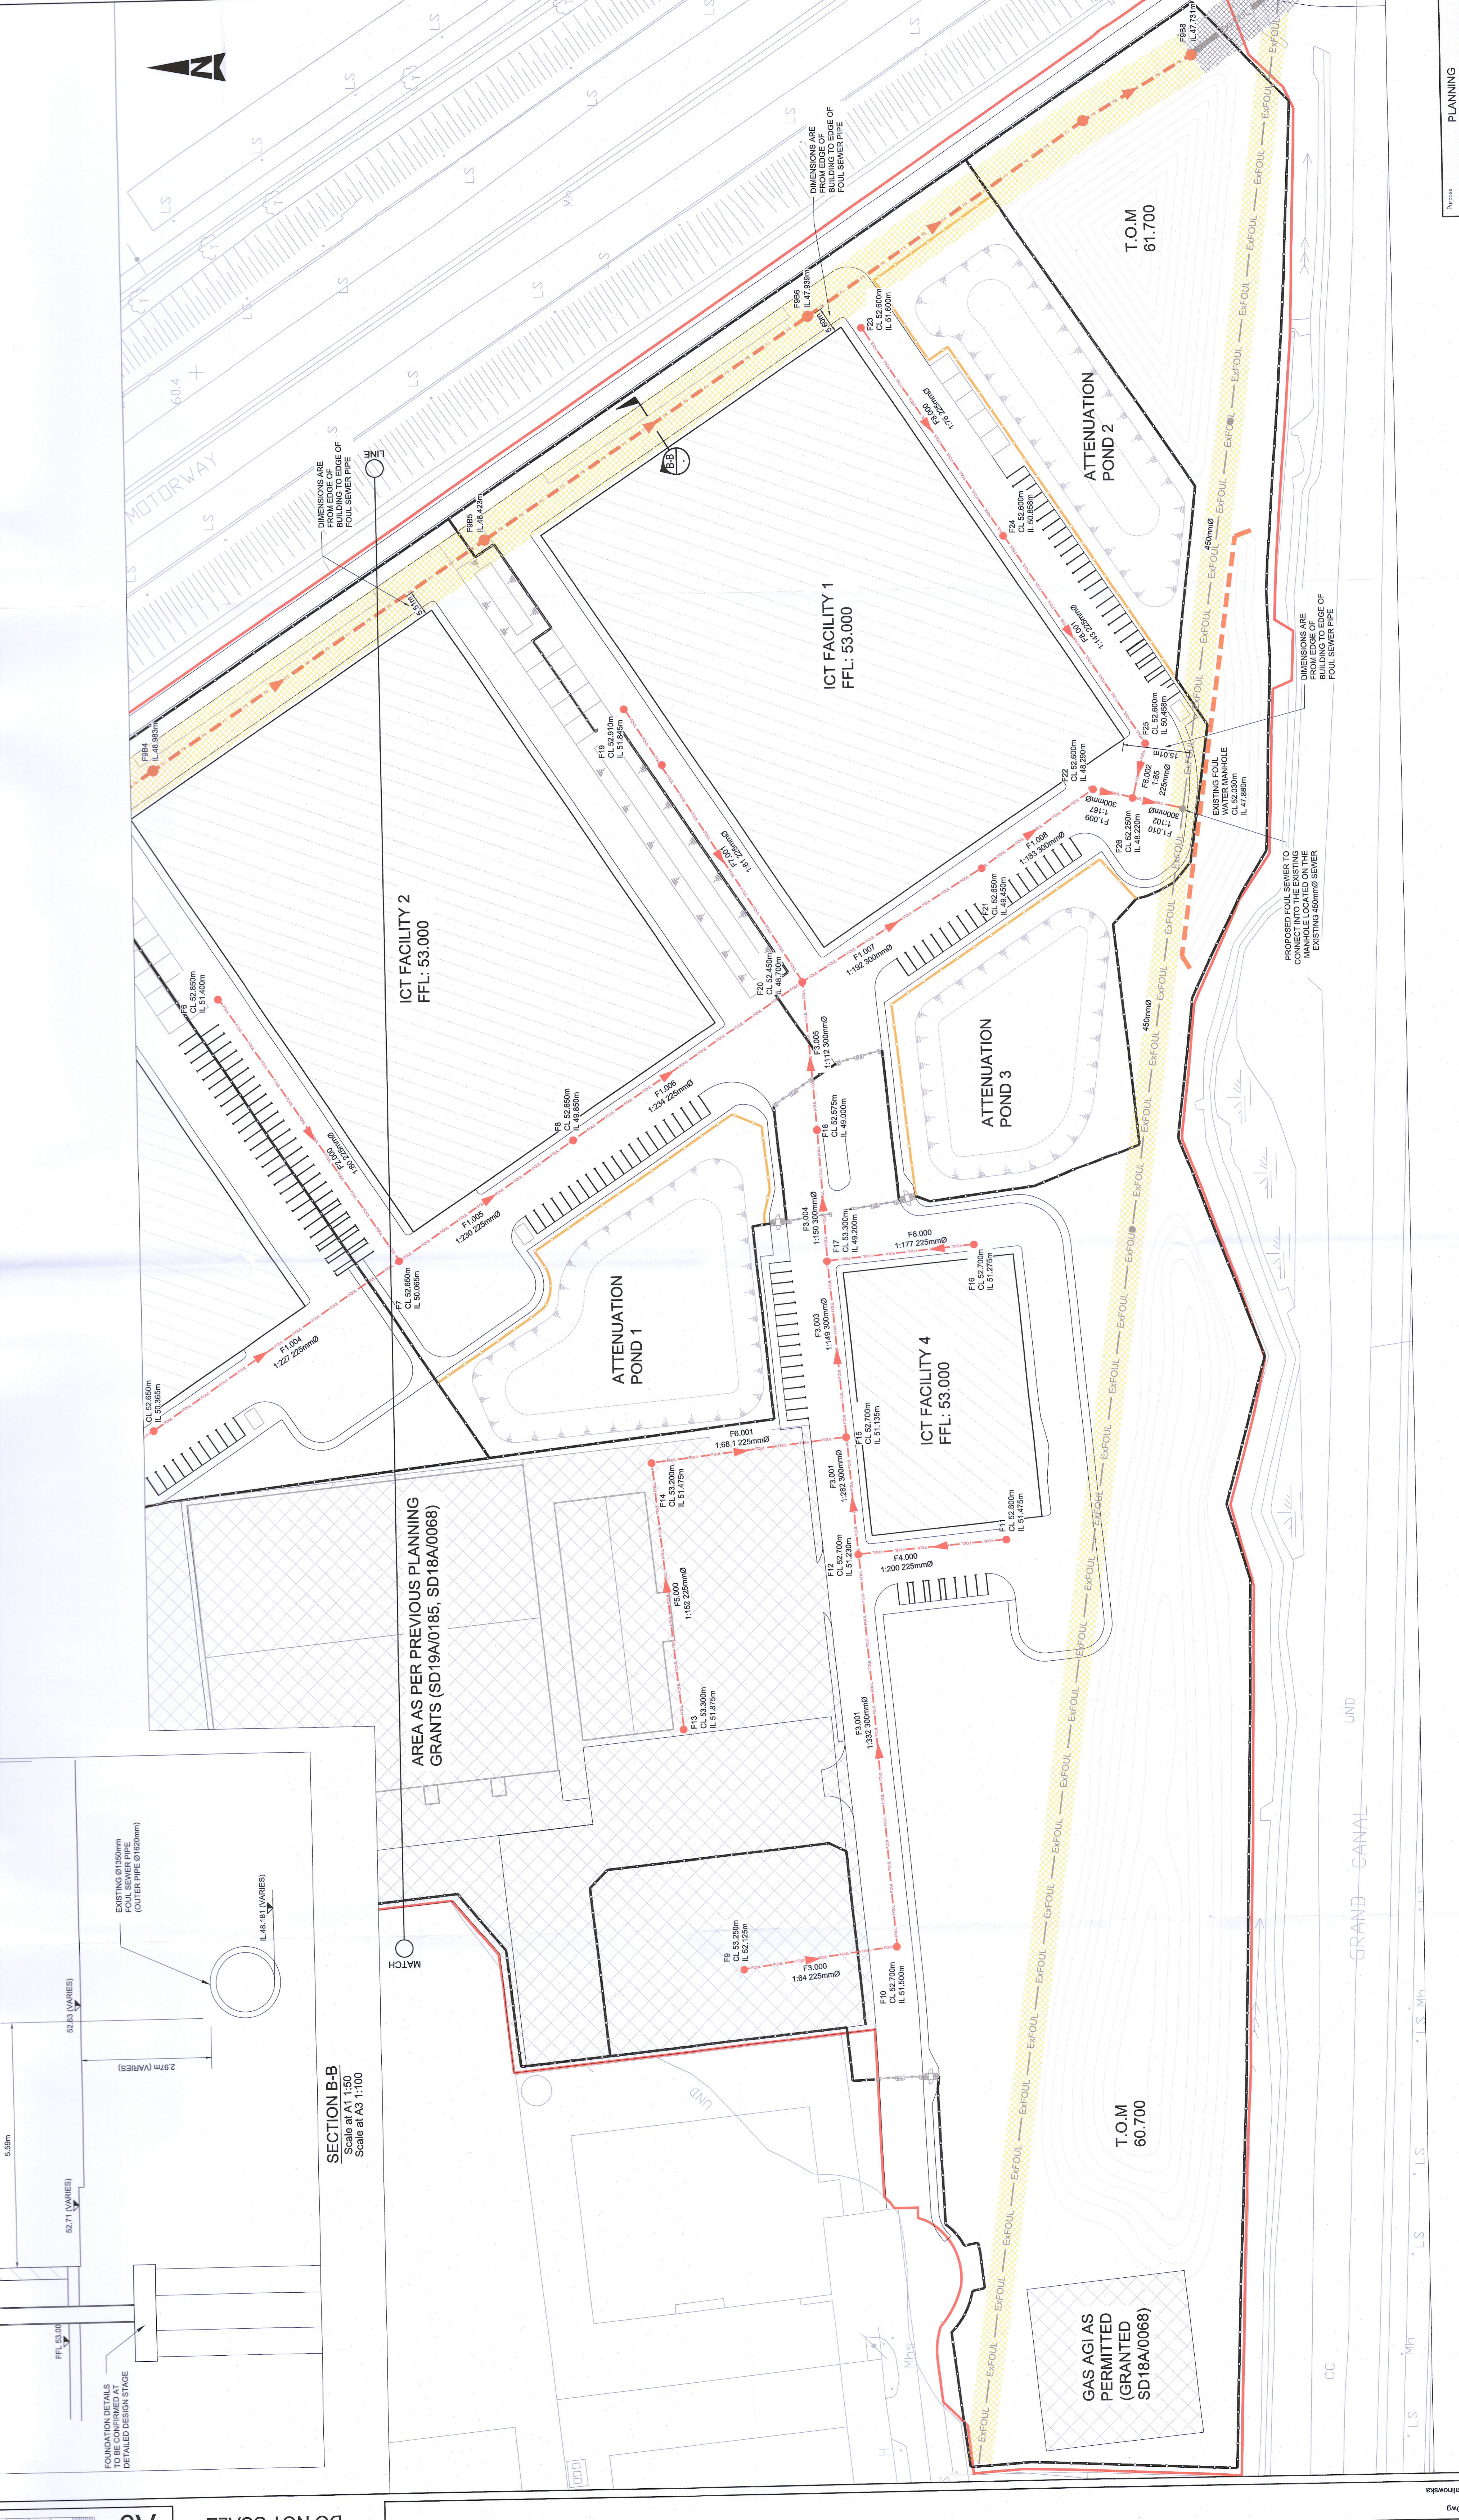

SECTION B-B
Scale at A1 1:50
Scale at A3 1:100

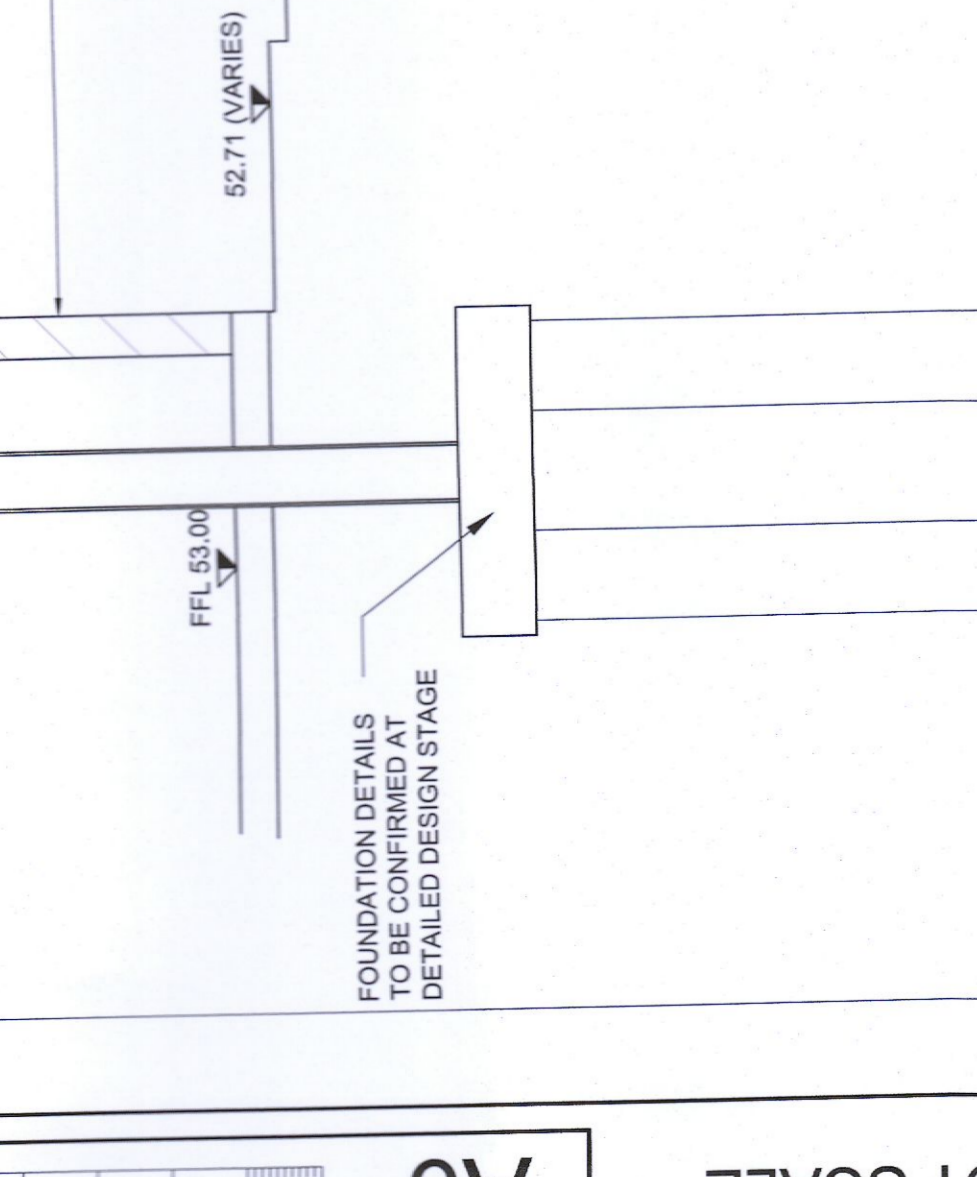

PROPOSED FOUL DRAINAGE LAYOUT SHEET 2

ATKINS
Member of the SNC-Lavalin Group

ECHELON Clondalkin DC Services Limited
Clondalkin ICT Facility

Rev	Date	Description
1	17.09.20	ISSUED FOR OUTLINE PLANNING
2	17.09.20	ISSUED FOR OUTLINE PLANNING
3	17.09.20	ISSUED FOR PLANNING
4	17.09.20	ISSUED FOR FURTHER INFORMATION
5	17.09.20	ISSUED FOR FURTHER INFORMATION

OS SHEET REFERENCES:

3261-25 3262-21

LEGEND

- PROPOSED FOUL SEWER PIPE
- PROPOSED FOUL SEWER MANHOLE
- EXISTING FOUL SEWER LINE TO BE RETAINED
- EXISTING FOUL SEWER LINE TO BE REMOVED
- EXISTING GABION RETAINING WALL
- EXISTING WAYLEAVE
- PERMITTED FOUL SEWER PIPE

OS SHEET REFERENCES:

3261-25 3262-21

LEGEND

- EXTENTS OF PLANNING APPLICATION
- PROPOSED RETAINING WALL
- PROPOSED GABION RETAINING WALL
- EXISTING WAYLEAVE
- PERMITTED FOUL SEWER PIPE

PLANNING

PROPOSED FOUL DRAINAGE LAYOUT SHEET 2

Project: Clondalkin ICT Facility

Client: ECHELON Clondalkin DC Services Limited

Scale: 1:10000

Author: JOK

Checker: JOK

Date: 17.09.20

Issue: 17.09.20

Revision: 5

Project Number: DUB10-ATK-ZZ-DR-C-960522

Revision: 5