
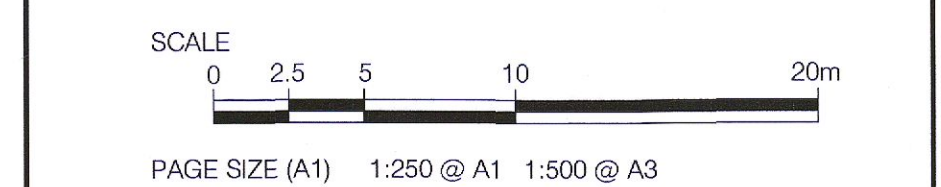
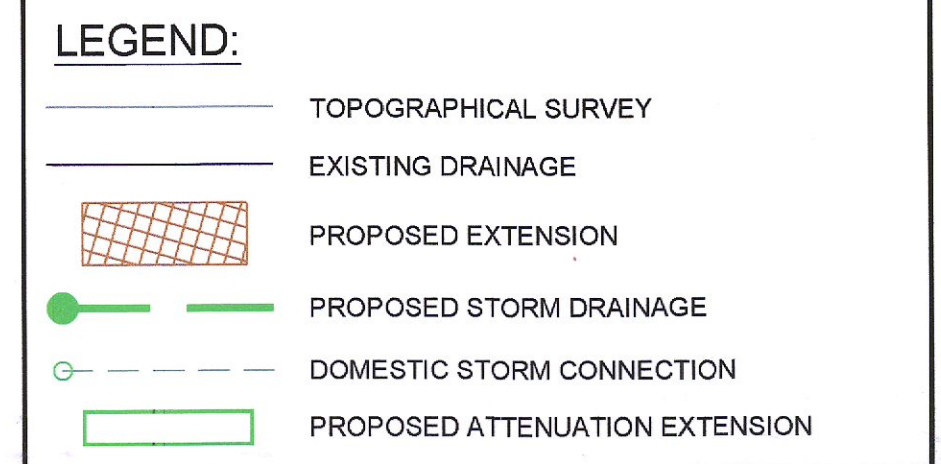


21-182-P-100 STORM DRAINAGE LAYOUT
 C:\Users\Kevin.McShane\Documents\Company Files\Kevin.McShane Ltd\2021\21-182-Kiltipper Woods Care Home, Tallaght, Dublin\Drawings\21-182-P-100 Storm Drainage Layout

THIS DRAWING HAS BEEN PREPARED FOR THE SOLE USE OF KEVIN MCSHANE LTD.'S CLIENT. IT MAY NOT BE USED, MODIFIED, REPRODUCED OR RELIED UPON BY THIRD PARTIES EXCEPT WITH PRIOR WRITTEN AGREEMENT FROM KEVIN MCSHANE LTD. KEVIN MCSHANE LTD ACCEPTS NO RESPONSIBILITY, AND DENIES ANY LIABILITY WHATSOEVER, TO ANY PARTY THAT USES OR RELIES ON THIS DRAWING WITHOUT KEVIN MCSHANE LTD.'S EXPRESS WRITTEN CONSENT. ANY INFORMATION PROVIDED BY THIRD PARTIES AND REFERRED TO HEREIN HAS NOT BEEN CHECKED OR VERIFIED BY KEVIN MCSHANE LTD. DO NOT SCALE FROM THIS DRAWING, ALL MEASUREMENTS TO BE OBTAINED FROM THE STATED DIMENSION.

NOTES:
 1. EXISTING INFORMATION PROVIDED BY OTHERS AND NO GUARANTEE AS TO THE ACCURACY IS GIVEN BY KEVIN MCSHANE LTD.

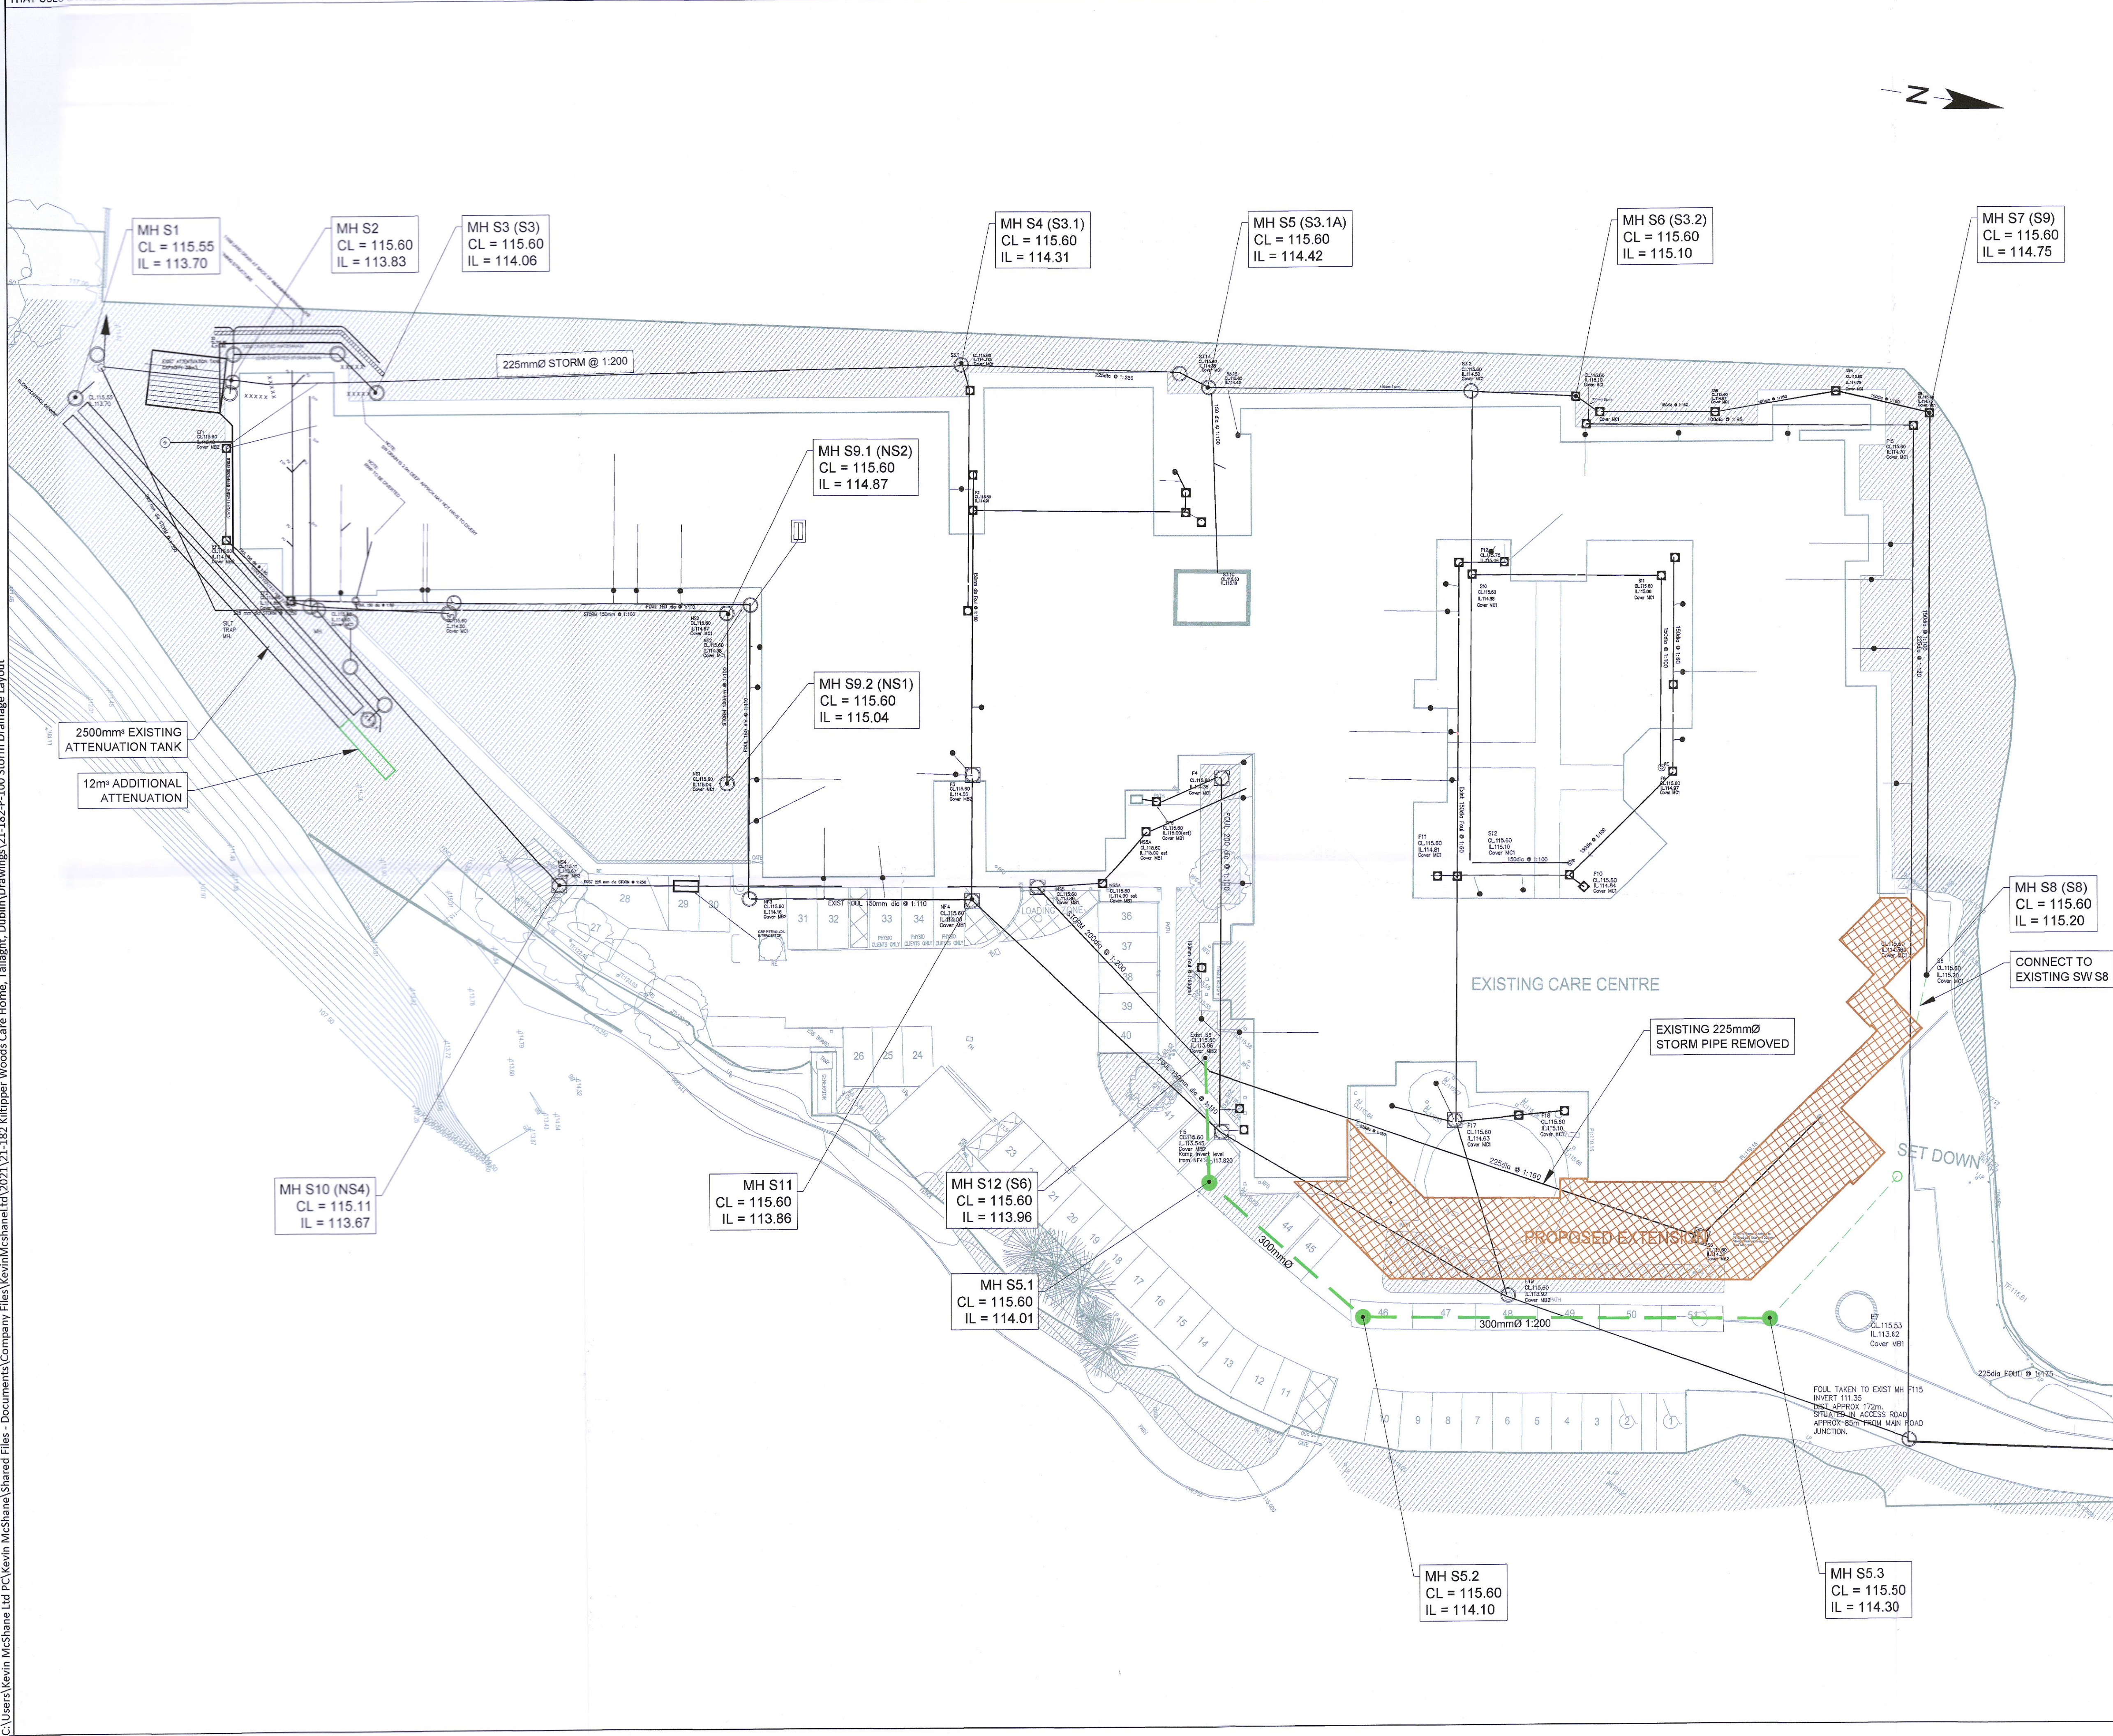

Rev.	Date	Description	By	Chkd	App'd
STATUS: PRELIMINARY					

Kevin McShane Ltd
 Civil Engineering & Transport Planning
 The Studio, 555 Lisburn Road, Belfast, BT9 7GQ
 T: 028 95609798
 E: info@kevinmcs Shane.co.uk

MR D MCDERMOTT	client	
KILTIPPER WOODS CARE CENTRE KILTIPPER ROAD DUBLIN	project	
DRAINAGE LAYOUT PROPOSED STORM WATER DRAINAGE	drawing	
project no. 21-182	client no. 21-182-P-100	rev no. -
drawn SMG	scale 1:250 @ A1	date 15-02-2022