


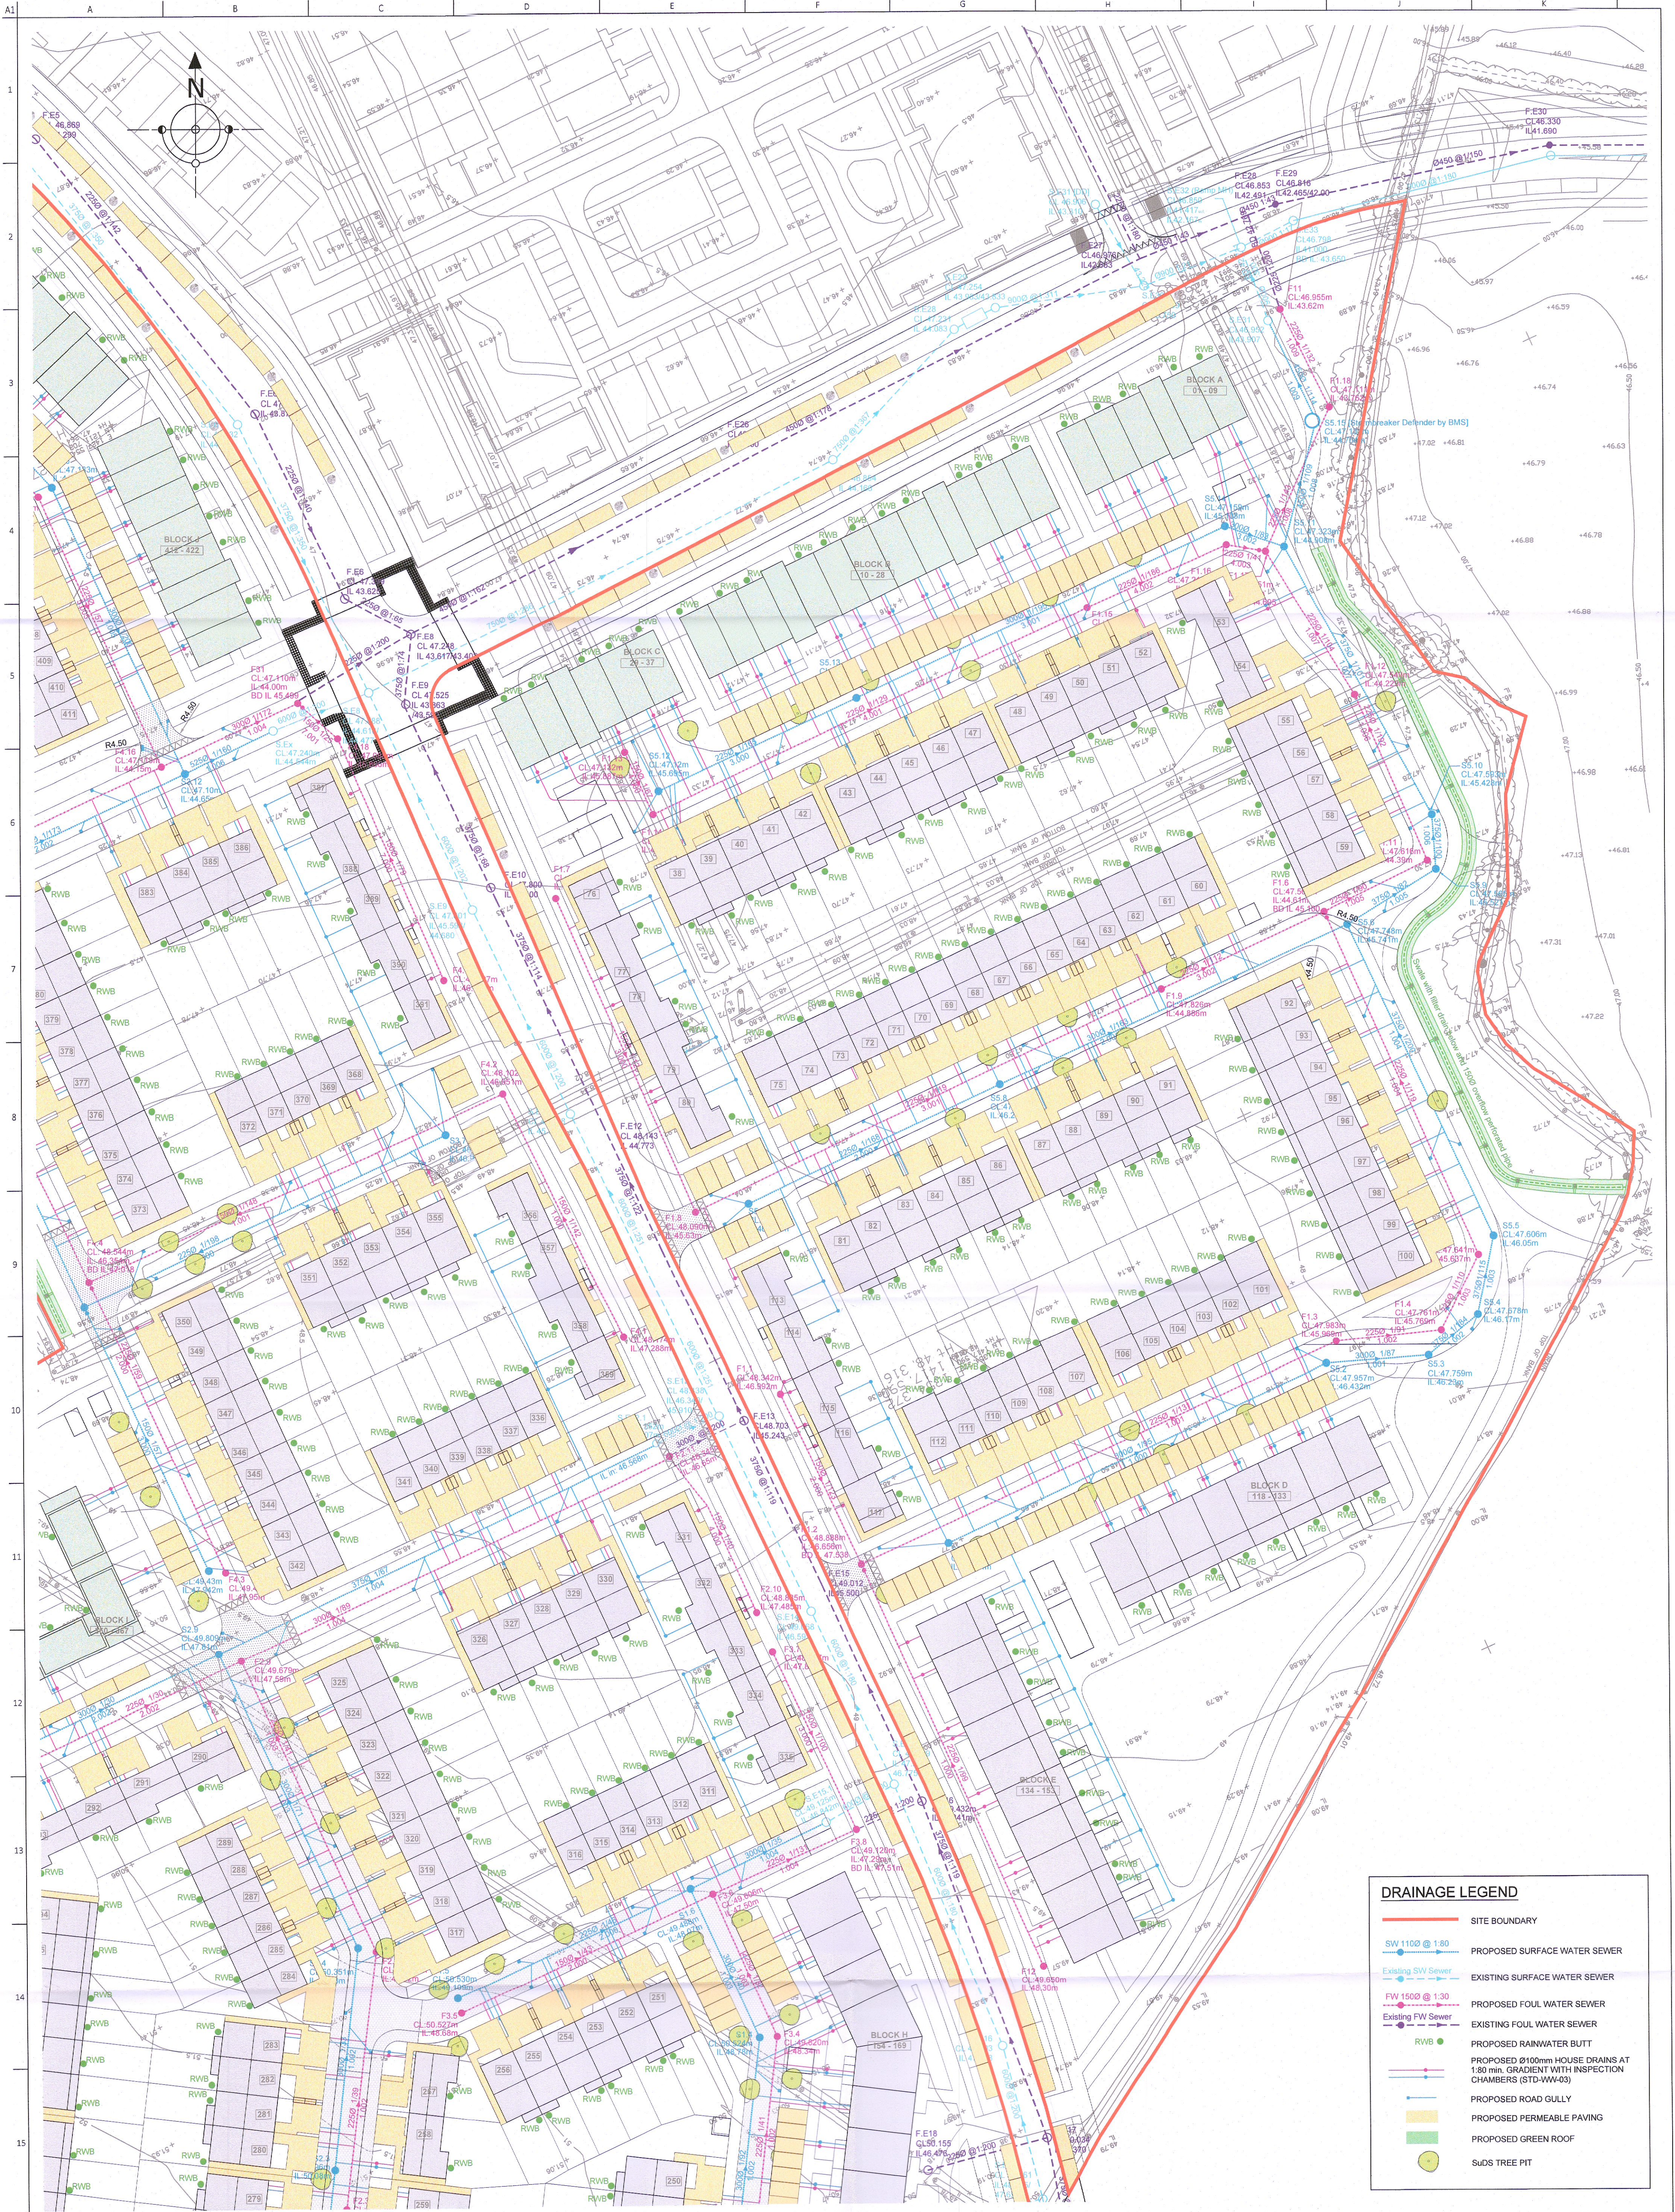

DRAINAGE LEGEND

SITE BOUNDARY

SW 1100 @ 1:80

EXISTING SW Sewer

FW 1500 @ 1:30

EXISTING FW Sewer

RWB

PROPOSED RAINWATER BUTT

PROPOSED 100mm HOUSE DRAINS AT 1:80 min. GRADIENT WITH INSPECTION CHAMBERS (STD-WW-03)

PROPOSED ROAD GULLY

PROPOSED PERMEABLE PAVING

PROPOSED GREEN ROOF

SUDS TREE PIT

Ordnance Survey Ireland Licence No. EN 0055632
© Ordnance Survey Ireland / Government of Ireland
This drawing is Copyright and must only be used for the project named

P3	27.06.2022	LAYOUT UPDATED	NMO
P2	17.12.2021	REDLINE BOUNDARY UPDATED	NMO
P1	19.11.2021	SITE LAYOUT UPDATED	CG
Rev.	Date	Description	By

Project Title
**PHASE 3
TUBBER LANE - ADAMSTOWN**

Architect
DAVEY & SMITH ARCHITECTS

Date	By	Checked	Scale @ A1
SEP 2021	CG NMO	PM	1:500

Drawing Title
**DRAINAGE LAYOUT
SHEET 3 OF 3**

Drawing Status
PLANNING

Job No.	Drawing No.	Issue
20065	106	P3

**POGA**
CONSULTING ENGINEERS
STRUCTURAL • CIVIL

Unit C2, Nutgrove Office Park
Rathfarnham
Dublin 14
D14 CR20
Tel: +353 (0)1 205 1101
www.poga.ie