


REVISION SCHEDULE				
REV. NO.	REV. DESCRIPTION	REV. DATE	DRAWN	CHECKED
P01	ISSUED FOR PLANNING	16/06/2022	CG	JMM

DRAINAGE LEGEND	
	FOUL SEWER (EXISTING)
	FOUL SEWER (NEW)
	FOUL SEWER (SLUNG FROM GROUND FLOOR SLAB)
	SURFACE WATER SEWER (EXISTING)
	SURFACE WATER SEWER (NEW)
	SURFACE WATER (SLUNG FROM GROUND FLOOR SLAB)
	GREY WATER SEWER (EXISTING)
	GREY WATER SEWER (NEW)
	FOUL SEWER RISING MAIN
	SURFACE WATER RISING MAIN
	GREY WATER RISING MAIN
	EXISTING SEWER TO BE DECOMMISSIONED
	EXISTING WATER MAIN
	PROPOSED WATER MAIN
	PROPOSED FLOOD PIPES
	FSMH (NEW FOUL SEWER MANHOLE)
	SWMH (NEW SURFACE WATER MANHOLE)
	FIRE HYDRANT

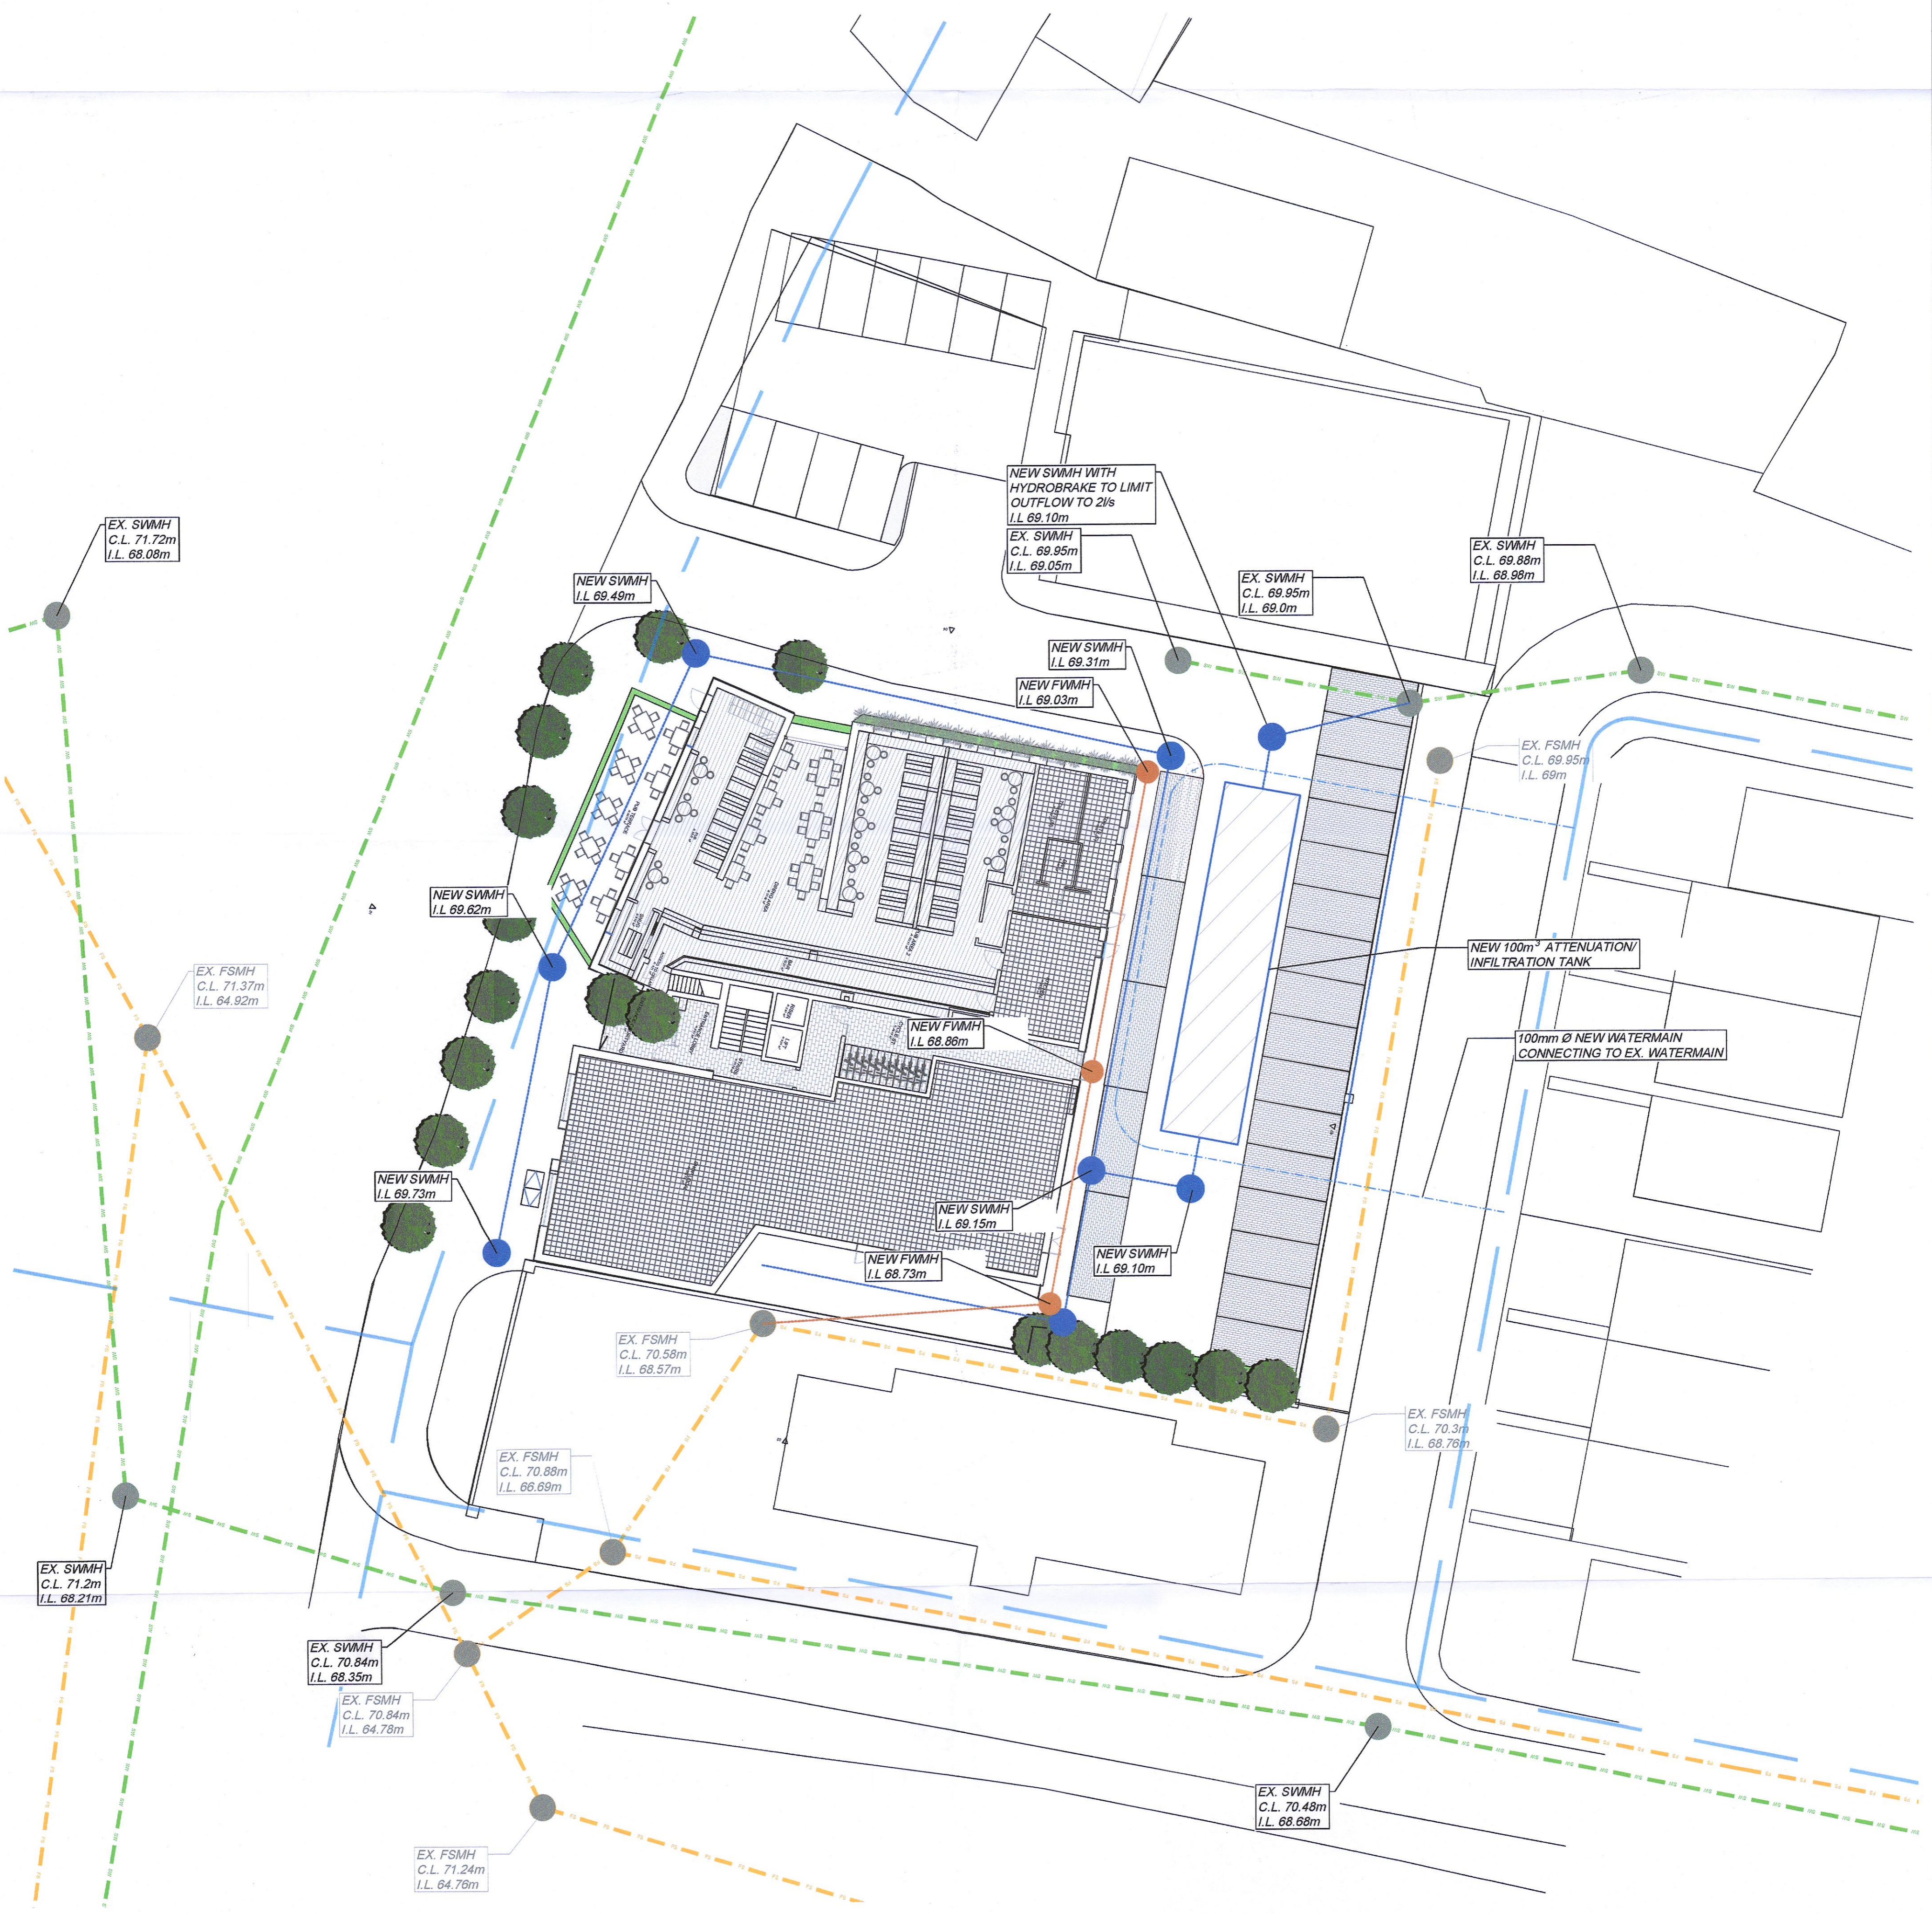

Drawing Stage: PLANNING	Project Details:	Drawn by: CG	Checked by: JMM	Approved by: JMM	Date: 16/06/2022		Behan House, 10 Lower Mount Street, Dublin 2. D02 HT71 Tel: +353 (0)1 661 1100 e-mail: info@cora.ie Web: www.cora.ie																		
	Site Address: CUCKOO'S NEST, GREENHILLS ROAD, KILNAMANAGH, DUBLIN24	Project Name: CUCKOO'S NEST		Scale: 1:200	Project Number: 21816		<table border="1"> <tr> <td>Project:</td> <td>Originator:</td> <td>Zone:</td> <td>Level:</td> <td>Type:</td> <td>Discipline:</td> <td>Drawing No:</td> <td>Stage:</td> <td>Revision:</td> </tr> <tr> <td>21816</td> <td>CORA</td> <td>ZZ</td> <td>00</td> <td>DR</td> <td>C</td> <td>101</td> <td>03</td> <td>P01</td> </tr> </table>	Project:	Originator:	Zone:	Level:	Type:	Discipline:	Drawing No:	Stage:	Revision:	21816	CORA	ZZ	00	DR	C	101	03	P01
	Project:	Originator:	Zone:	Level:	Type:			Discipline:	Drawing No:	Stage:	Revision:														
	21816	CORA	ZZ	00	DR			C	101	03	P01														
Client: -	Drawing Title: PROPOSED DRAINAGE LAYOUT PLAN		Project:	Originator:	Zone:	Level:	Type:	Discipline:	Drawing No:	Stage:	Revision:														
Architect: DAVEY SMITH ARCHITECTS	Contractor: -		21816	CORA	ZZ	00	DR	C	101	03	P01														