



1 SITE LOCATION MAP
Scale: 1:1000

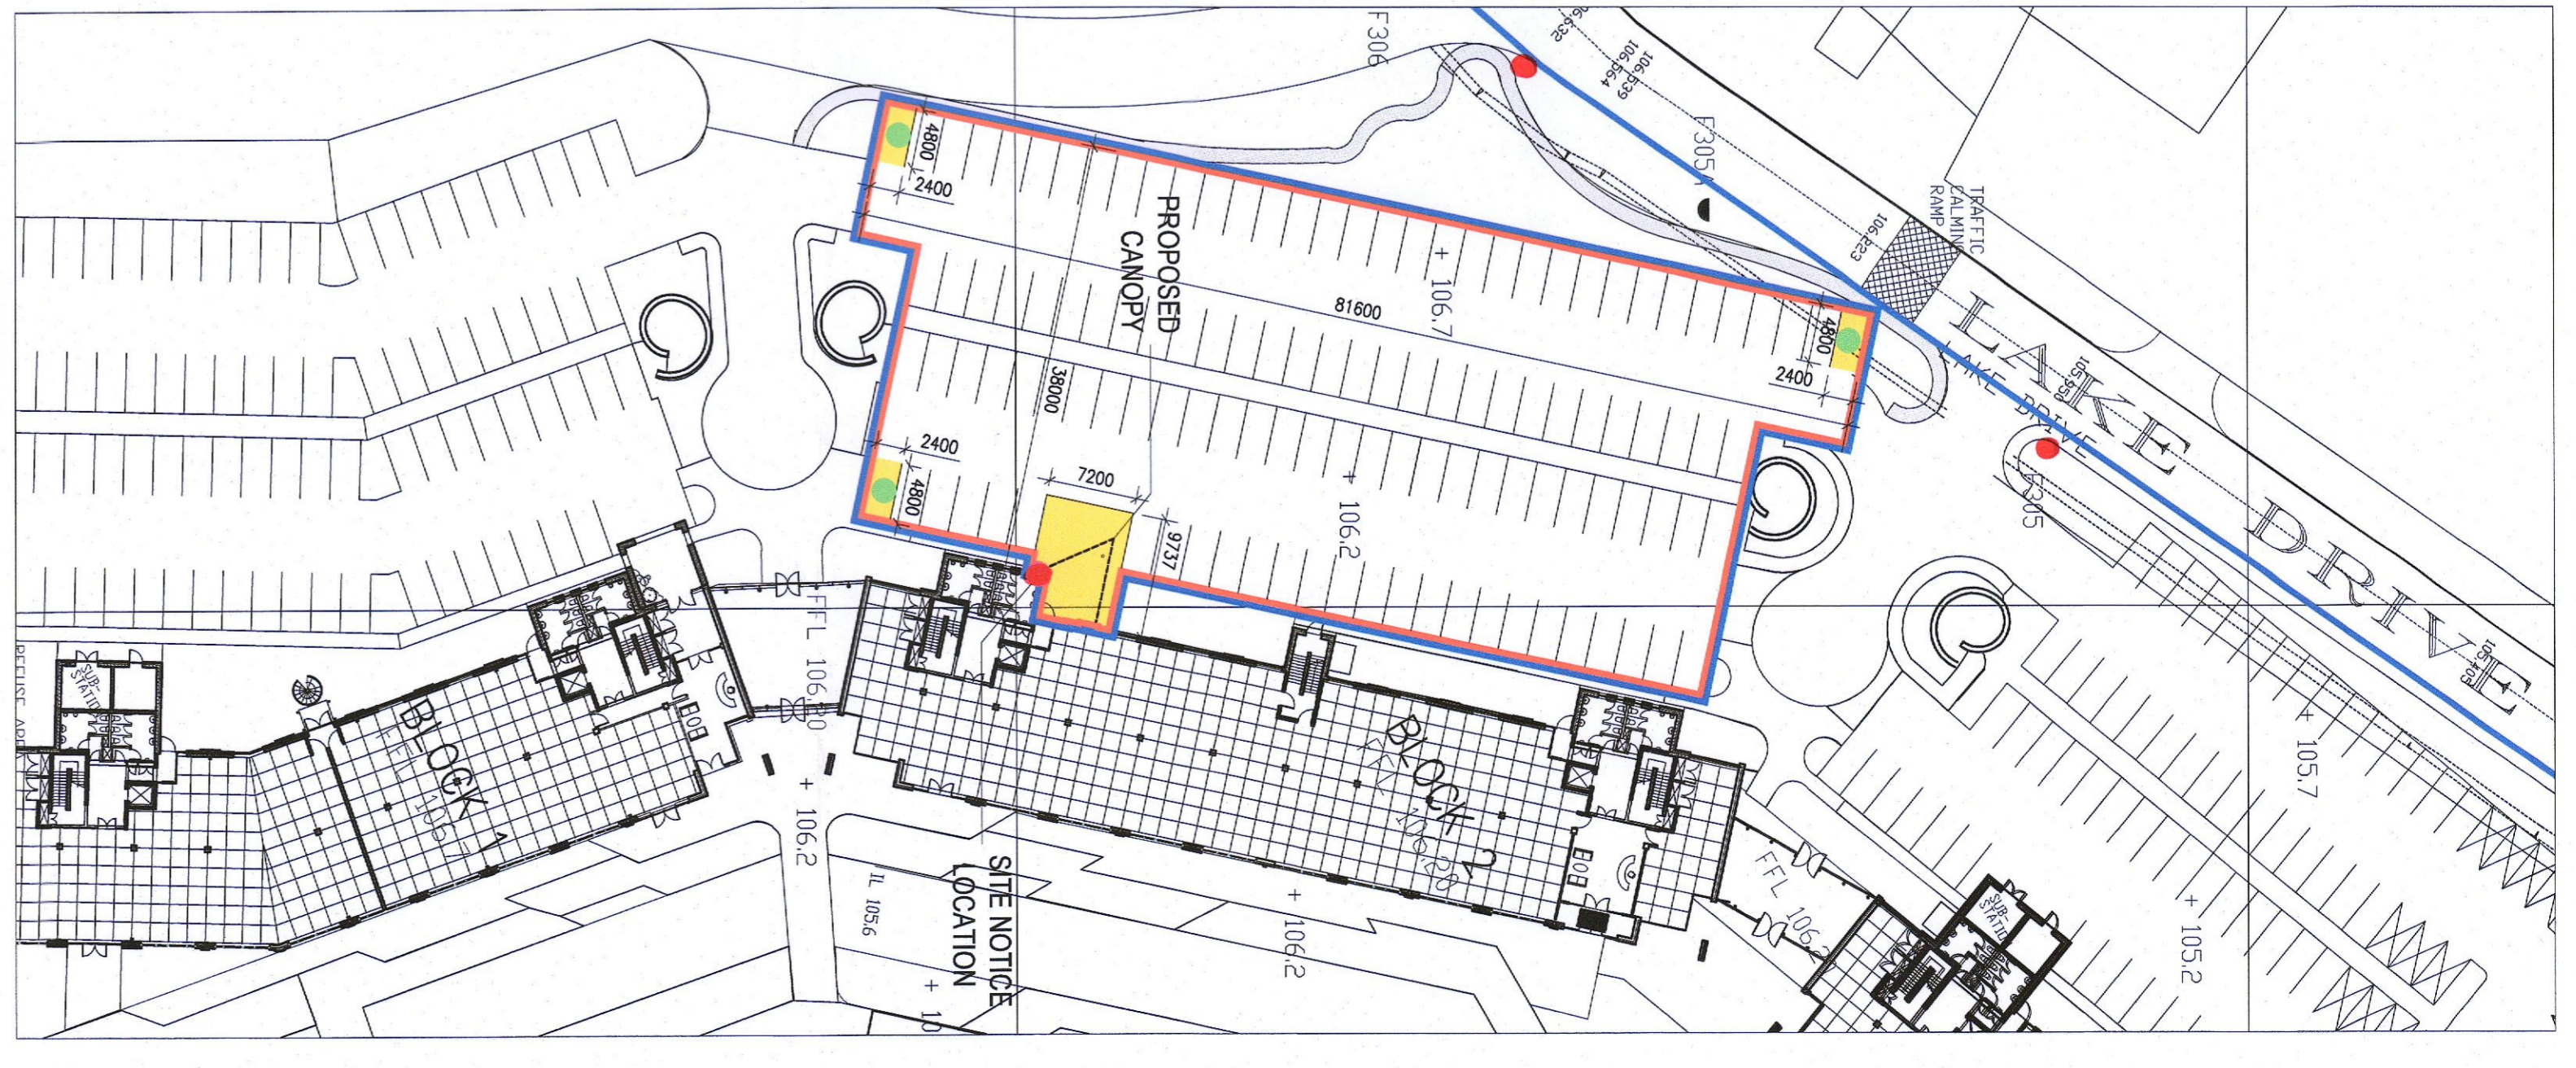

2 SITE LAYOUT PLAN
Scale: 1:500

- Legend**
- OUTLINE OF SITE BOUNDARY
 - OTHER LANDS IN APPLICANT'S INTEREST
 - PROPOSED DEVELOPMENT
 - 3NO. RELOCATED CAR PARK SPACES
 - SITE NOTICE LOCATIONS

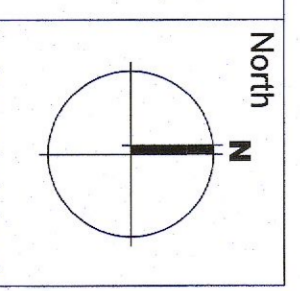

Ordinance Survey, Ireland
 Licence No. AR 074LS02535308
 Map Series:
 3389-02 3389-07 3389-A

- Notes**
1. Copyright Reserved
 2. The applicant is responsible for providing all necessary information on site and shall under all circumstances to the architect
 3. The architect is responsible for checking all drawings and documents on site and shall under all circumstances to the architect
 4. Where appropriate, for details of e. structure, or mechanical and electrical details, see Erection drawings
 5. Proprietary items shall be fixed in accordance with manufacturer's instructions
 6. Site preparation items shall be checked with manufacturer
 7. The architect shall be responsible for the coordination of services, fixtures and services.

Issue Status	Revision	Date	By
Planning Application	PT	27/06/22	REVISION FOR PERMITS
Fire Cert			
Disability Cert			
Construction			
AS BUILT			
Information Only			

Project: **BLOCK 2 ENTRANCE CANOPY RIVERWALK CITYWEST**

Client: **VARIES**

Scale: **VARIES**

Drawn by: **50794-200**

Checked by: **PI**

Design: **KF**

Date: **07/06/22**

9-7 MANOON TERRACE, DUBLIN 5, IRELAND
 T: +353 1 918 2400
 www.bkd.com

bkd architects
 BURKE KENNEDY BOYLE