




ANCILLARY OFFICES - GROUND FLOOR PLAN
SCALE 1:100

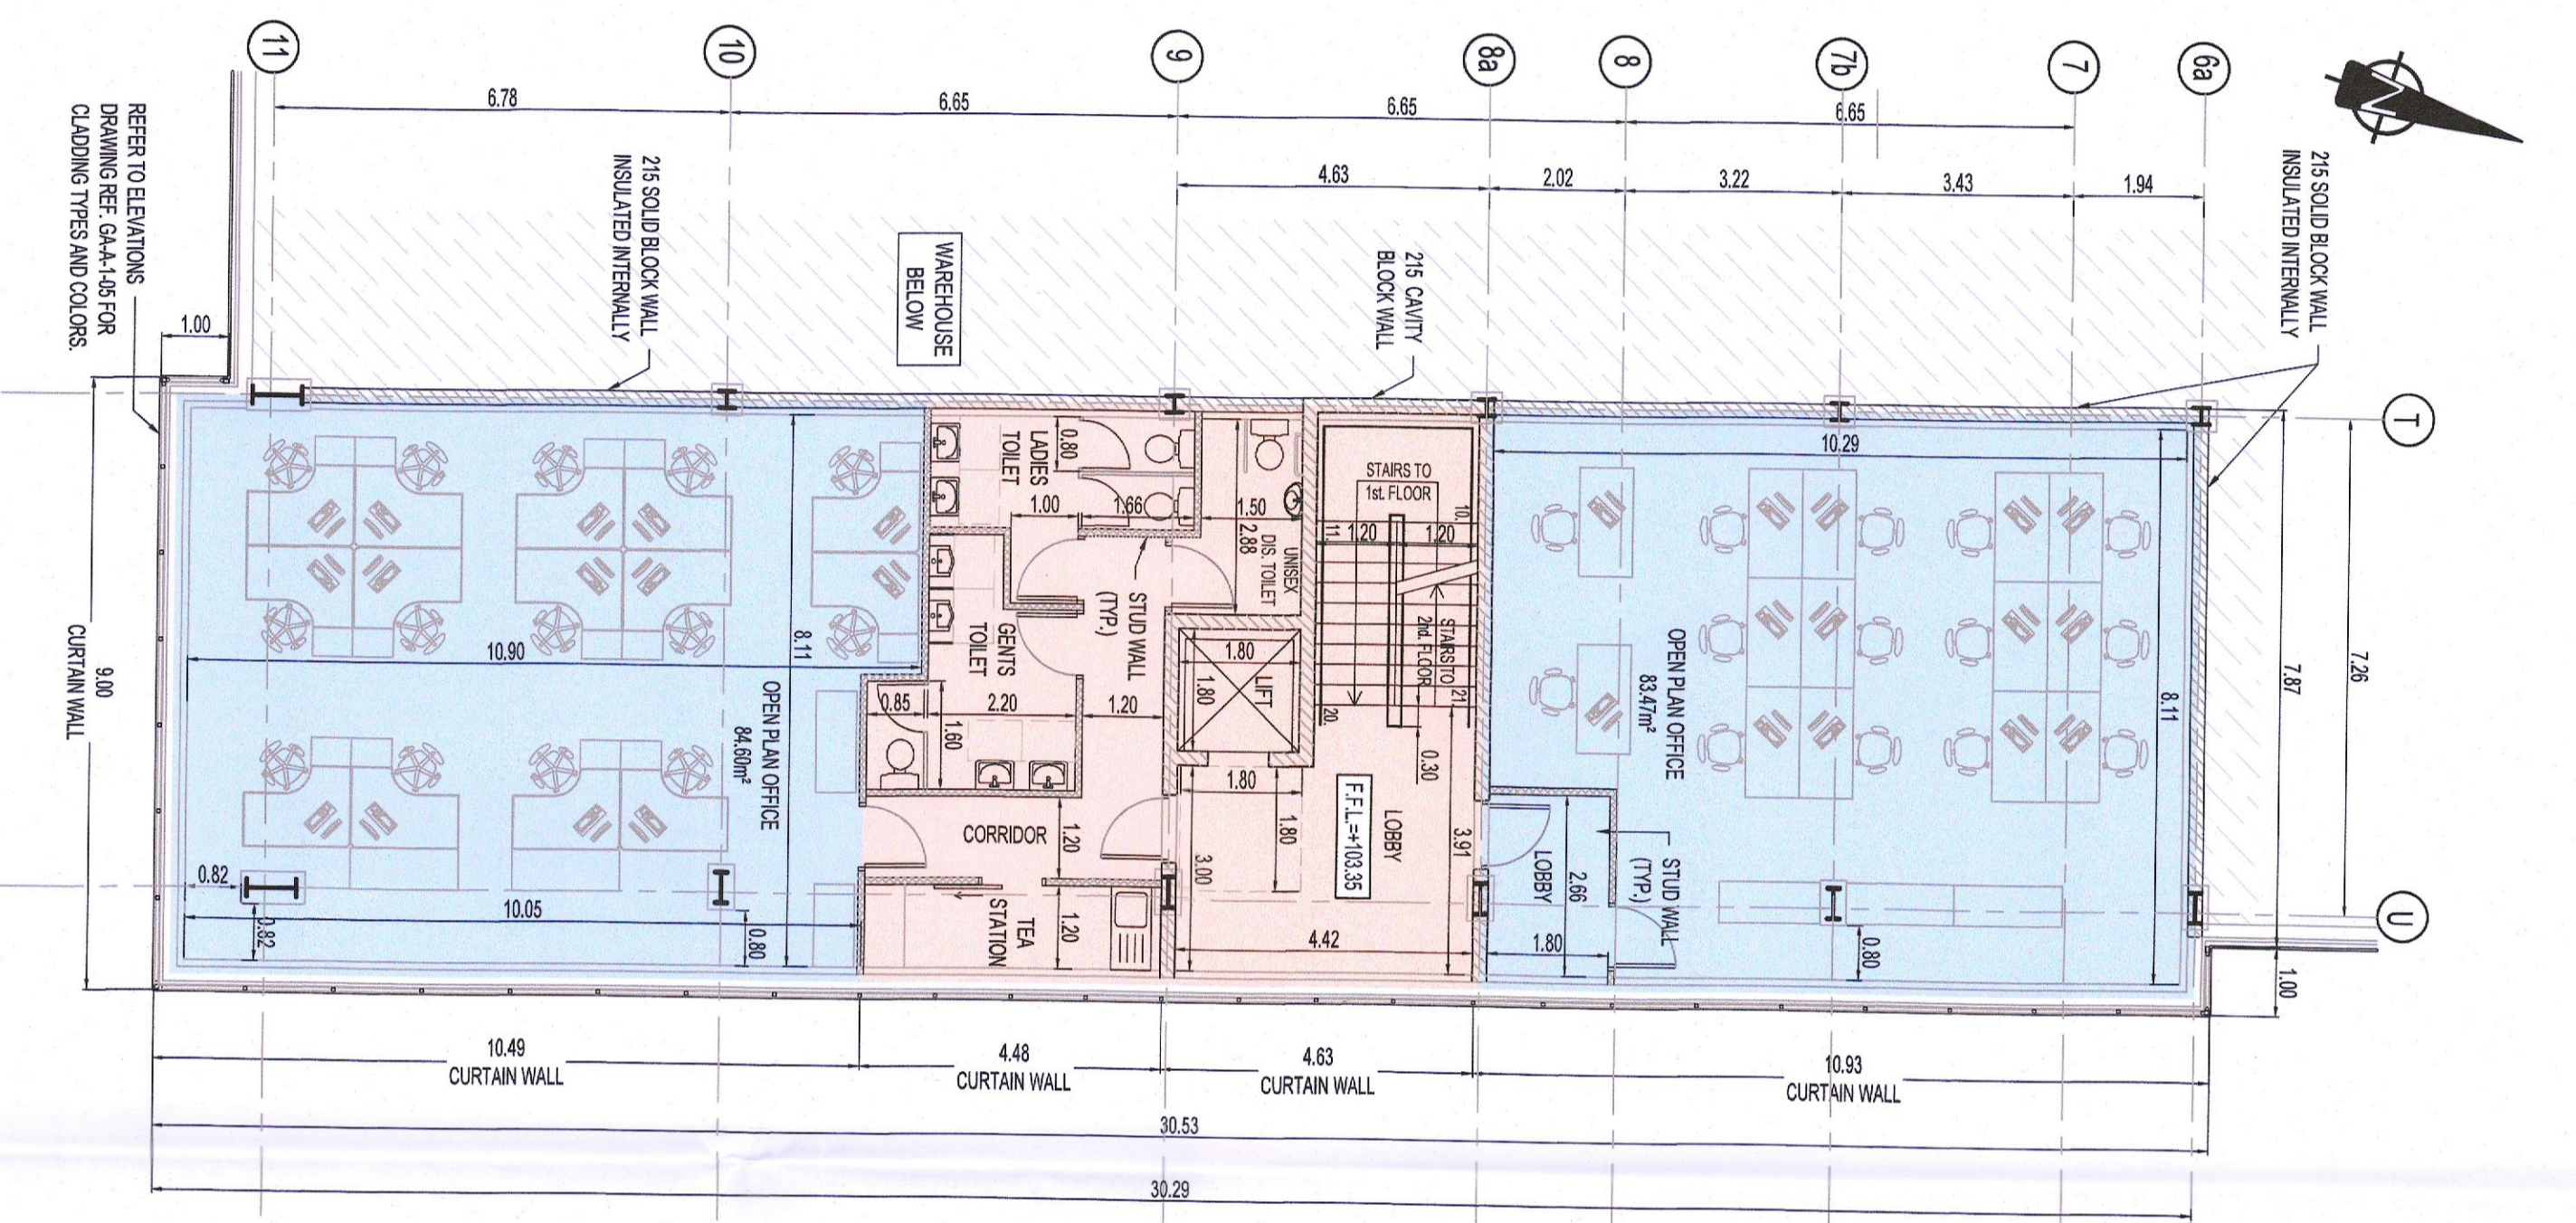

ANCILLARY OFFICES - FIRST FLOOR PLAN
SCALE 1:100

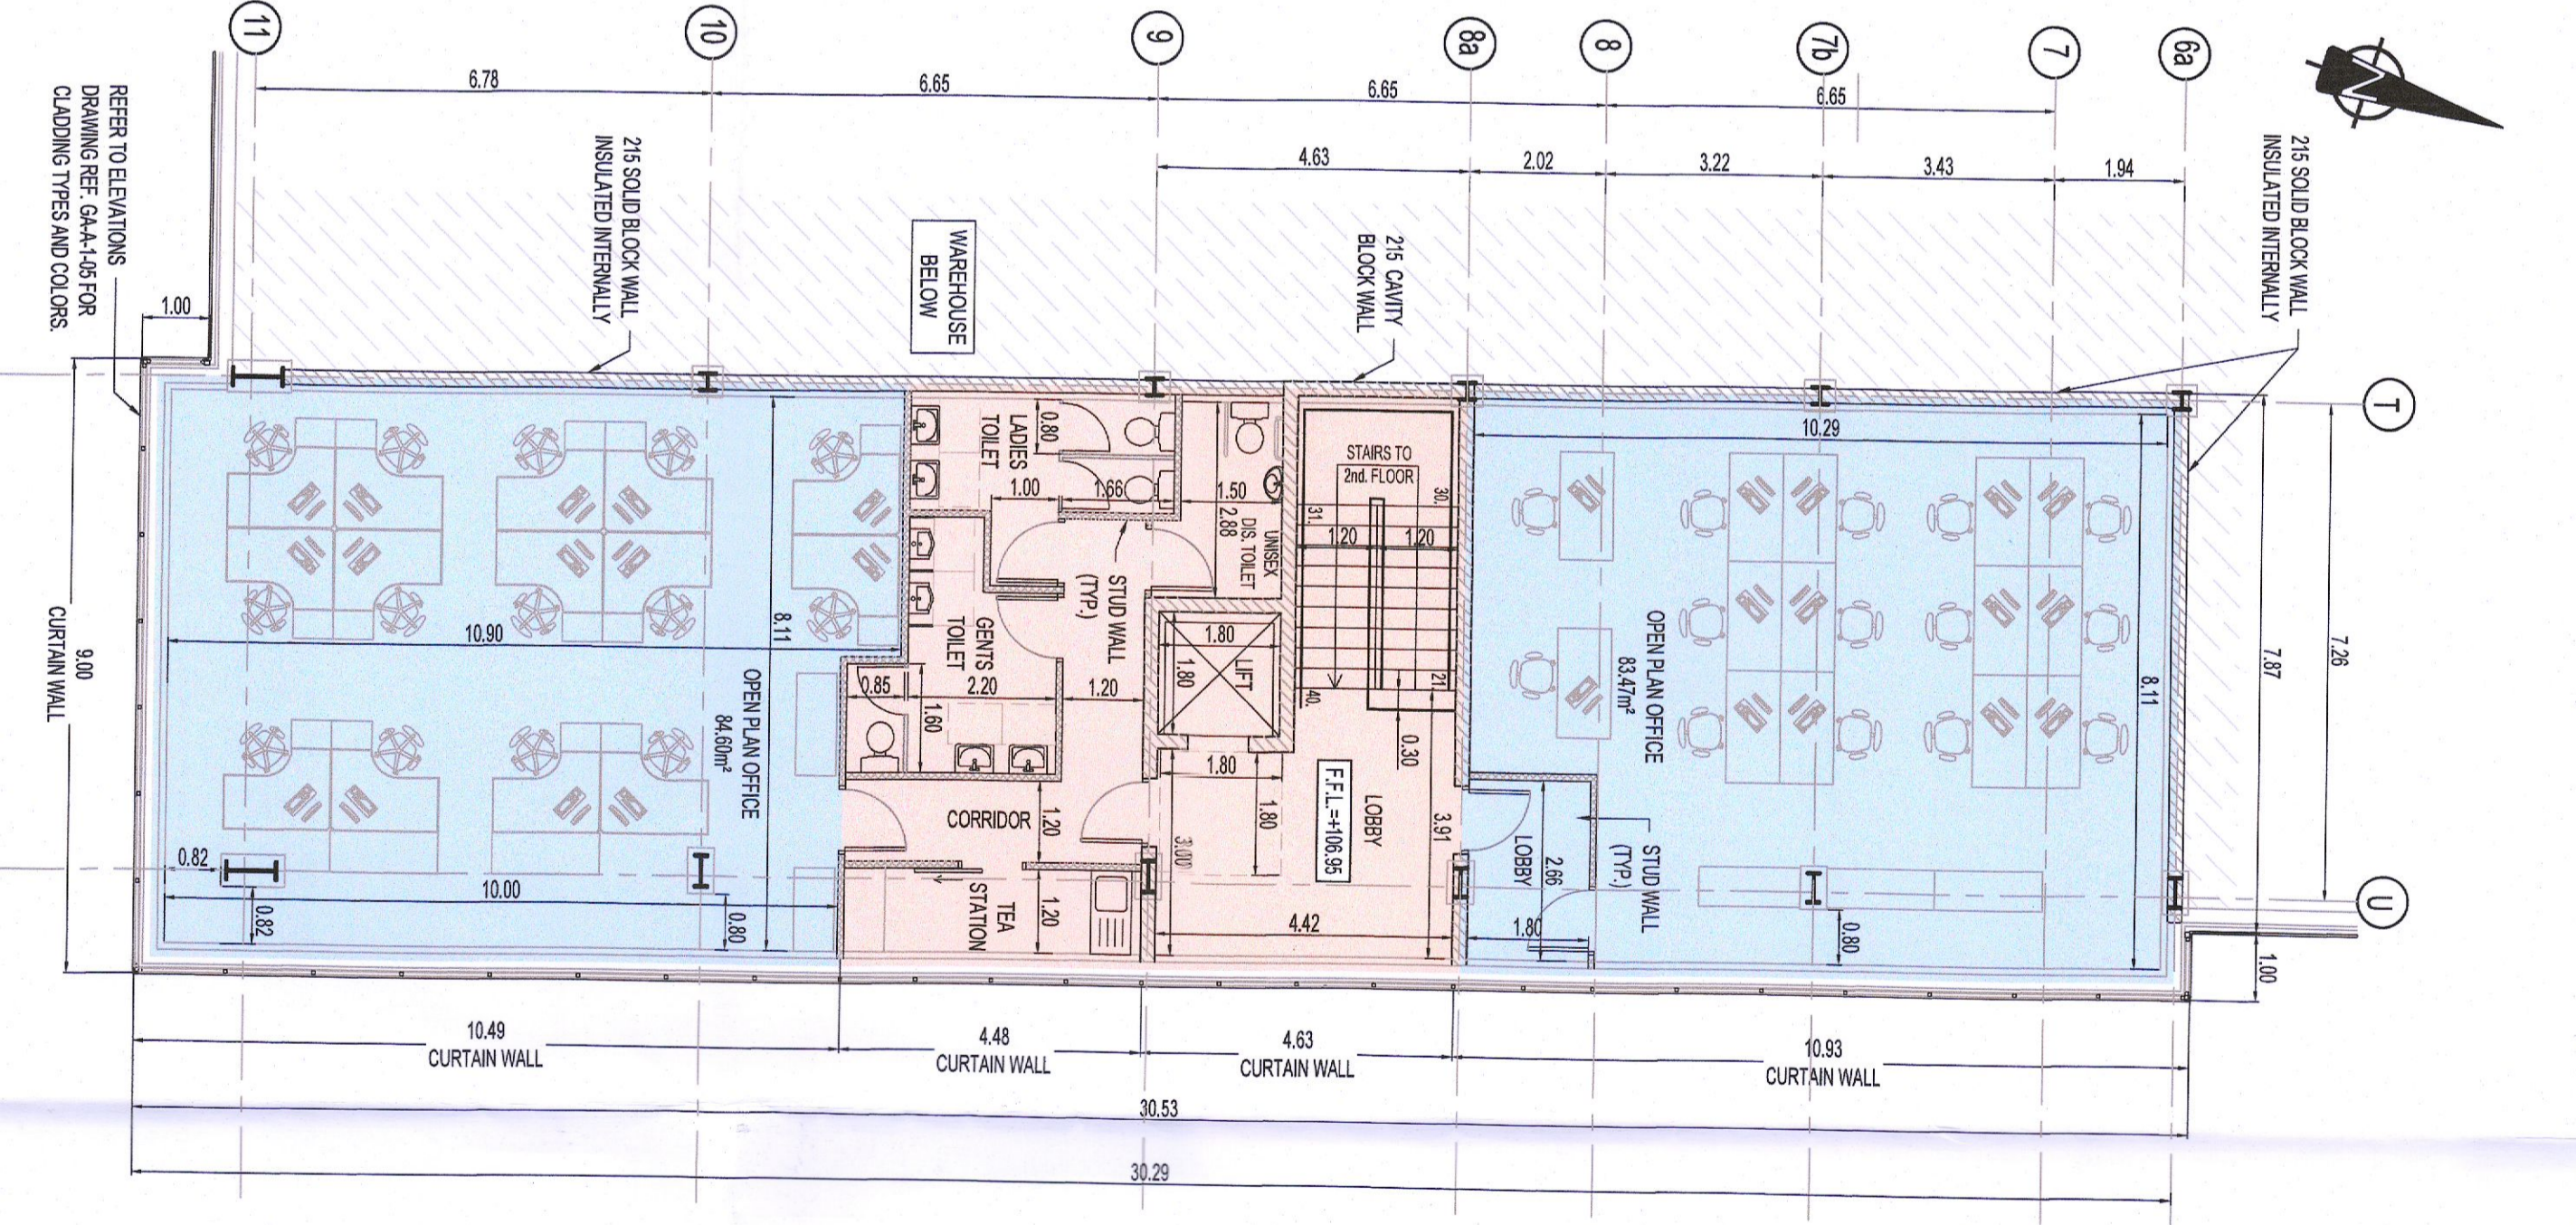

ANCILLARY OFFICES - SECOND FLOOR PLAN
SCALE 1:100

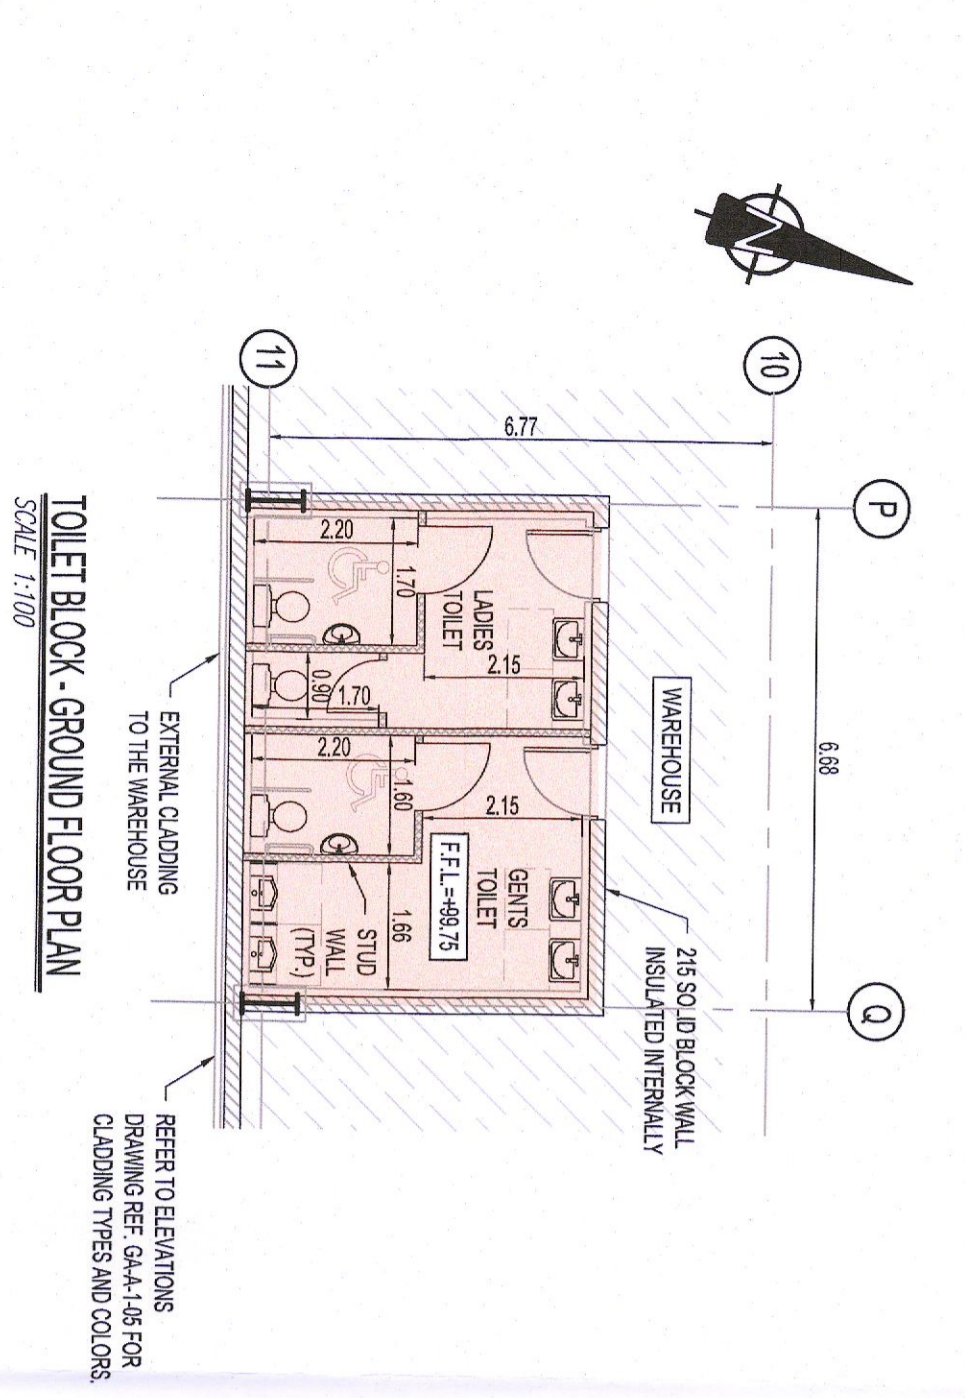


TOILET BLOCK - GROUND FLOOR PLAN
SCALE 1:100



WAREHOUSE - GROUND FLOOR PLAN
SCALE 1:100



WAREHOUSE - FIRST FLOOR PLAN
SCALE 1:100

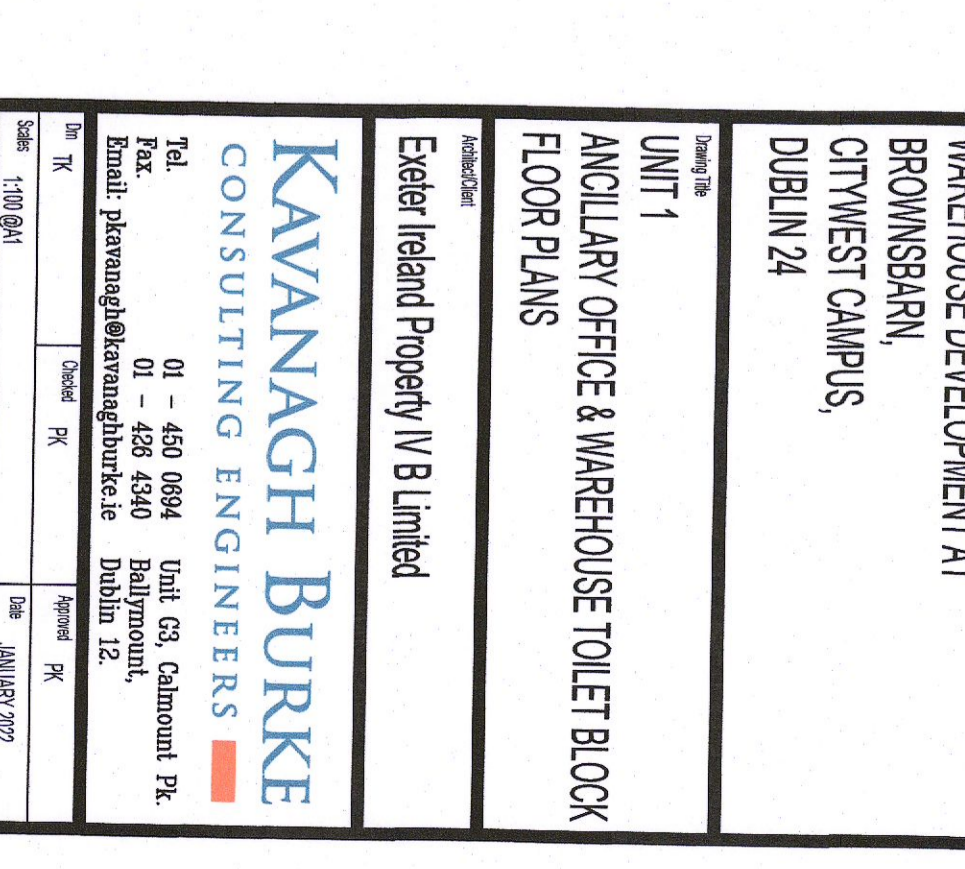

KEY PLAN
SCALE 1:1750

- NOTES:**
1. THIS DRAWING IS TO BE READ IN CONJUNCTION WITH ALL OTHER RELEVANT DRAWINGS & SPECIFICATIONS.
 2. DO NOT SCALE. USE FIGURED DIMENSIONS ONLY.

| Rev | Date | By | CHK | APP | Desc |
|-----|------------|-----|-----|-----|---------------------------------------|
| P.3 | 24/01/2021 | TK | PK | PK | ISSUED FOR PLANNING APPROVAL REVISION |
| P.2 | 04/08/2020 | SKB | SB | PK | ISSUED FOR DRAWINGS |
| 1st | 1st | 1st | 1st | 1st | 1st |

PLANNING A1
WAREHOUSE DEVELOPMENT AT
BROWNSBAR, CITYWEST CAMPUS,
DUBLIN 24

UNIT 1
ANCILLARY OFFICE & WAREHOUSE TOILET BLOCK
FLOOR PLANS

Exeter Ireland Property IV B Limited

KAVANAGH BURKE
CONSULTING ENGINEERS
01 - 450 0894 Unit C3, Cabmount Pk.
01 - 455 4340 Ballymount, Dublin 12.
Email: pav@kavanaghburke.ie

Drawn: TK
Checked: PK
Date: JANUARY 2021
Scale: 1:100 @A1
Drawing No: D1678
Revision: GA-A-104
Sheet: P.3

PERMITTED DRAWING
(PROVIDED FOR RECORD PURPOSES ONLY)
SDCC GRANTED PLANNING REGISTER
REFERENCE No. SD21A0162