


Planning Pack Map

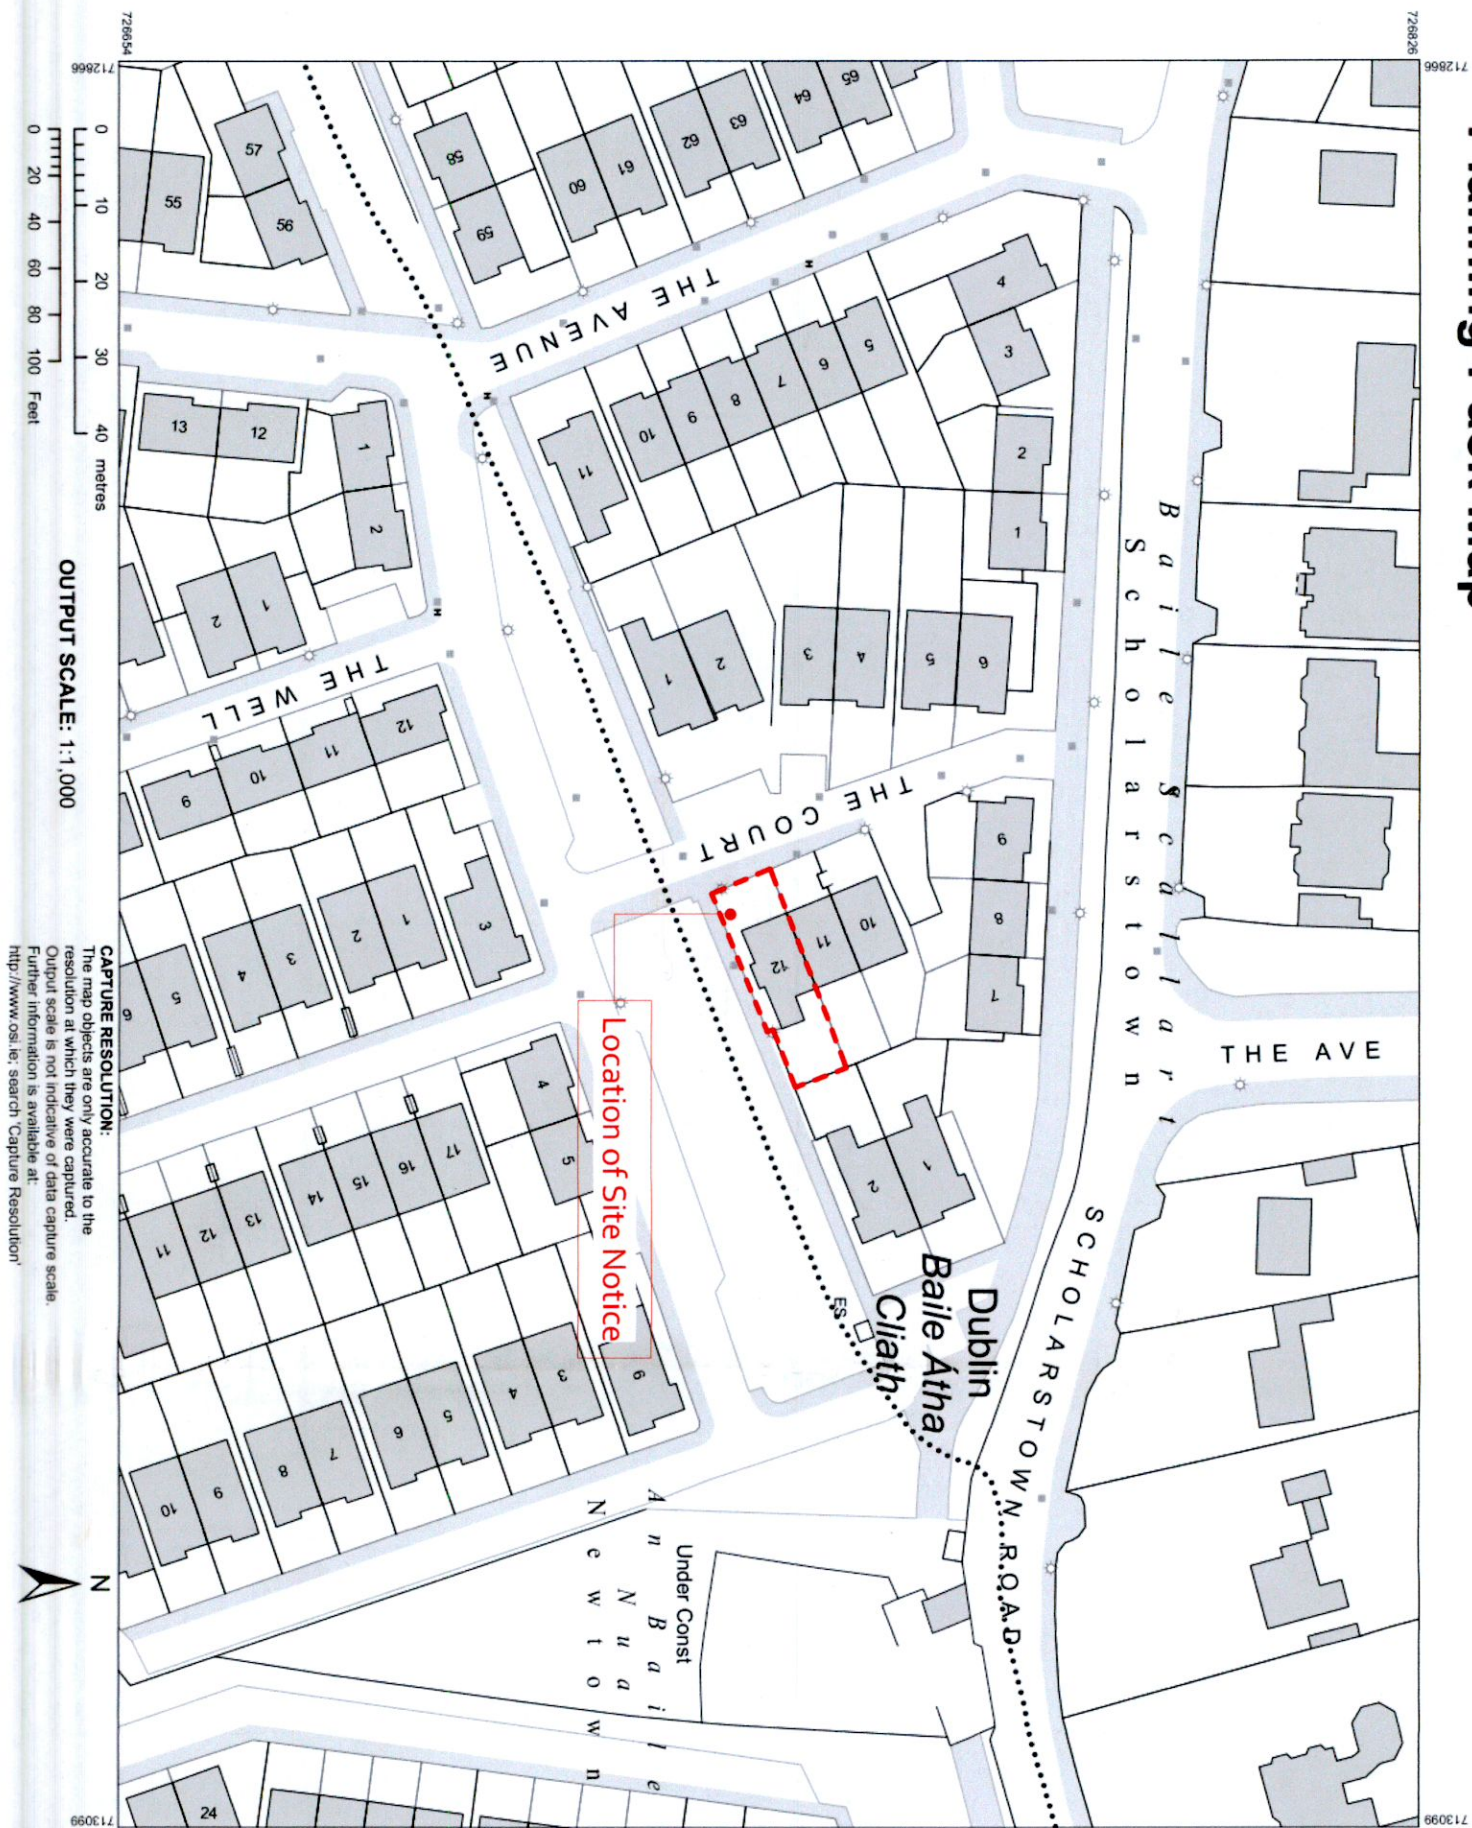

CAPTURE RESOLUTION:
The map objects are only accurate to the resolution at which they were captured. Output scale is not indicative of data capture scale. Further information is available at: <http://www.osi.ie/search/CaptureResolution>

LEGEND:
<http://www.osi.ie/search/LargeScaleLegend>



CENTRE COORDINATES:
ITM 712983,726740
PUBLISHED: 30/05/2022
MAP SERIES: 1:1,000

ORDER NO.: 50271258_1
MAP SHEETS: 3391-17

COMPILED AND PUBLISHED BY:
Ordnance Survey Ireland,
Phoenix Park,
Dublin 8,
Ireland.

Unauthorised reproduction infringes Ordnance Survey Ireland and Government of Ireland copyright.

All rights reserved. No part of this publication may be copied, reproduced or transmitted in any form or by any means without the prior written permission of the copyright owners.

The representation on this map of a road, track or footpath is not evidence of the existence of a right of way.

Ordnance Survey maps never show legal property boundaries, nor do they show ownership of physical features.

© Suirbhíreacht Ordnáis Éireann, 2022
© Ordnance Survey Ireland, 2022
www.osi.ie/copyright

PLANNING DRAWING

Drawings prepared for statutory approval only. Not to be used for Pricing or as a Construction Drawing.

Project Name:	12 The Court	Drawn by:	BOX
Drawing Title:	OS MAP		
Scale:	Date:	Drg No.:	
	20.04.2020	21010 -P-050	
Top floor, 2 Wexford Street, Do2 XA02, D 2, Ireland.			
T: +353 (0) 1 47 888 39 E: info@box.ie W: www.box.ie			

Revision Schedule

No.	Date	Description
-----	------	-------------

- NOTE**
1. Copyright Reserved.
 2. Do not scale off this drawing use figured dimensions only.
 3. The contractor is to check all dimensions and levels on site.
 4. Where appropriate, for R.C. structure, or mechanical and electrical details refer to Engineers drawings.
 5. Proprietary items to be fixed in strict accordance with manufacturers instructions and recommendations.
 6. The contractor shall be responsible for the co-ordination of structure and services.
 7. The contractor shall be responsible for ensuring that all work complies with the current Building Regulations.