


© No dimensions to be scaled from this drawing. All dimensions to be checked by the contractor on site, any errors or discrepancies to be reported to the Architects.



01
P902 PROPOSED VIEW FROM PLAYING PITCH
SCALE: NTS

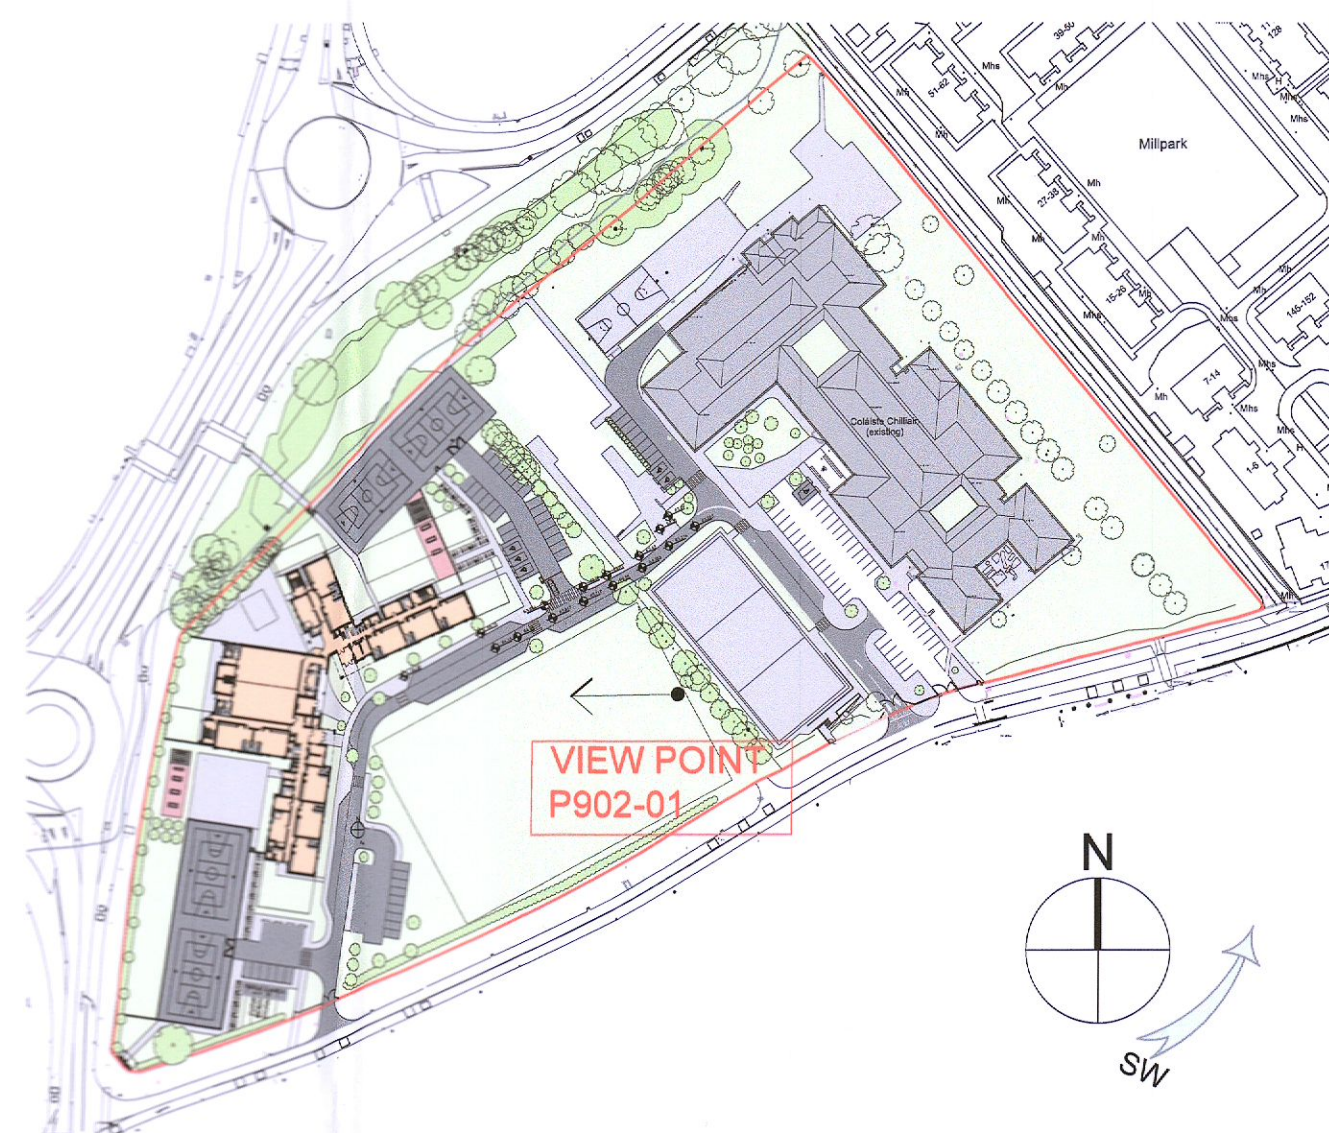

02
P902 SITE PLAN SHOWING CAMERA POSITION
SCALE: 1:2000

DRAWING STATUS: PLANNING APPLICATION

NEWENHAM MULLIGAN & ASSOCIATES	job	Gaelscoil na Camóige agus Gaelscoil Chluain Dolcáin	date	FEB 2017
	client	Dublin+Dún Laoghaire Education+Training Board	drawn	CR
ARCHITECTS 11/12 BAGGOT COURT, DUBLIN 2 * TELEPHONE 01 6767400 * FACSIMILE 01 6767280 * E-MAIL info@nma.ie	description	PROPOSED VIEW FROM PLAYING PITCH	scale	NTS
			checked	MGNW
			job no.	7234 - CLON
			dwg. no.	P902
			rev.	

Location p:\7234\7234 2d clondalkin\03 planning\7234-clon-p902-3d view to school from playing pitch.dwg