


PROPOSED GROUND FLOOR PLAN WITH DRAINAGE LAYOUT

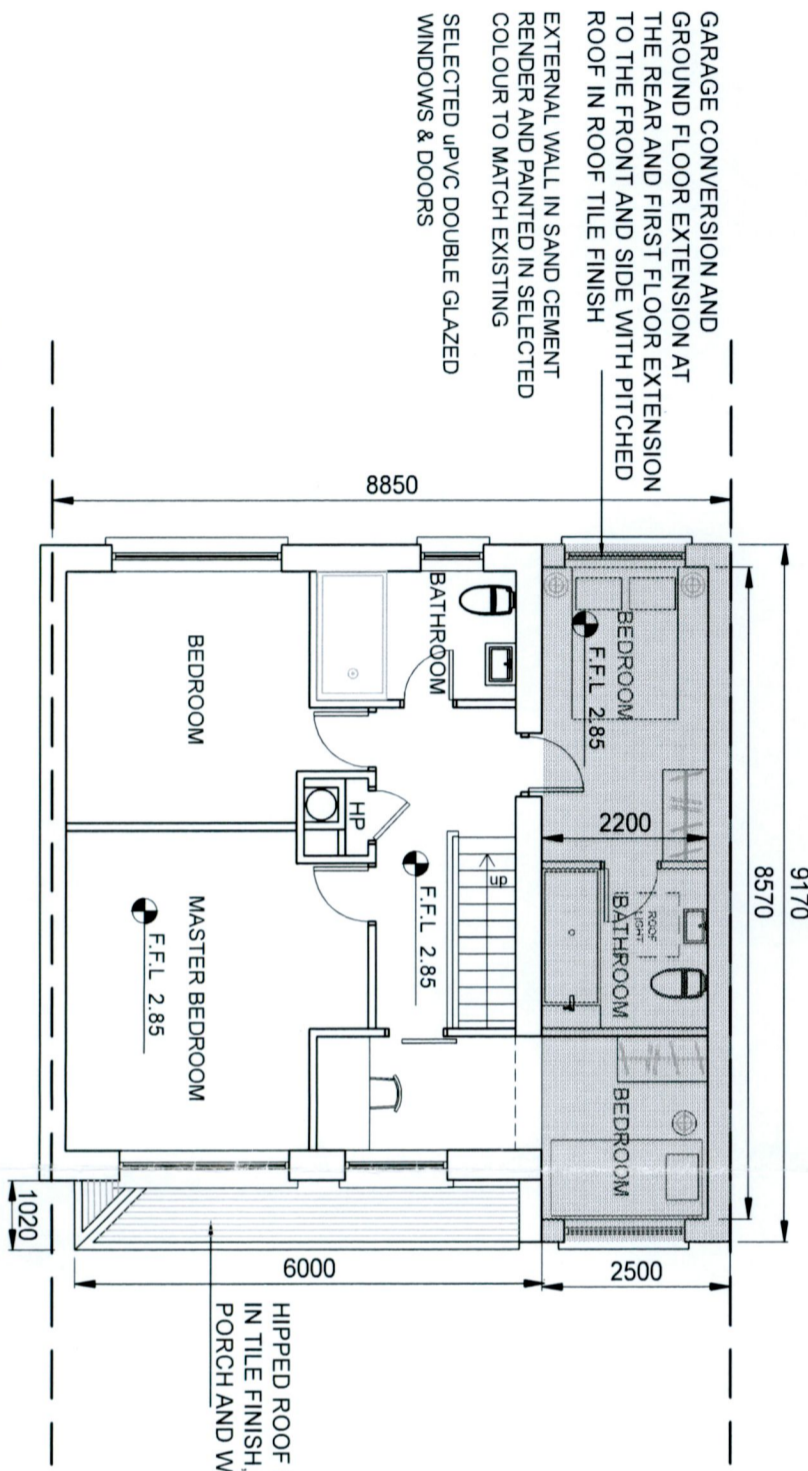


PROPOSED FIRST FLOOR PLAN

PLANNING

drawings prepared by: Ling Kwok
 address: 1, St. Attracta Road, Dublin 7
 contact no.: 01 5212589
 email: beslerdesigngroup@gmail.com

rev	note	date	initial	notes	stage	date	drawn by	checked by	revision	drawing number
					PLANNING	07.08.2022	LK			2213-PL-FP-01

client: ANTHONY BRODERICK & STEPHANIE JAMES-BRODERICK
 project title: DEVELOPMENT AT 38, OLD BAWN PARK, TALLAGHT
 drawing title: PROPOSED FLOOR PLANS WITH DRAINAGE LAYOUT

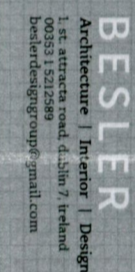

scale: 1:100@A3
 checked by: name
 revision: -