


**PATRICK JOYCE ASSOCIATES**  
CONSULTING ENGINEERS

2 Prospect Grove  
Stacking Lane  
RathFarnham  
Dublin 16

Telephone: (01) 4946745  
Mobile: (087) 2476375  
E-Mail: patrick.joyceassociates@gmail.com

Soakaway: 7.80 m x 5.00 m Effective Depth: 1.00 m  
Soakaway shall be designed and constructed in accordance with BRE Digest 365

The entrance driveway shall be constructed using compacted crushed stone/ gravel

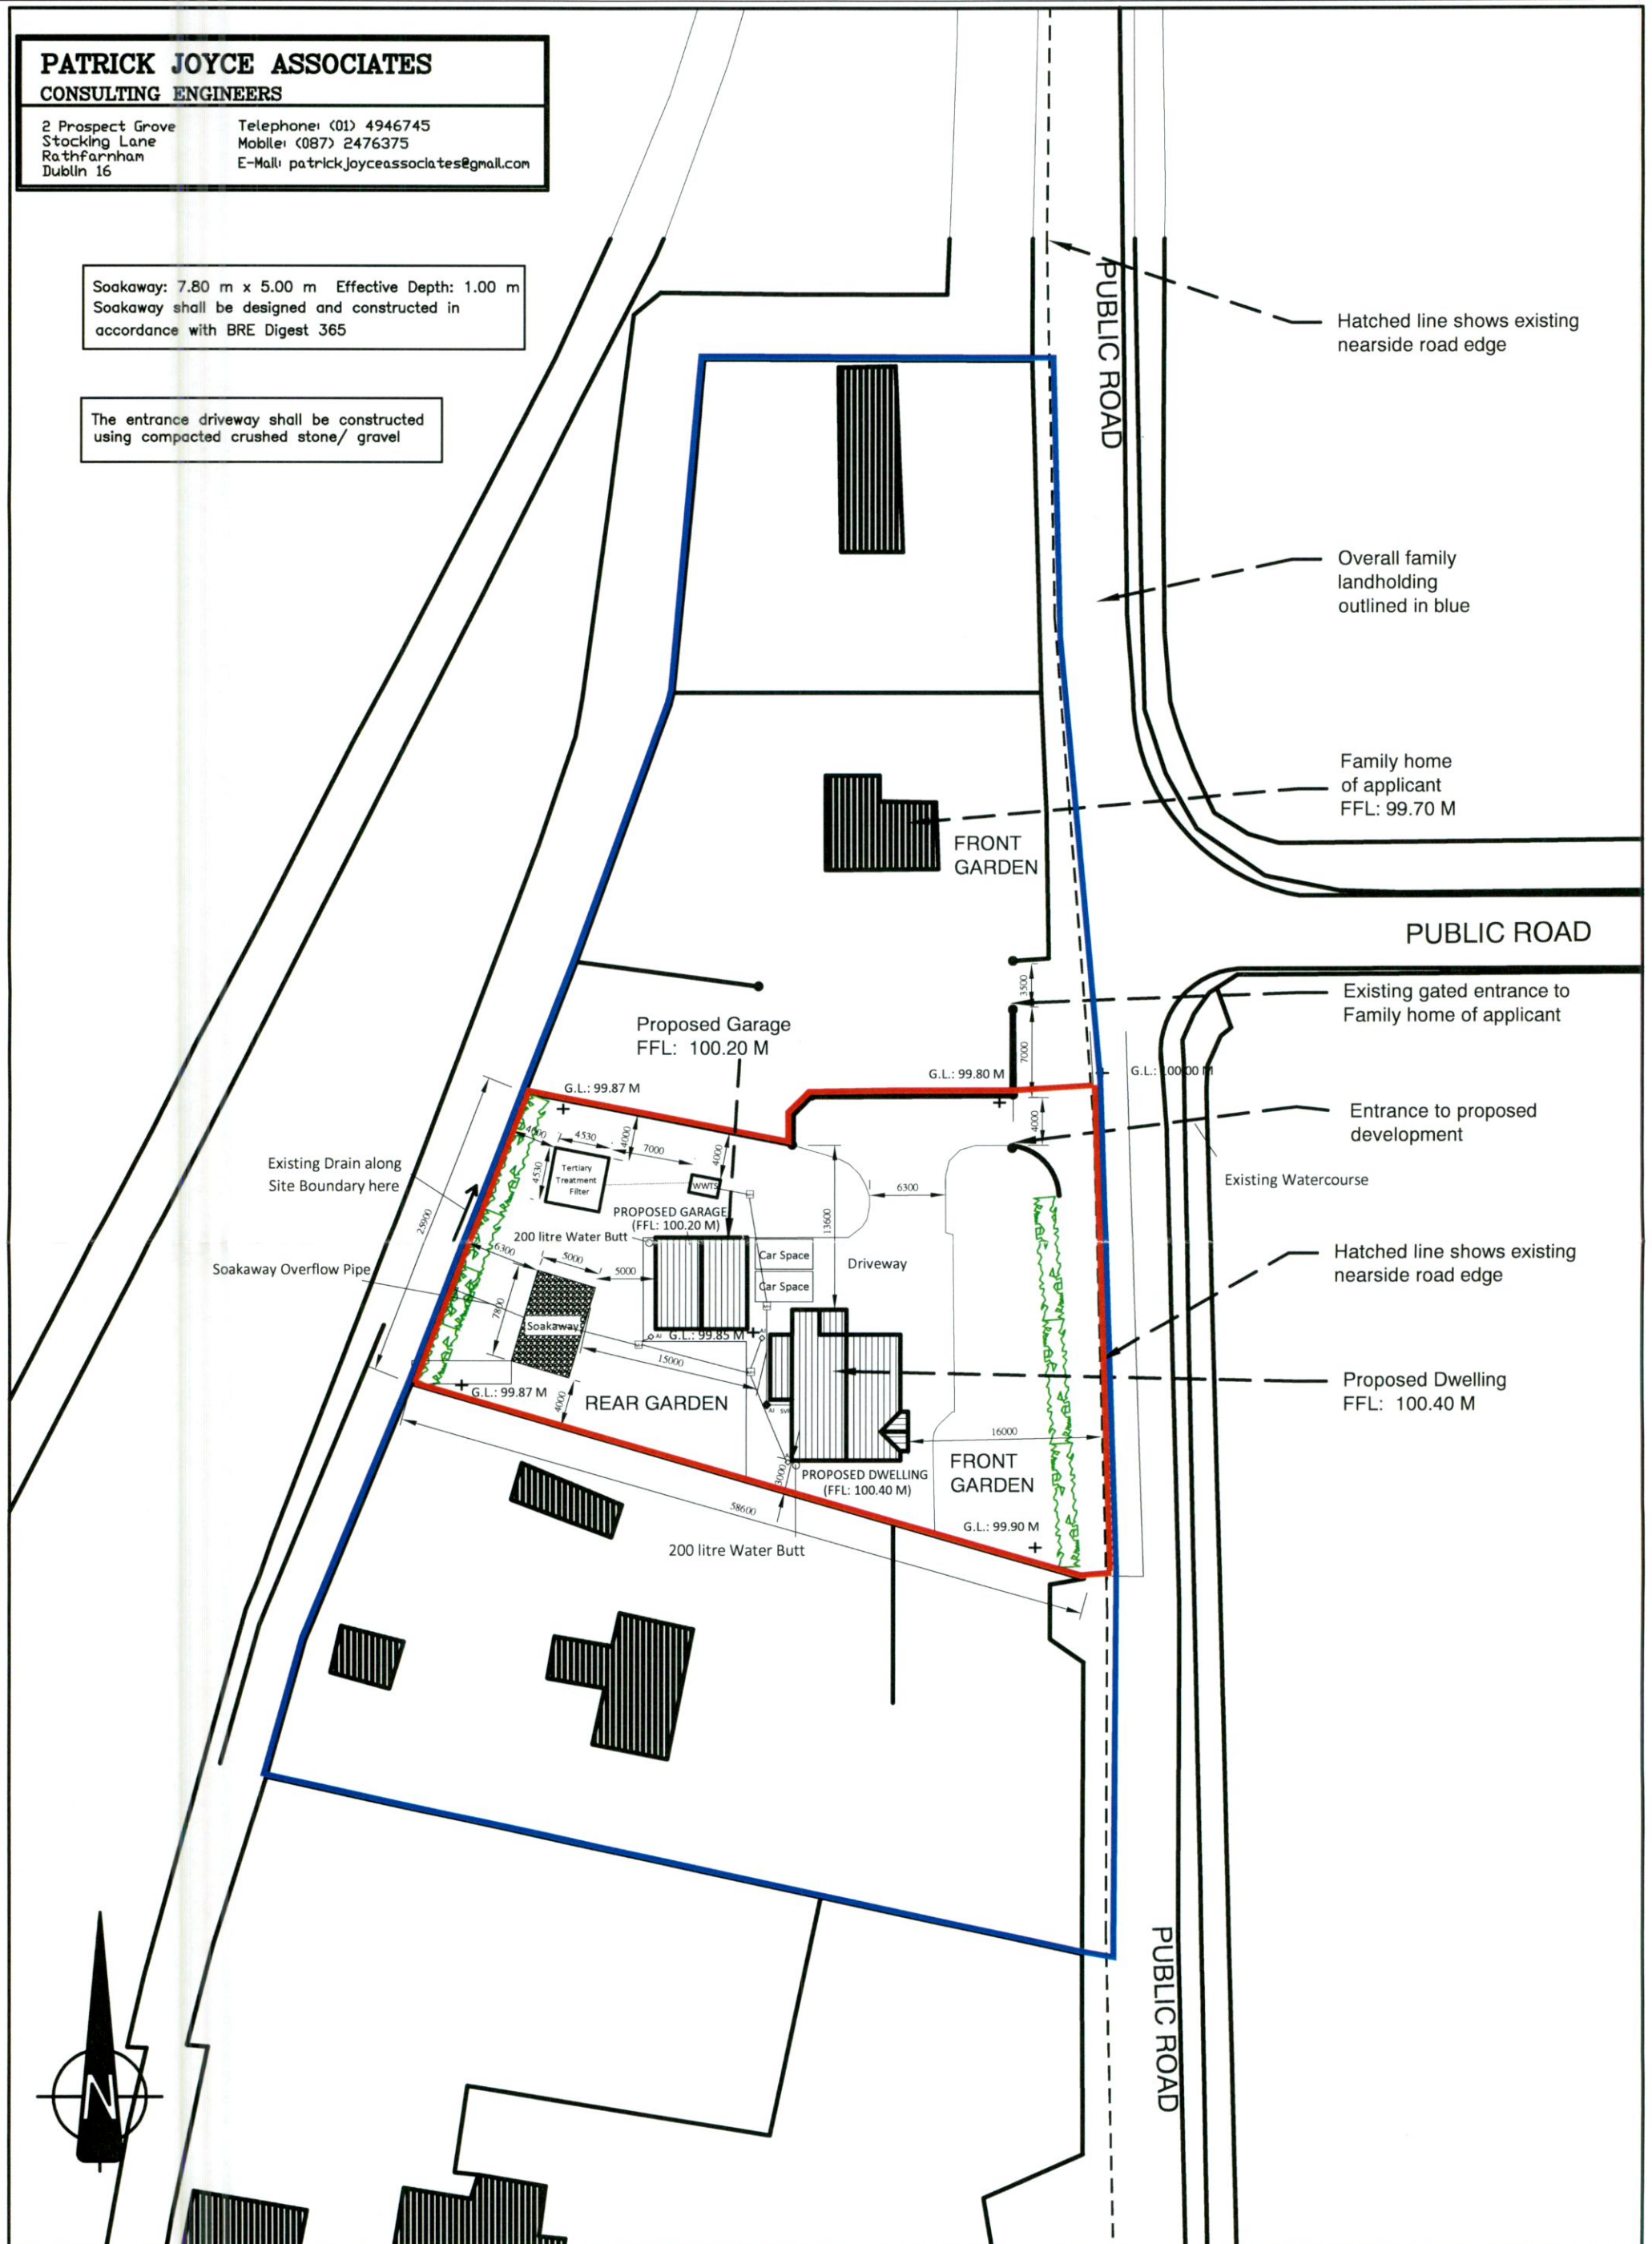

ISSUED FOR PLANNING APPLICATION PURPOSES ONLY

**MCGILLEN DESIGN SERVICES**  
PLANNING AND PROJECT MANAGEMENT

BURGAGE, T: (045) 891 468  
BLESSINGTON, M: (087) 646 9079  
CO. WICKLOW, E: petermcgillen@hotmail.com

**COPYRIGHT:**  
The design and details shown on this drawing are applicable to their project only and may not be reproduced in whole or in part or be used for any other project or purposes without the written permission of McGillen Design Services with whom copyright resides

**DO NOT SCALE FROM THIS DWG:**  
Use given dimensions. Contractor to check all dimensions on site prior to commencement of works. Any discrepancies are to be referred to the Site Architect/ Engineer.

<b>MCGILLEN DESIGN SERVICES, "BURGAGE", BLESSINGTON, CO. WICKLOW.</b>				
E-Mail: petermcgillen@hotmail.com		Phone: 045/ 891468		
<b>CLIENT:</b> David Fallon Baldonnell Upper Dublin 22	<b>PROJECT:</b> Proposed Development at Baldonnell Upper, Baldonnell Road Dublin 22	<b>DRAWING TITLE:</b> SITE DRAINAGE LAYOUT PLAN		
<b>PREPARED BY:</b> PMcG/PJ	<b>DATE:</b> 02/08/2021	<b>DWG NO:</b> PP008	<b>SCALE:</b> 1:500	<b>REVISION:</b> A
		<b>STATUS:</b> PLANNING		