




NOTES:
 THIS DRAWING IN WHOLE OR IN PART SHALL NOT BE COPIED WITHOUT THE PRIOR PERMISSION OF McARDLE DOYLE LTD.
 ALL WORKS TO COMPLY WITH THE CURRENT BUILDING REGULATIONS.
 DO NOT SCALE.
 ORDNANCE SURVEY IRELAND LICENCE No. AR 0105722
 © ORDNANCE SURVEY IRELAND / GOVERNMENT OF IRELAND

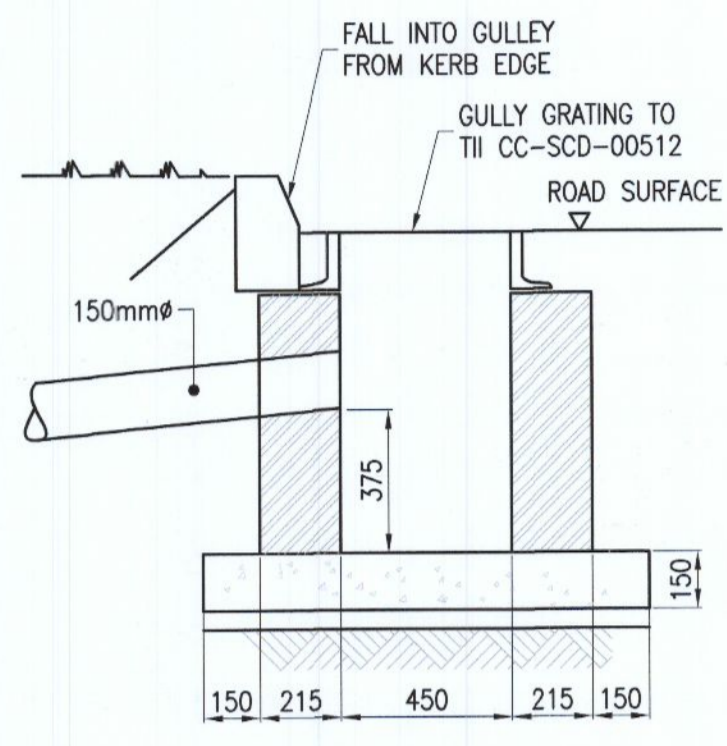


SECTION THROUGH ROAD INLET GULLY (TII CC-SCD-00511)
 SCALE 1:20

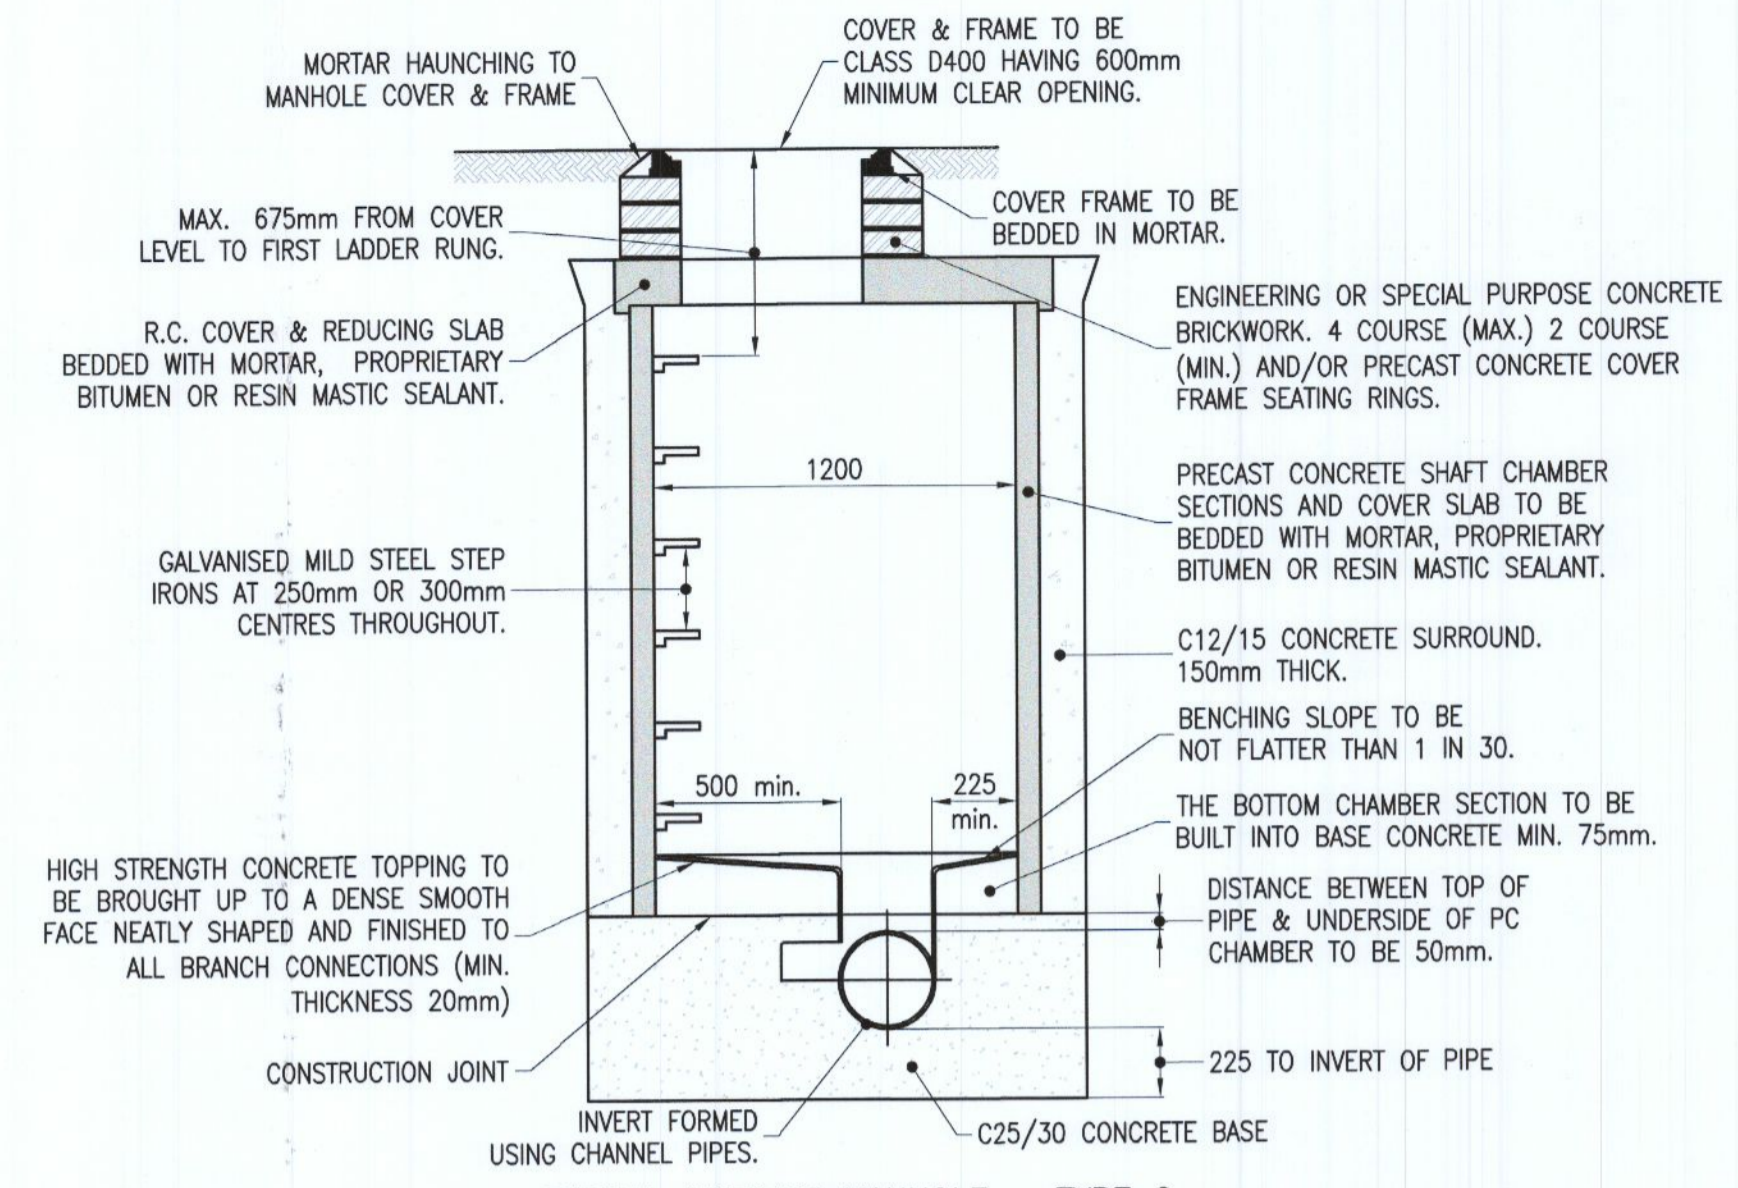


TYPICAL PRECAST MANHOLE - TYPE C (TII CC-SCD-00504)
 SCALE 1:25

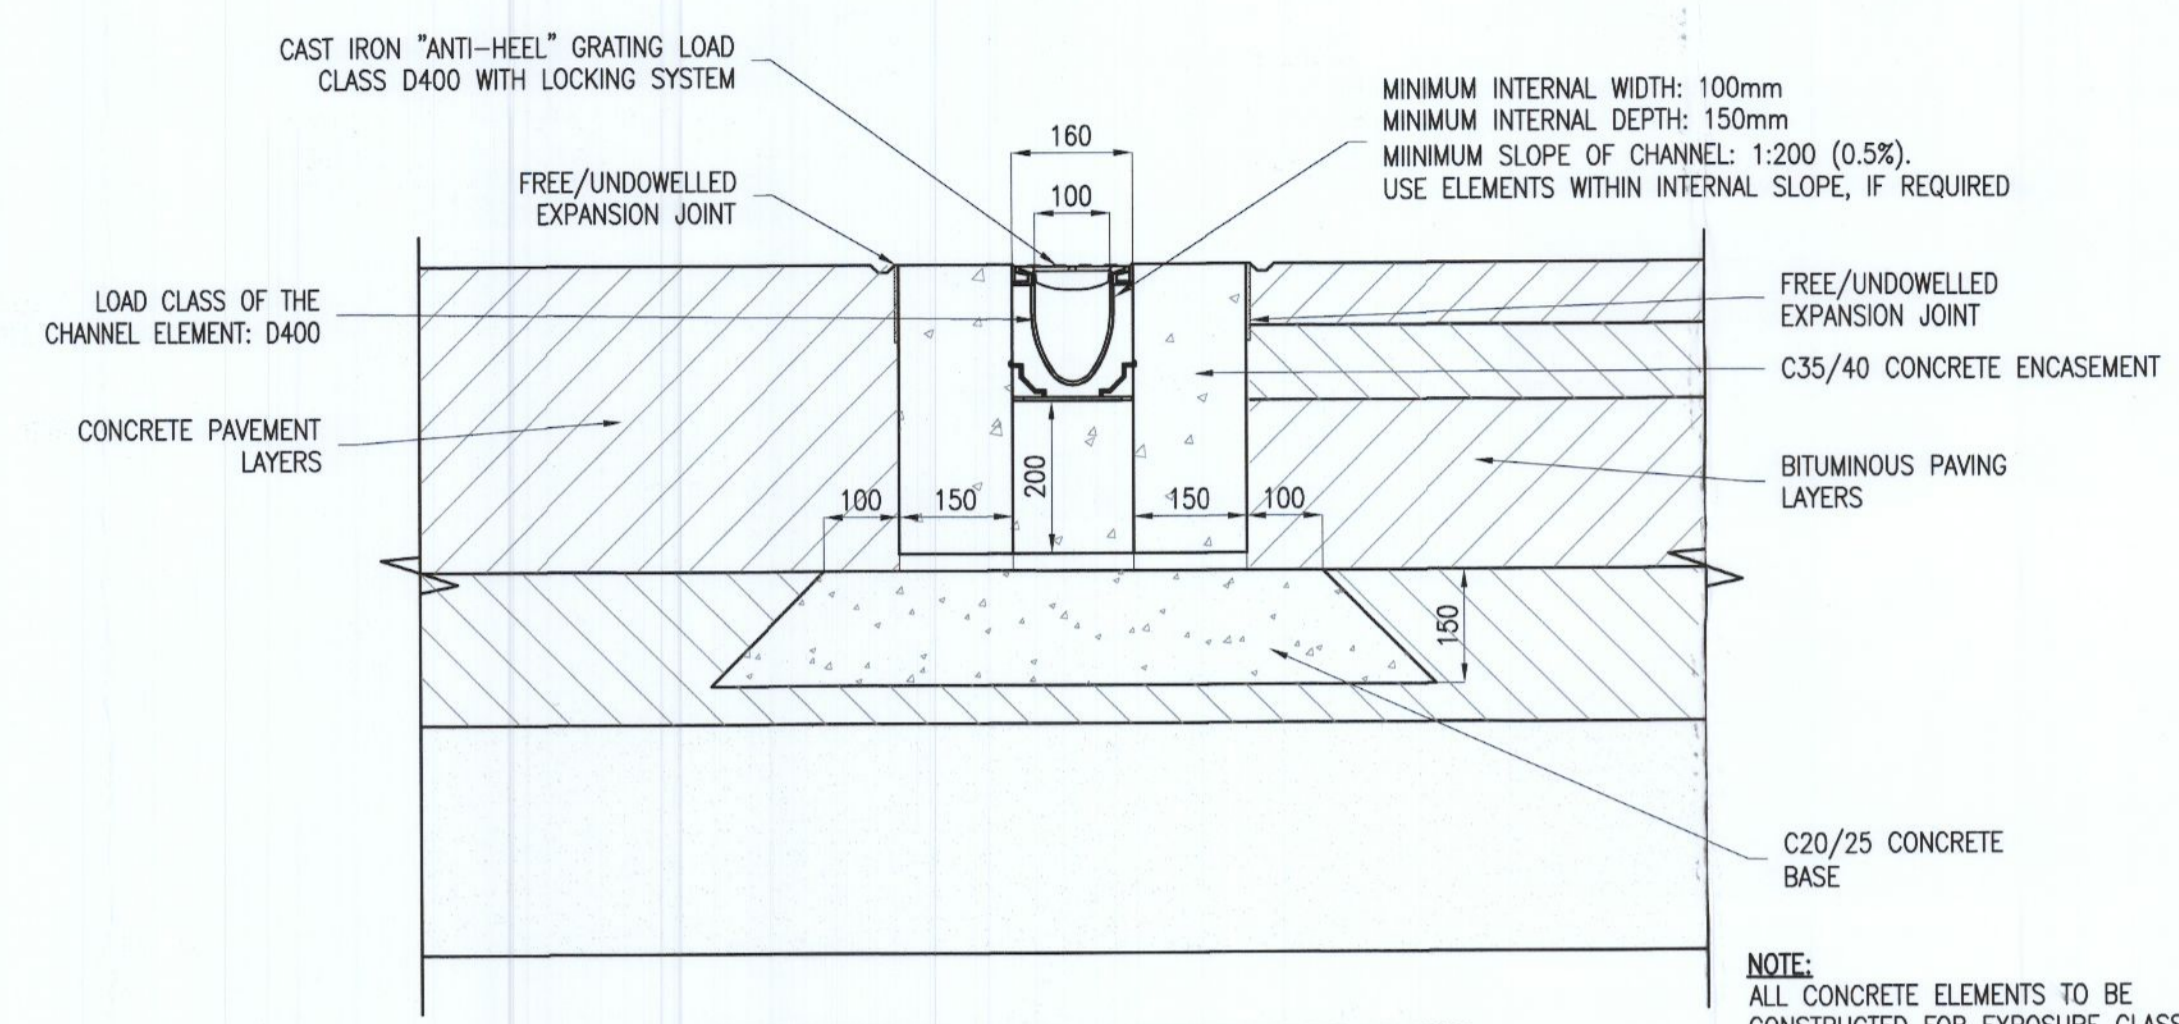


TYPICAL SECTION THROUGH FORECOURT LINEAR CHANNEL DRAIN (ACO DRAIN OR SIMILAR)
 SCALE 1:10

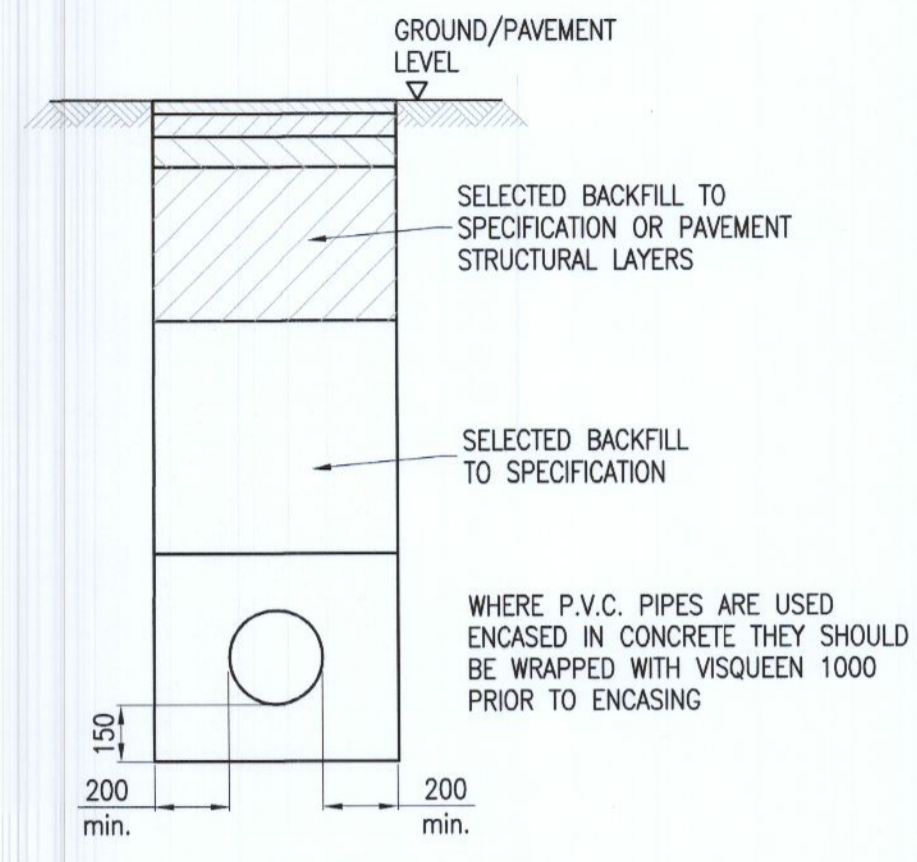


GRANULAR SURROUND DETAIL FOR SEWERS AND DRAINS (TII CC-SCD-00521-TYPE S)
 SCALE 1:20

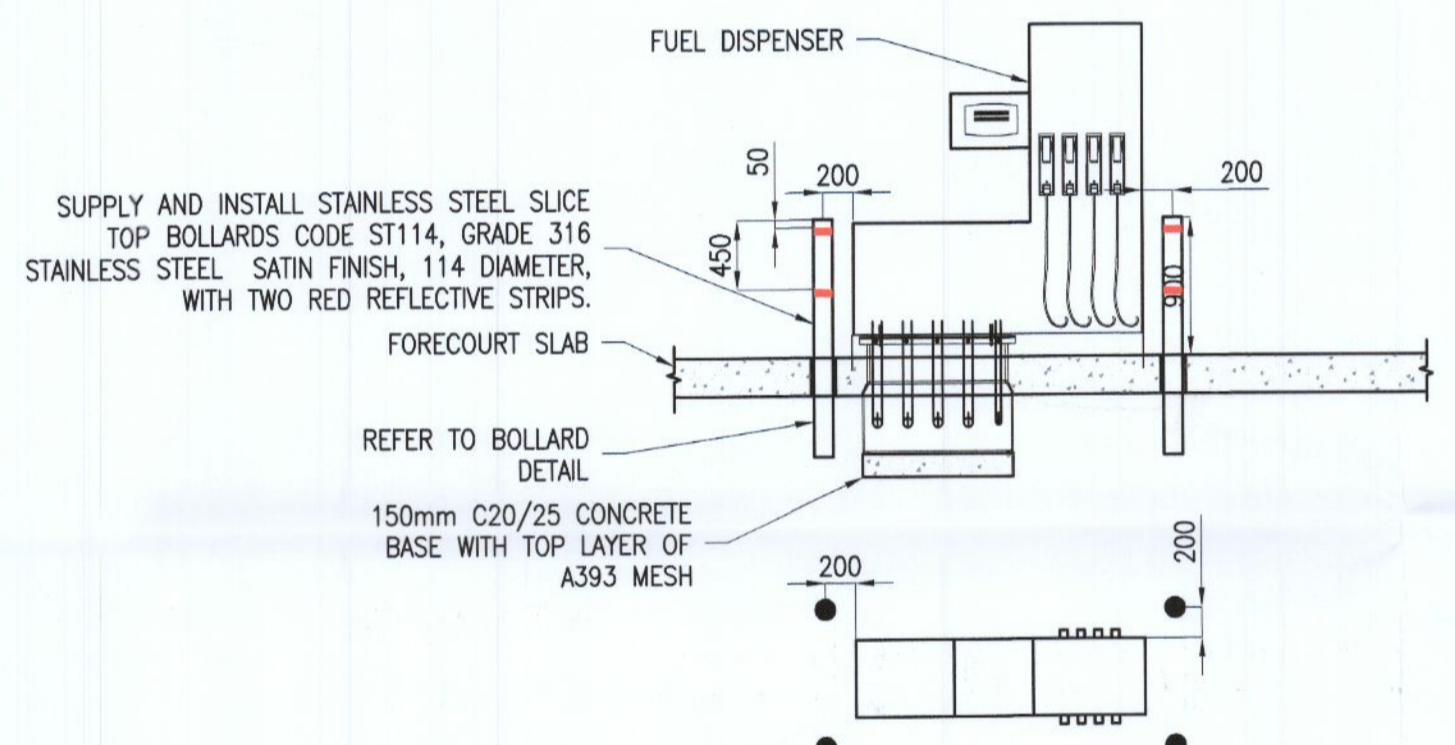


RETAIL FORECOURT PUMP DETAIL
 SCALE 1:50

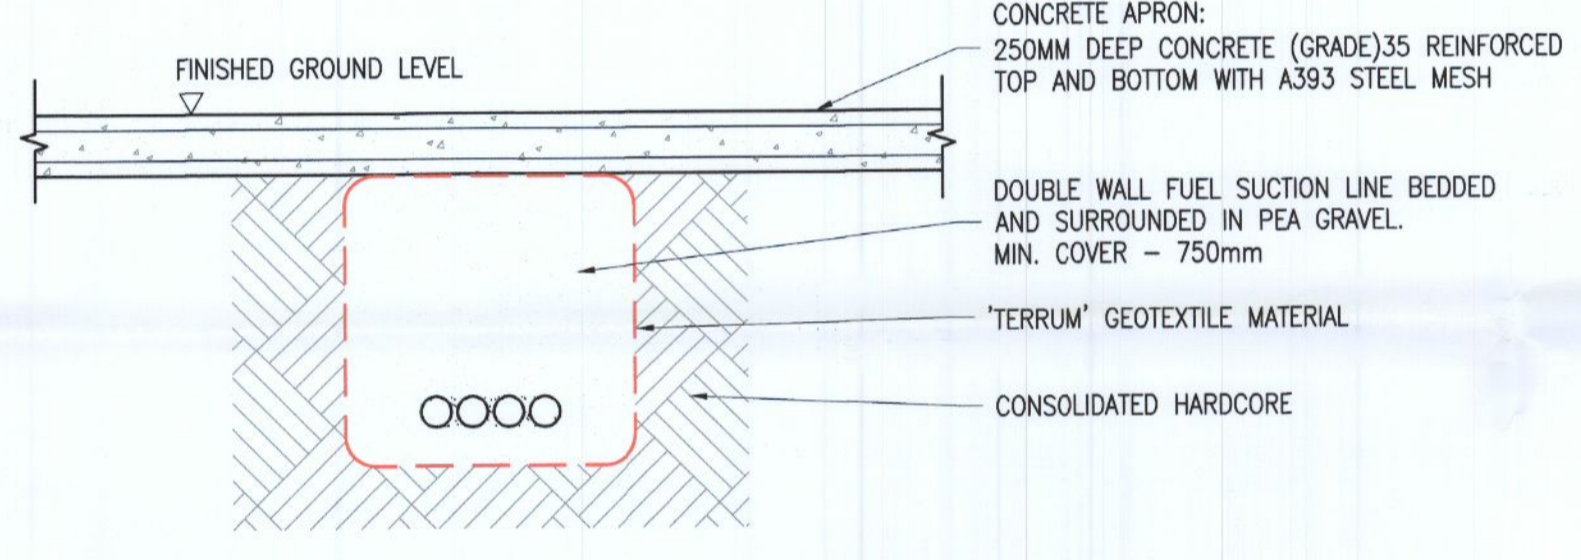


FUEL PIPEWORK SECTION
 SCALE 1:25

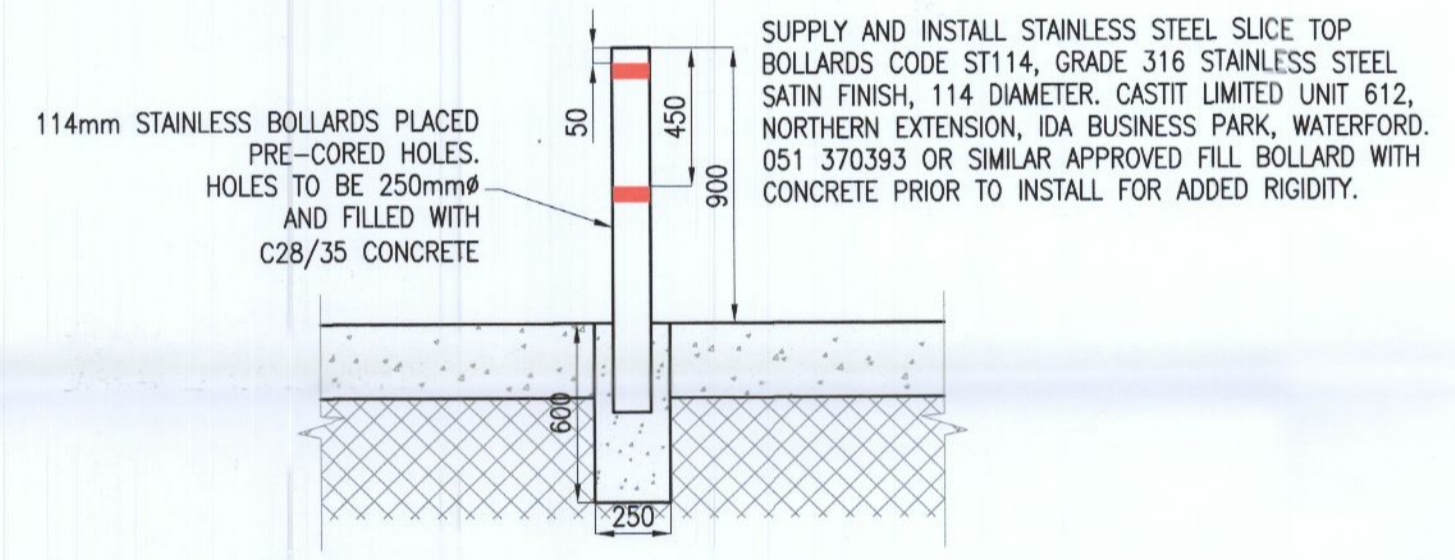


STAINLESS STEEL BOLLARD DETAIL
 SCALE 1:25

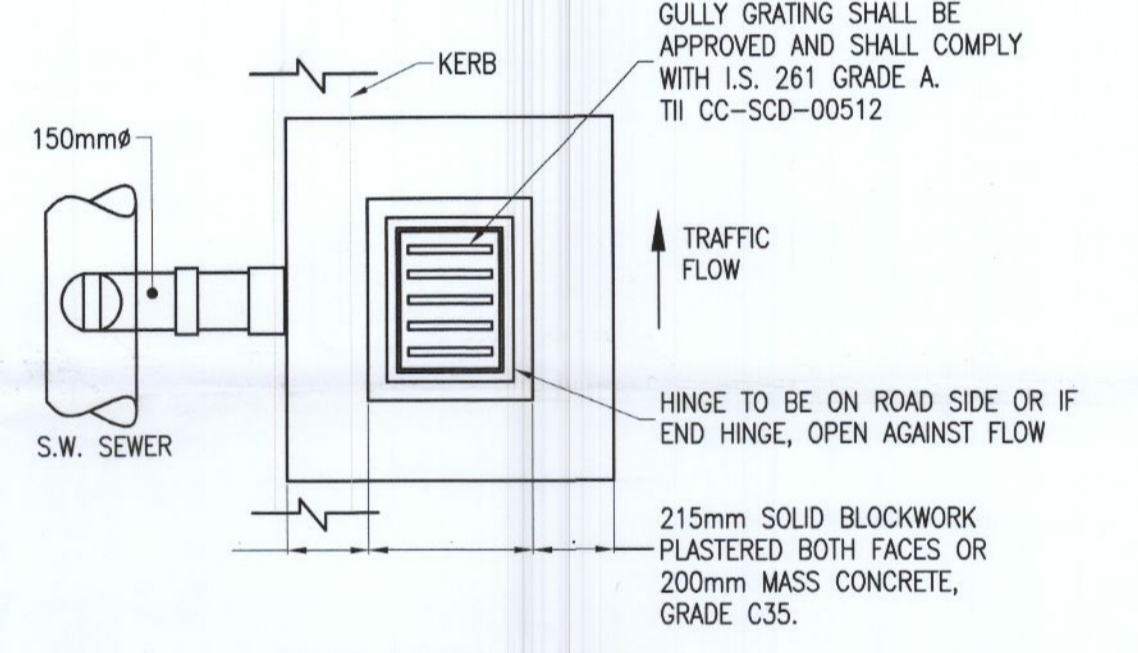

PLAN OF ROAD GULLY (TII CC-SCD-00511)
 SCALE 1:20

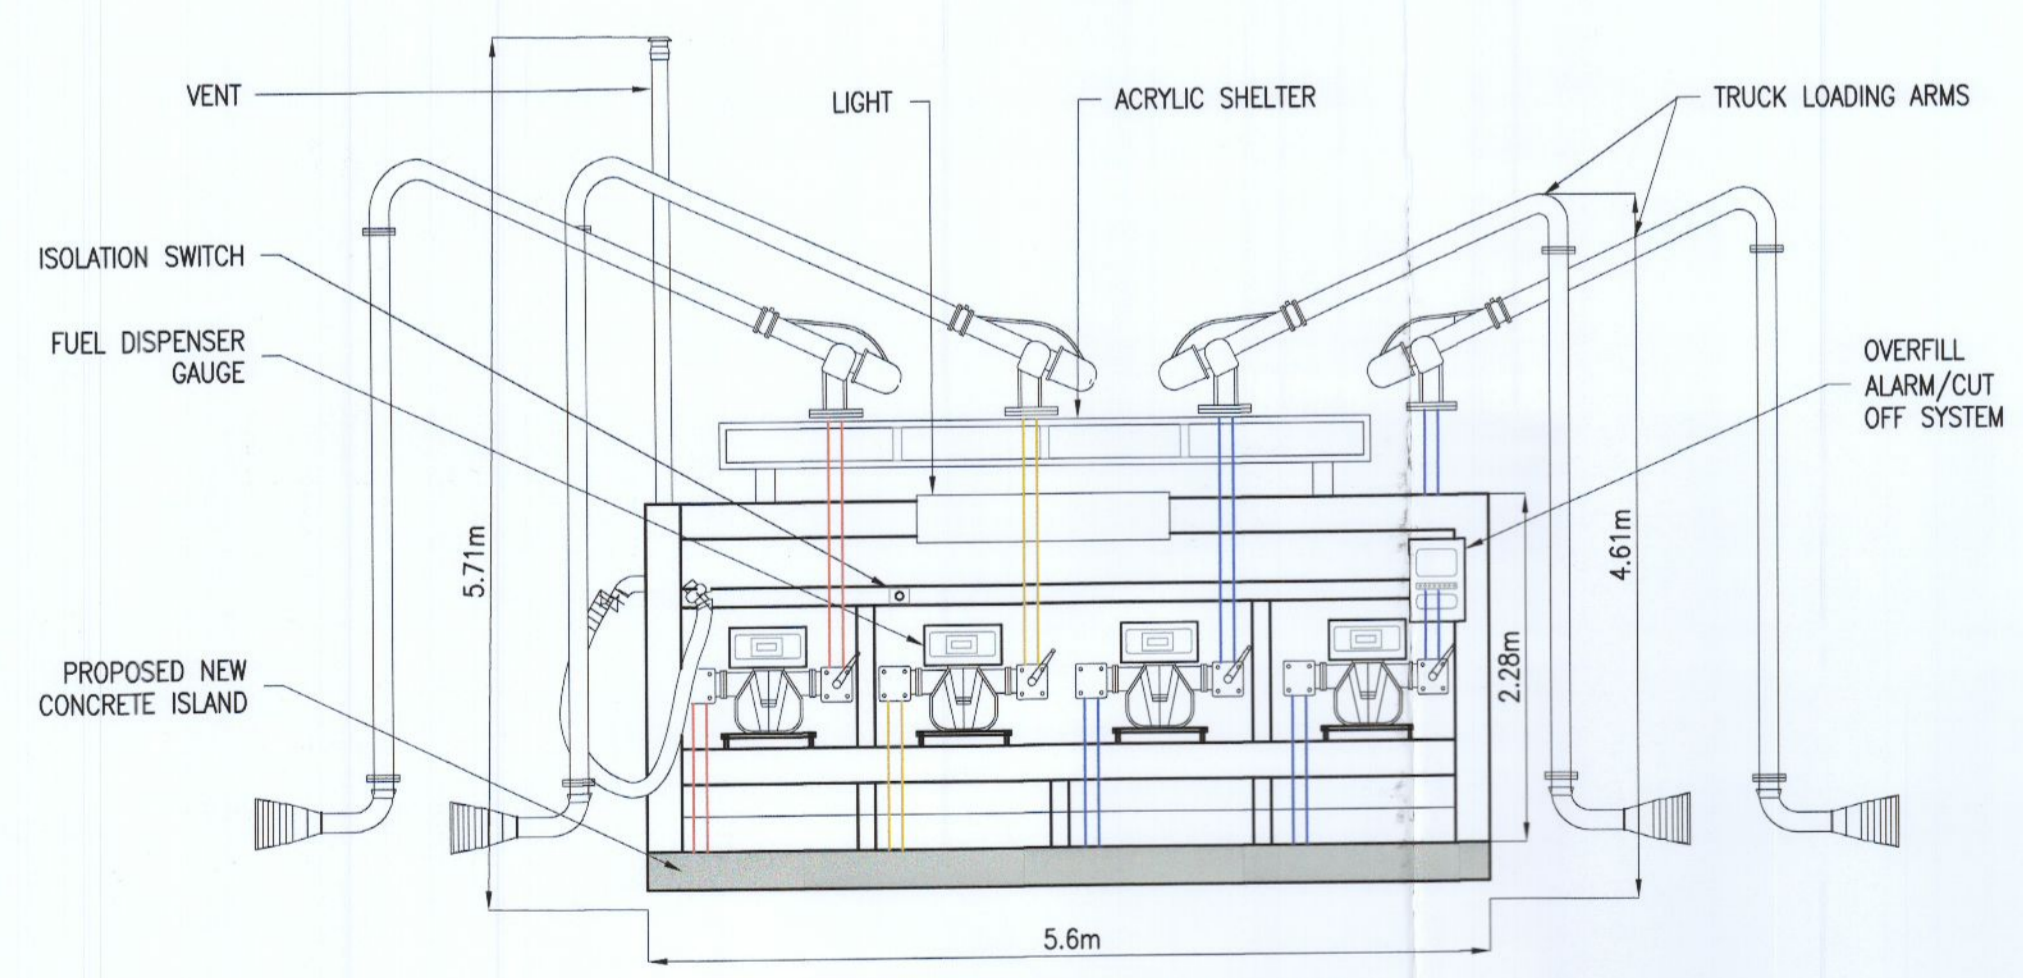

PROPOSED BOTTOM LOADING SKID FRONT ELEVATION
 SCALE 1:50

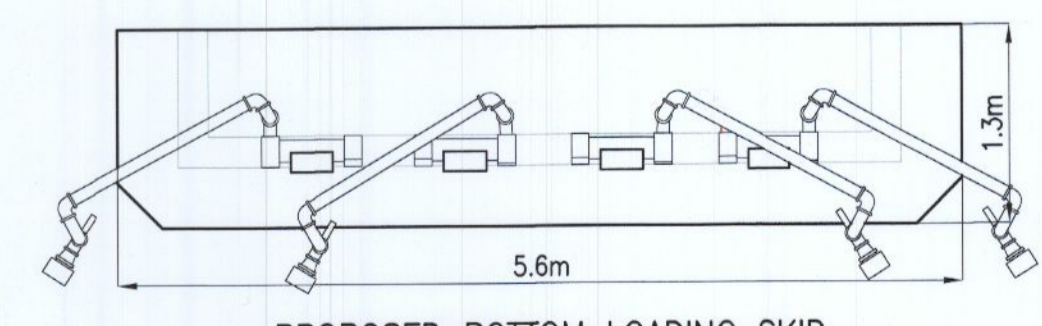

PROPOSED BOTTOM LOADING SKID PLAN
 SCALE 1:50

ISSUED FOR PLANNING	GDR	12/07/22
Rev. Description	By	Date

McArdle Doyle
 Second Floor Exchange Building The Long Walk Dundalk, Co. Louth
 Chartered Engineers Architectural Services & Project Managers
 mail@mcardedoyle.ie +353(0) 42 942 9052

PROJECT: FUEL DEPOT 24 GREENHILLS Rd, TALLAGHT, Co. DUBLIN

CLIENT: **JONES OIL**

DRAWING TITLE: SECTIONS & DETAILS

Date	Drawn	Checked	Approved
12/07/22	GDR	GR	RMcA
Scale at A1	Drawing Number	Status	Rev.
AS SHOWN	P2224.C11	PL	-