




NOTES:
 THIS DRAWING IN WHOLE OR IN PART SHALL NOT BE COPIED WITHOUT THE PRIOR PERMISSION OF McARDLE DOYLE LTD.
 ALL WORKS TO COMPLY WITH THE CURRENT BUILDING REGULATIONS.
 DO NOT SCALE.
 ORDINANCE SURVEY IRELAND LICENCE No. AR 0105722
 © ORDINANCE SURVEY IRELAND / GOVERNMENT OF IRELAND
 OS REF: 3390-03, 3390-08, 3390-02, 3390-07
 TM CO-ORDINATES 708775.1274, 728520.117

- LEGEND:**
- PROPOSED STORM SEWER
 - EXISTING STORM SEWER
 - EXISTING STORM SEWER (REMOVED)
 - PUBLIC STORM SEWER
 - PROPOSED FOUL SEWER
 - EXISTING FOUL SEWER
 - PUBLIC FOUL SEWER
 - PROPOSED CONTAMINATED SEWER
 - EXISTING CONTAMINATED SEWER
 - EXISTING CONTAMINATED SEWER (REMOVED)
 - PROPOSED CONTAMINATED ACO CHANNEL
 - EXISTING CONTAMINATED ACO CHANNEL
 - EXISTING GULLY STORM
 - EXISTING GULLY CONTAMINATED

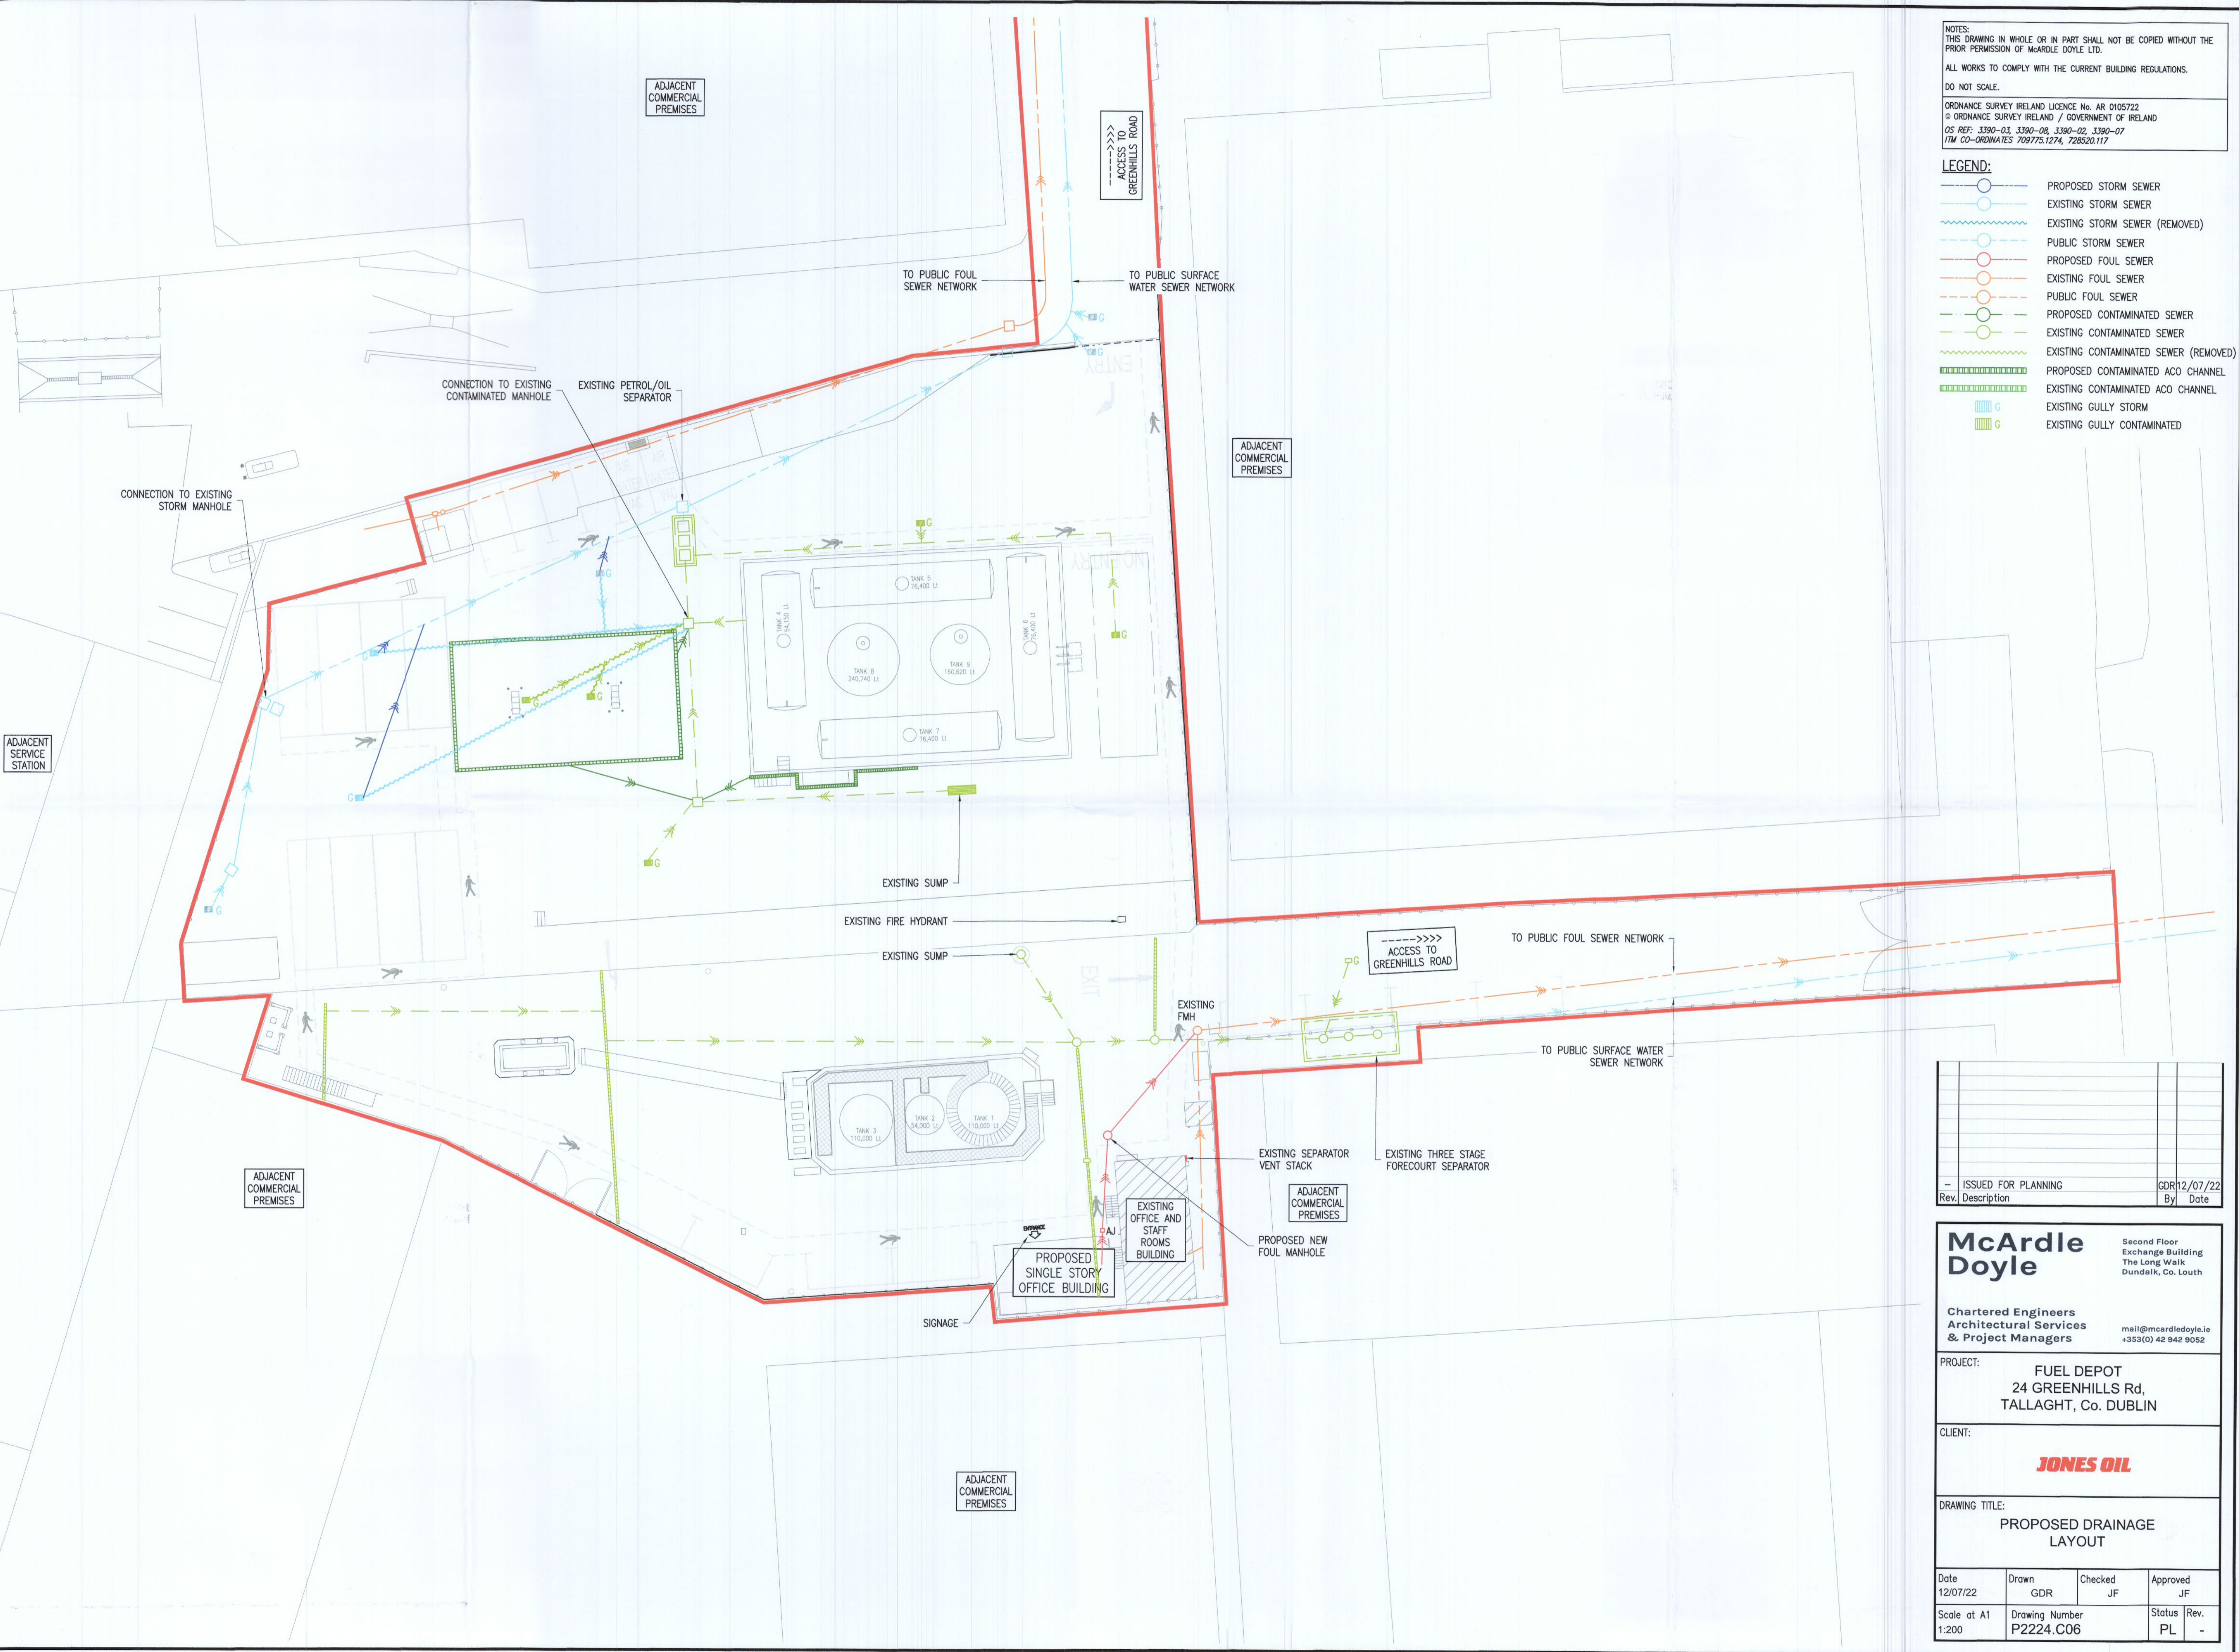

ISSUED FOR PLANNING	GDR12/07/22
Rev. Description	By Date

McArdle Doyle
 Second Floor
 Exchange Building
 The Long Walk
 Dundalk, Co. Louth
 Chartered Engineers
 Architectural Services
 & Project Managers
 mail@mcardle Doyle.ie
 +353(0) 42 942 9052

PROJECT: FUEL DEPOT
 24 GREENHILLS Rd,
 TALLAGHT, Co. DUBLIN

CLIENT: **JONES OIL**

DRAWING TITLE: PROPOSED DRAINAGE LAYOUT

Date 12/07/22	Drawn GDR	Checked JF	Approved JF
Scale at A1 1:200	Drawing Number P2224.C06	Status PL	Rev. -