


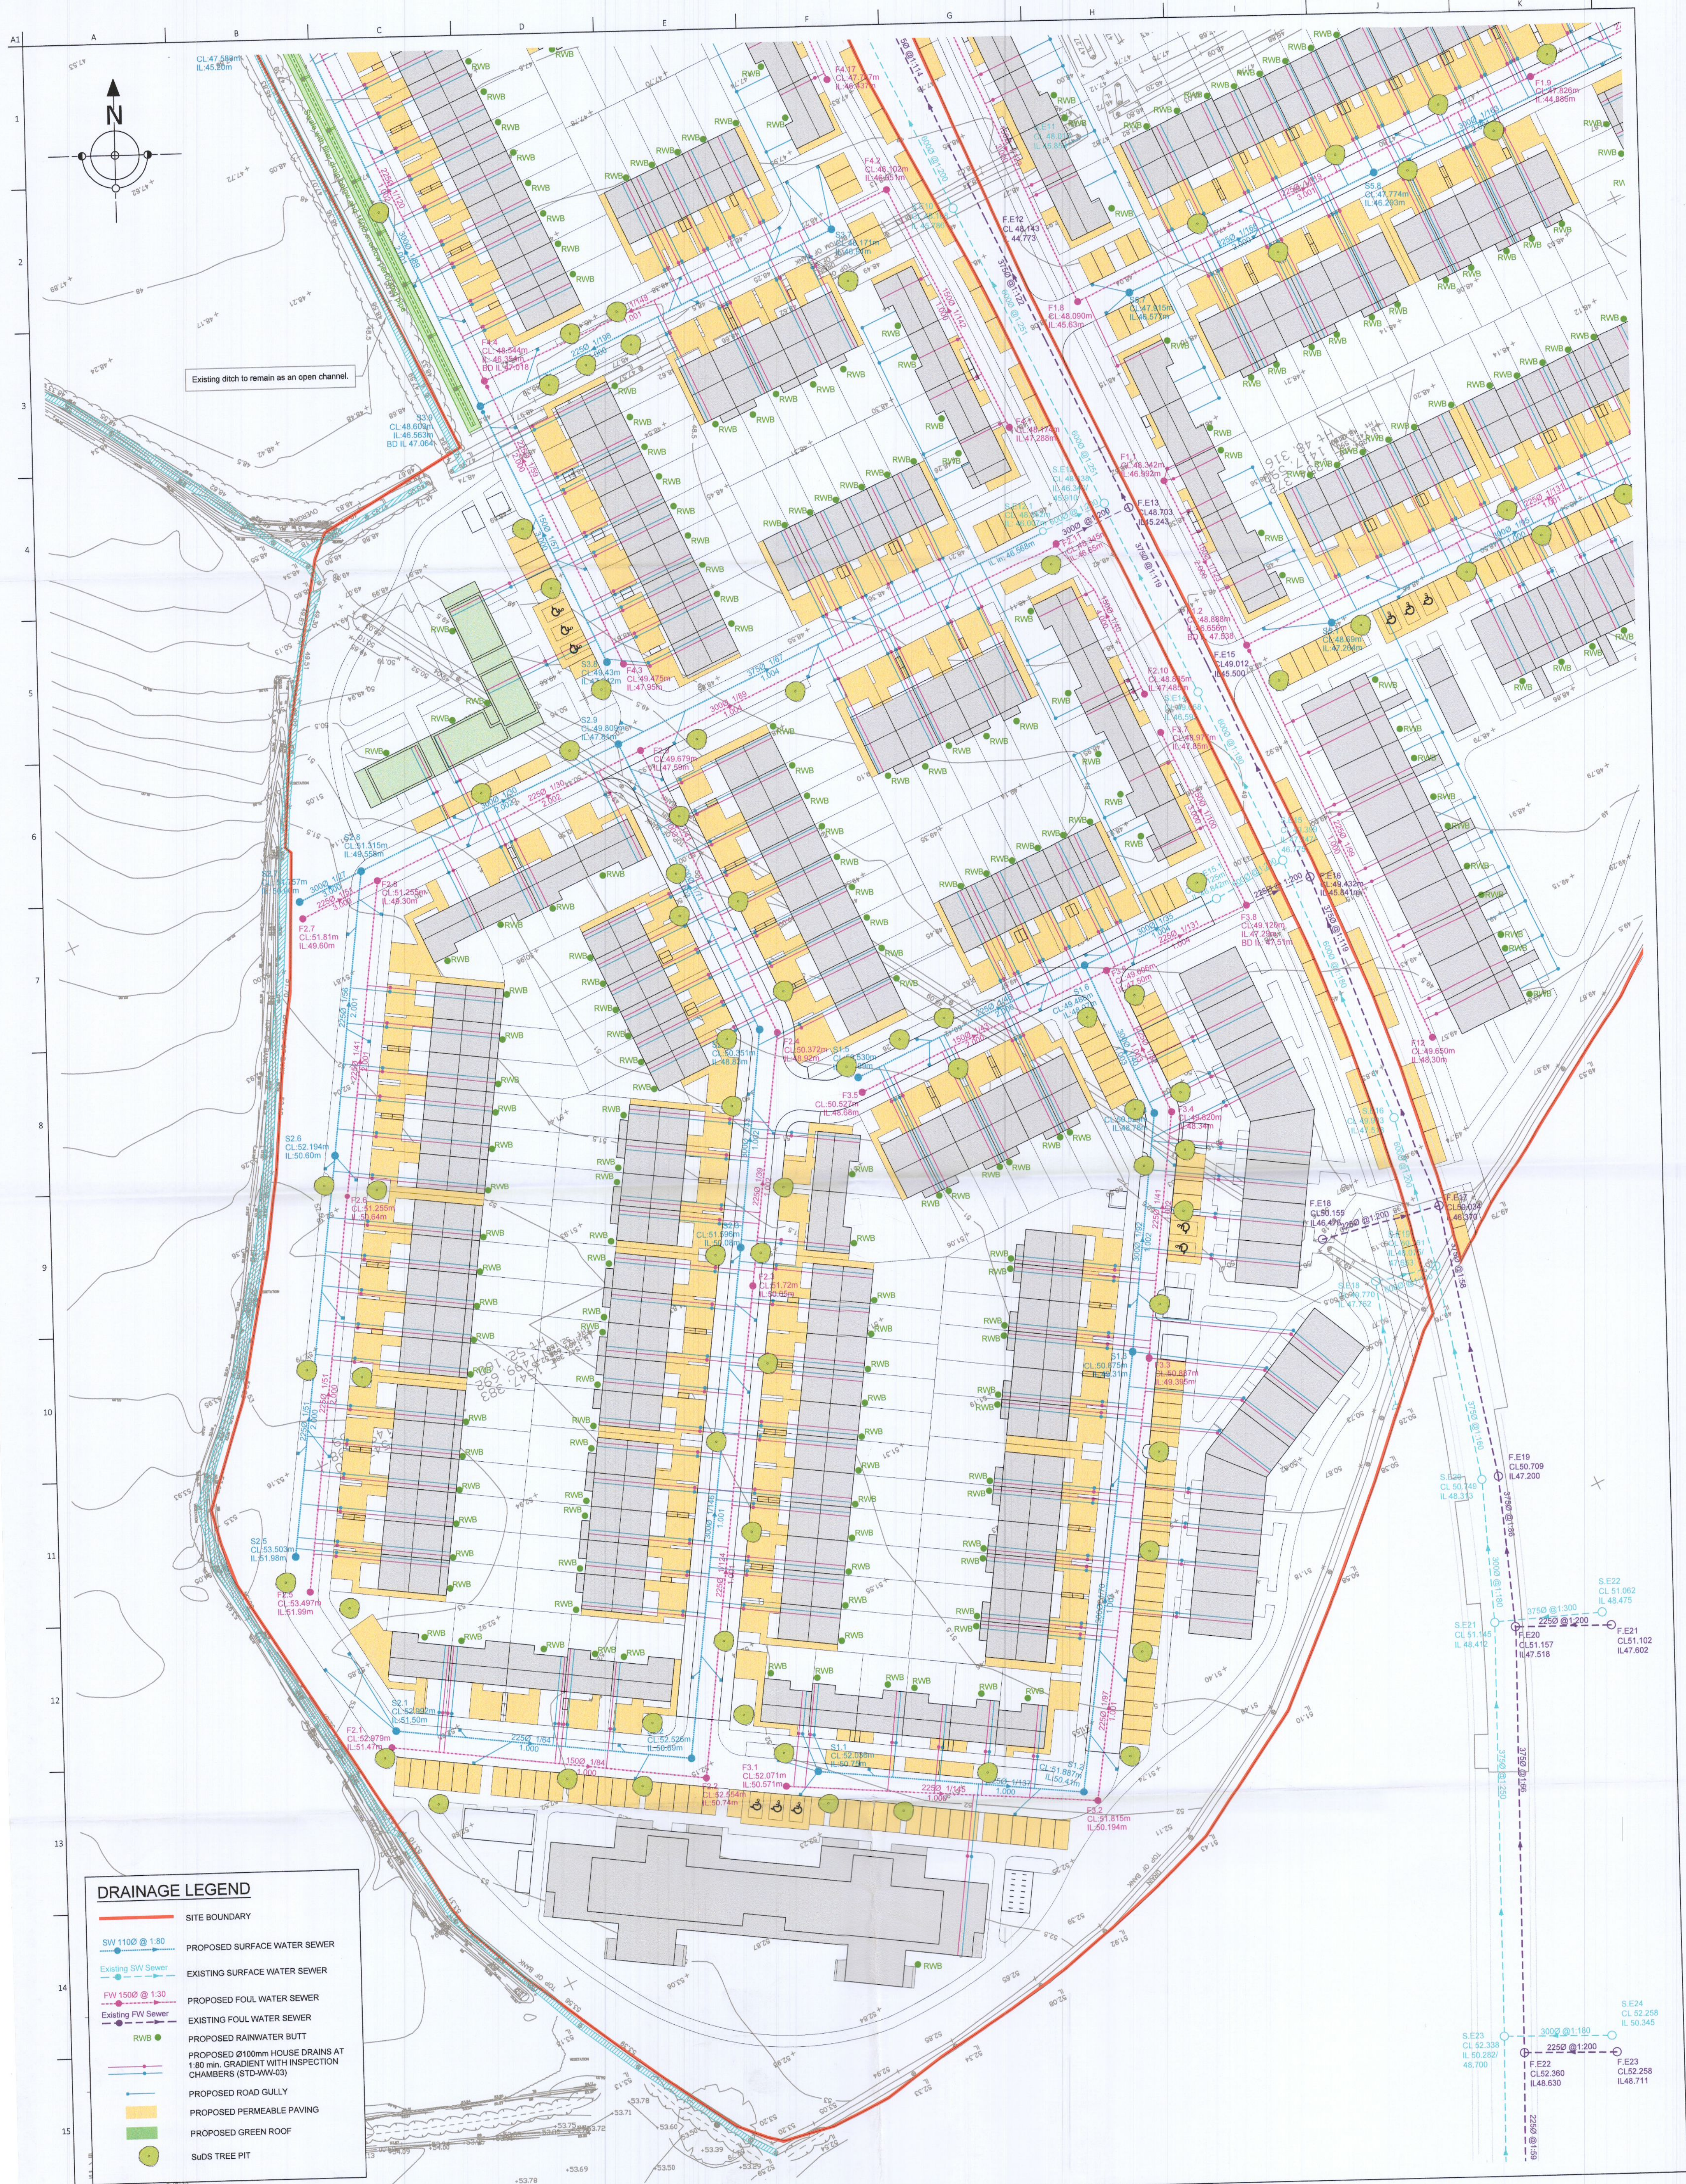

DRAINAGE LEGEND

- SITE BOUNDARY
- SW 1100 @ 1.80 PROPOSED SURFACE WATER SEWER
- EXISTING SURFACE WATER SEWER
- FW 1500 @ 1.30 PROPOSED FOUL WATER SEWER
- EXISTING FOUL WATER SEWER
- PROPOSED RAINWATER BUTT
- PROPOSED Ø100mm HOUSE DRAINS AT 1.80 min. GRADIENT WITH INSPECTION CHAMBERS (STD-WW-03)
- PROPOSED ROAD GULLY
- PROPOSED PERMEABLE PAVING
- PROPOSED GREEN ROOF
- SuDS TREE PIT

P4	22.09.2022	LAYOUT UPDATED	NMO
P3	27.06.2022	LAYOUT UPDATED	NMO
P2	17.12.2021	REDLINE BOUNDARY UPDATED	NMO
P1	19.11.2021	SITE LAYOUT UPDATED	CG
Rev.	Date	Description	By

Project Title
**PHASE 3
TUBBER LANE - ADAMSTOWN**

Architect
DAVEY & SMITH ARCHITECTS

Date	By	Checked	Scale @ A1
SEP 2021	CG NMO	PM	1:500

Drawing Title
**DRAINAGE LAYOUT
SHEET 1 OF 3**

Drawing Status
PLANNING

Job No.	Drawing No.	Issue
20065	104	P4

POGA
CONSULTING ENGINEERS
STRUCTURAL & CIVIL

Unit C2, Nutgrove Office Park
Rathfarnham
Dublin 14
D14 CR20
Tel: +353 (0)1 205 1101
www.poga.ie