


Proposed Drainage Layout
(1:50 @A1 / 1:100 @A3)

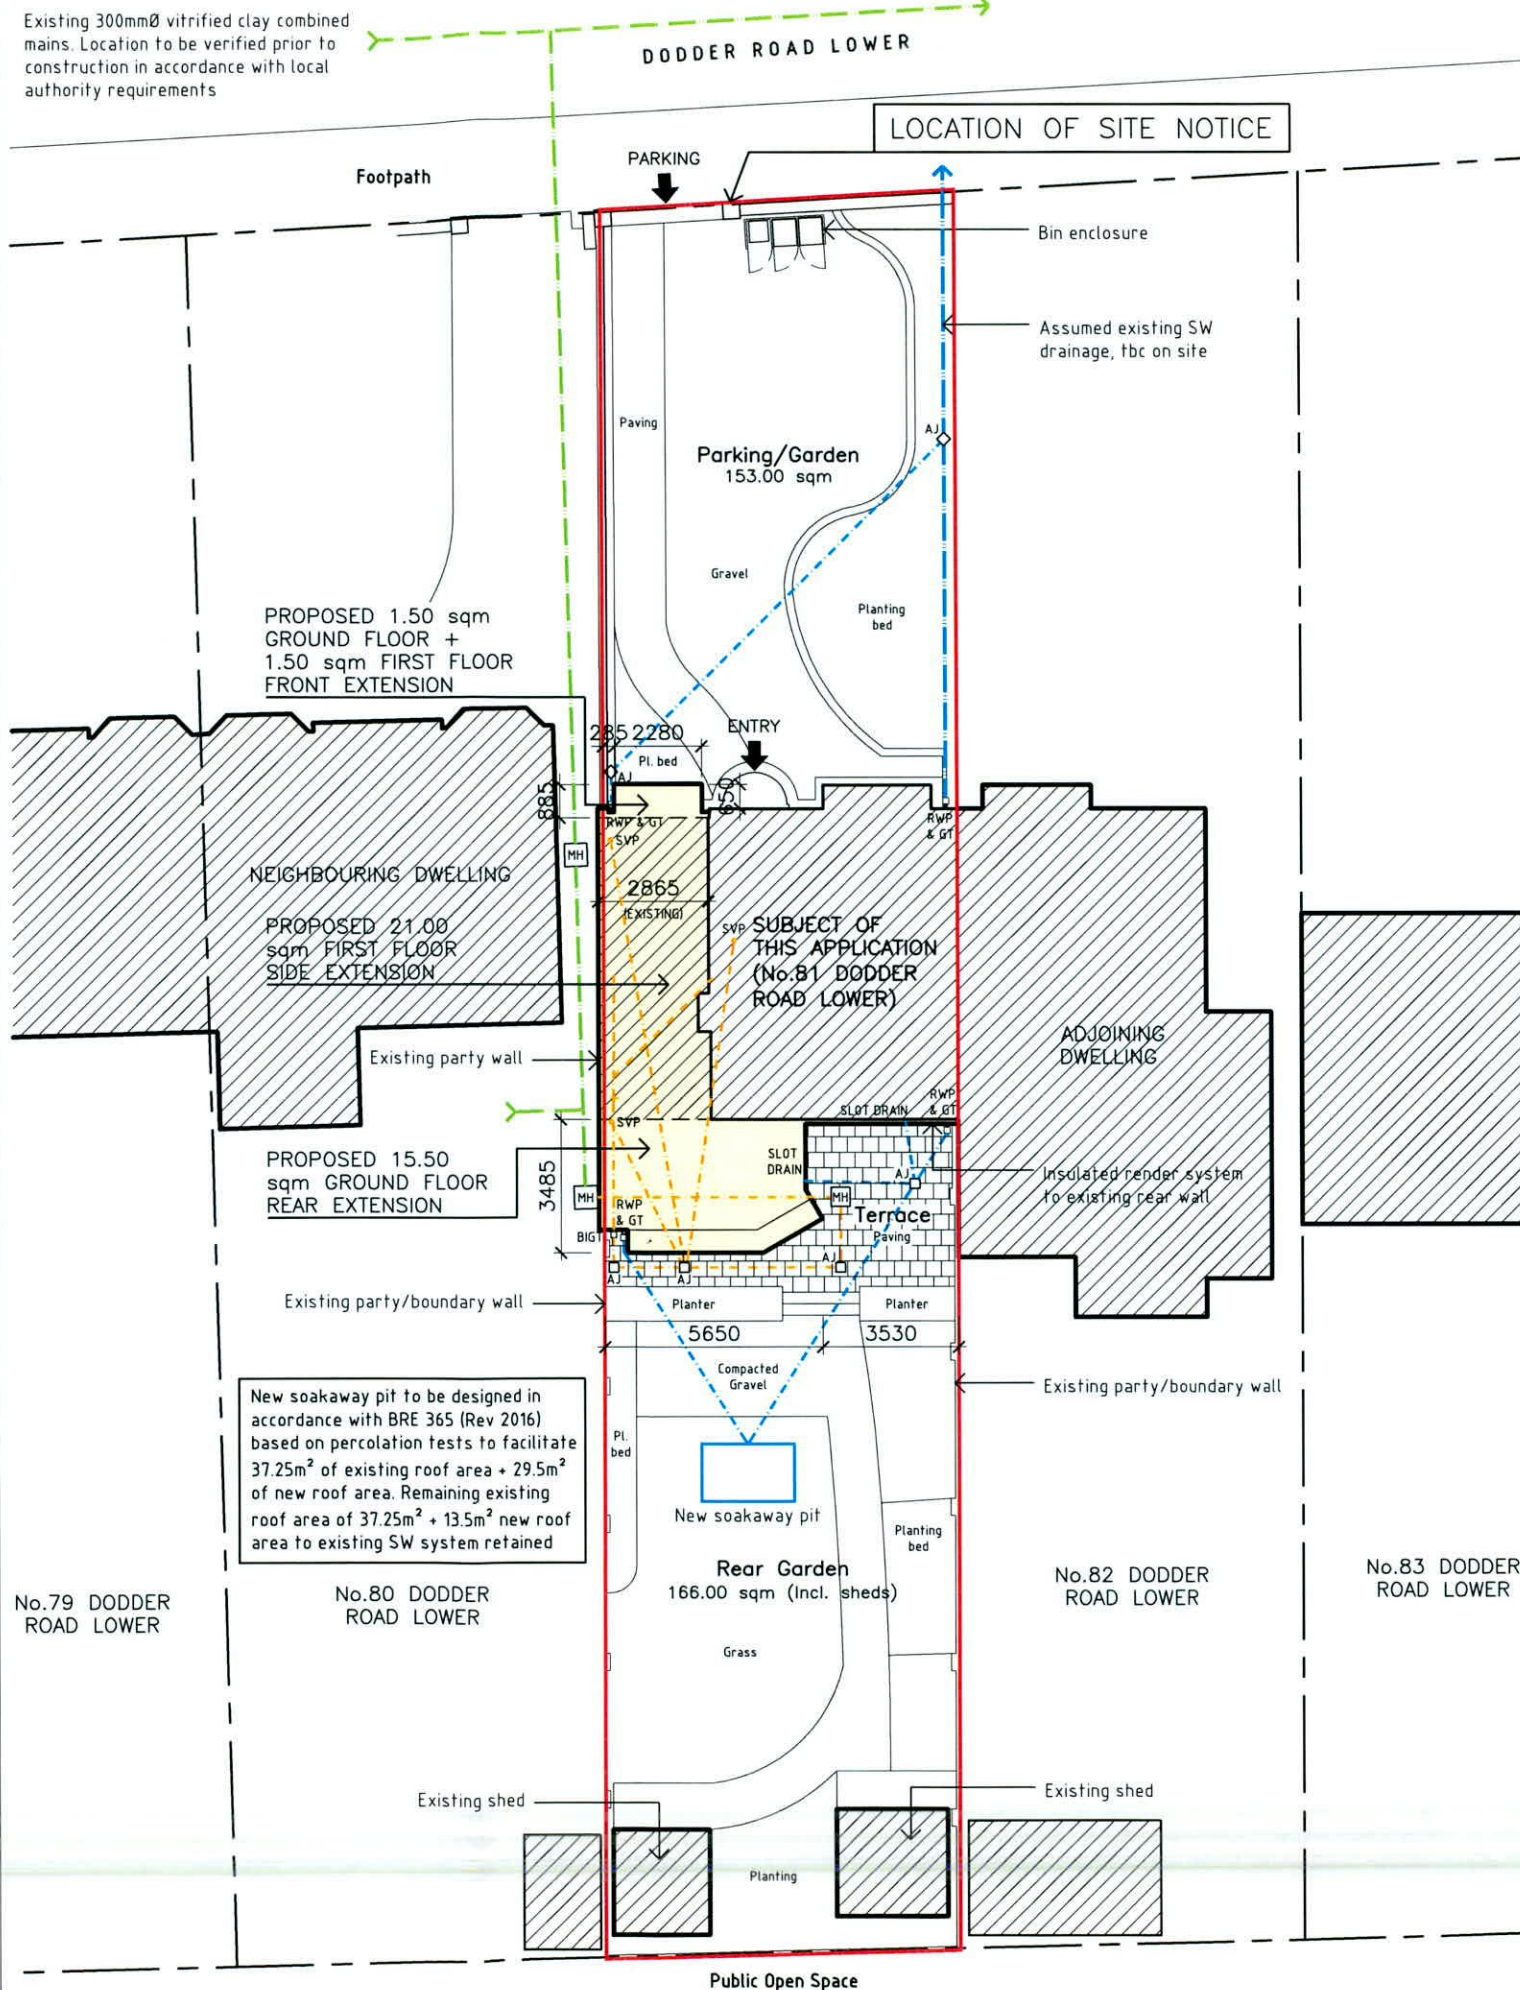

Site Plan / Block Plan

(Site Area = 445 sqm / 0.11ac / 0.0441ha). Ref. O.S. Map Sheet Nos. 3328-19/20/24/25

- NOTES:**
1. This drawing is copyright and may only be reproduced with the architects permission.
 2. Do not scale
 3. Use only written dimensions

- KEY:**
- Proposed Extension
 - Existing SW drainage
 - Existing FW drainage
 - Existing Combined drainage
 - Proposed SW drainage
 - Proposed FW drainage



Rev.	Date	Dn.	Appd.	Details
Drawing Plotted on: 08/09/2022				

Client:
MARION & BRENDAN McDONALD

Fionnuala Rogerson Architects
Ardona House, Lower Churchtown Rd, Dublin 14
Telephone: (01) 2984261
E-mail: info@rogerson.ie



Project Title
Alterations & Extension to
81 Dodder Road Lower,
Rathfarnham, Dublin 14,
D14 X588

Drawing Title
Site Plan/Block Plan,
Drainage Layout
(Proposed)

Drawing Status
PLANNING APPLICATION

Scales: 1:100 @A1/1:200 @A3

Date	Appd.	Dn.	Rev.
June 2022	-	NG	-
Project No.	Drawing No.	Ch:	Rev.
2011	PA-05	-	-