




EXISTING SITE LAYOUT PLAN

Scale 1:200


- SITE OUTLINED IN RED
- LANDS IN OWNERSHIP OF APPLICANT OUTLINED IN BLUE

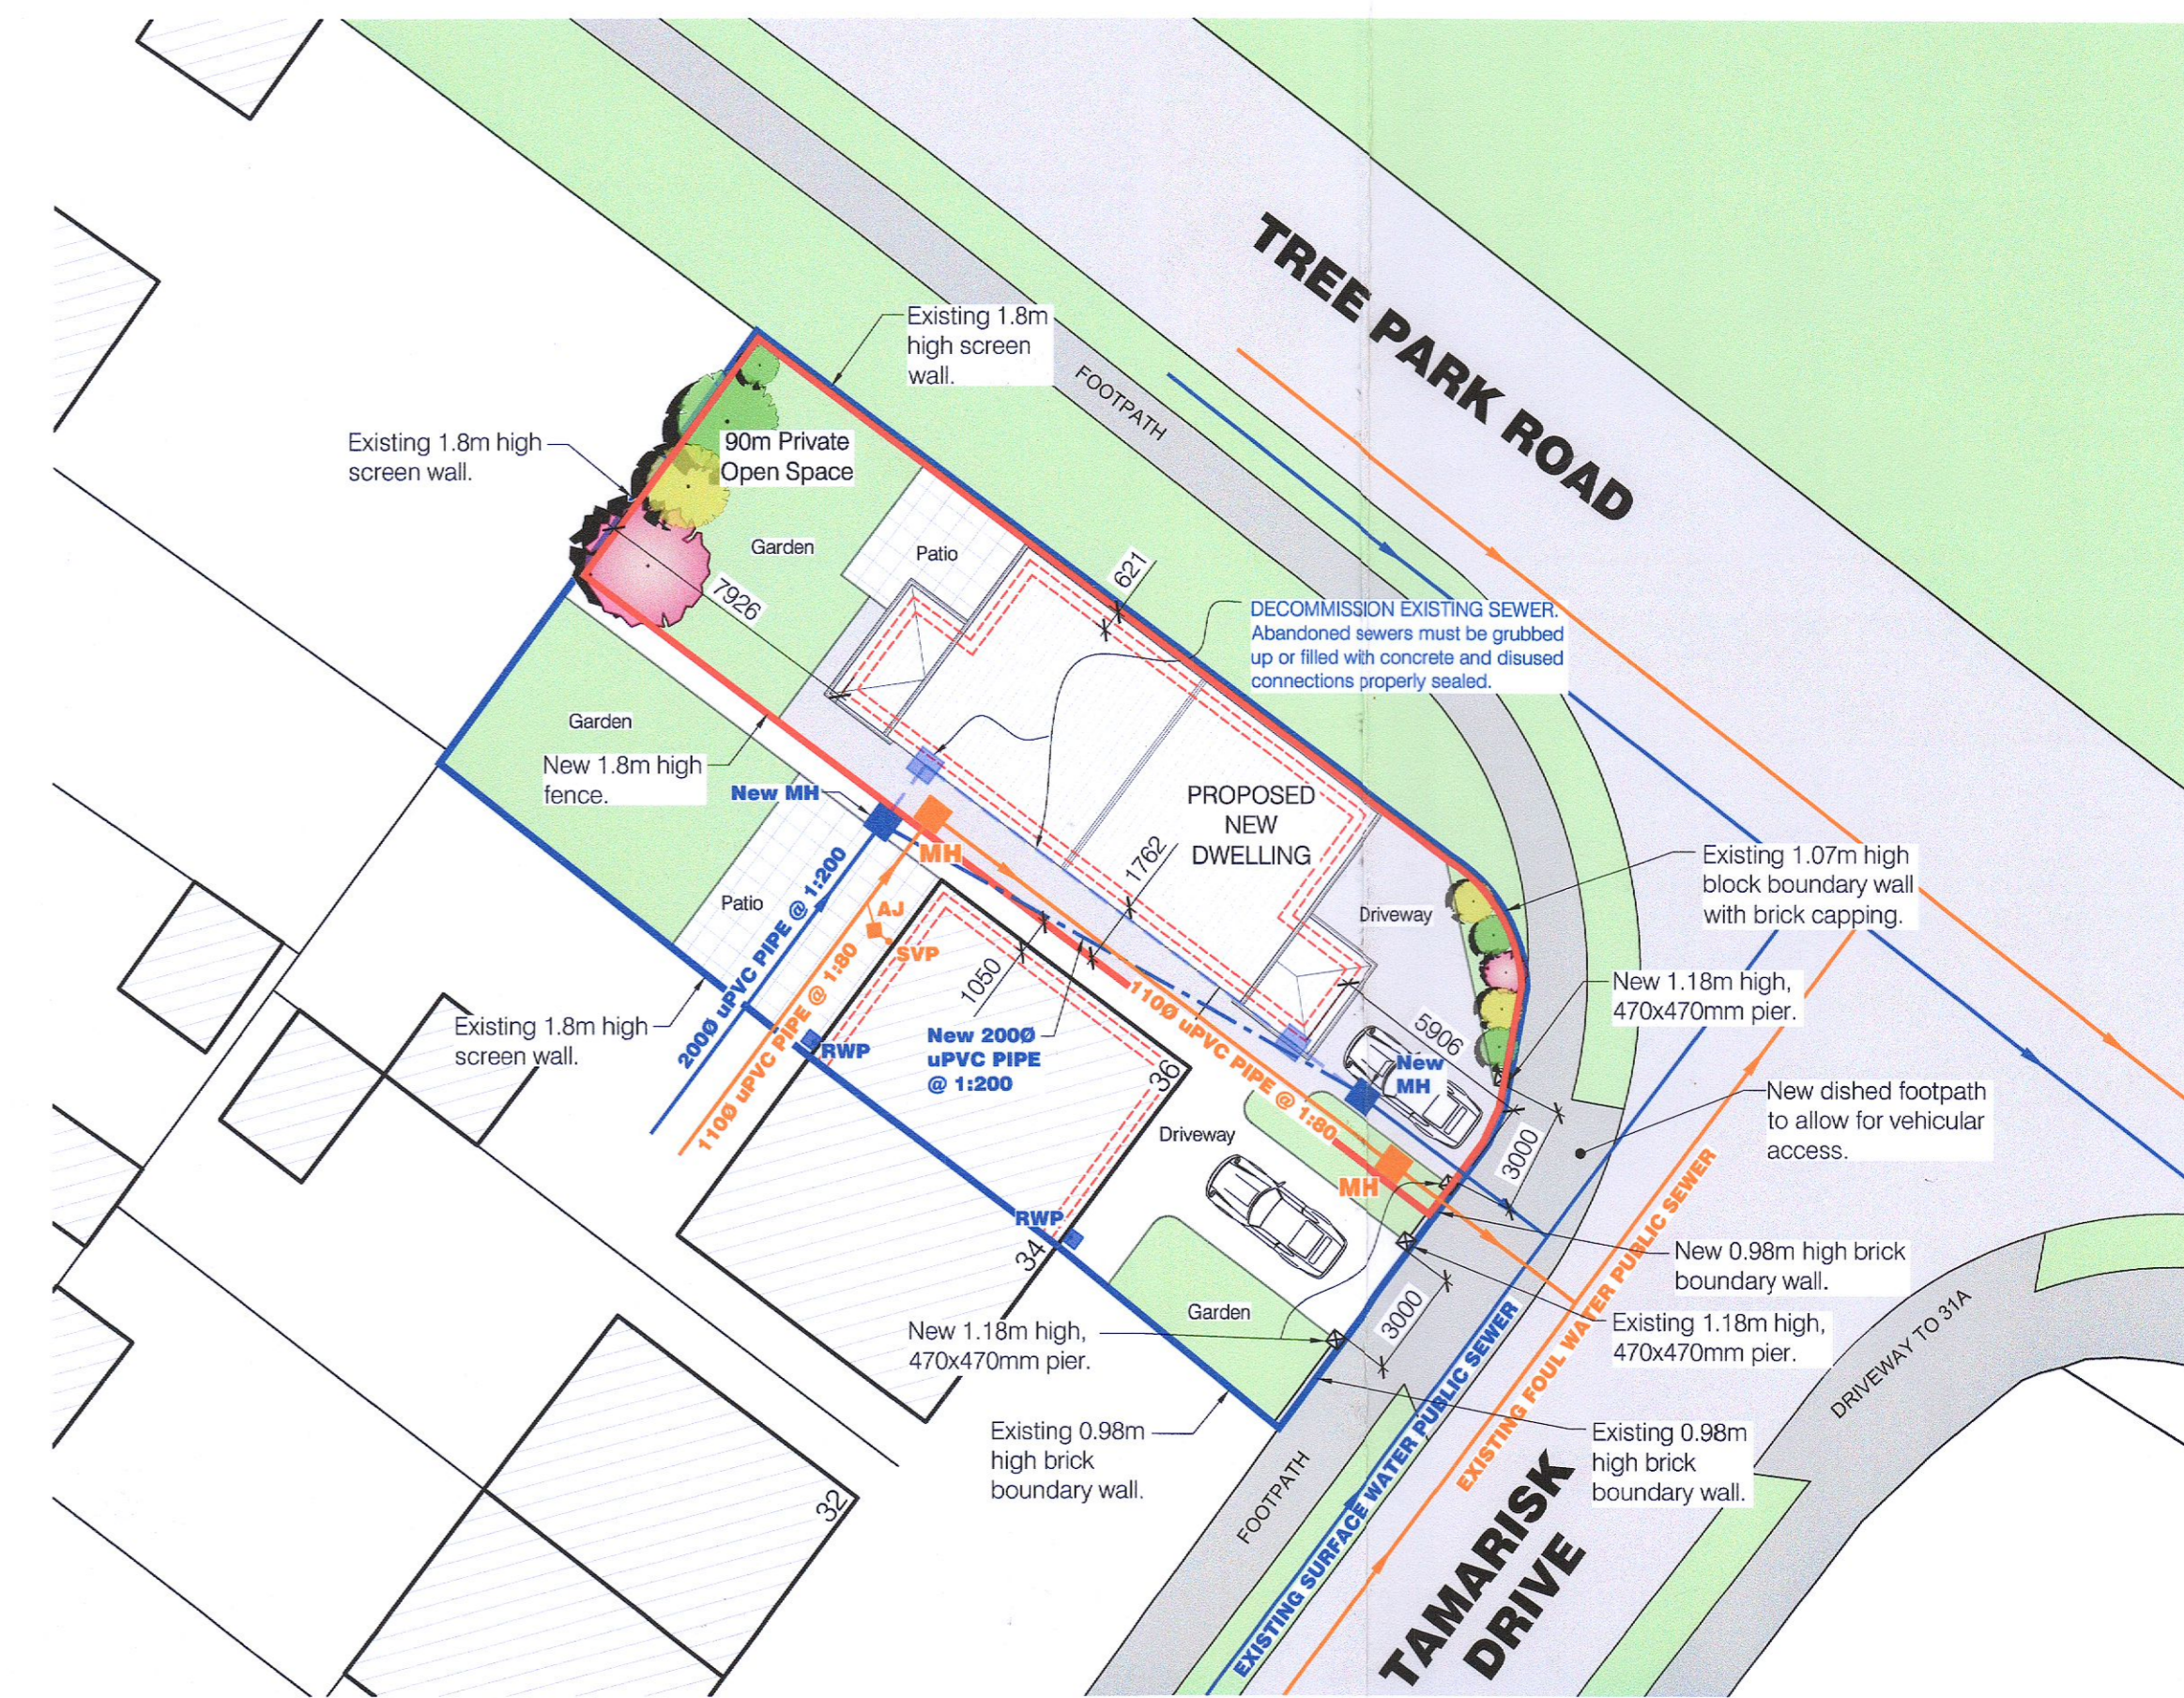

PROPOSED SITE LAYOUT PLAN


Scale 1:200

- SITE OUTLINED IN RED
- LANDS IN OWNERSHIP OF APPLICANT OUTLINED IN BLUE

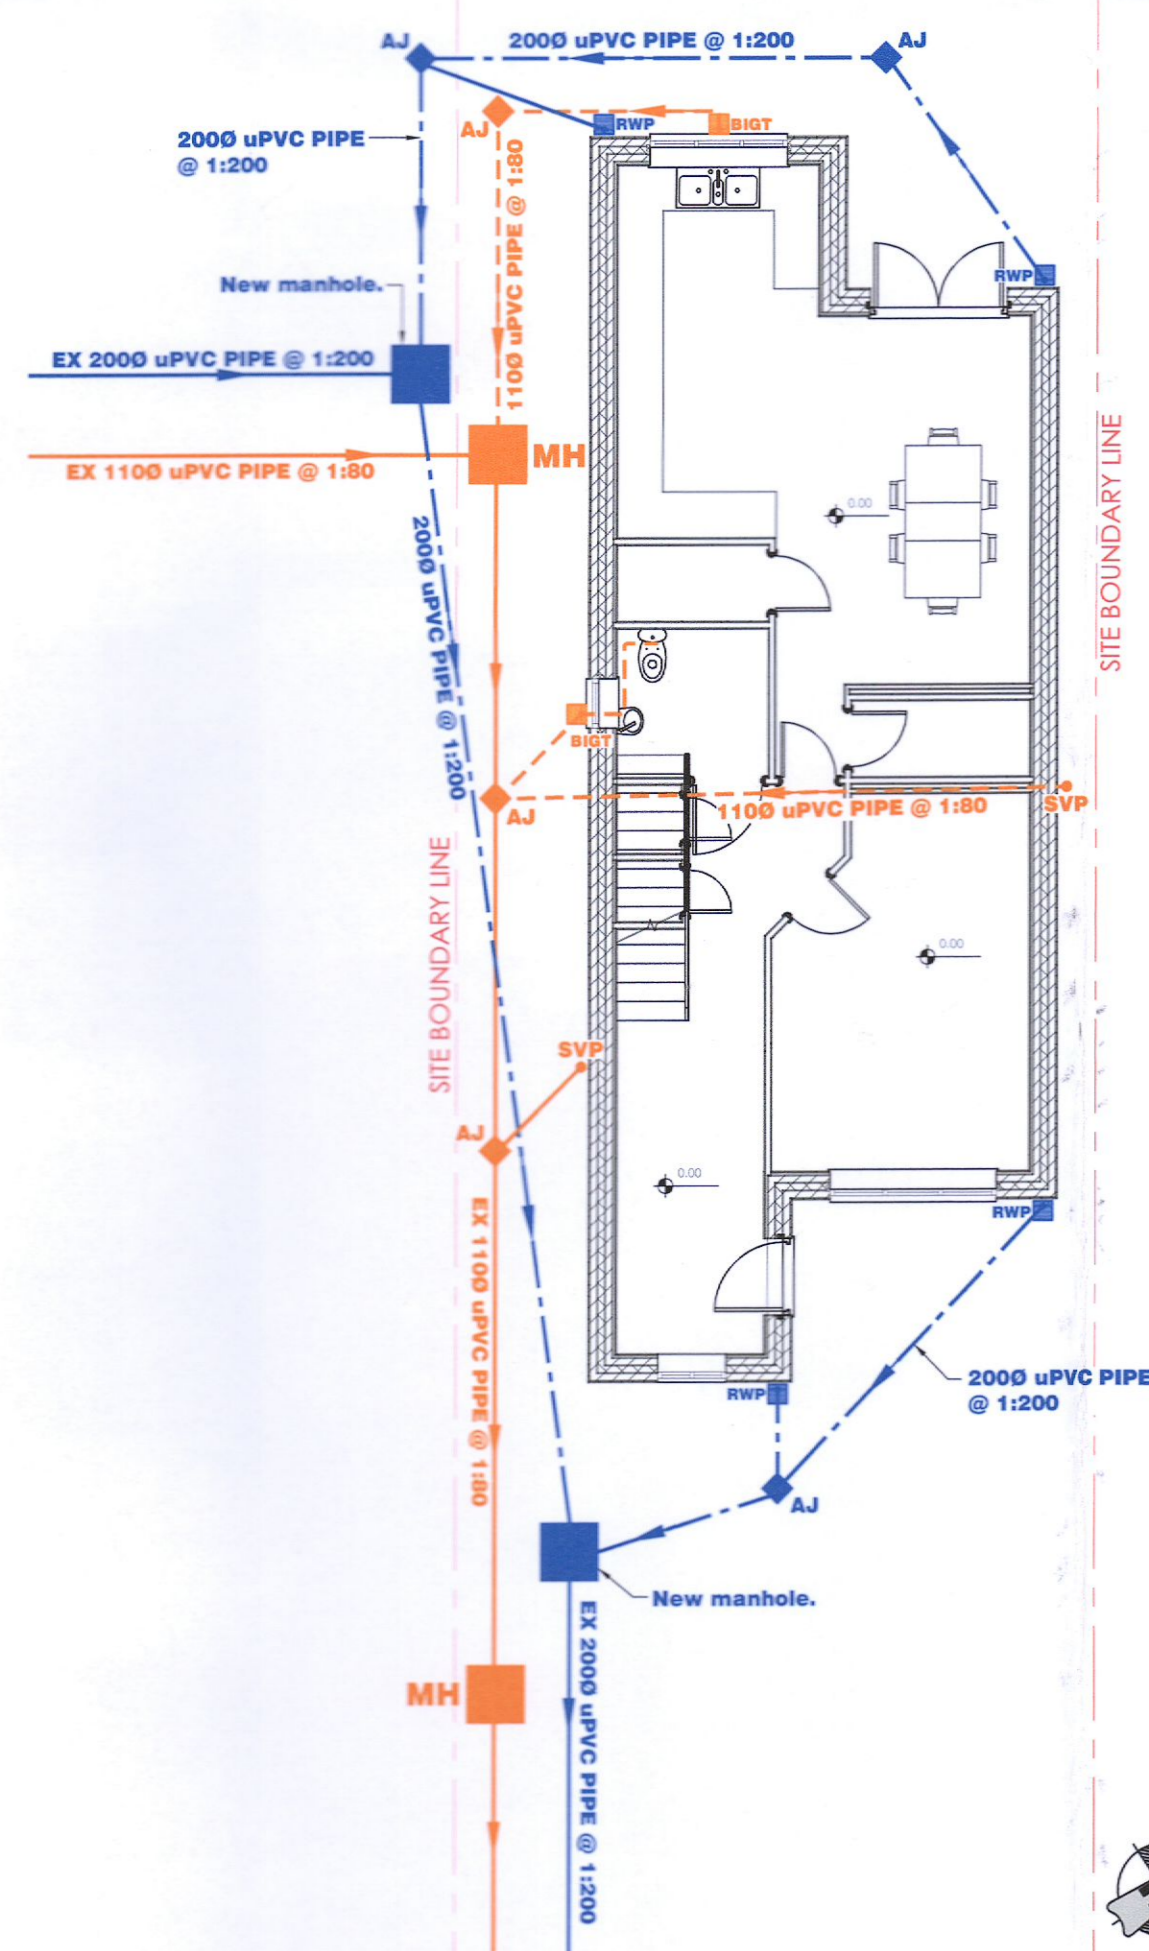


PROPOSED GROUND FLOOR DRAINAGE LAYOUT

Scale 1:100

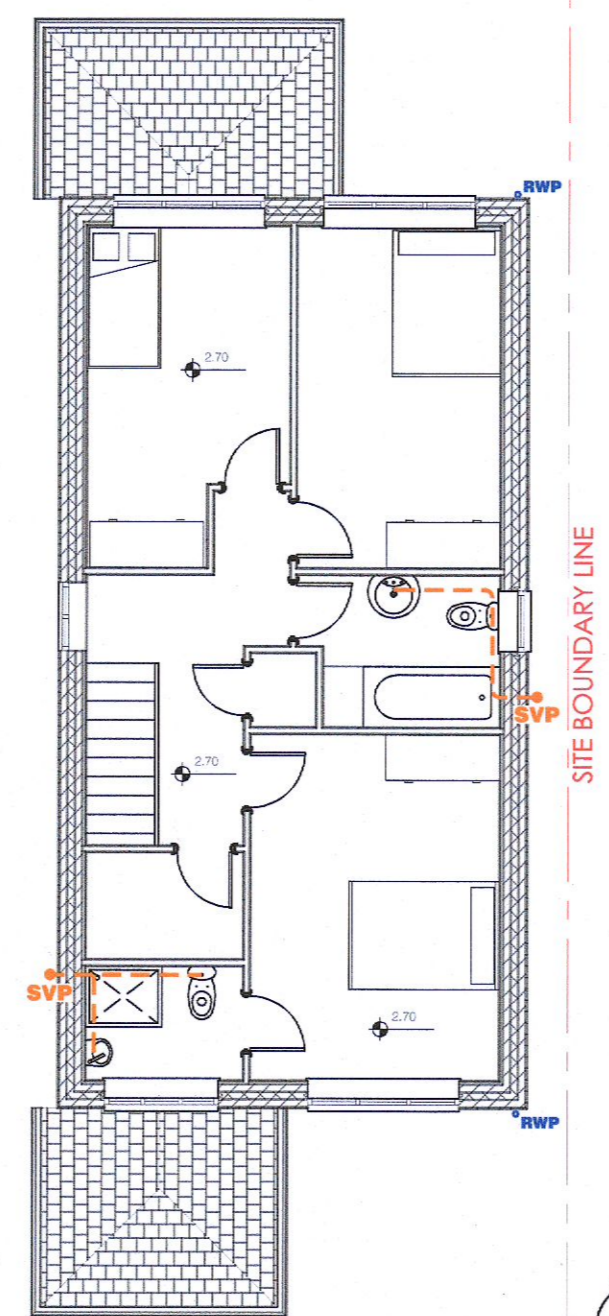

PROPOSED FIRST FLOOR DRAINAGE LAYOUT

Scale 1:100

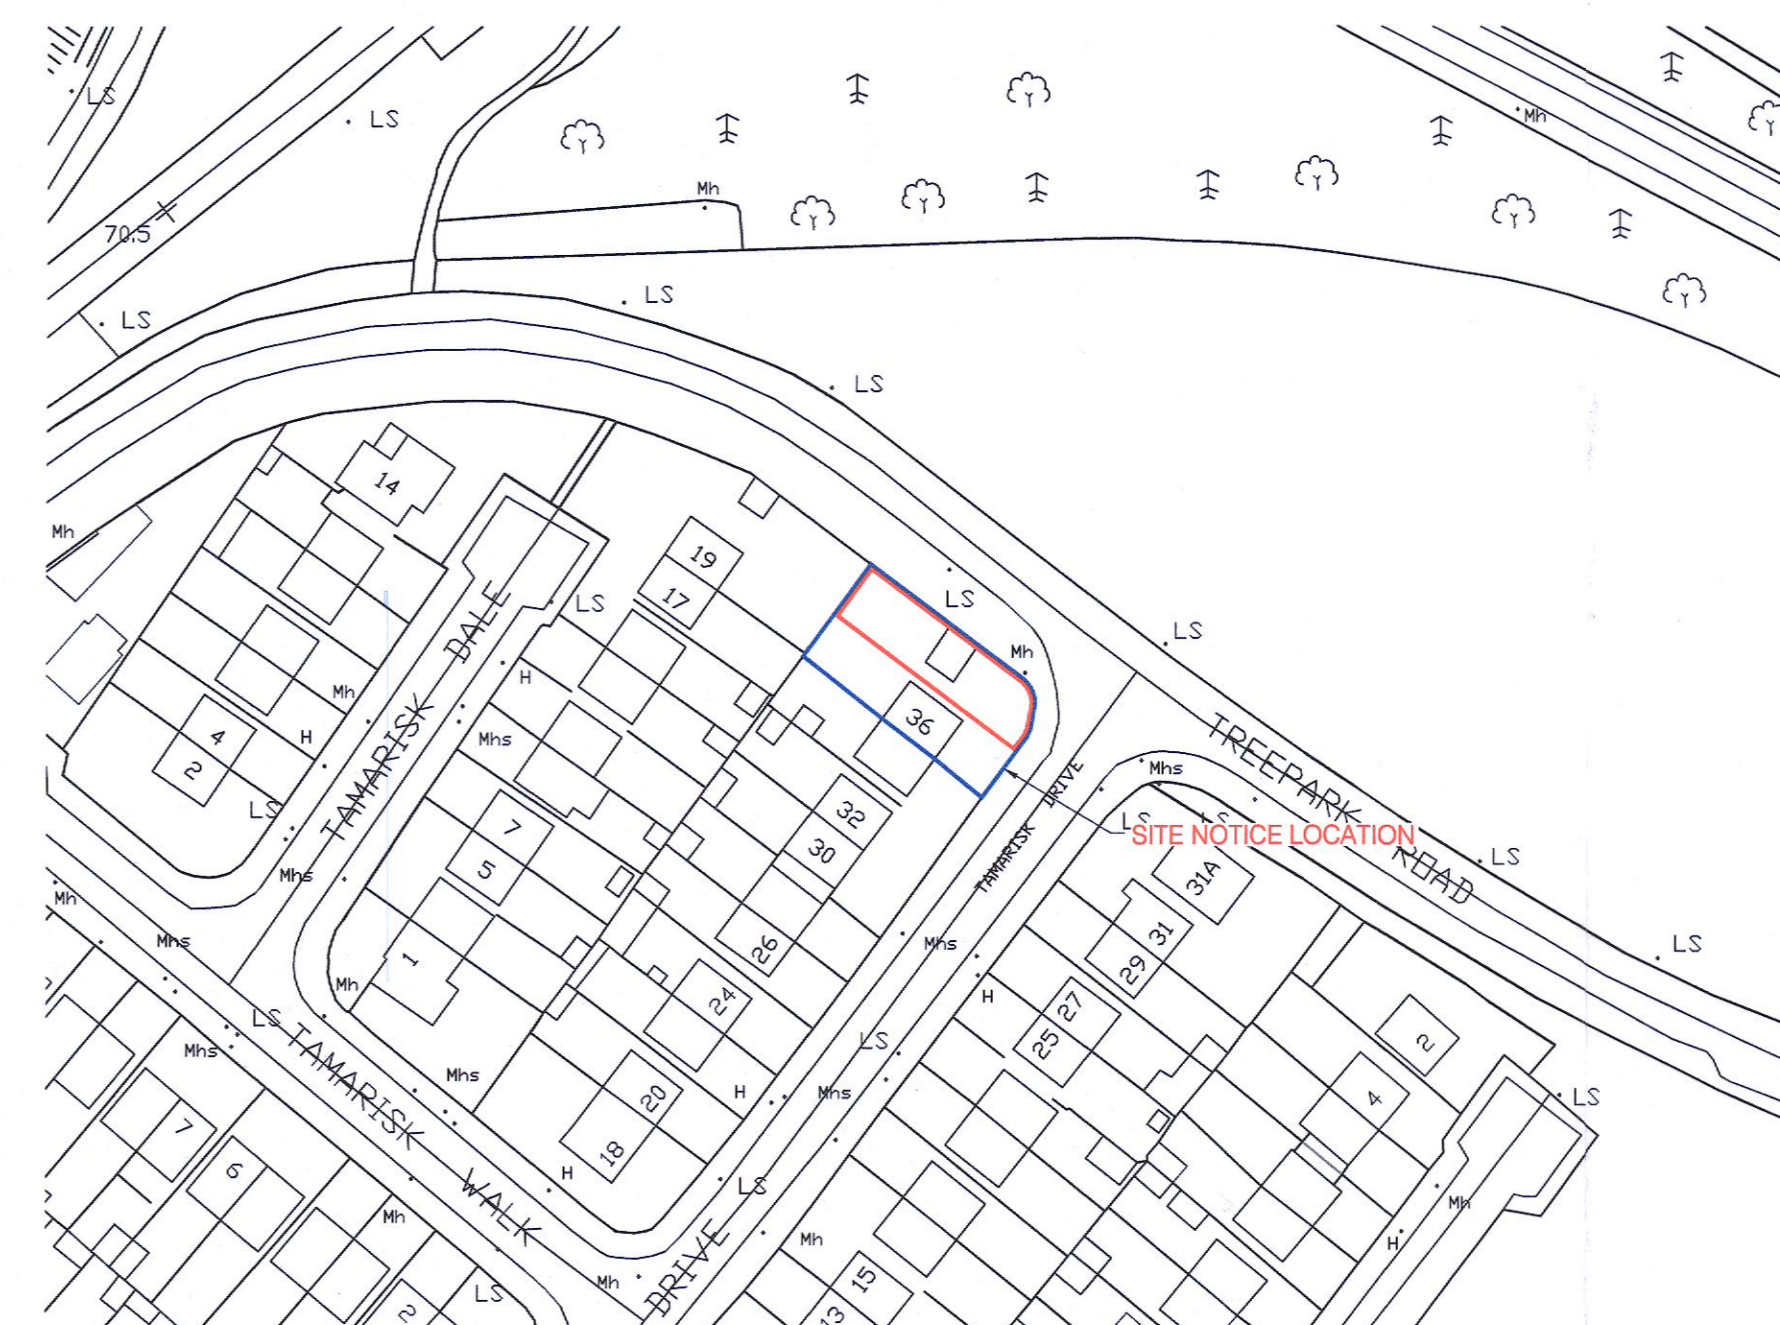

SITE LOCATION MAP

Scale 1:1000

OS SHEET NUMBER: 3327-17, 3327-18, 3327-22 & 3327-23
© Ordnance Survey Ireland / Government of Ireland

LEGEND:

- Denotes new surface water manhole
- ♦ Denotes new surface water access junction
- Denotes new surface water line
- Denotes RWP + BGT
- Denotes new foul water manhole
- Denotes new foul water access junction
- - - Denotes new foul water line

NOTES:

- This drawing to be read in conjunction with all relevant Architects and Engineers drawings.
- Do not scale drawing.
- All dimensions in millimeters unless otherwise stated.
- Refer to Architects drawings for setting dimensions and finishing details.
- All dimensions and setting out to be confirmed and checked with Architects drawings. Any discrepancies to be disclosed to architects and Engineers office.
- All building works to comply with current building regulations.

Rev	Revision description	Date	Drawn	Design	Check
A	Issued for Planning	APR 2022	KD	RMF	RMF

Job Title:
**36 TAMARISK DRIVE
KILNAMANAGH
DUBLIN 24
D24 PHR2**

Drawing Title:
**SITE LOCATION
MAP, SITE LAYOUT
& DRAINAGE PLANS**

Client:
DENIS MORGAN

Drawing number:
420/22/01

Scale:
**A1 @ 1:200
& 1:1000**

Date:
JULY 22

Robert M Foley & Associates

4 Robinhood Park
Clondalkin
Dublin 22
D22 H923
Tel : 083 130 5081
email: rmfolydesign@gmail.com

