


DO NOT SCALE DRAWING

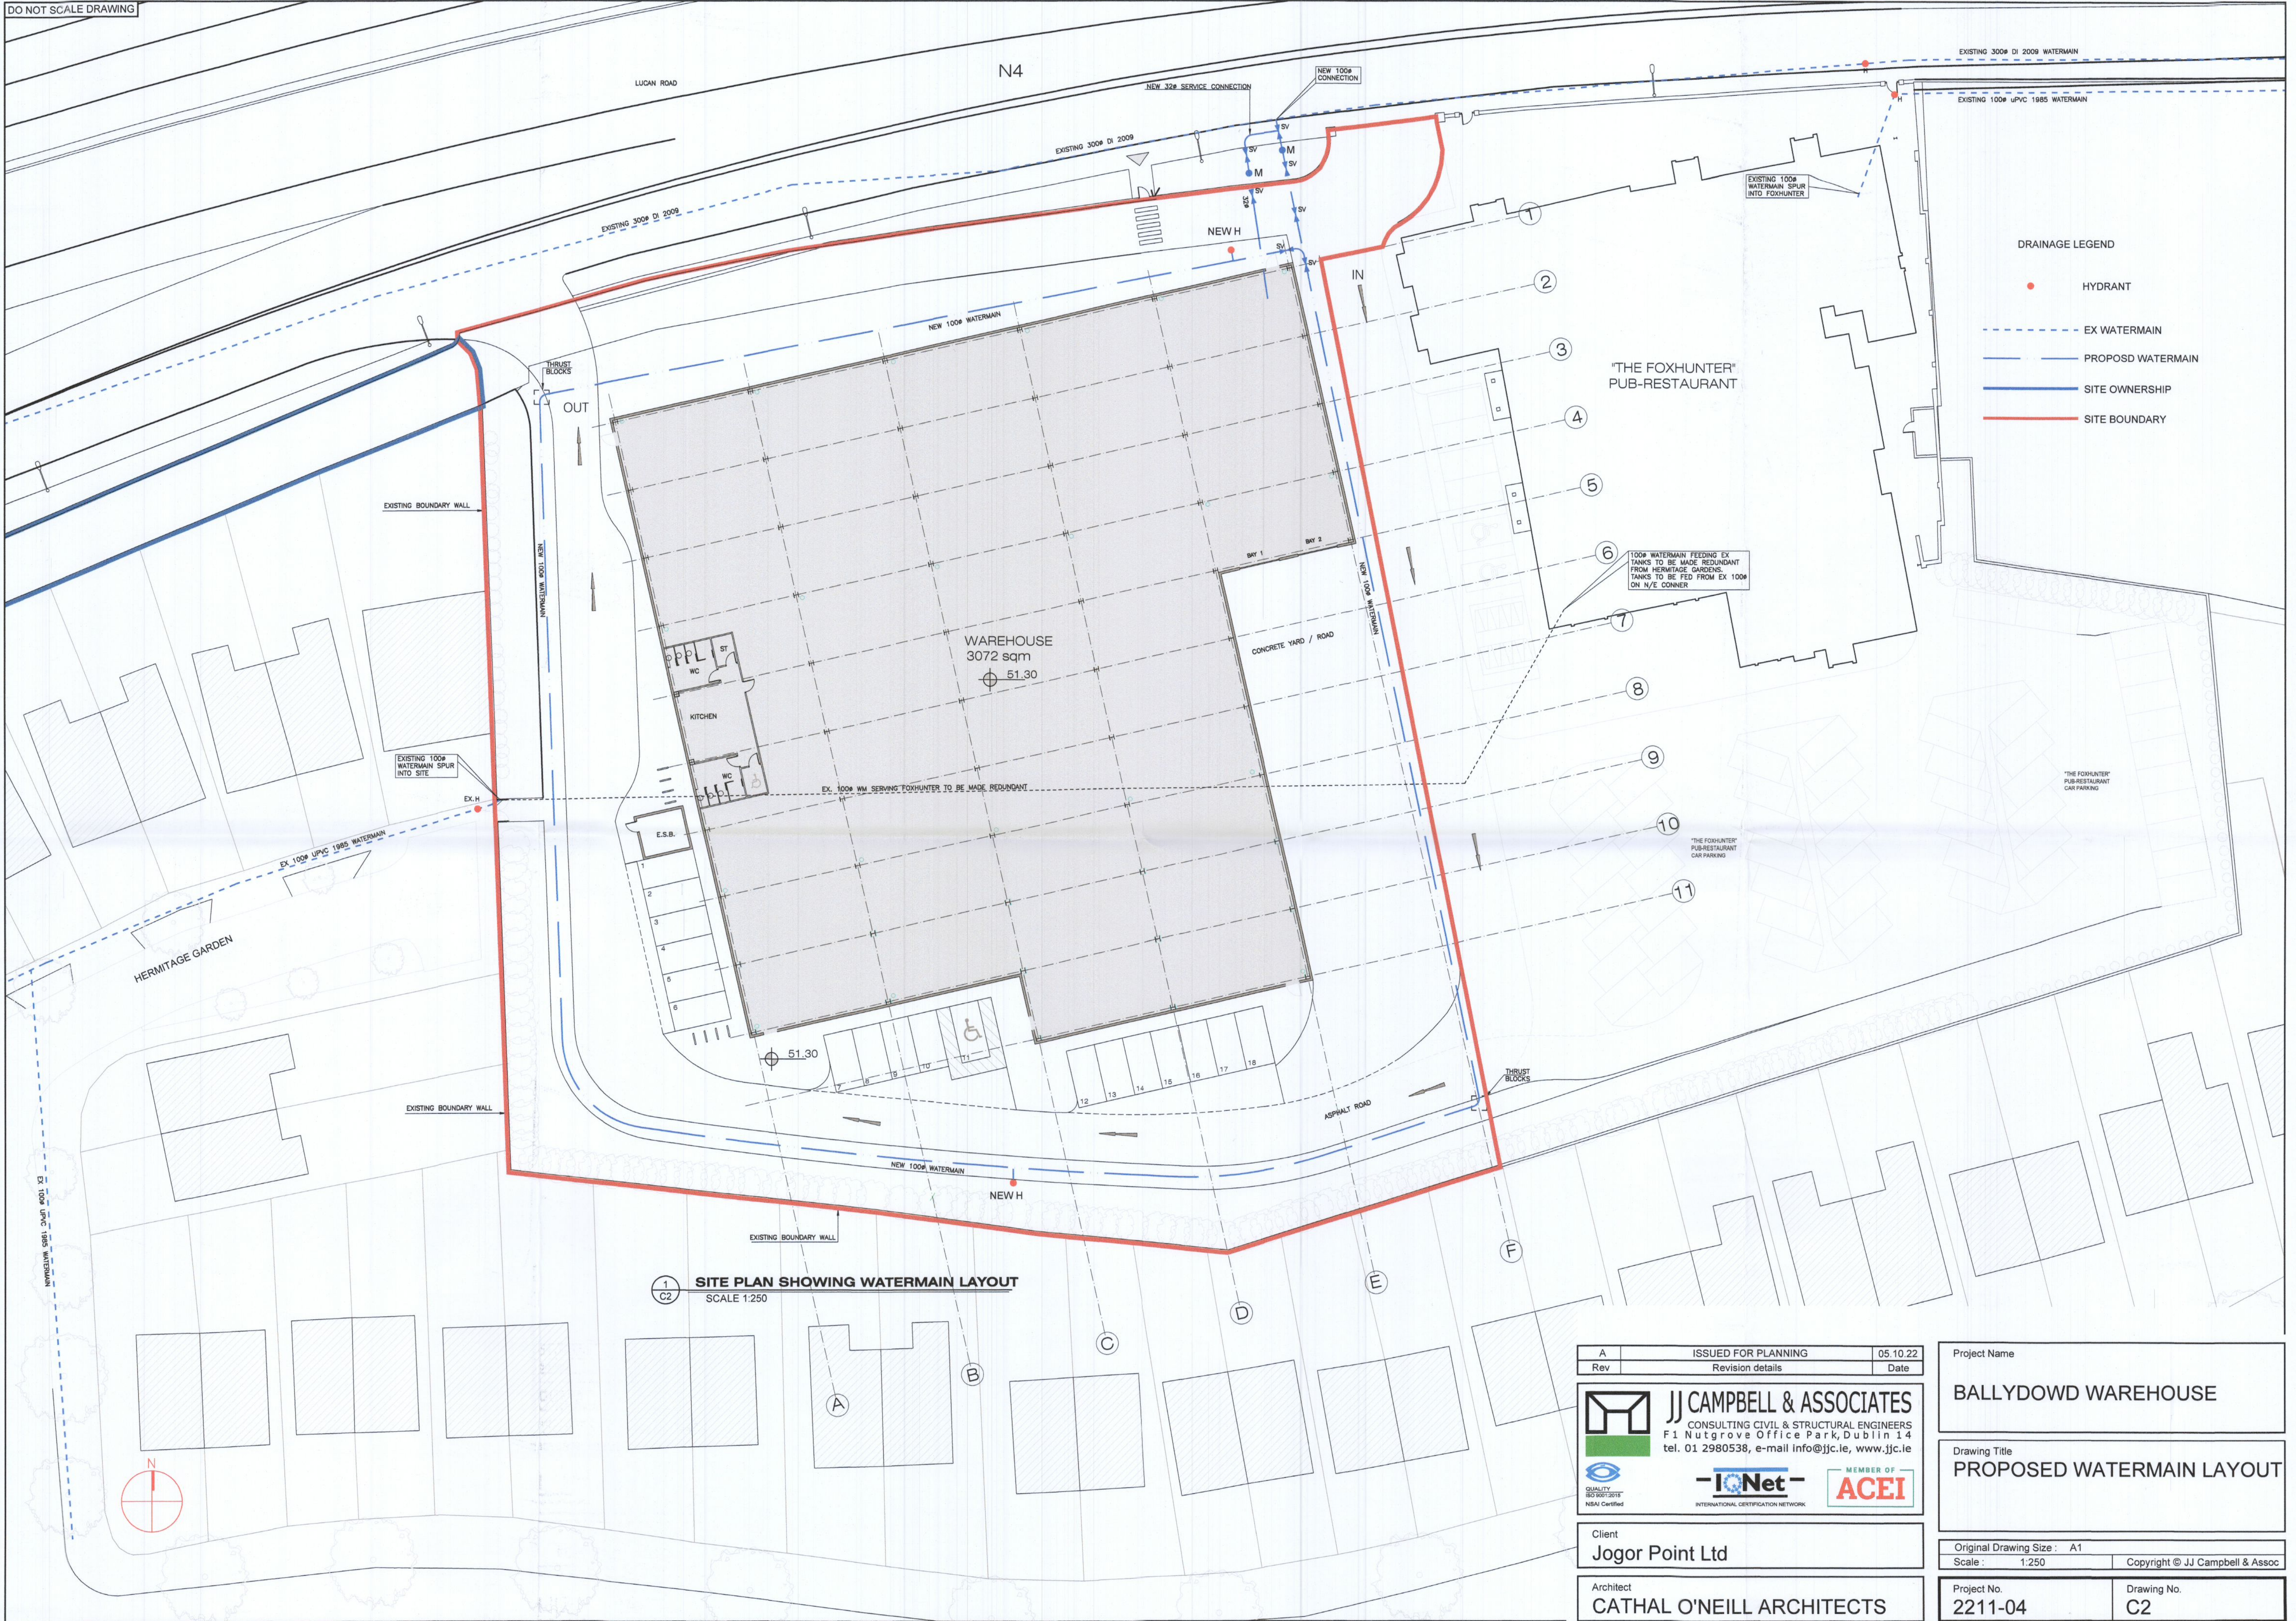

- DRAINAGE LEGEND**
- HYDRANT
 - - - EX WATERMAIN
 - PROPOSD WATERMAIN
 - SITE OWNERSHIP
 - SITE BOUNDARY

SITE PLAN SHOWING WATERMAIN LAYOUT
SCALE 1:250

A	ISSUED FOR PLANNING	05.10.22
Rev	Revision details	Date

JJ CAMPBELL & ASSOCIATES
CONSULTING CIVIL & STRUCTURAL ENGINEERS
F1 Nutgrove Office Park, Dublin 14
tel. 01 2980538, e-mail info@jjc.ie, www.jjc.ie

QUALITY ISO 9001:2015
NSAI Certified

IONet
INTERNATIONAL CERTIFICATION NETWORK

MEMBER OF **ACEI**

Client
Jogor Point Ltd

Architect
CATHAL O'NEILL ARCHITECTS

Project Name
BALLYDOWD WAREHOUSE

Drawing Title
PROPOSED WATERMAIN LAYOUT

Original Drawing Size : A1
Scale : 1:250 Copyright © JJ Campbell & Assoc

Project No.
2211-04

Drawing No.
C2