


PAIRC GLEANN TRASNA

Proposed Block Plan & Drainage Layout
SCALE 1:200

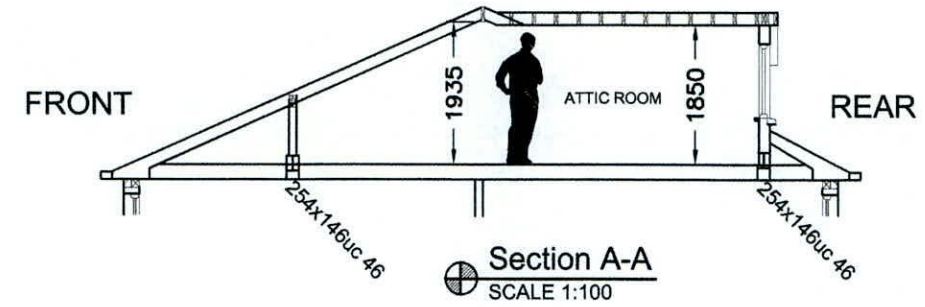

Section A-A
SCALE 1:100

DRAINAGE LEGEND

	PROPOSED 150mm UPVC SURFACE WATER PIPE
	PROPOSED 150mm UPVC FOUL SEWER PIPE
	EXISTING SURFACE WATER PIPE
	EXISTING FOUL SEWER PIPE

P	ISSUED FOR PLANNING	ND	Sept' 2022
REV:	REVISION TITLE:	DRN:	CHD: DATE:

Issued for Planning

THIS DRAWING IS ISSUED FOR PLANNING PERMISSION ONLY, AND IS NOT A CONSTRUCTION DRAWING

AA Architecture

4 CARRIGMORE CLOSE, AYLESBURY,
Dublin 24 - Ph: 01 4148358

CLIENT: **Ryan Cassidy & Lisa Cunniffe**
JOB TITLE: **PROPOSED WORKS AT 35 PAIRC GLEANN TRASNA, AYLESBURY, TALLAGHT, DUBLIN 24**

TITLE: **PROPOSED BLOCK PLAN, DRAINAGE LAYOUT & SECTION A-A**

SCALE: As Shown INITIALS: ND DATE: Sept' 2022

JOB No: S283 DRAWING No: 004 REV: P

NOTES:
This drawing is to be read in conjunction with all relevant Engineers drawings.
Do not scale use figured dimensions ONLY.
All dimensions in millimeters unless otherwise stated.
All dimensions to be checked on site.
All building works to comply with current building regulations & in accordance with Homebond Standards.