




Proposed Block Plan & Drainage Layout
SCALE 1:200

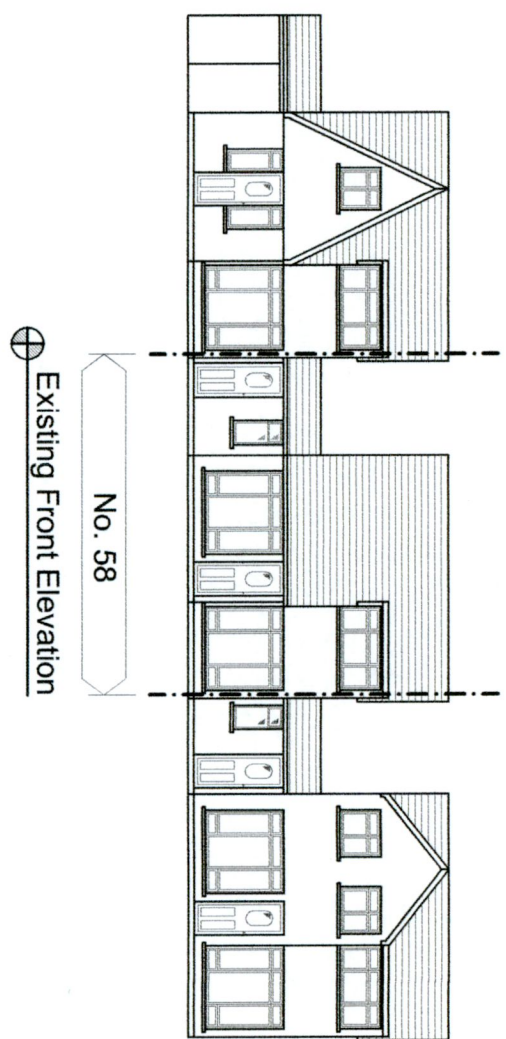

Existing Front Elevation
No. 58

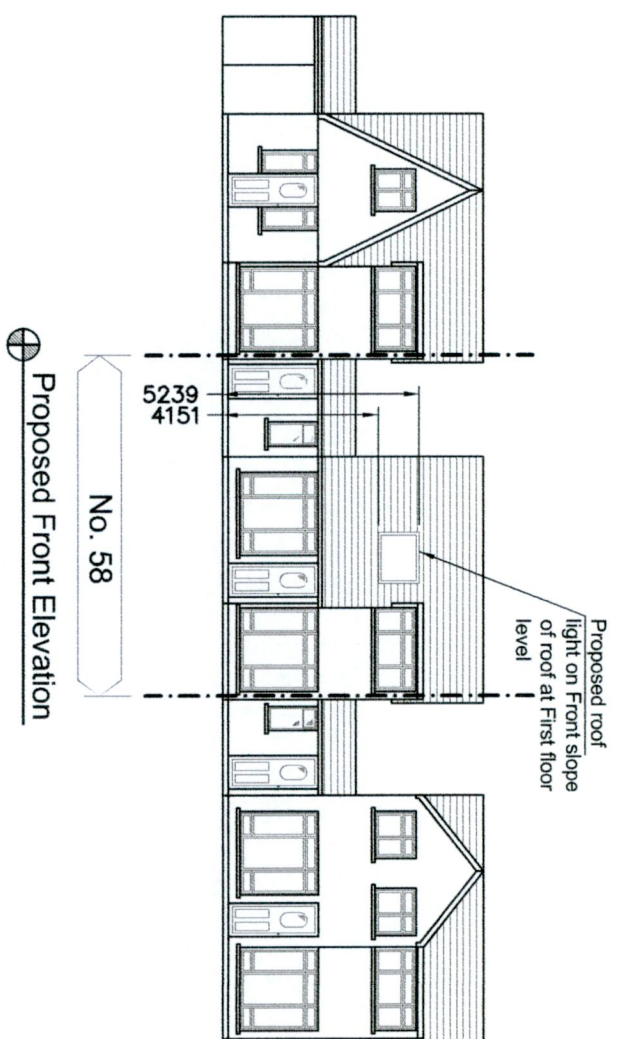

Proposed Front Elevation
No. 58

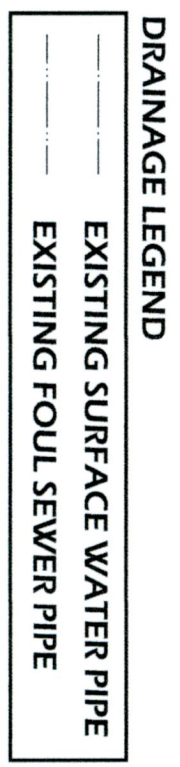

Issued for Planning

CLIENT: Linda Leonard

JOB TITLE: PROPOSED WORKS AT 58 MONASTERY DRIVE,
CLONDALKIN, DUBLIN 22

P	ISSUED FOR PLANNING	ND	Sept' 2022
REV:	REVISION TITLE:	DRN:	CHD:
		DATE:	

AA Architecture

4 CARRIGMORE CLOSE, AYLESBURY,
Dublin 24 - Ph: 01 4148358

TITLE: EXISTING, PROPOSED ELEVATIONS
& BLOCK PLAN, DRAINAGE
LAYOUT

SCALE:	INITIALS:	DATE:
1:200	ND	Sept' 2022
JOB No: S284	DRAWING No: 003	REV: P

NOTES:

This drawing is to be read in conjunction with all relevant Engineers drawings.
Do not scale use figured dimensions ONLY.
All dimensions in millimeters unless otherwise stated.
All dimensions to be checked on site.
All building works to comply with current building regulations & in accordance with Homebond Standards.

THIS DRAWING IS ISSUED FOR PLANNING PERMISSION ONLY, AND IS NOT A CONSTRUCTION DRAWING