



03-A
P009
Site Section 03 - Part 1
1:200 @ A1

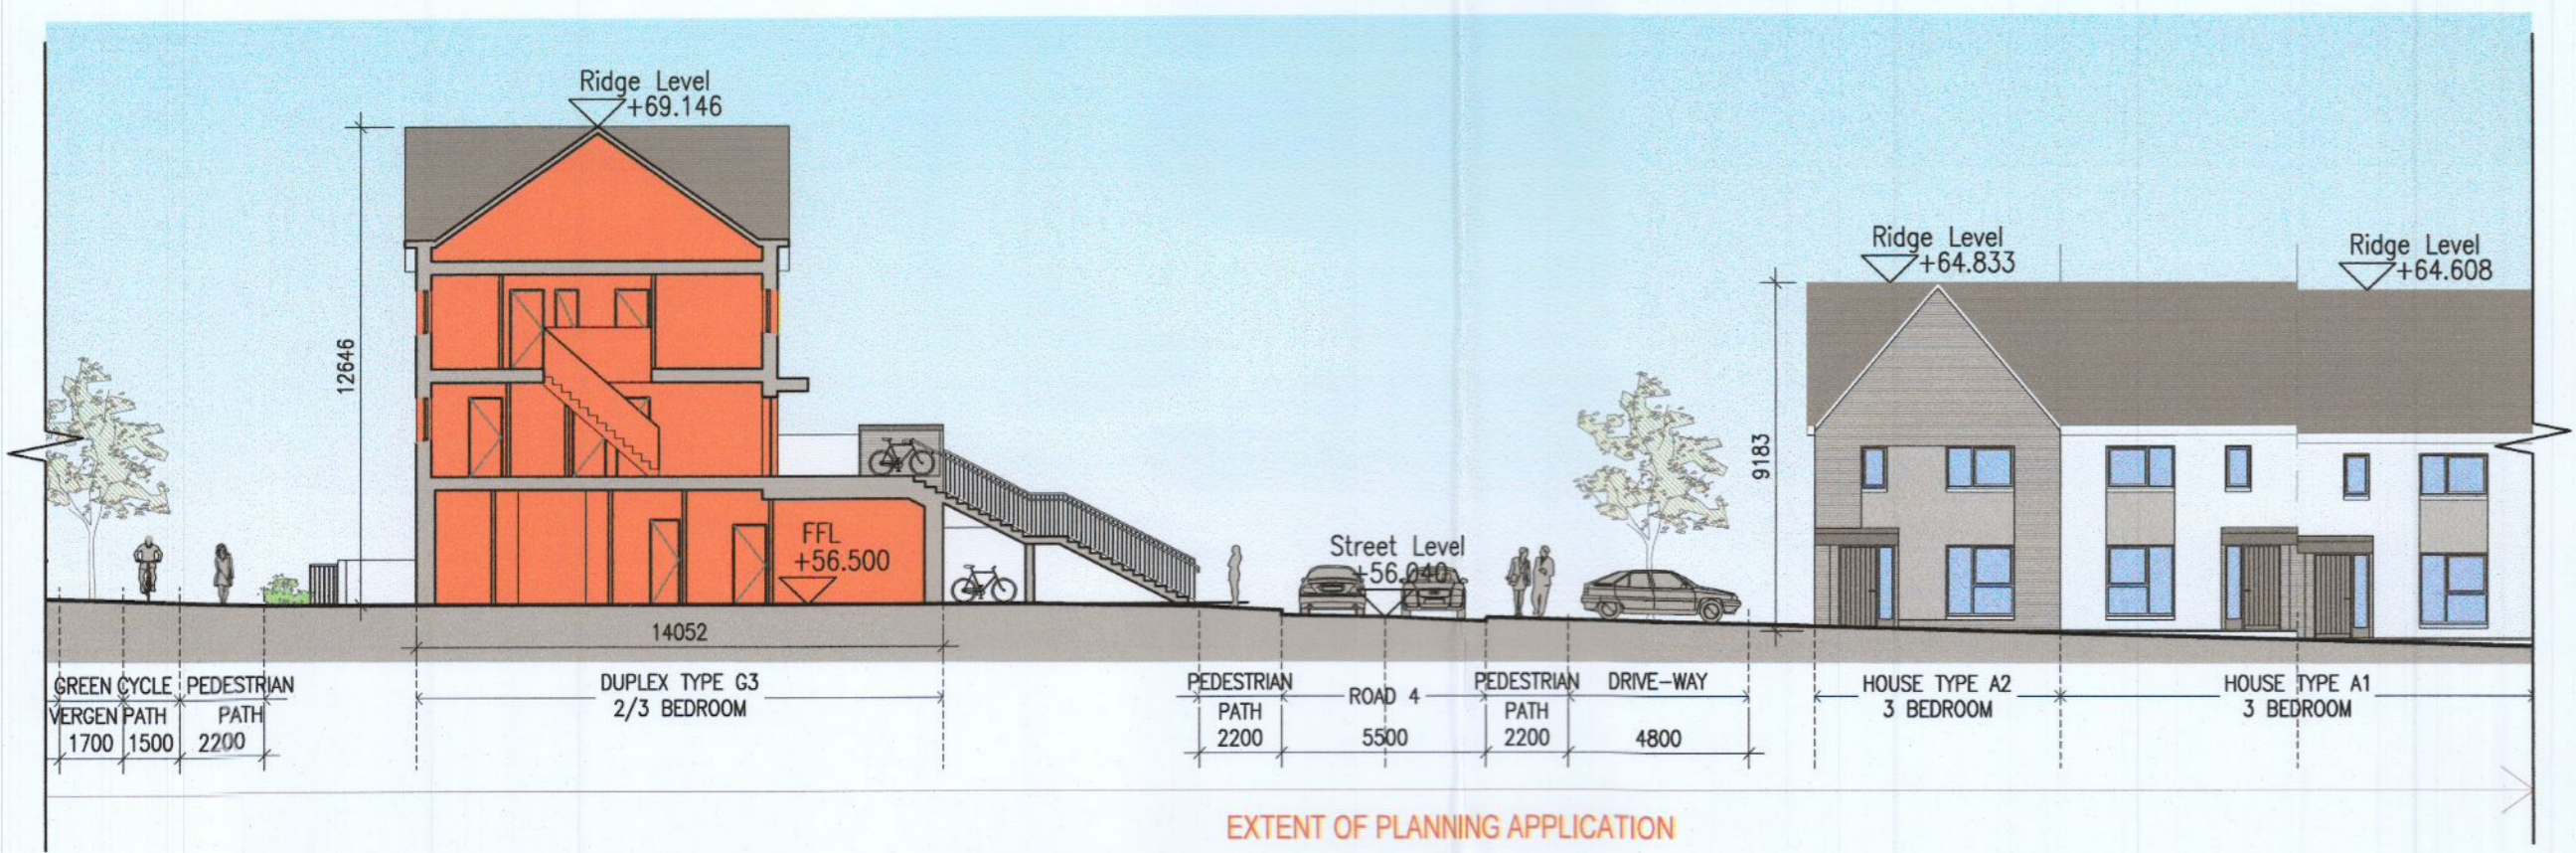

03-B
P009
Site Section 03 - Part 2
1:200 @ A1

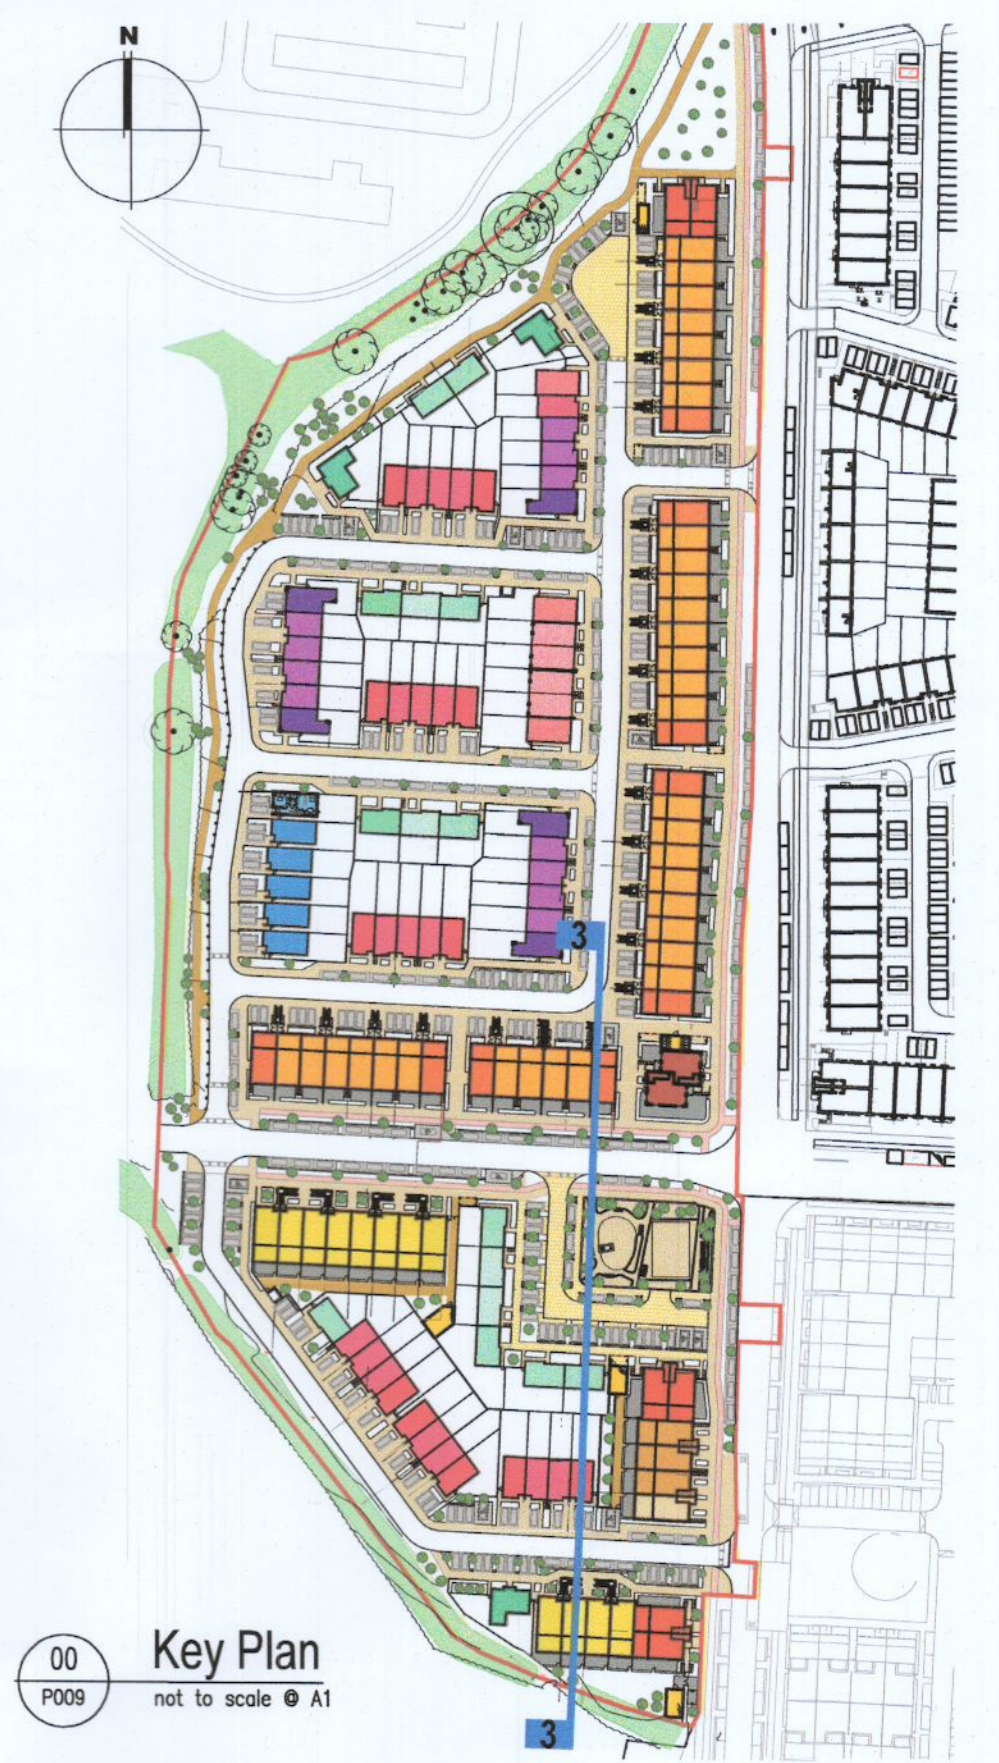

- Notes**
1. Copyright Reserved
 2. Work to figure dimensions only. Do not scale drawing.
 3. The contractor is responsible for checking all levels and dimensions on site and shall refer all discrepancies to the Architect
 4. Where appropriate, for details of r.c. structure, or mechanical and electrical details, see Engineers drawings
 5. Proprietary items shall be fixed in strict accordance with manufacturers instructions.
 6. Sizes of proprietary items shall be checked with manufacturers.
 7. The contractor shall be responsible for the coordination of structure, finishes and services.

Issue Status	No.	Date	Revision	Initials
Progress	01	14.10.2022	ISSUED FOR PLANNING	JN
Planning Application				
Fire Cert				
Disability Cert				
Tender				
Construction				
As Built				
Information Only				

Project		Aderrig Phase 3 Adamstown SDZ	
Drawing Title		Residential Development	
Drawing No		6259A-P-009	
Scale	1:200 @A1	Rev	01
Drawn	ED	Date	28/09/2022

6-7 HARCOURT TERRACE, DUBLIN 2, IRELAND
t +353 1 610 2400 f +353 1 670 7305
e architecture@bkd.ie
www.bkd.ie

bkd architects
BURKE-KENNEDY DOYLE