




DUPLEX TYPE J2 HANDED

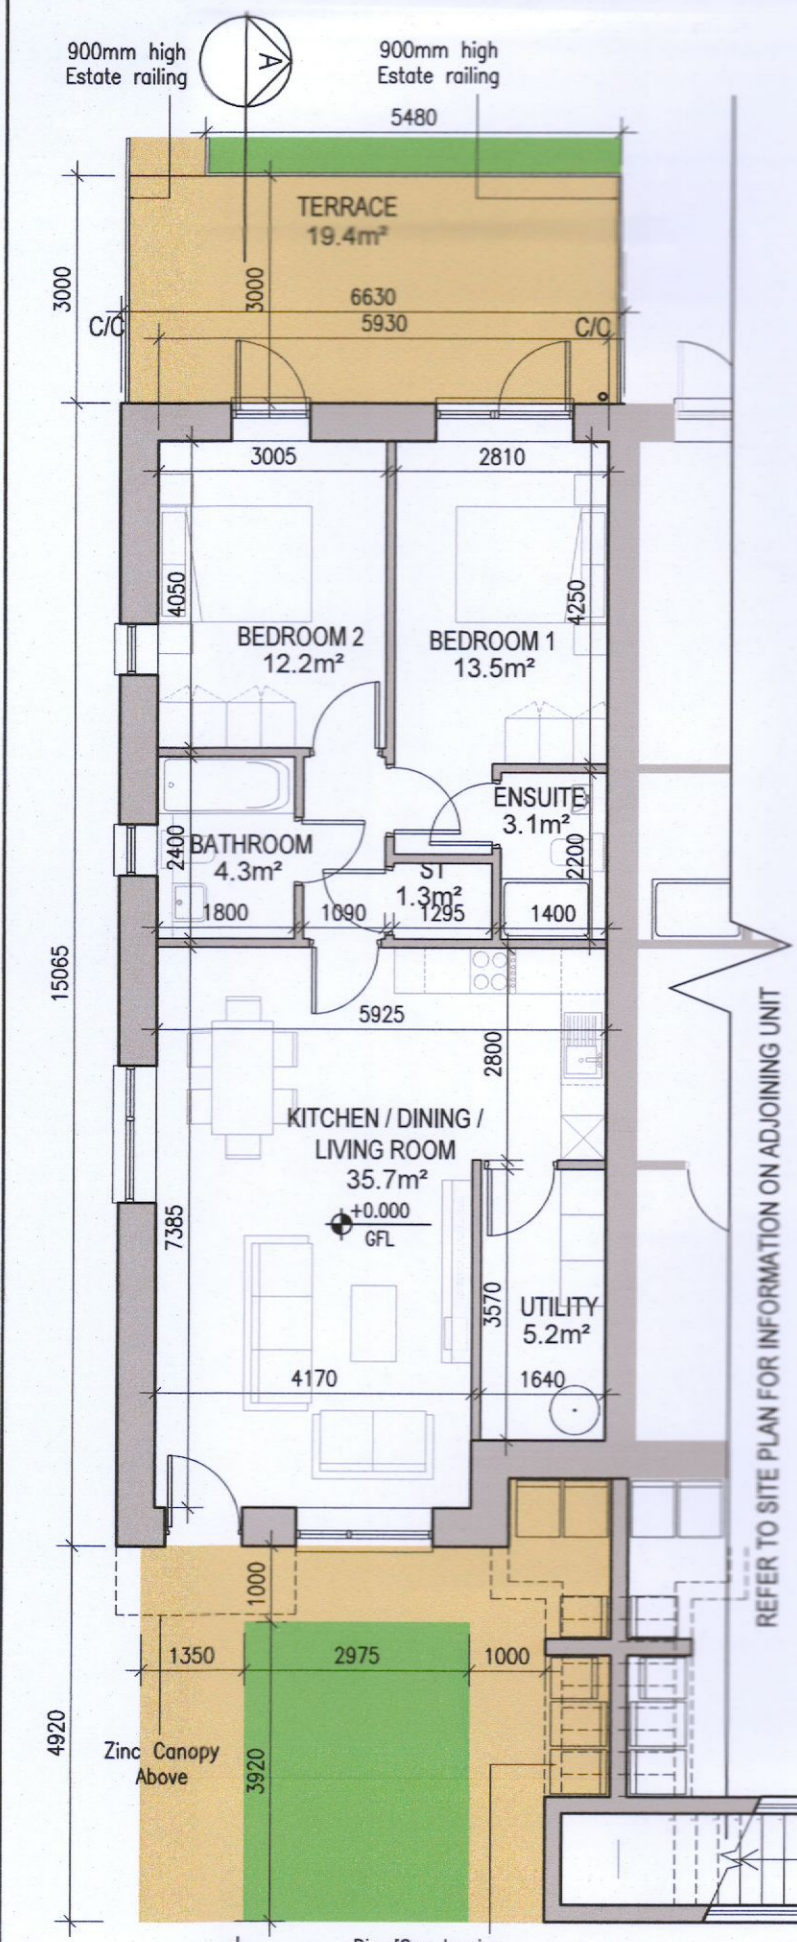


01 Ground Floor Plan [J2.A]
1:100@A1

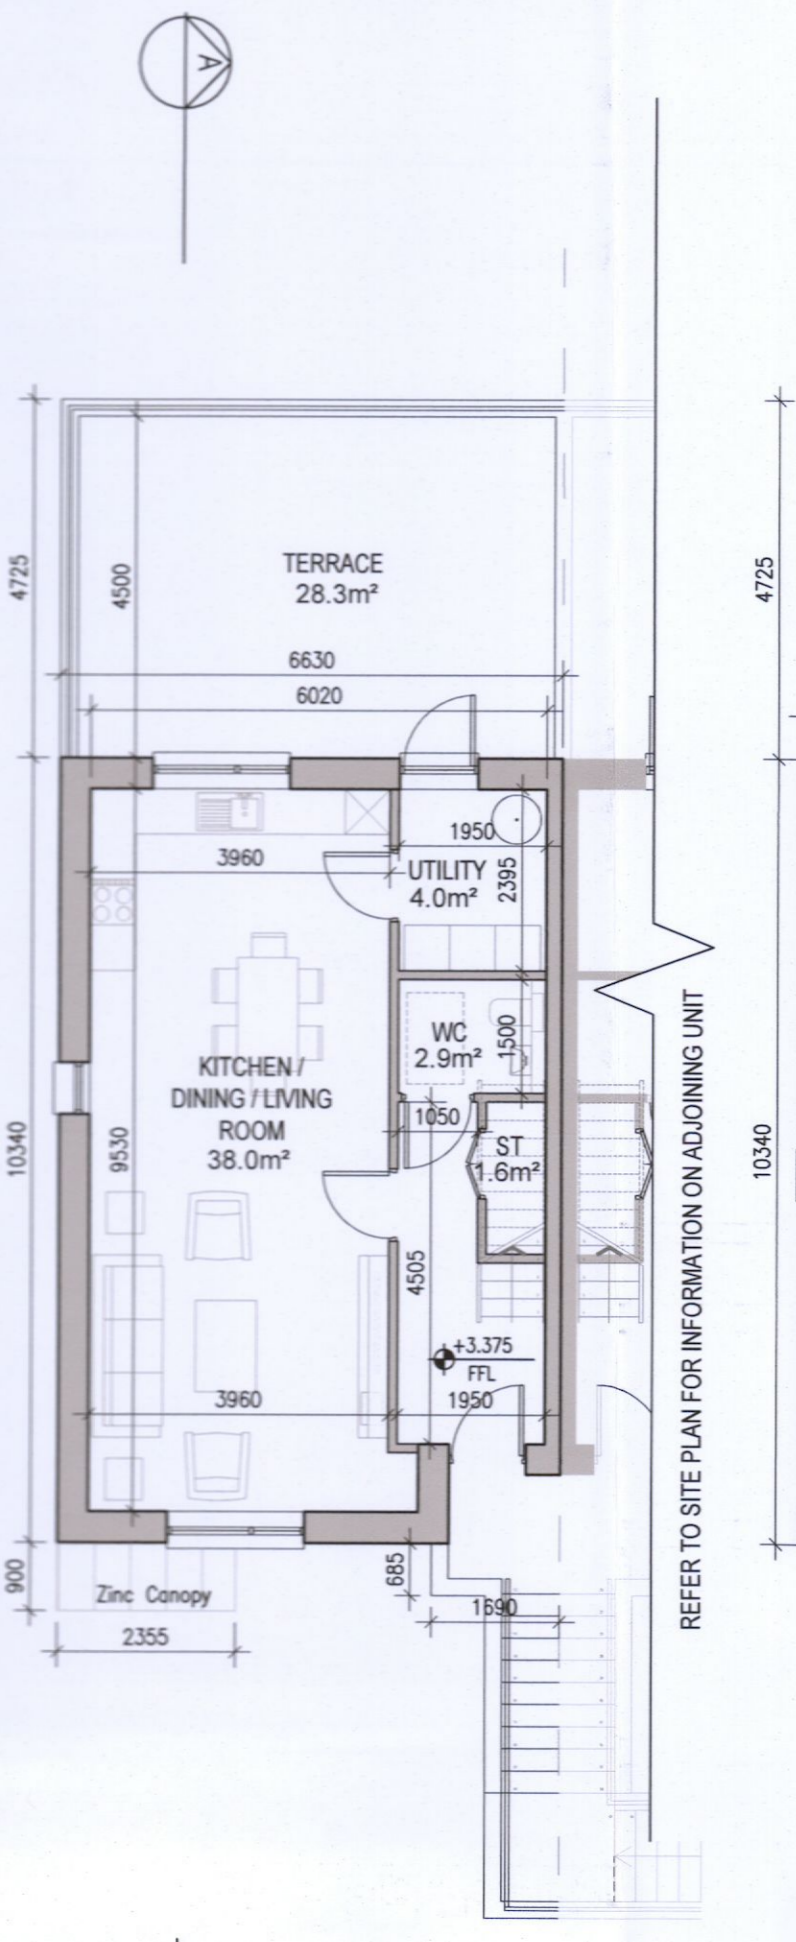


02 First Floor Plan [J2.B]
1:100@A1

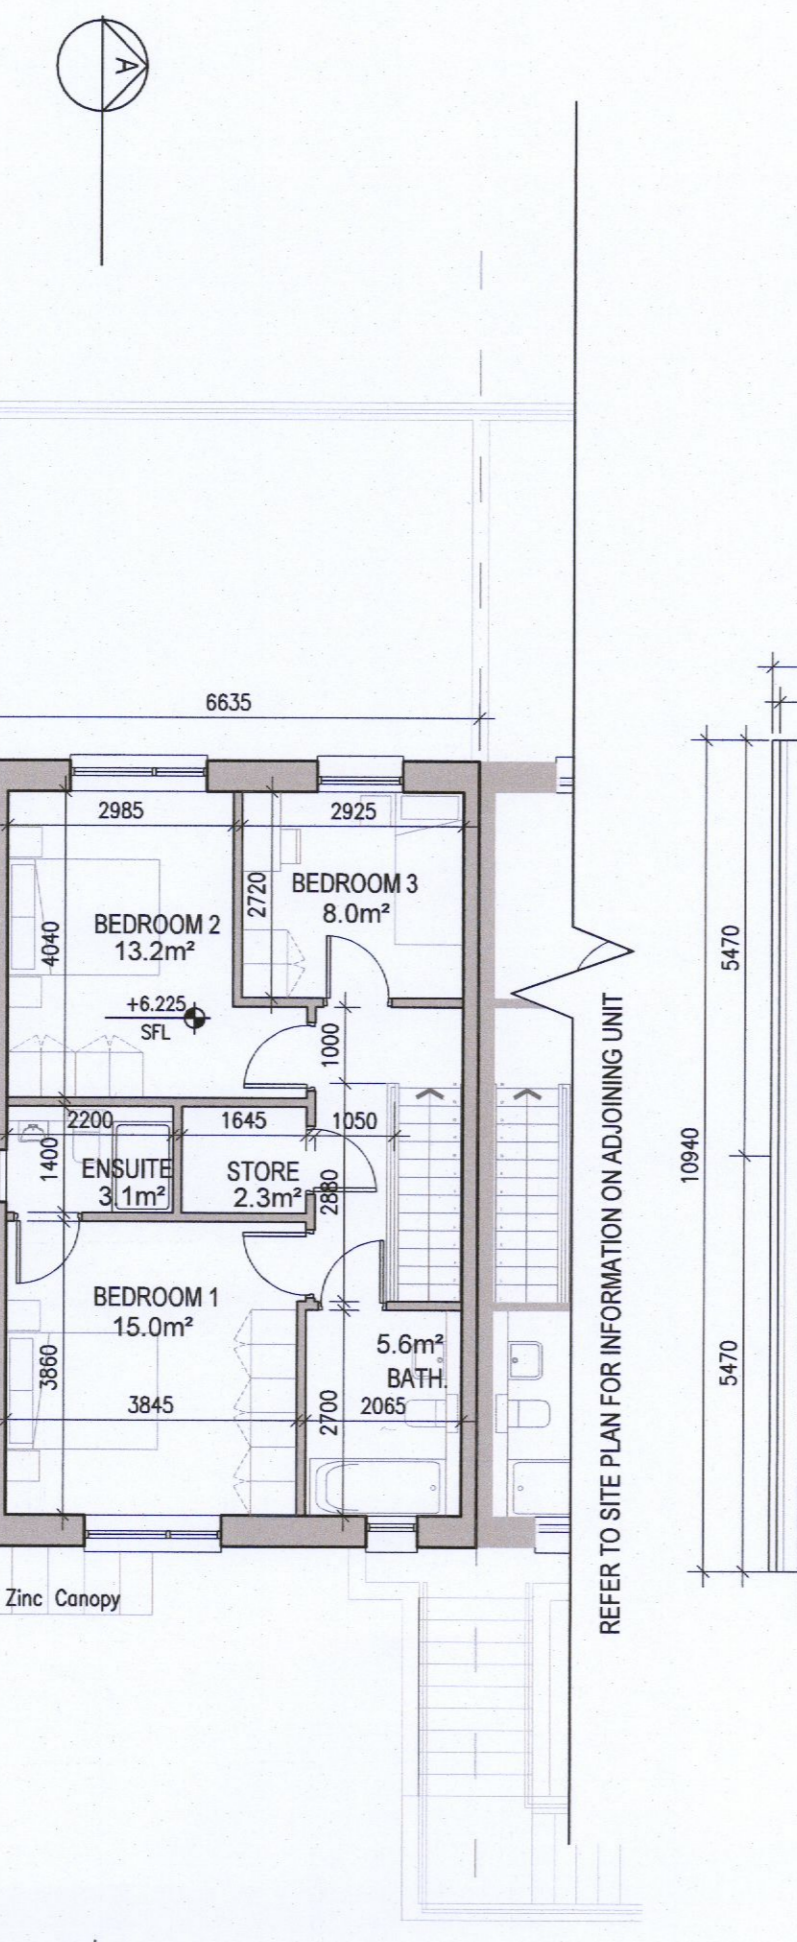

03 Second Floor Plan [J2.B]
1:100@A1

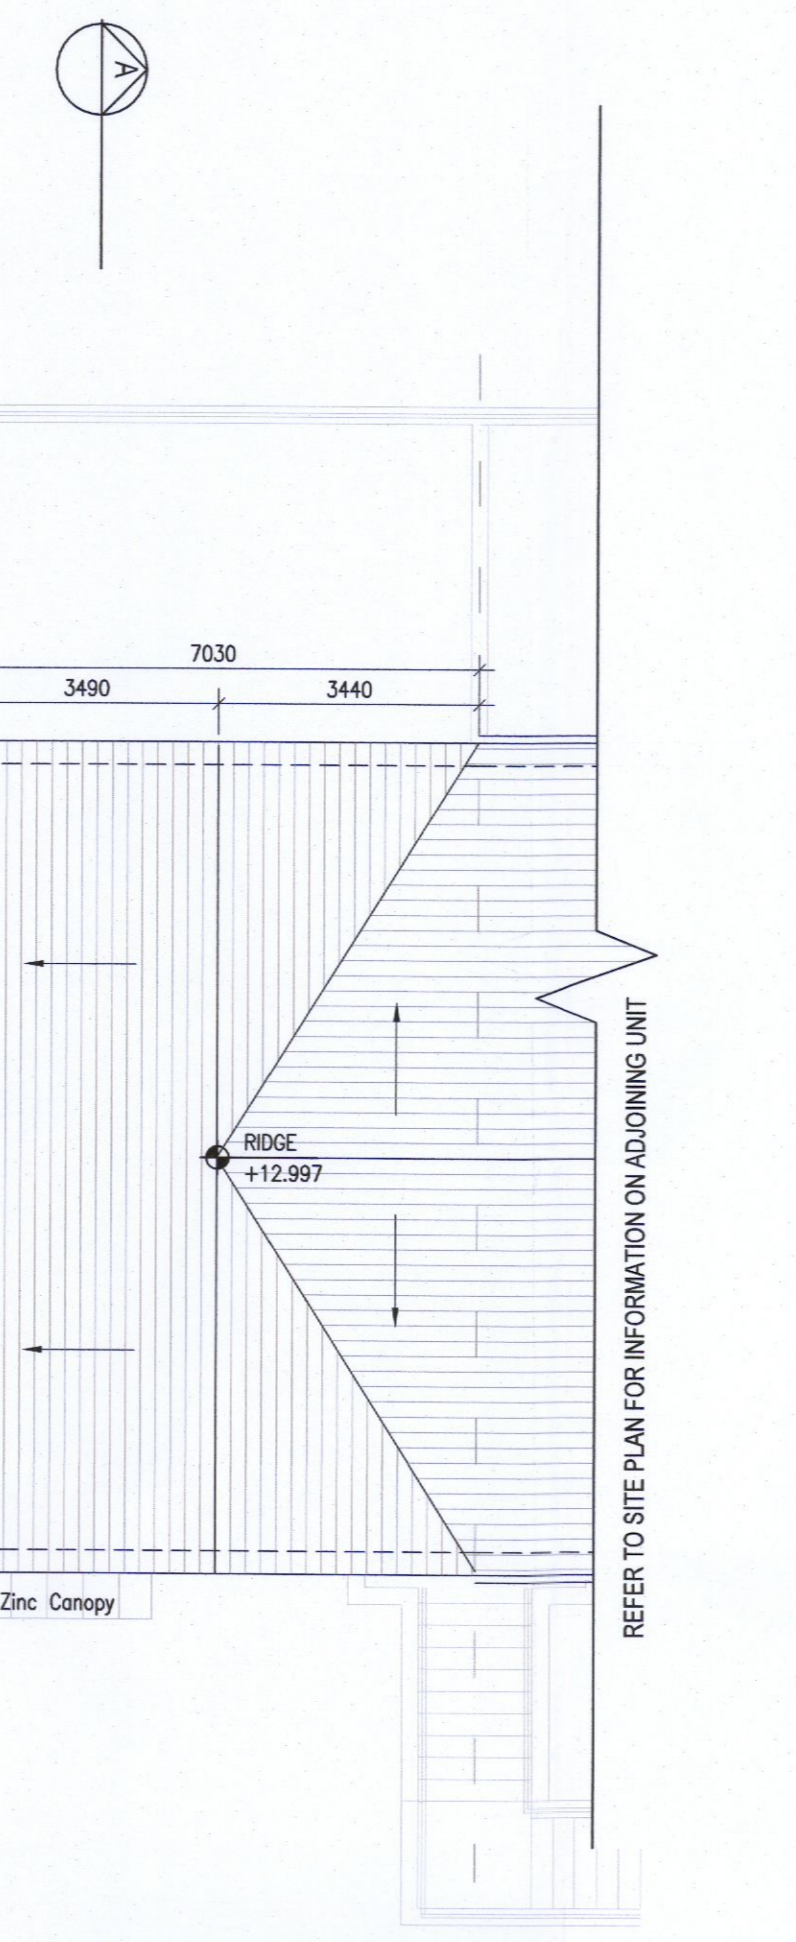

04 Roof Floor Plan
1:100@A1

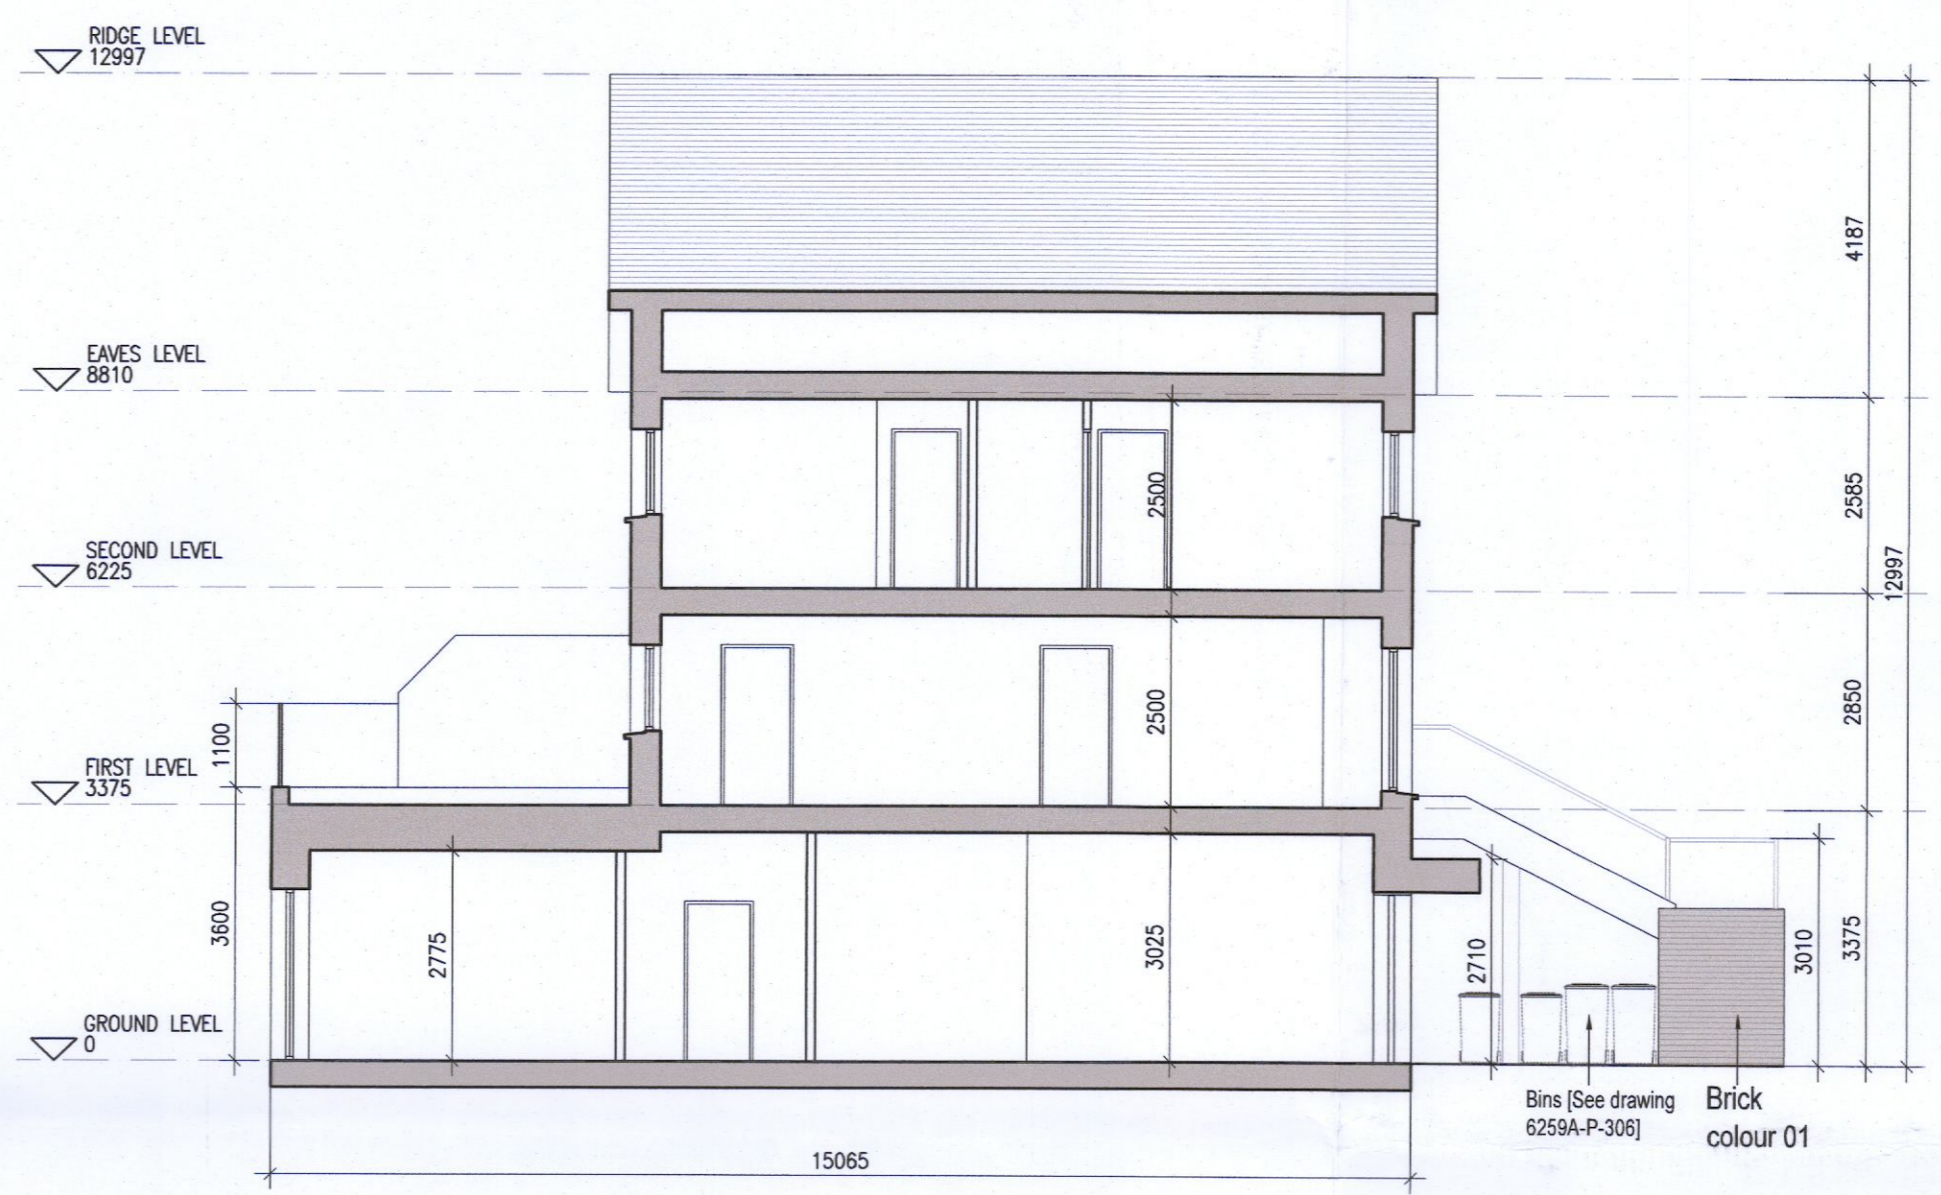

05 Typical Section [A-A]
1:100@A1




KEY PLAN [NTS]


HOUSE TYPES	No. OF UNITS
Type A1/A2 - 3 bed	16
Type B1/B2 - 3 bed	28
Type C1/C2/C3 - 3 bed	15
Type D - 4 bed	3
Type E1/E2 - 4 bed	7
Type K1/K2 - 4 bed	6
TOTAL	75

DUPLEX	No. OF UNITS
Type F1 - 2 bed	3
Type F2 - 3 bed	3
Type F3 - 2 bed	1
Type F3 - 3 bed	1
Type F3 - 4 bed	6
Type G1 - 2 bed	33
Type G2 - 3 bed	33
Type G2 - 2 bed	2
Type G3 - 3 bed	2
Type G3 - 2 bed	7
Type G3 - 4 bed	7
Type H1/H2 - 3 bed	2
Type H1/H2 - 4 bed	2
Type J1 - 2 bed	9
Type J2 - 3 bed	9
Type J2 - 2 bed	3
Type J2 - 3 bed	3
TOTAL NO. OF UNITS	132


TOTAL NO. OF UNITS 207

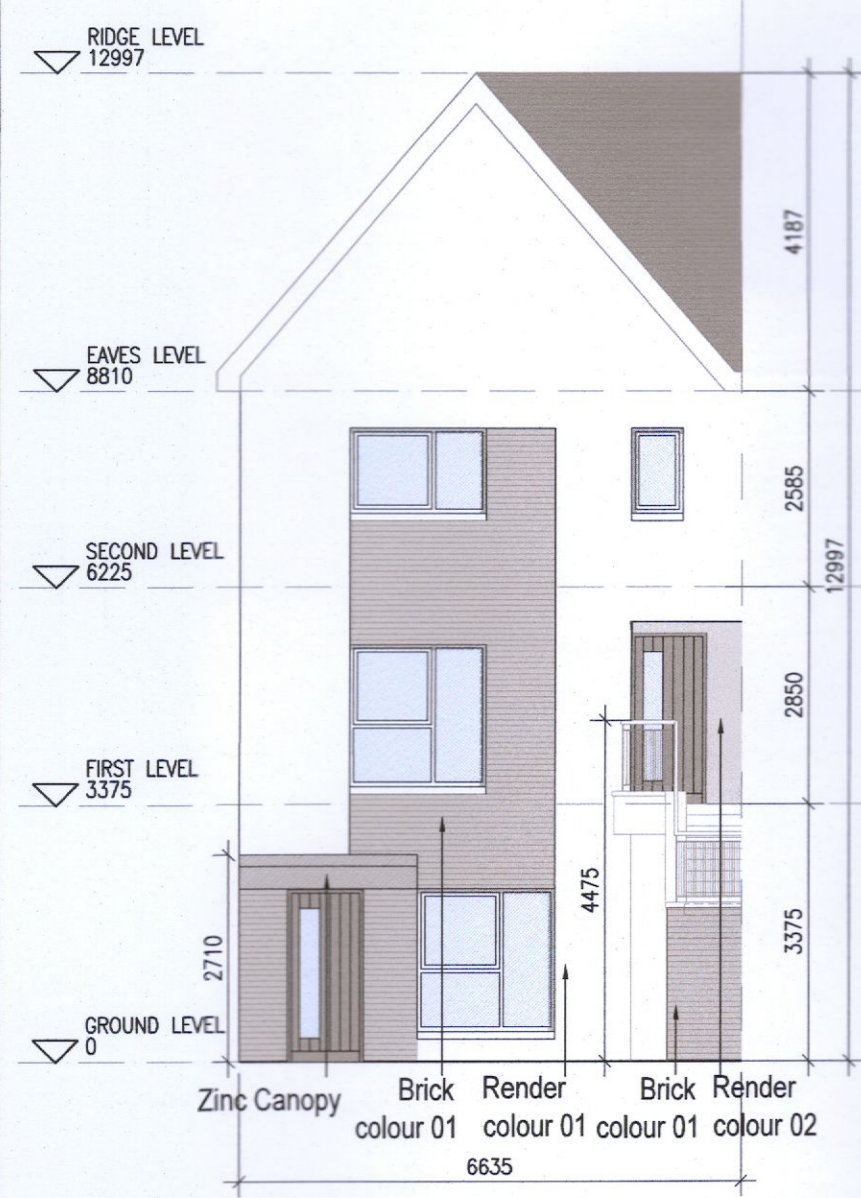

08 Front Elevation J2.1
1:100@A1

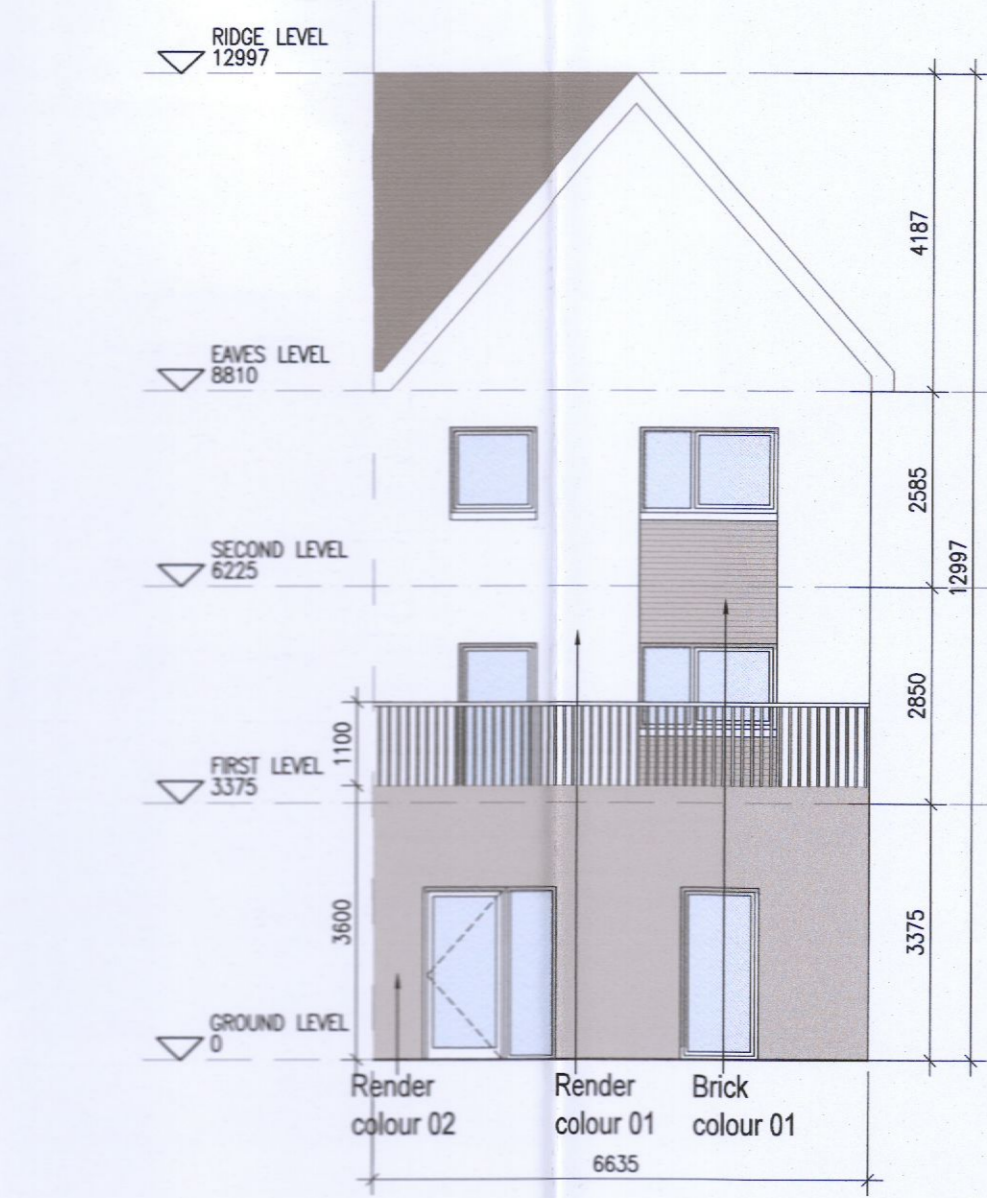

09 Rear Elevation [V2]
1:100@A1

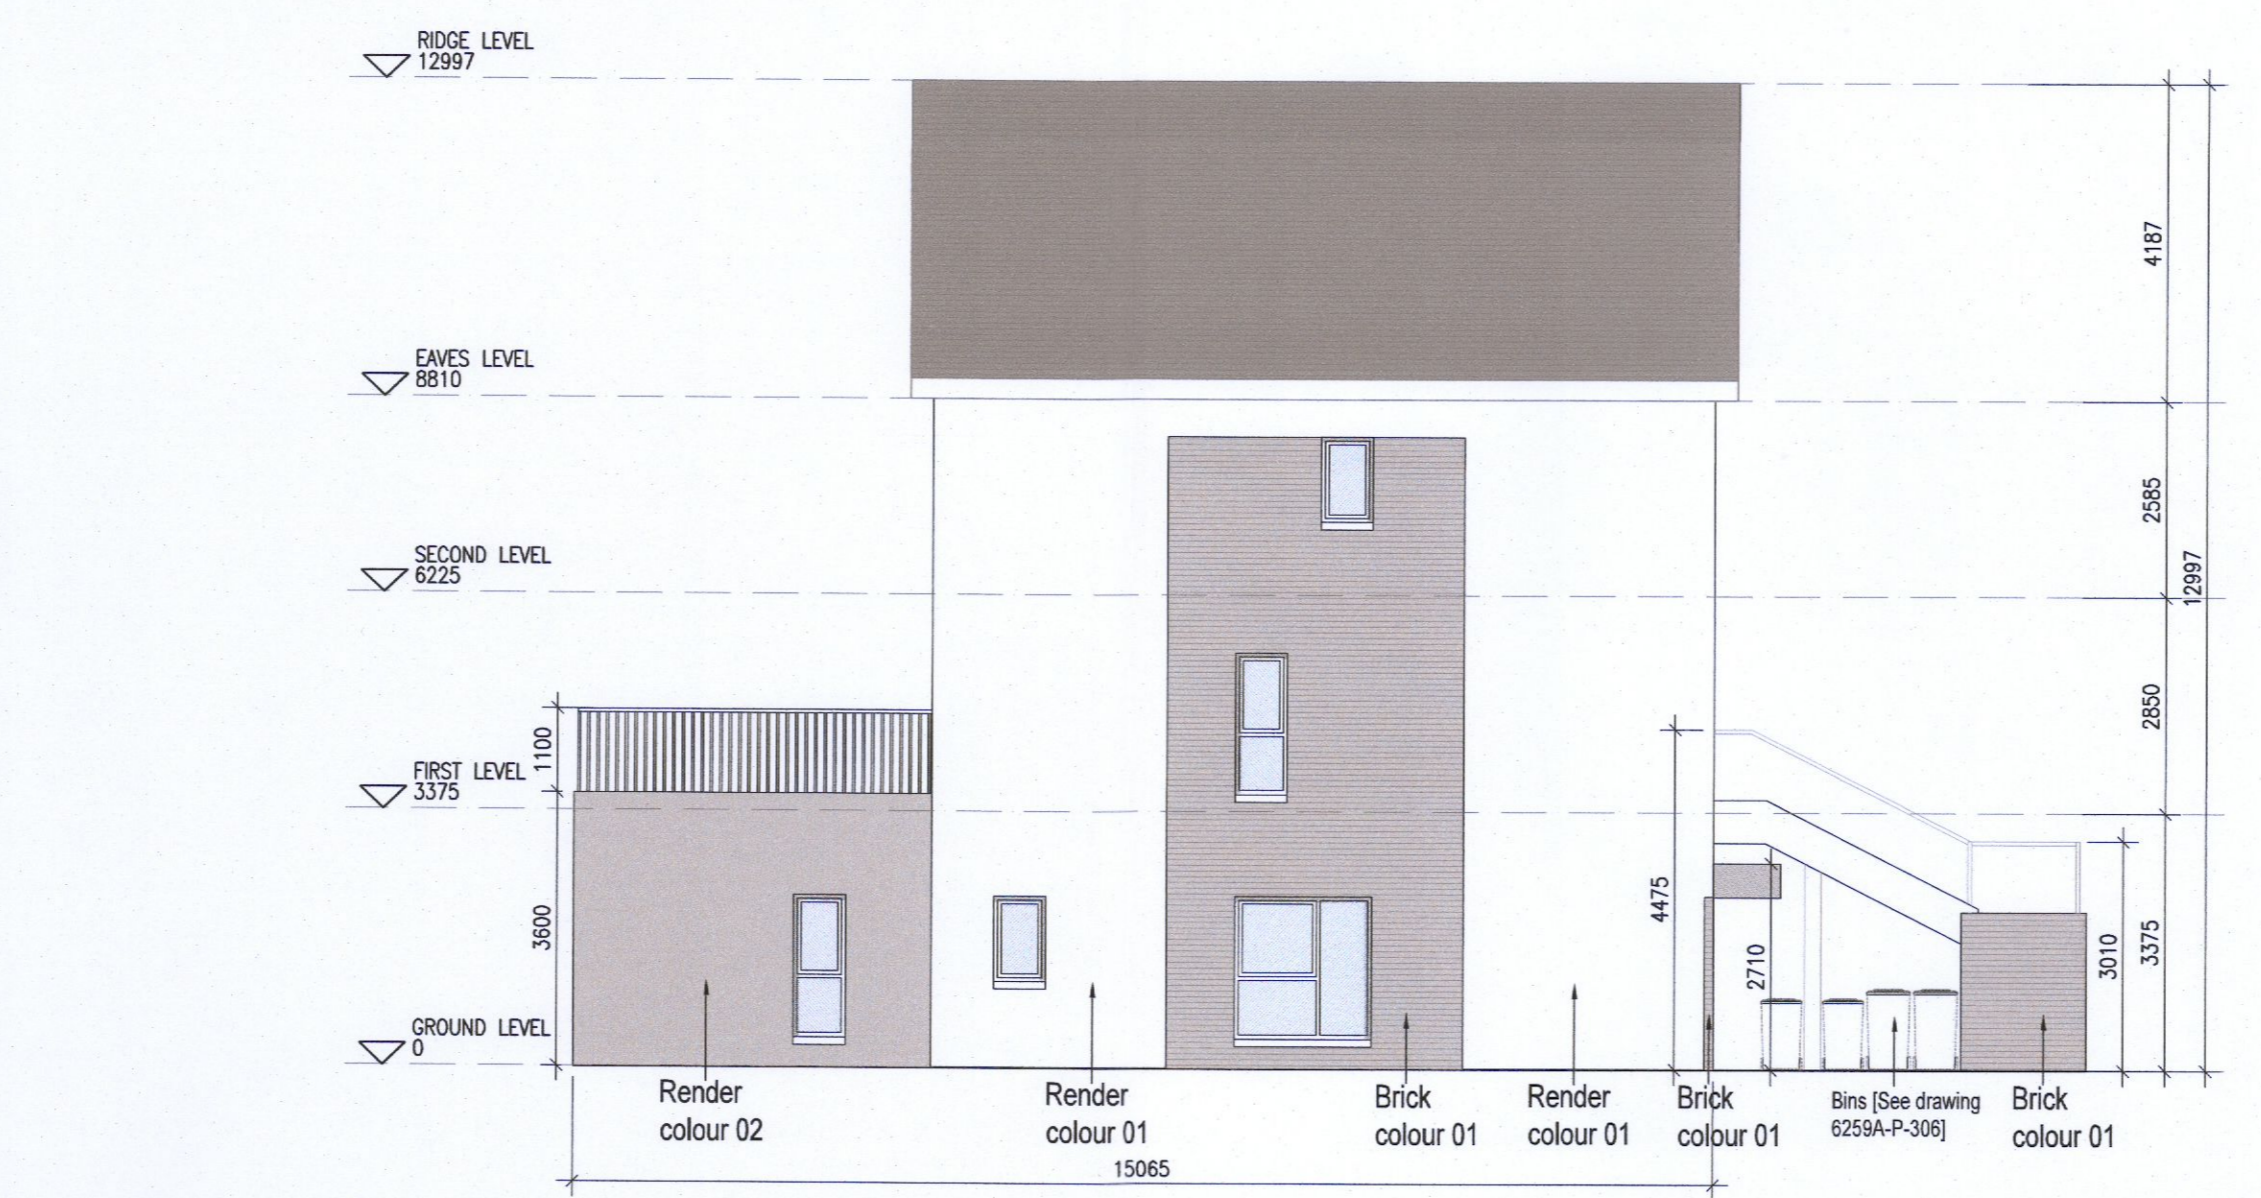

07 Side Elevation J2.1
1:100@A1

EXTERNAL FINISHES

WALLS: PAINTED SAND / CEMENT RENDER OR PROPRIETARY PRECOLOURED RENDER FINISH SELECTED BRICKWORK WHERE INDICATED ON DRAWINGS

WINDOWS: SELECTED PROPRIETARY DOUBLE / TRIPLE GLAZED WINDOW SYSTEM WITH FRAMES TO APPROVED COLOUR OBSCURED GLAZING TO BATHROOMS AND EN-SUITES.

DOORS: SELECTED PROPRIETARY DOORS AND GLAZED SIDE SCREENS TO APPROVED COLOUR.

RAINWATER GOODS: uPVC OR POWDER COATED METAL GUTTERS AND RAINWATER PIPES TO SELECTED COLOUR.

MAIN ROOF: CONCRETE ROOF TILES IN SELECTED COLOUR.

LOW LEVEL PROJECTION: ZINC CANOPY TO ENTRANCE OF UNITS

OTHER ITEMS: uPVC OR POWDER COATED METAL FASCIAS, SOFFITS AND BARGE BOARDS PAINTED MILDSTEEL RAILINGS AND BALUSTRADES

J2.A [2 Bed] - Ground floor area	81.8 m²
J2.B [3 Bed] - First floor area	55.9 m²
Second floor area	57.4 m²
Total Floor Area (J2.B):	113.3 m²

REFER TO LANDSCAPE ARCHITECT'S DRAWINGS FOR ALL LANDSCAPING DETAILS

DUPLEX TYPE J1 HANDED

Notes

- Copyright Reserved
- Work to figured dimensions only. Do not scale drawing.
- The contractor is responsible for checking all levels and dimensions on site and shall refer all discrepancies to the Architect.
- Where appropriate, for details of c. structures, or mechanical and electrical details, see Engineers drawings.
- Proprietary items shall be fixed in strict accordance with manufacturers instructions.
- Sizes of proprietary items shall be checked with manufacturer.
- The contractor shall be responsible for the coordination of structure, finishes and services.

Issue Status

Progress	Planning Application
Fire Cert	Disability Cert
Tender	Construction
As Built	Information Only

No.	Date	Revision	Initials
01	13.10.22	ISSUED FOR PLANNING	AM

Project Aderrig Phase 3, Adamstown SD2 Residential Development

Drawing Title Duplex Type J2 (end terrace) Handed-Plans, Elevation, Section

Drawing No 6259A-P-218

Scale 1:100@A1 **Rev** 01 **Drawn** [FJ] **Date** OCT 2022

6-7 HARCOURT TERRACE, DUBLIN 2, IRELAND
+353-1-618 2400 +353-1-676 7365
www.bkd.ie

bkd architects
BURKE-KENNEDY DOYLE