



TYPE 5


House Unit Type:
F3

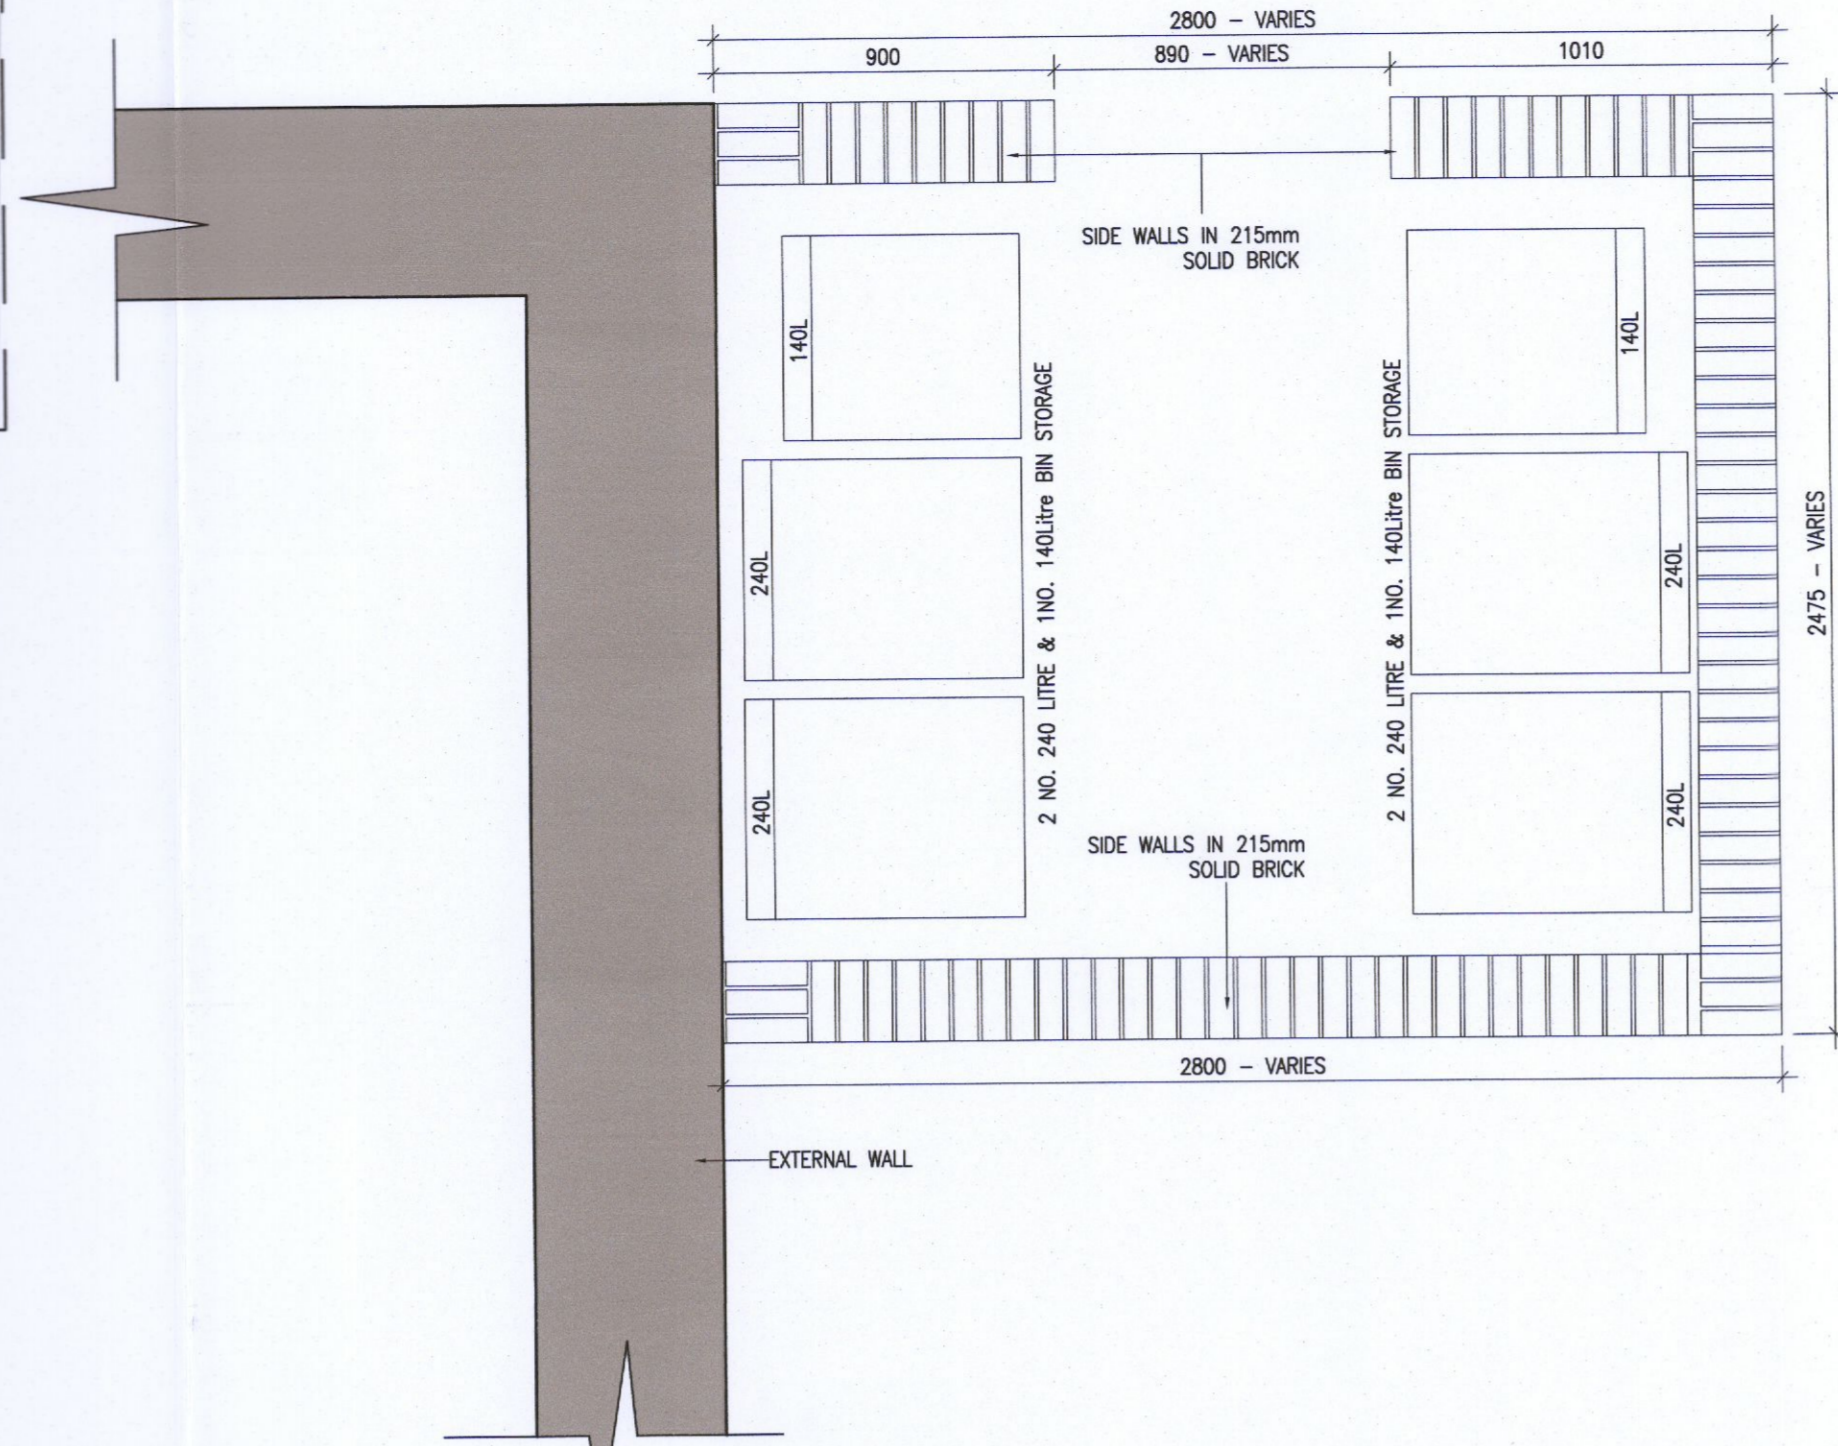


1 Bin store Type 5 Plan
Scale 1:20

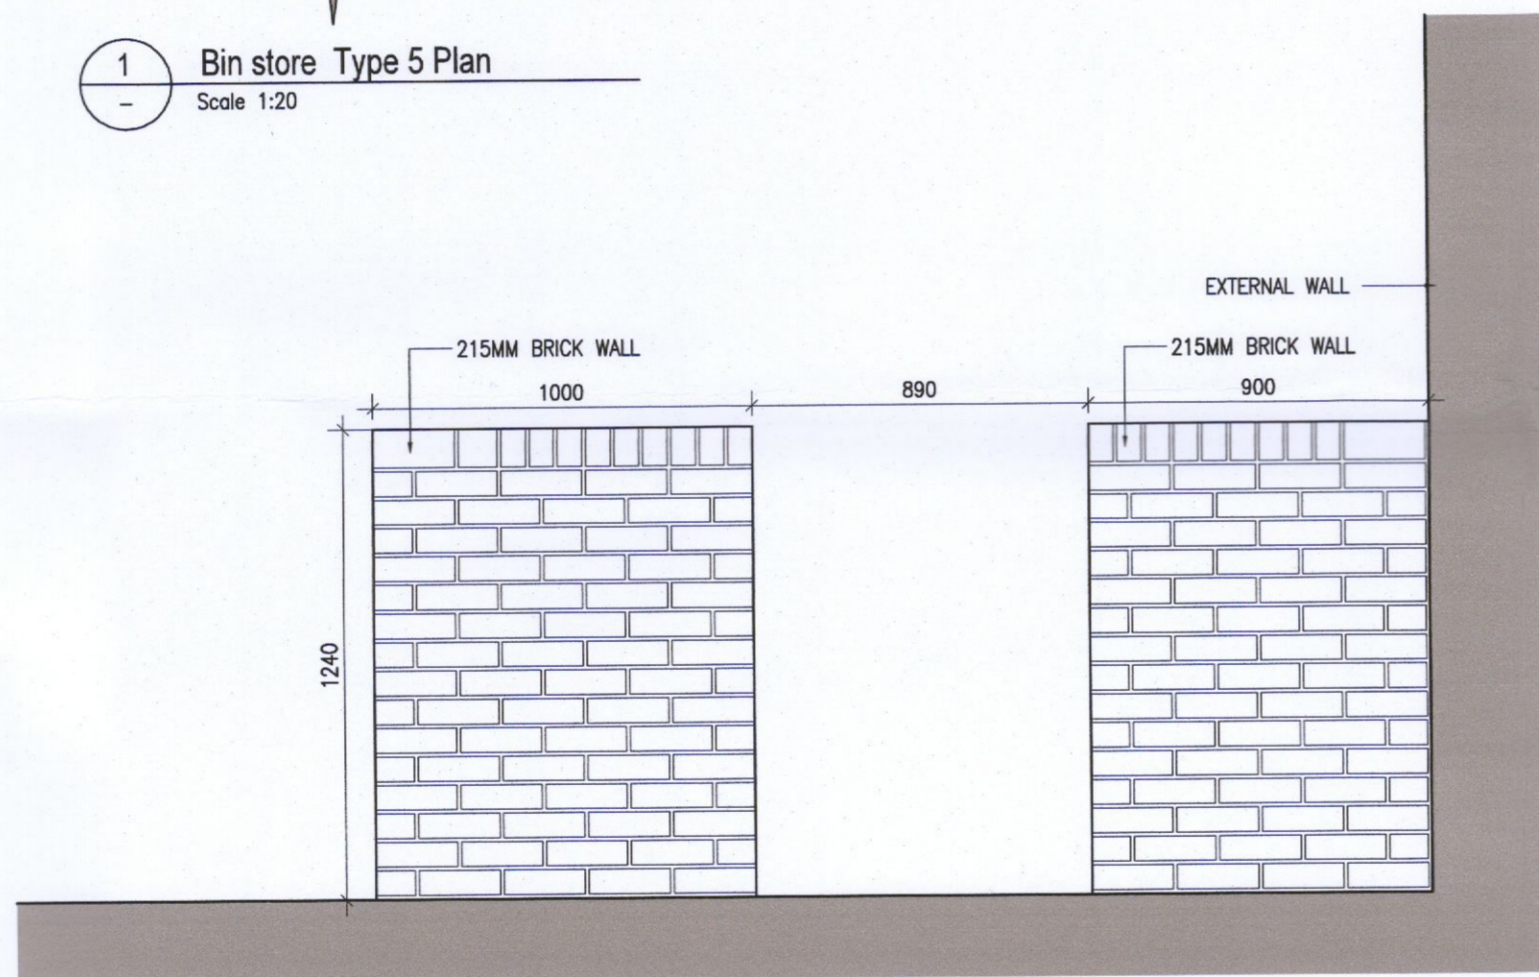


2 Bin store Type 5 Front Elevation
Scale 1:20

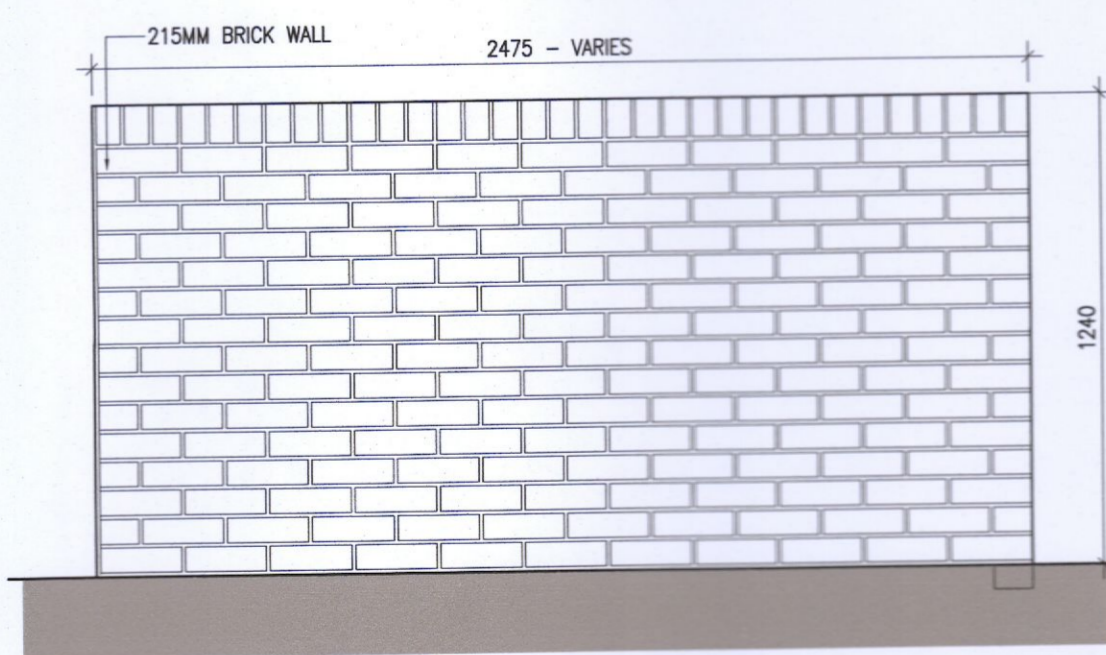

3 Bin store Type 5 Side Elevation
Scale 1:20

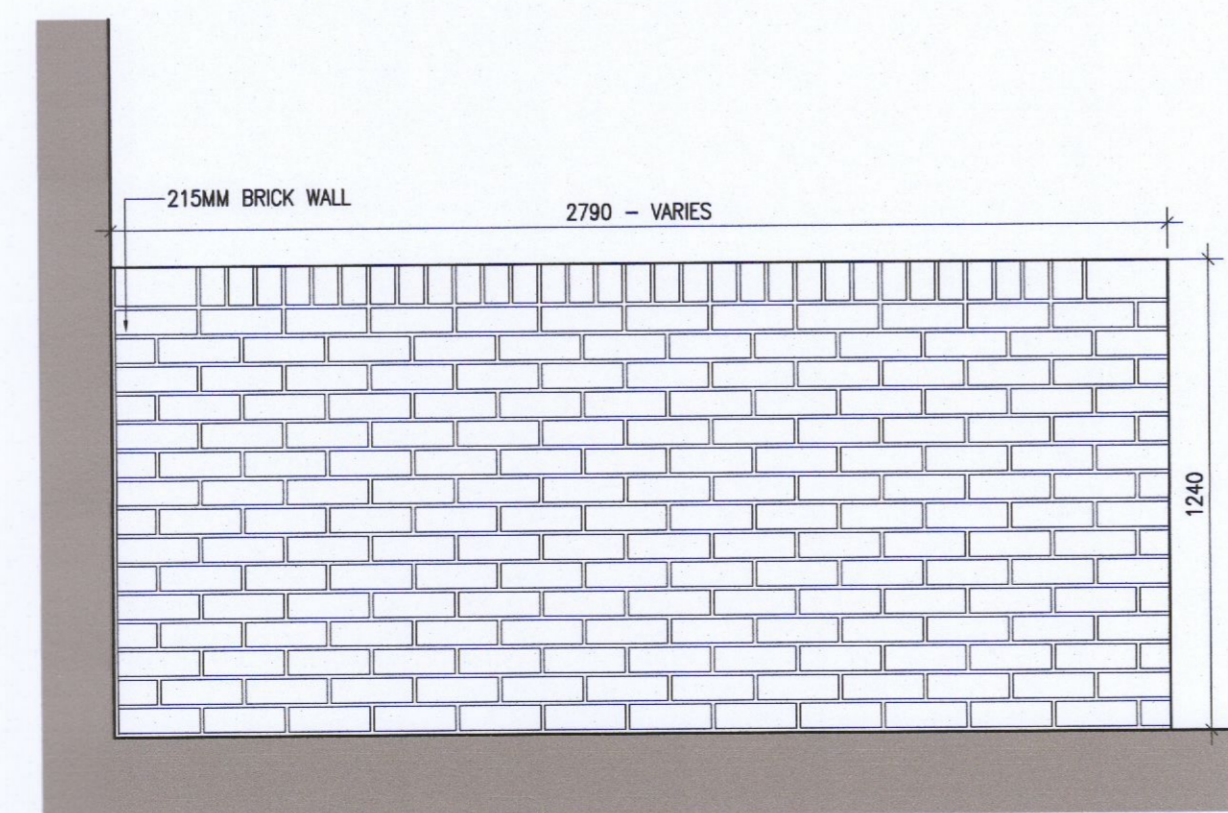

4 Bin store Type 5 Rear Elevation
Scale 1:20

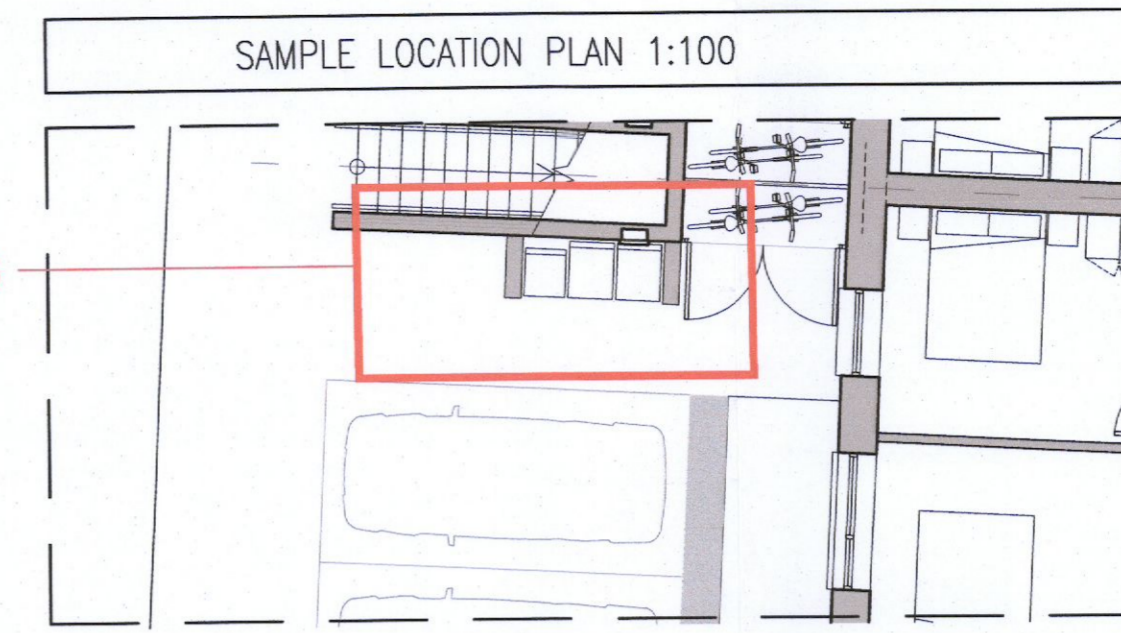


TYPE 6


House Unit Type:
G1,G3




TYPE 6

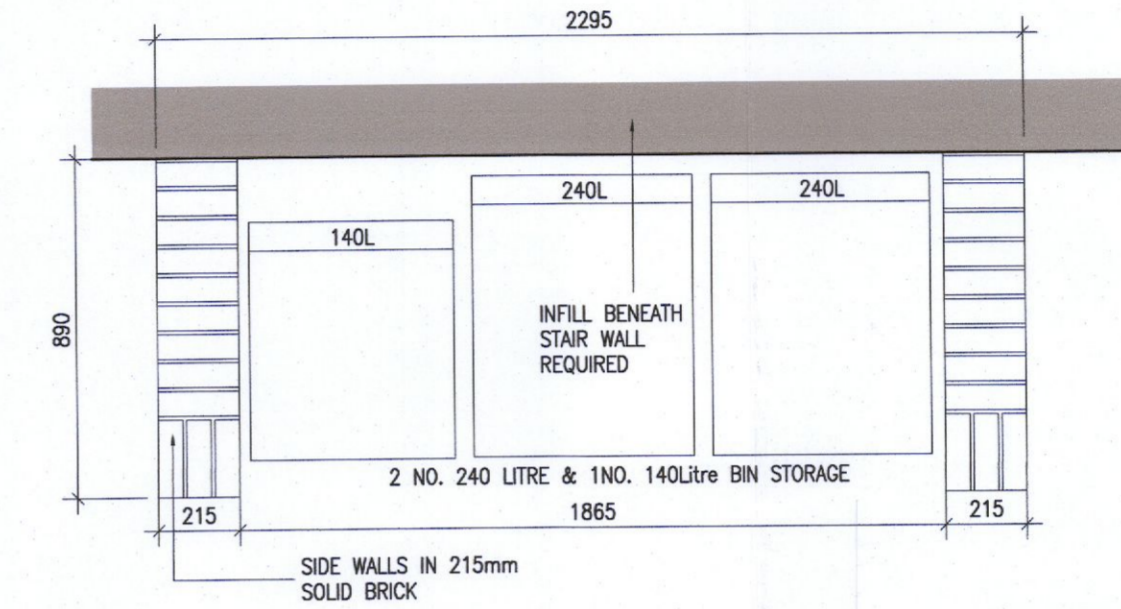

1 Bin store Type 6 Plan
Scale 1:20

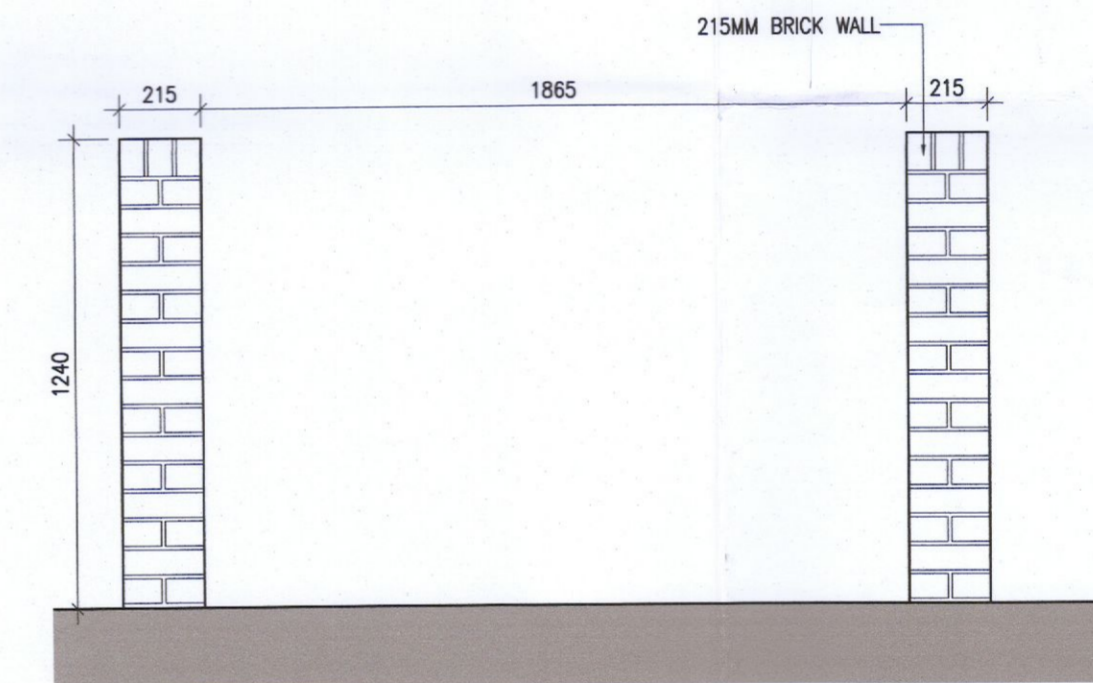

2 Bin store Type 6 Front Elevation
Scale 1:20

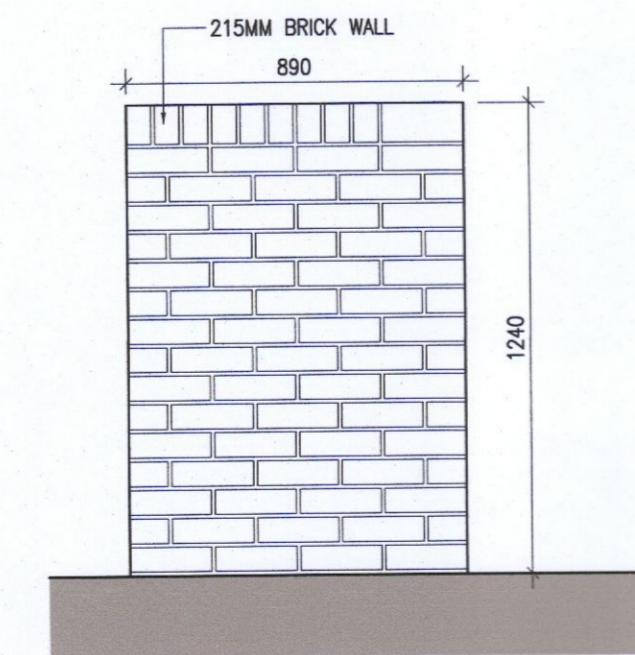

3 Bin store Type 6 Rear Elevation
Scale 1:20

Notes:

1. Copyright Reserved
2. Work to figured dimensions only. Do not scale drawing.
3. The contractor is responsible for checking all levels and dimensions on site and shall refer all discrepancies to the Architect.
4. Where appropriate, for details of r.c. structure, or mechanical and electrical details, see Engineers drawings.
5. Proprietary items shall be fixed in strict accordance with manufacturers instructions.
6. Sizes of proprietary items shall be checked with manufacturer.
7. The contractor shall be responsible for the coordination of structure, finishes and services.

Issue Status
Progress
Planning Application
Fire Cert
Disability Cert
Tender
Construction
As Built
Information Only

No.	Date	Revision	Initials
01	14.10.2022	ISSUED FOR PLANNING	AM

Project	Aderrig Phase 3 Adamstown SDZ Residential Development
Drawing Title	Bin Store Details Type 5 & 6
Drawing No	6258A-P-305
Scale	1:20 @A1
Rev	01
Drawn	EPS
Date	Sept 2022