

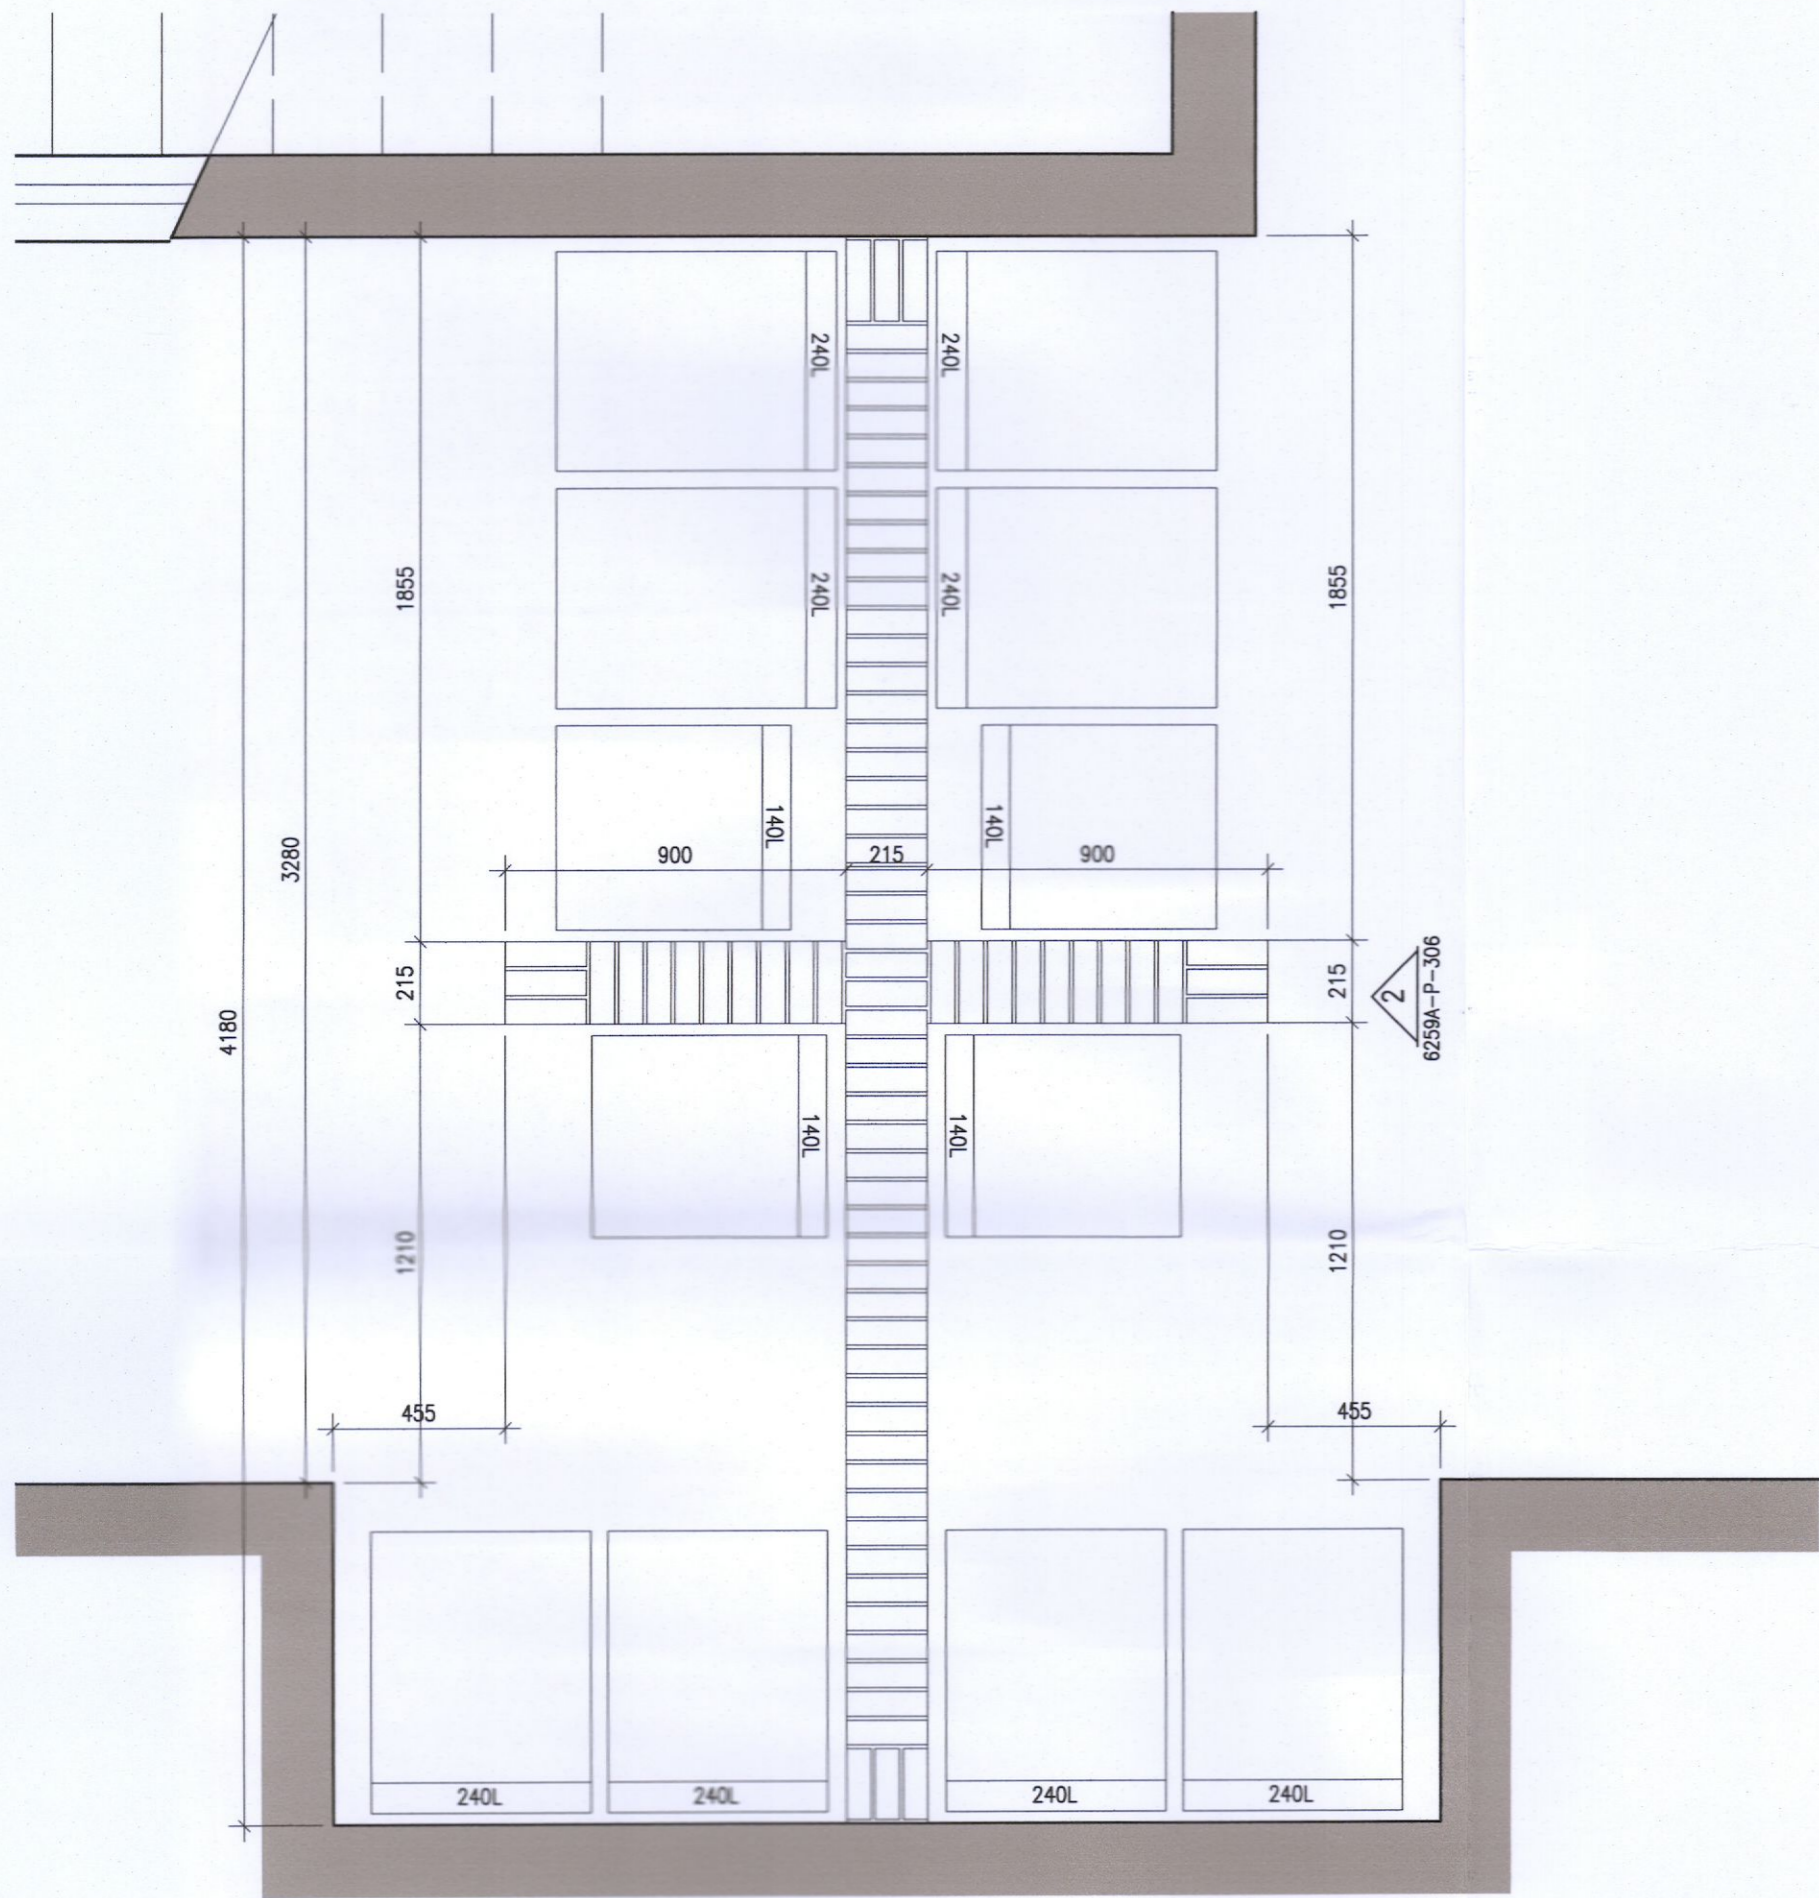


TYPE 7

House Unit Type:
J1.J2

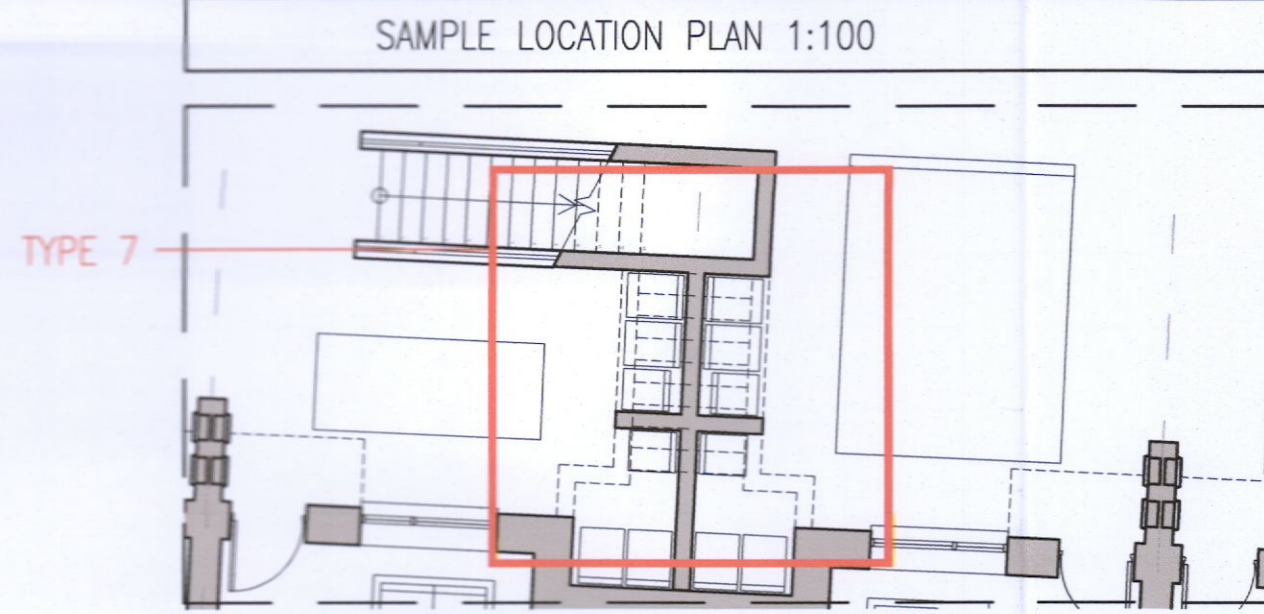

1 Bin store Type 7 Plan
Scale 1:20


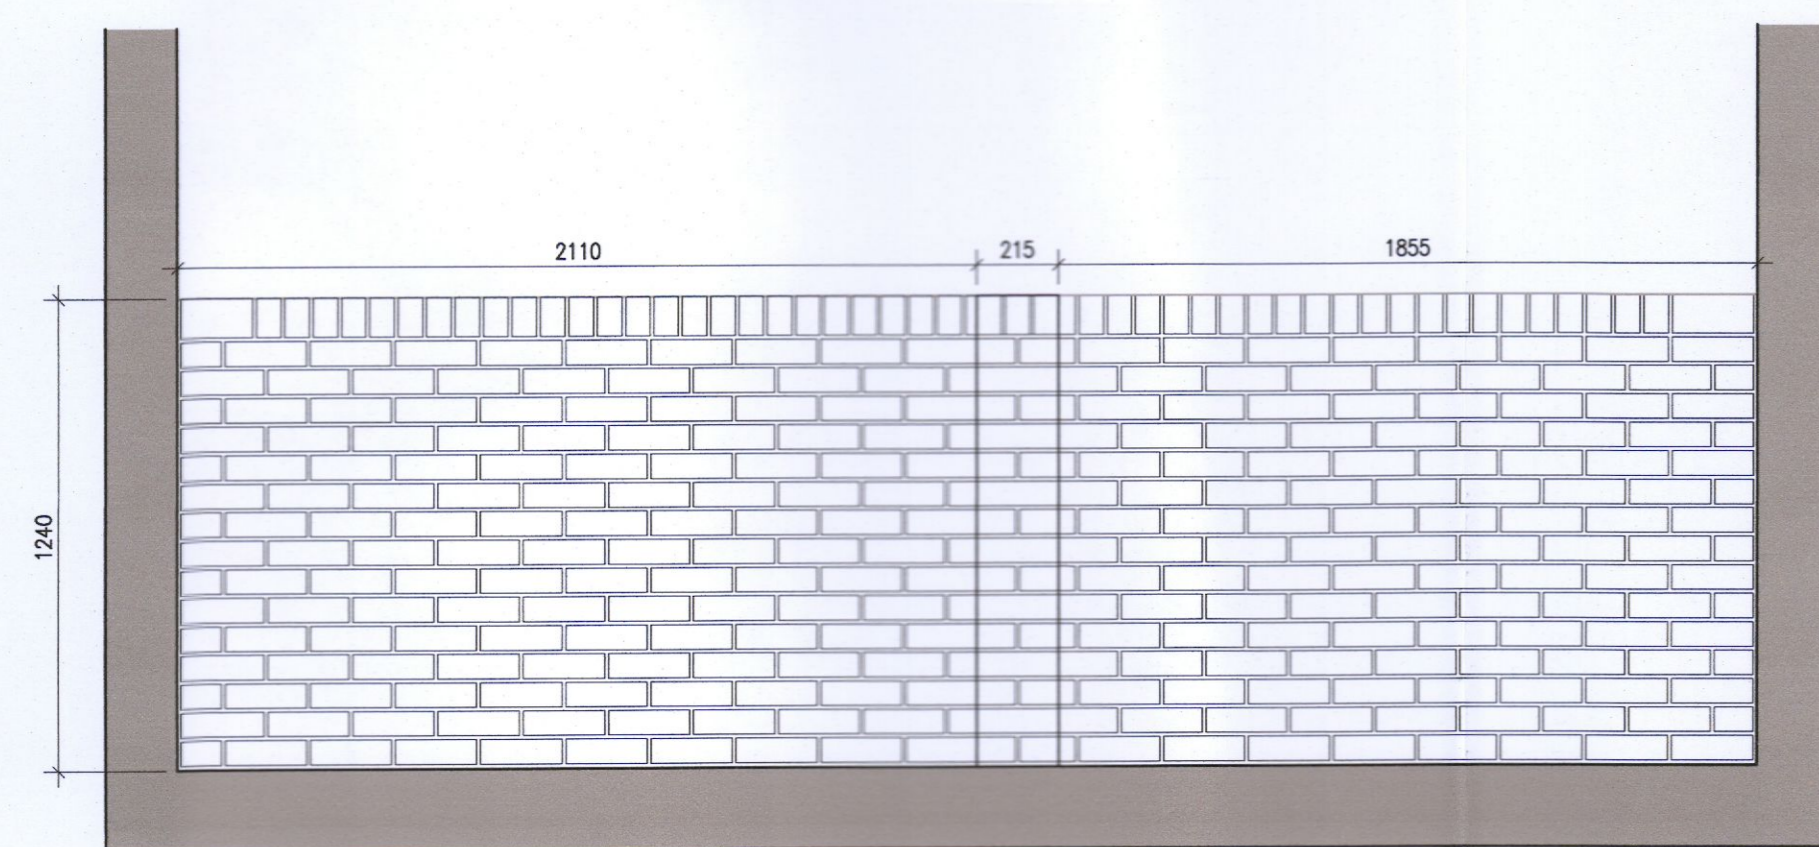


2 Bin store Type 7 Front Elevation
Scale 1:20


TYPE 8

TYPE 8


House Unit Type:
H1

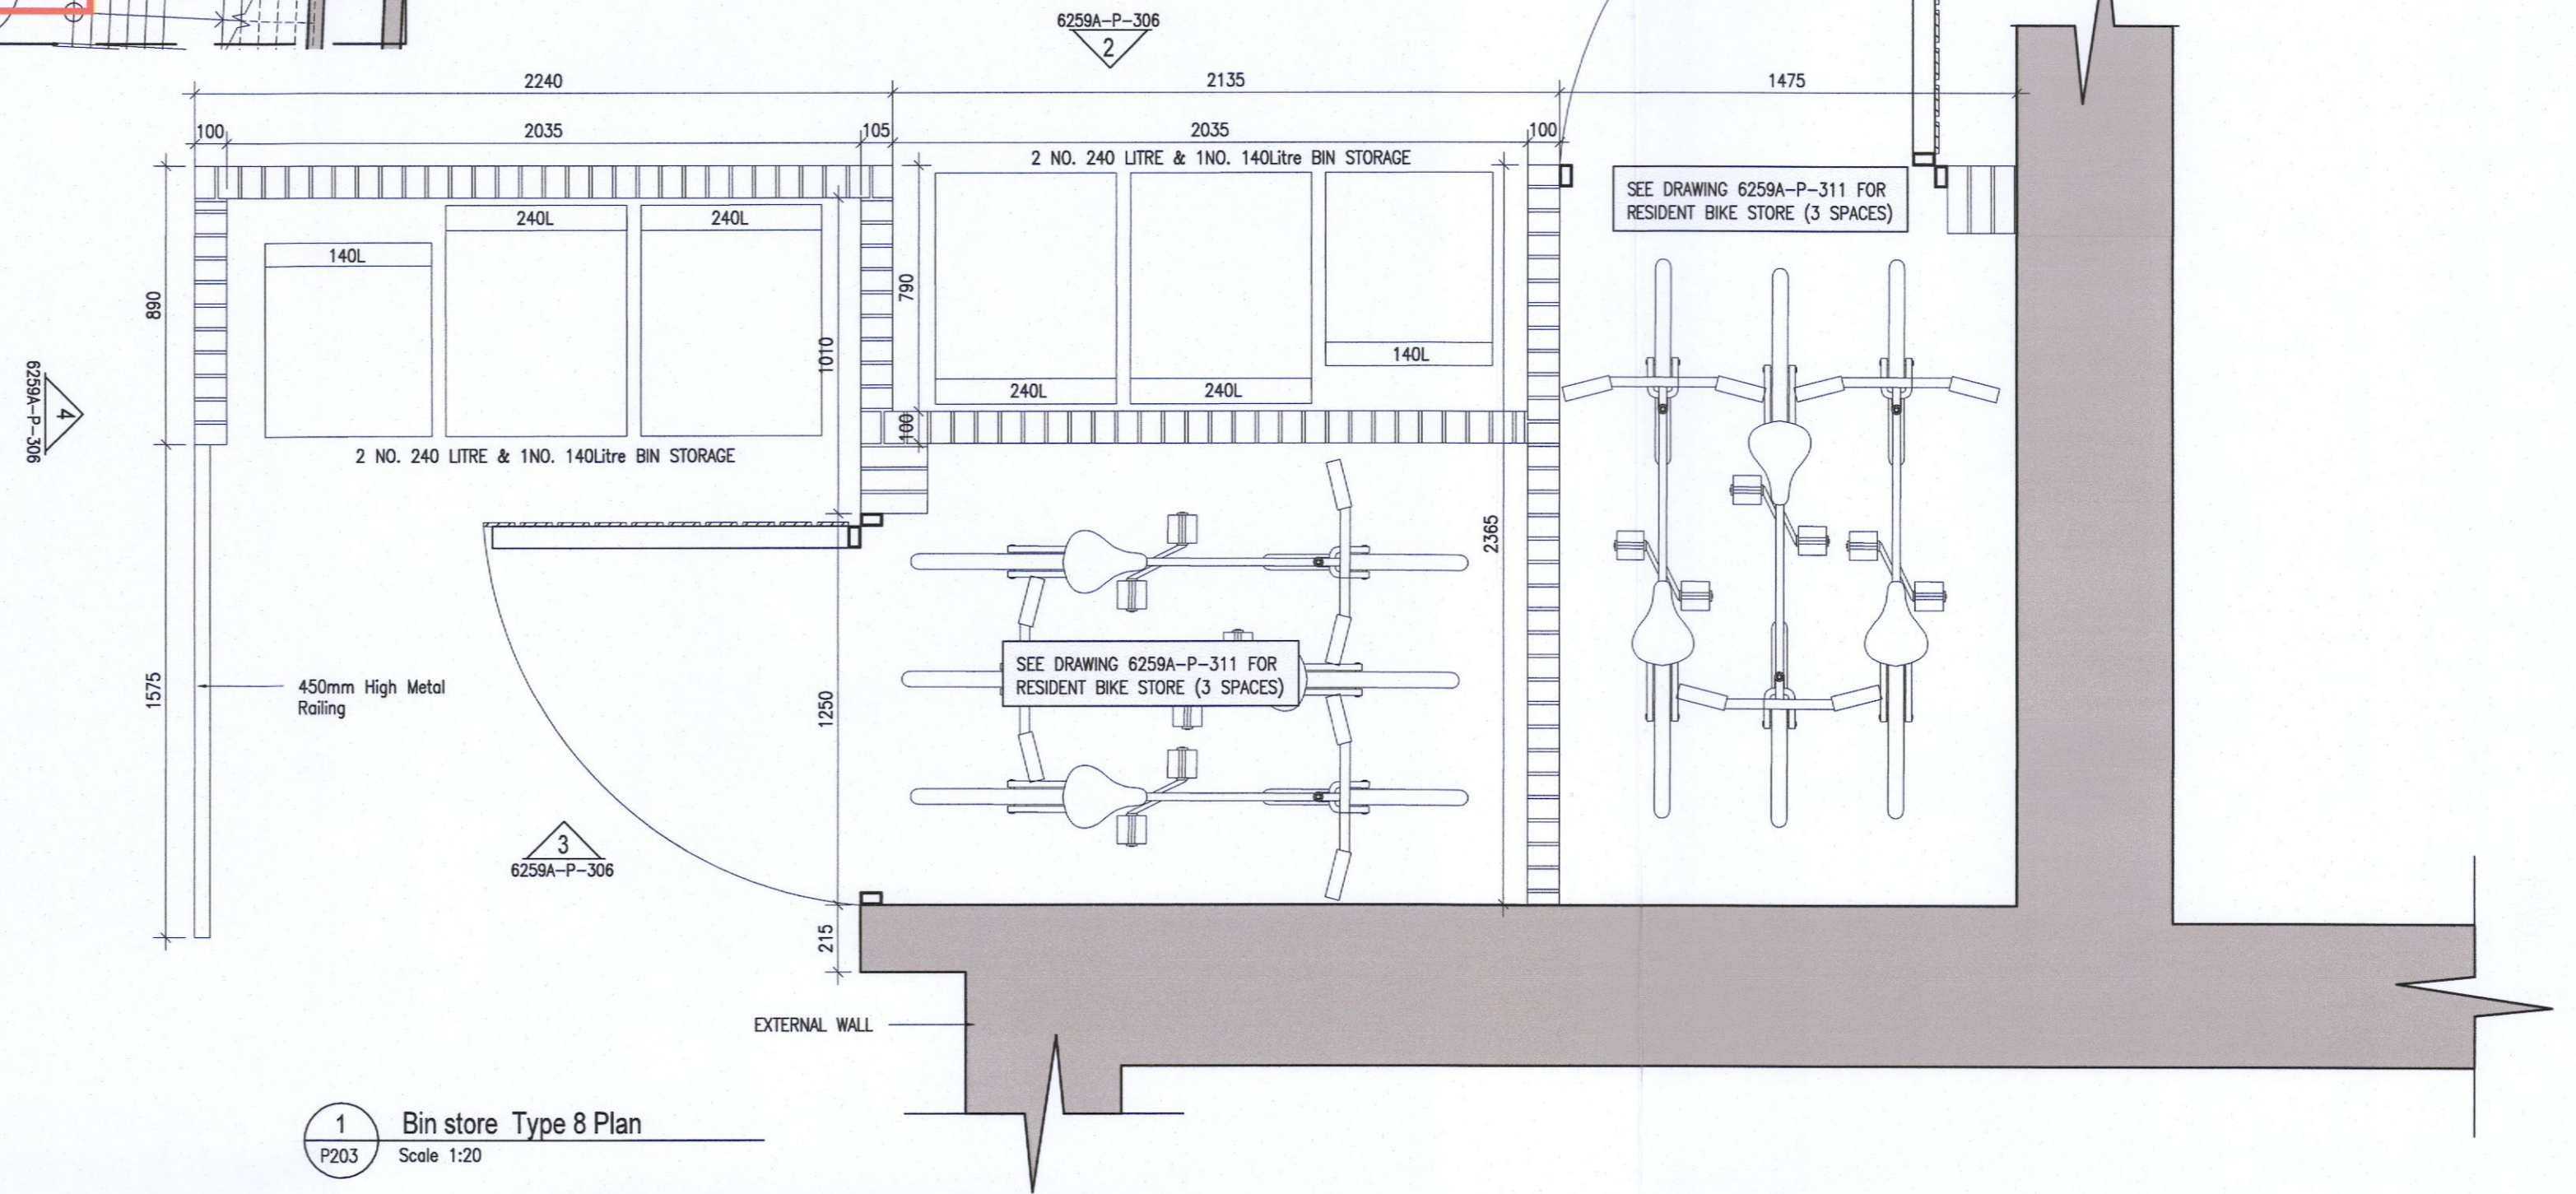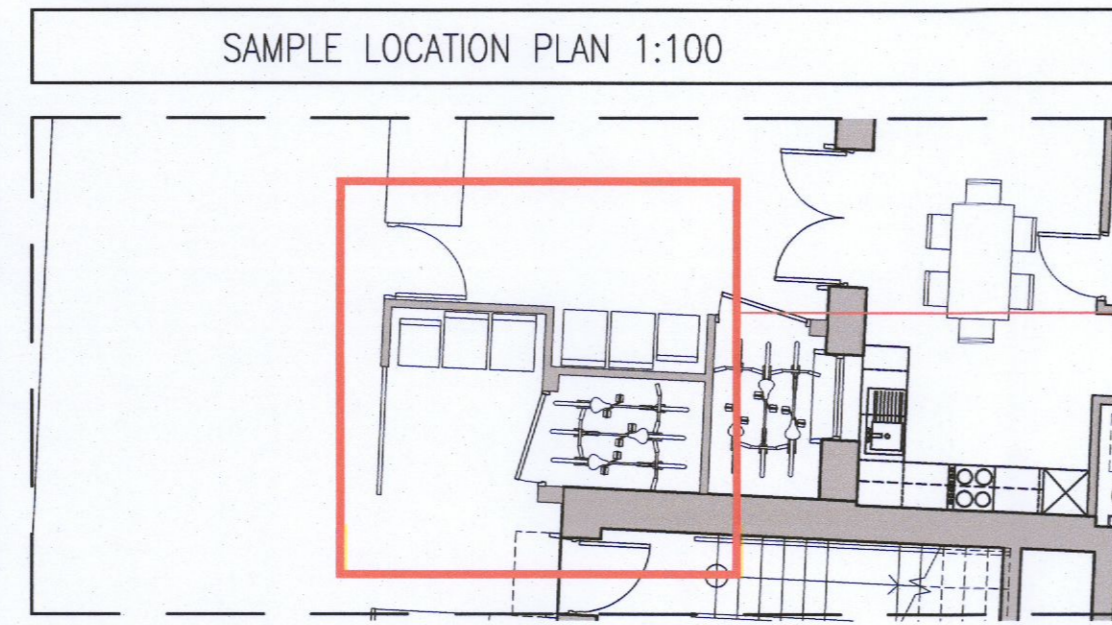


1 Bin store Type 8 Plan
Scale 1:20

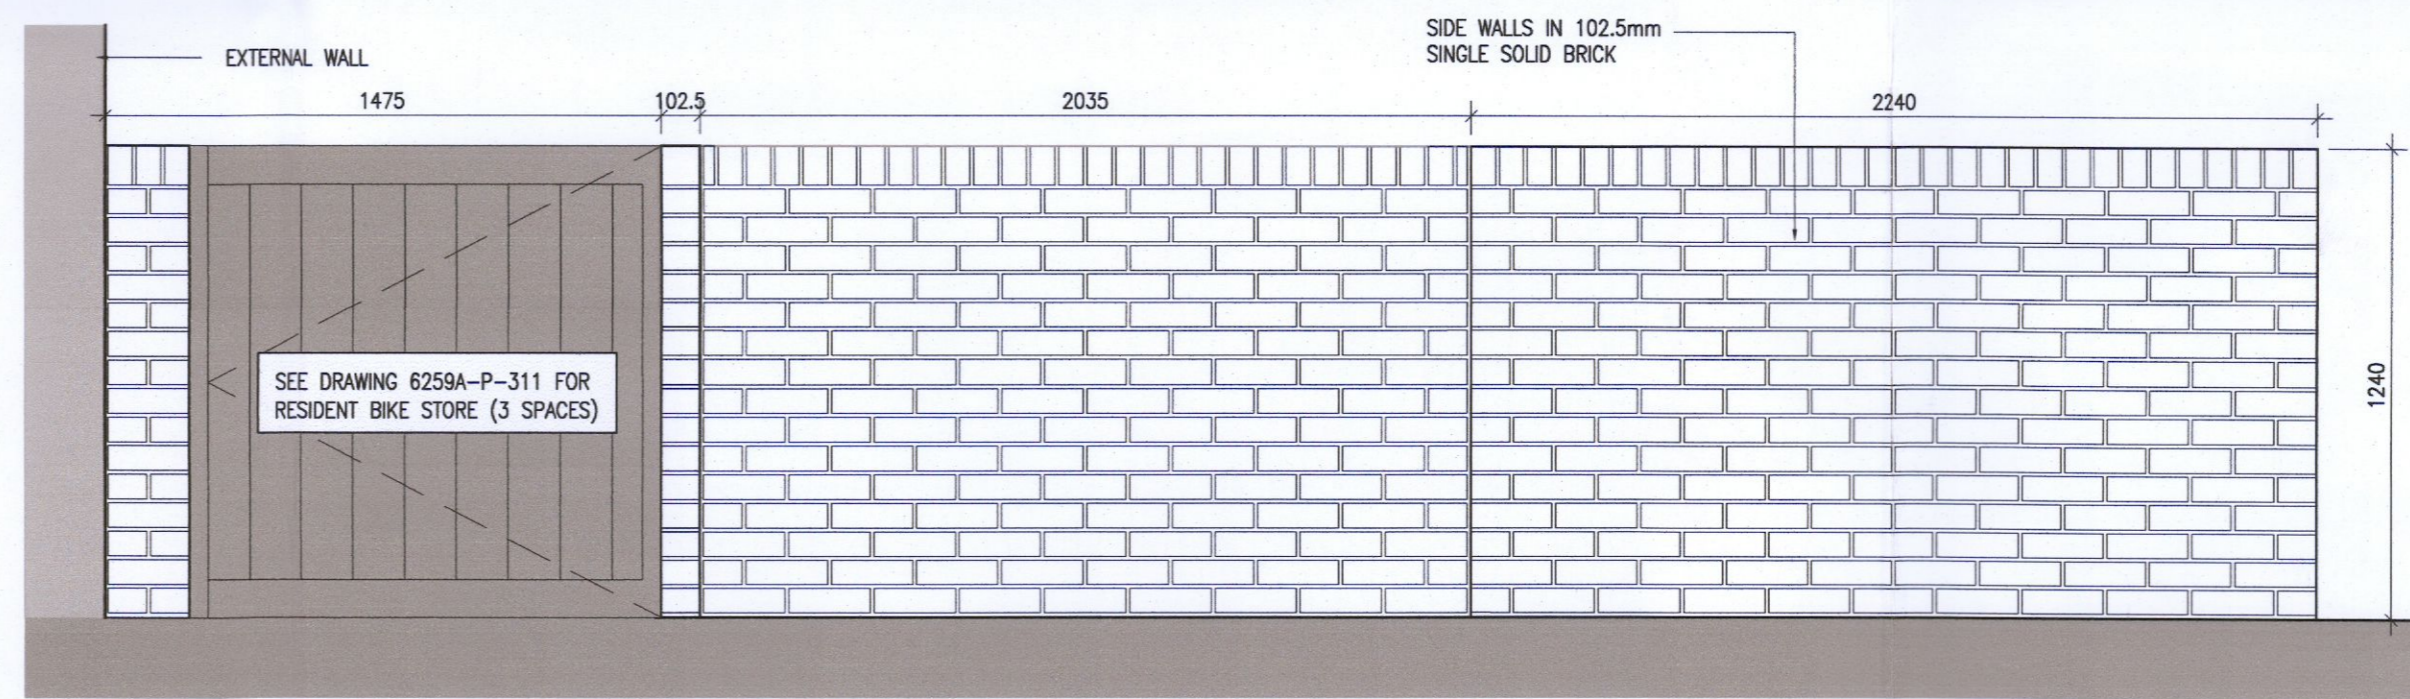

2 Bin store Type 8 Front Elevation
Scale 1:20

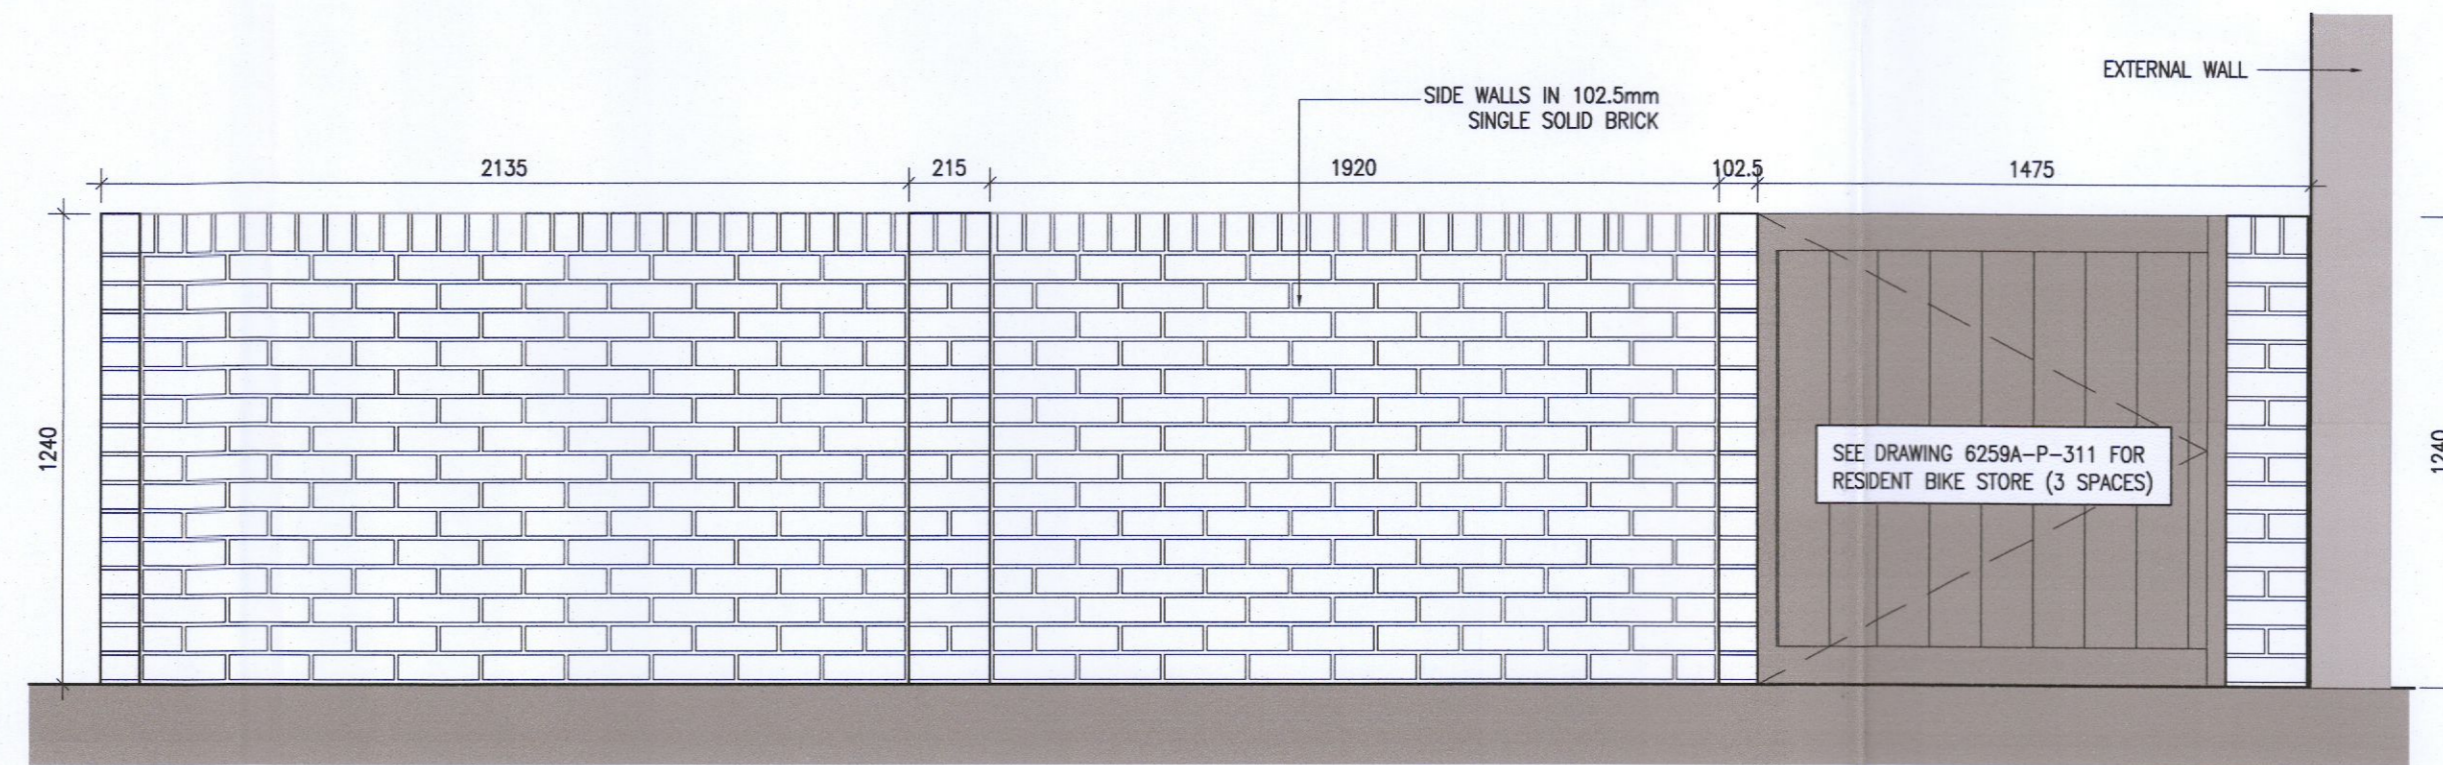

3 Bin store Type 8 Rear Elevation
Scale 1:20

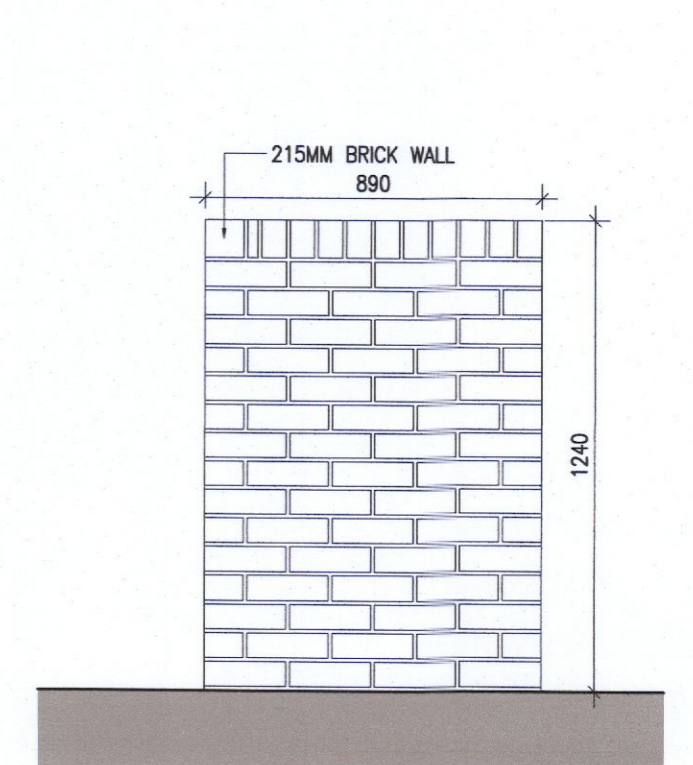

4 Bin store Type 8 Side Elevation
Scale 1:20

Notes	Issue Status
1. Copyright Reserved	Progress
2. Work to figured dimensions only. Do not scale drawing.	Planning Application
3. The contractor is responsible for checking all levels and dimensions on site and shall refer all discrepancies to the Architect	Fire Cert
4. Where appropriate, for details of i.e. structure, or mechanical and electrical details, see Engineers drawings	Disability Cert
5. Proprietary items shall be fixed in strict accordance with manufacturers instructions.	Tender
6. Sizes of proprietary items shall be checked with manufacturer.	Construction
7. The contractor shall be responsible for the coordination of structure, finishes and services.	As Built
	Information Only

No.	Date	Revision	Initials
01	14.10.22	ISSUED FOR PLANNING	AM

Project	Aderrig Phase 3 Adamstown SDZ Residential Development
Drawing Title	Bin Store Details Type 7 & 8
Drawing No	6259A-P-306
Scale	1:20 @A1
Rev	01
Draw	EPS
Date	OCT 2022

6-7 HARDCOURT TERRACE, DUBLIN 2, IRELAND
t +353-1-616 2400 f +353-1-476 7886
e architecture@bkd.ie
www.bkd.ie

bkd architects
BURKE-KENNEDY DOYLE