
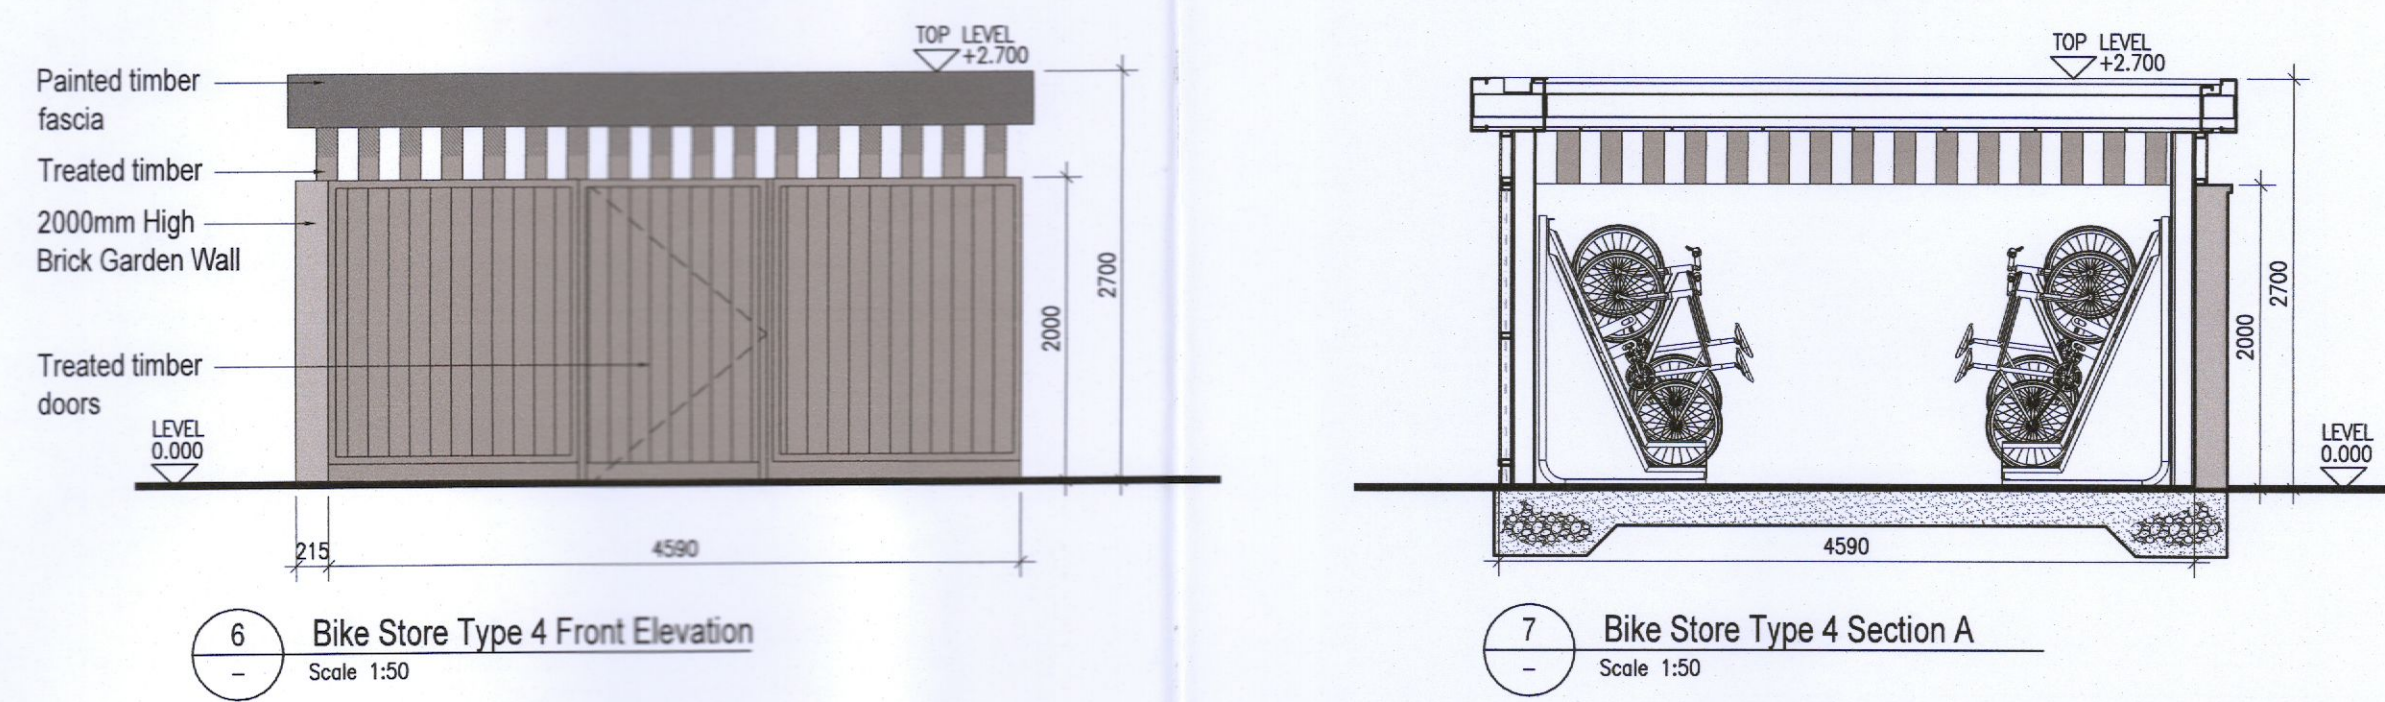
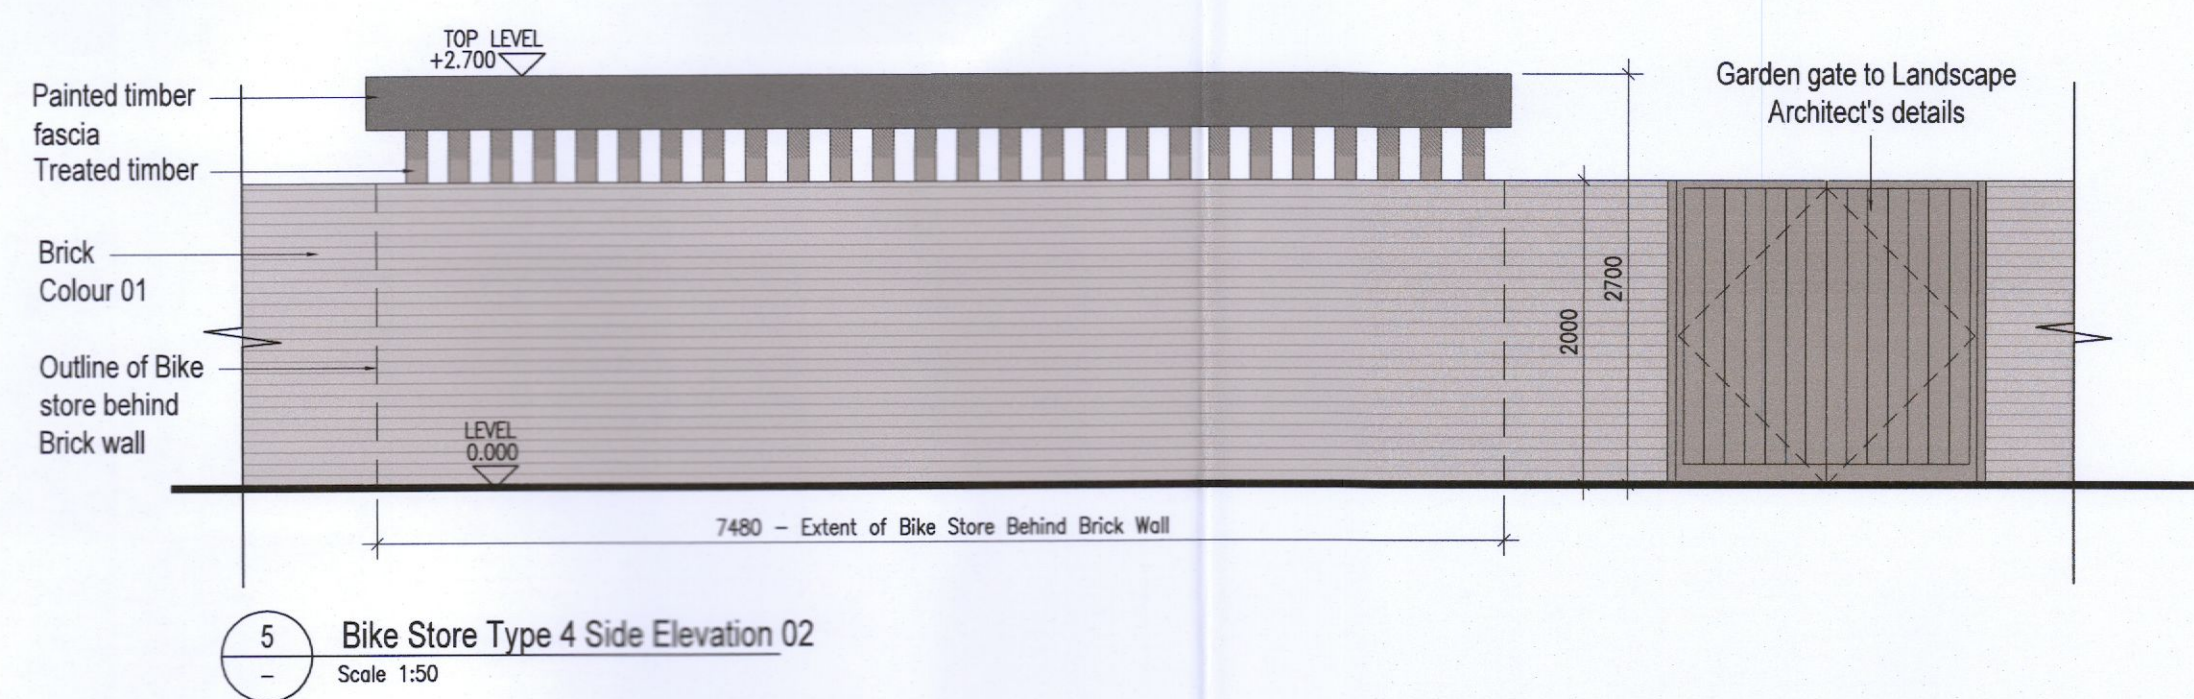
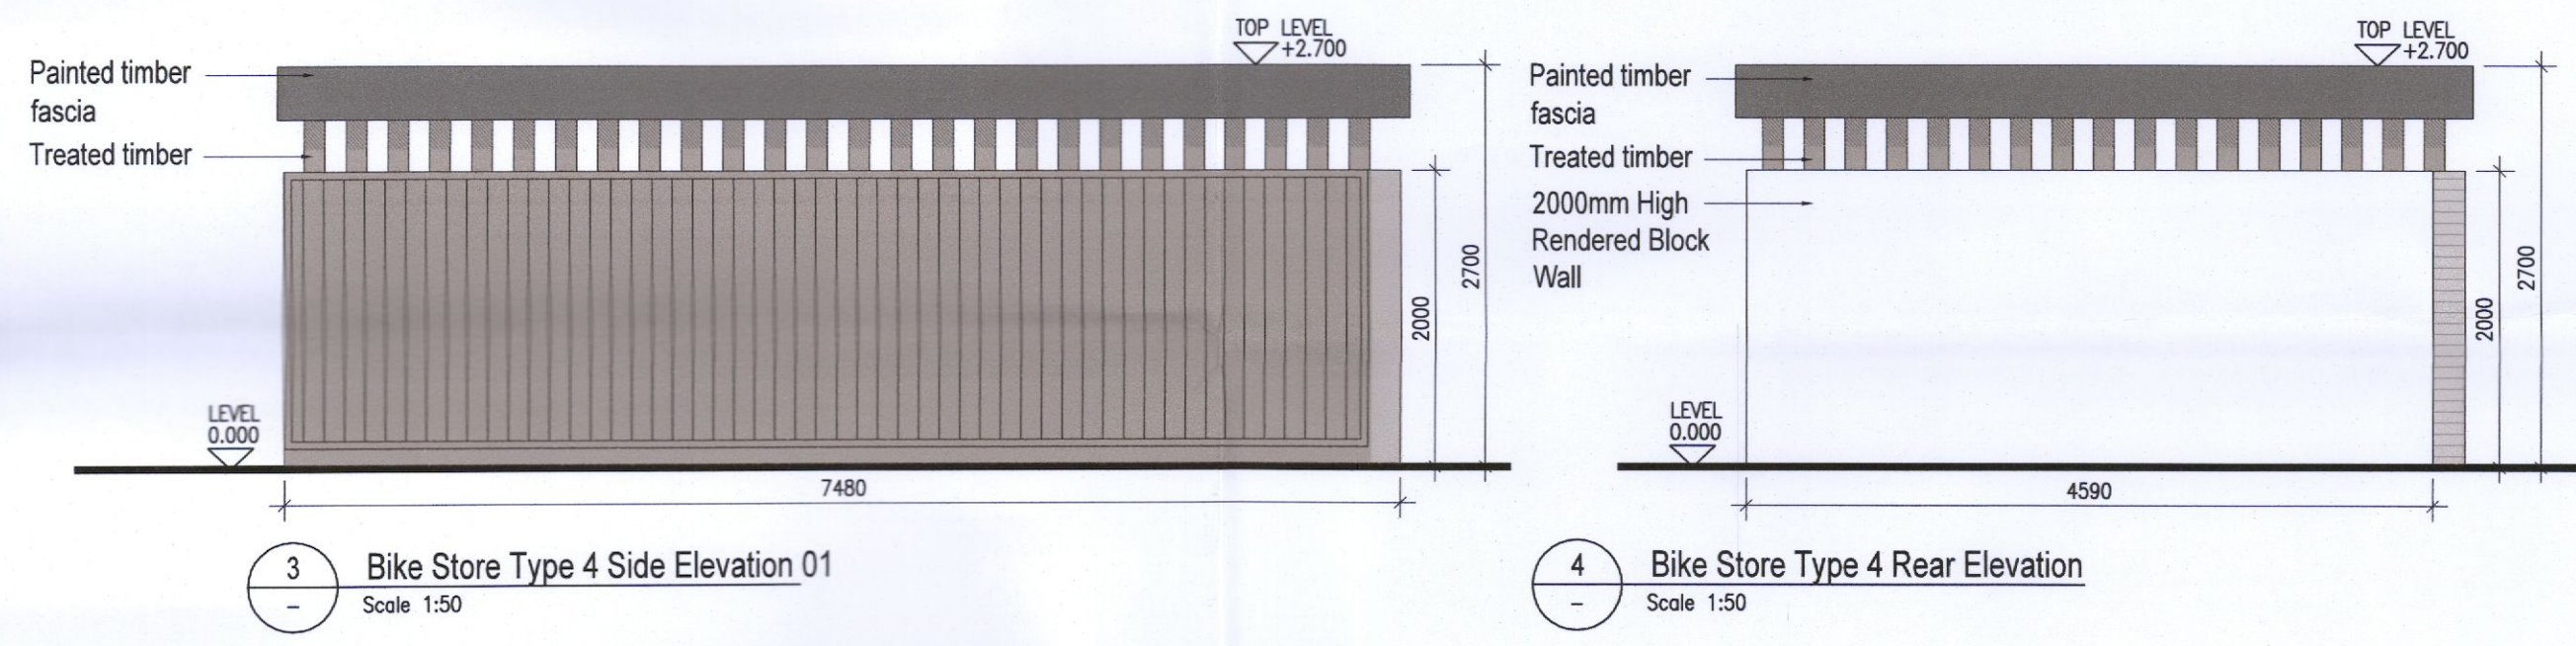
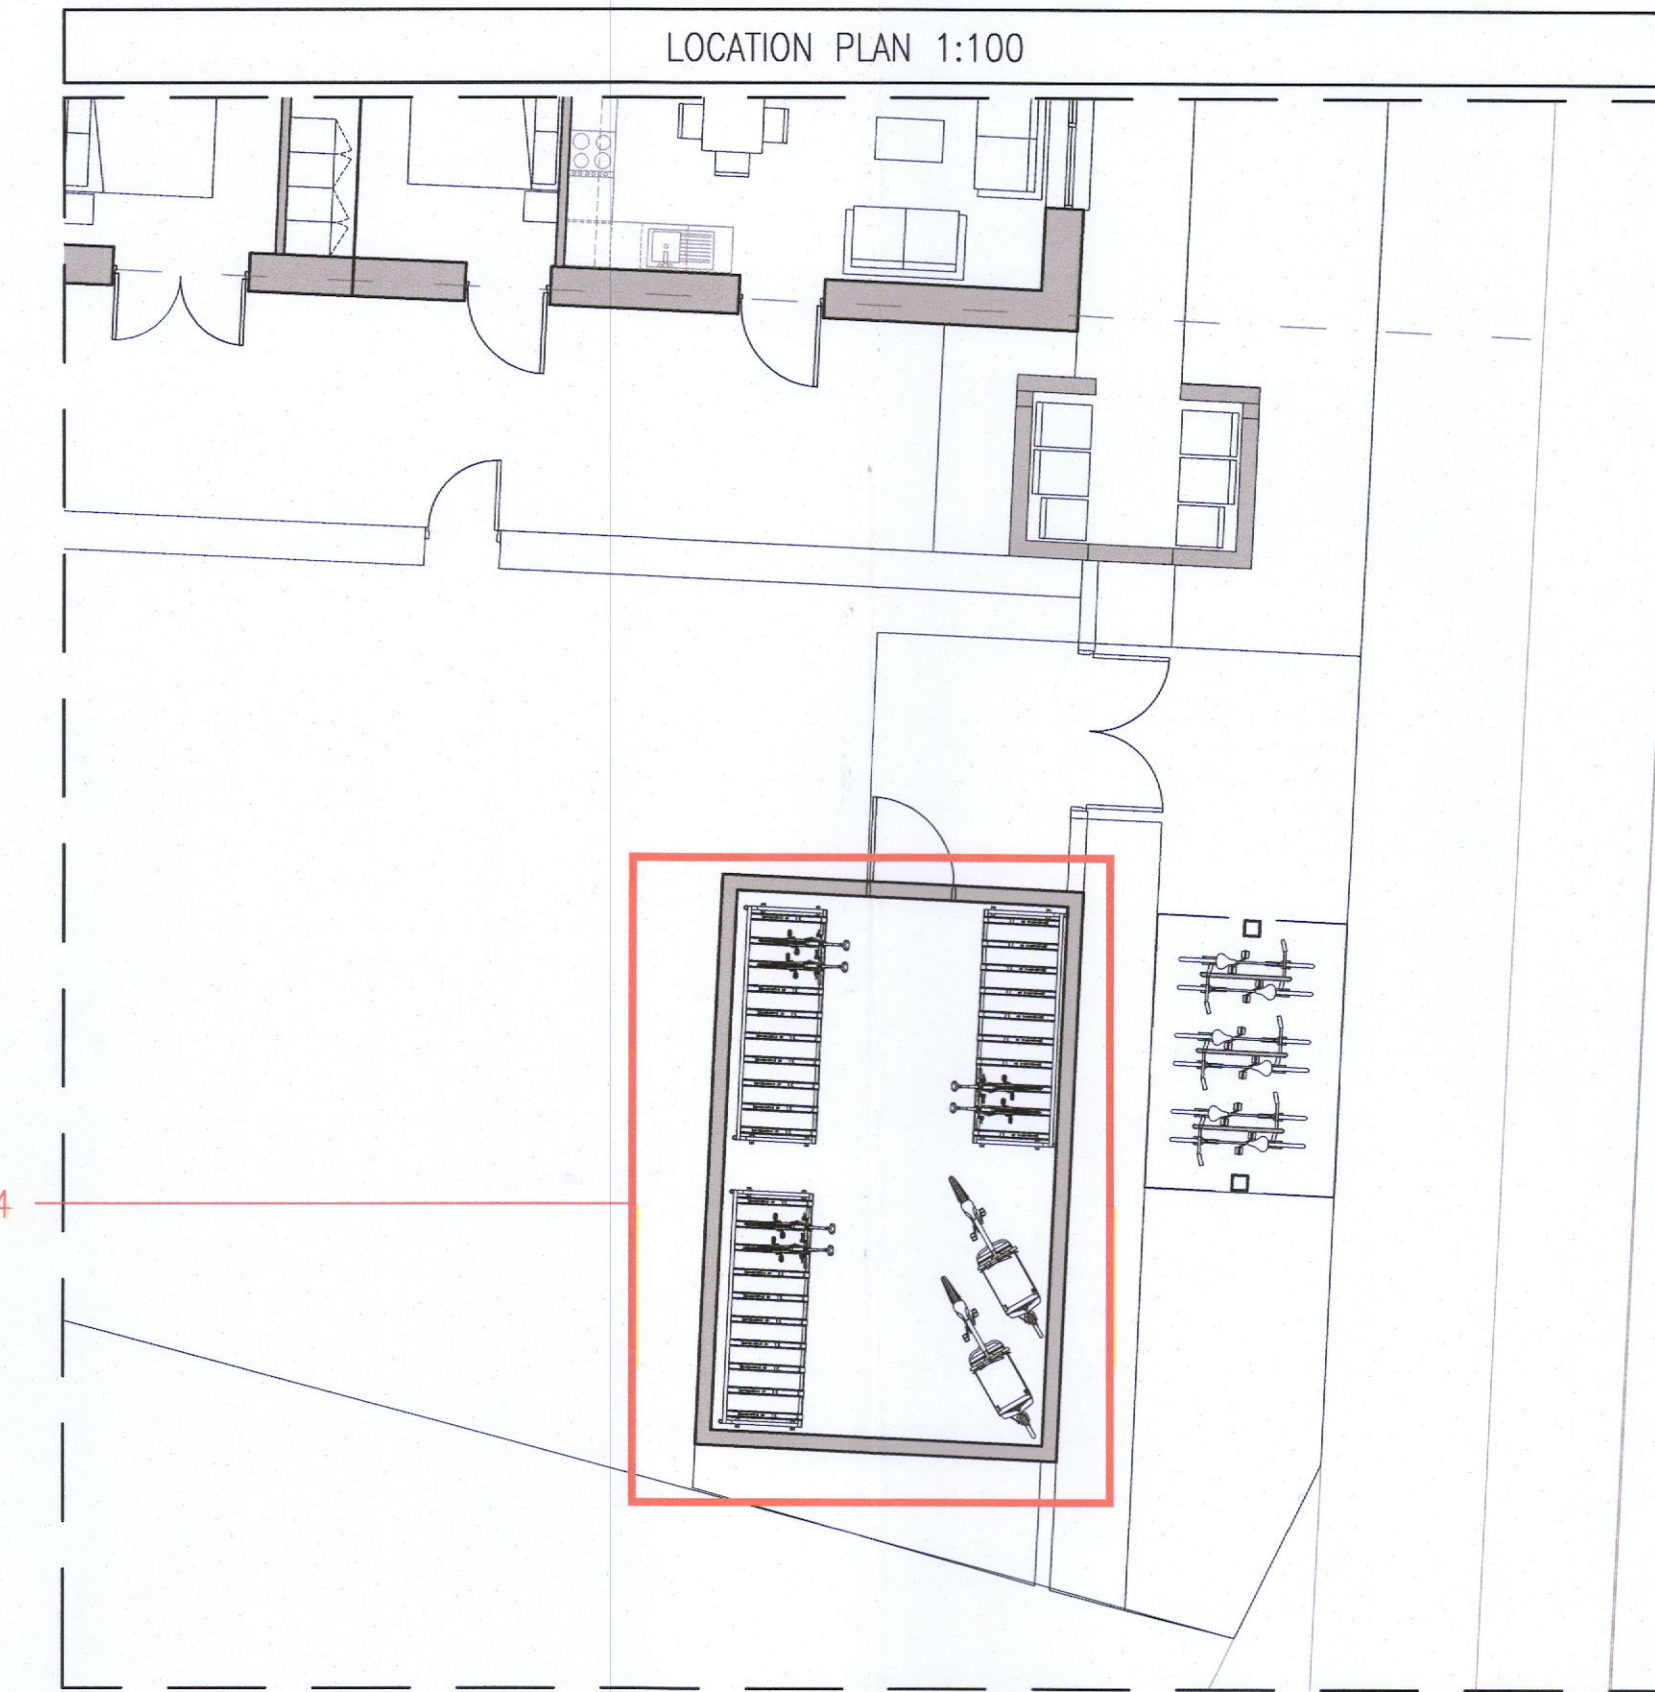


TYPE 4
Communal Bike Store

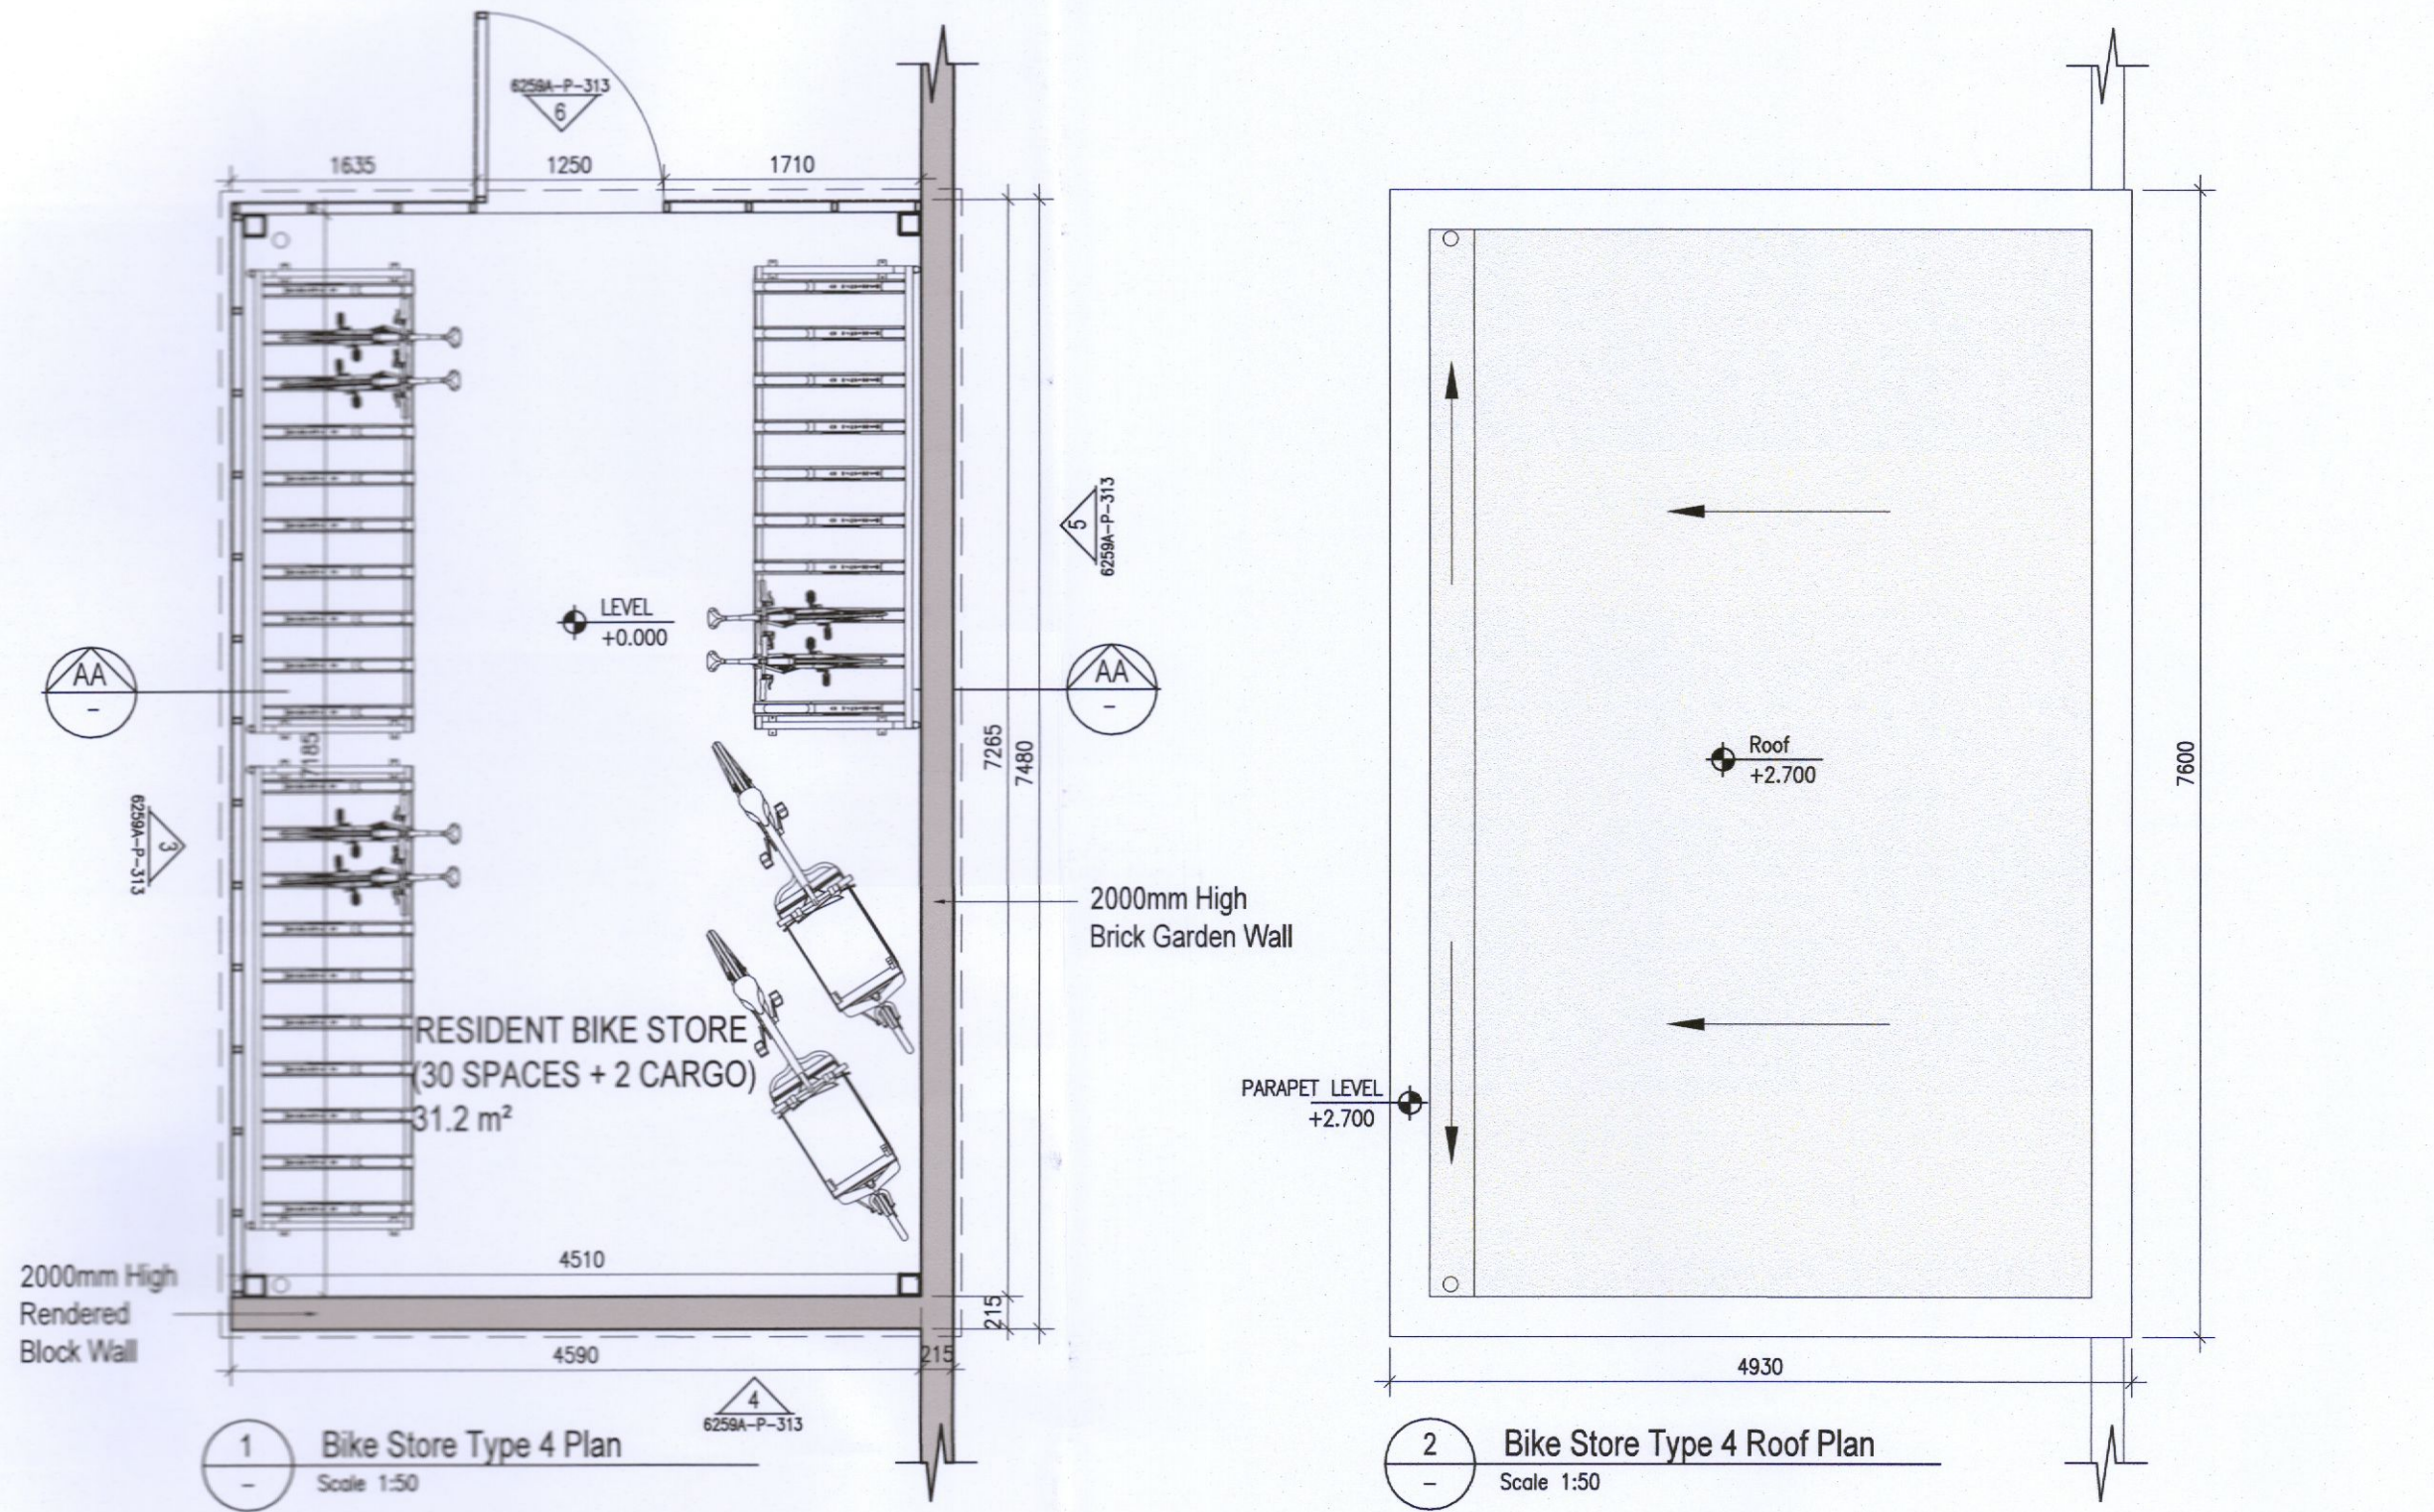

REFER TO LANDSCAPE ARCHITECT'S DRAWINGS FOR ALL LANDSCAPING DETAILS

Notes	
1. Copyright Reserved	
2. Work to figured dimensions only. Do not scale drawing.	
3. The contractor is responsible for checking all levels and dimensions on site and shall refer all discrepancies to the Architect.	
4. Where appropriate, for details of i.e. structure, or mechanical and electrical details, see Engineers drawings.	
5. Proprietary items shall be fixed in strict accordance with manufacturers instructions.	
6. Sizes of proprietary items shall be checked with manufacturer.	
7. The contractor shall be responsible for the coordination of structure, finishes and services.	

Issue Status	No.	Date	Revision	Initials
Progress	01	24.10.2022	ISSUED FOR PLANNING	ED
Planning Application				
Fire Cert				
Disability Cert				
Tender				
Construction				
As Built				
Information Only				

Project	Aderrig Phase 3 Adamstown SDZ Residential Development		6-7 HARCOURT TERRACE, DUBLIN 2, IRELAND T: +353-1-618 2400 F: +353-1-678 7885 e: architecture@bkd.ie www.bkd.ie
Drawing Title	Bike Store Details Type 4		bkd architects BURKE-KENNEDY DOYLE
Drawing No	6259A-P-313		
Scale	1:50 @A1	Rev 01	