



1 Bike Store Type 5 Plan
Scale 1:50




2 Bike Store Type 5 Roof Plan
Scale 1:50

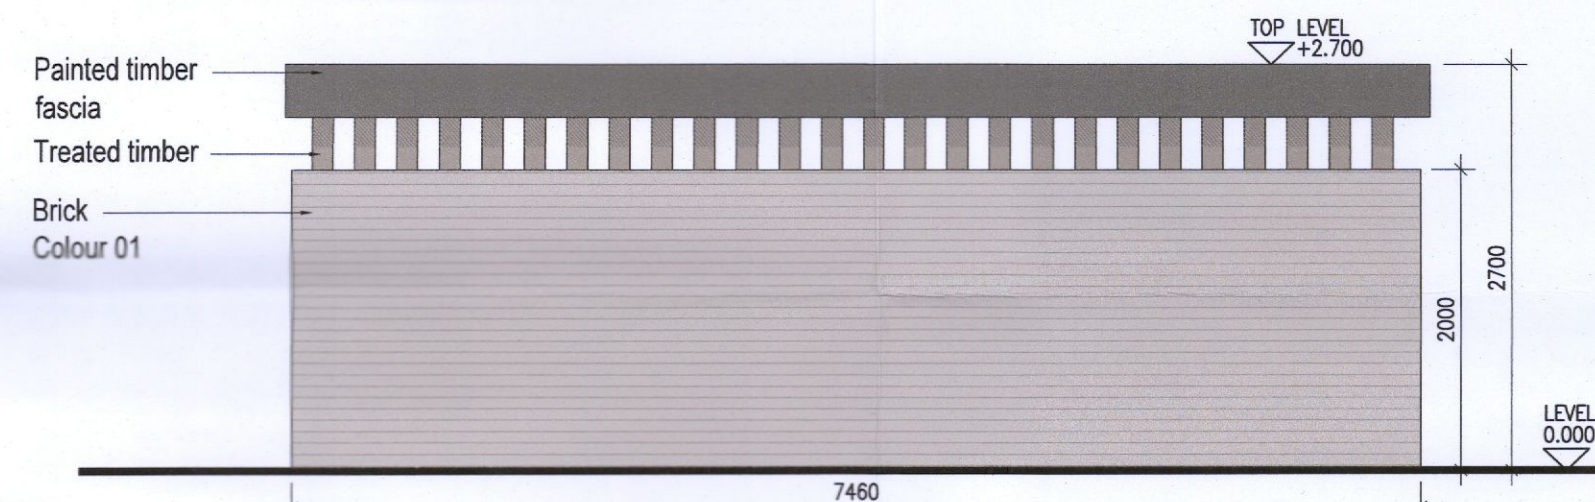


3 Bike Store Type 5 Side Elevation 01
Scale 1:50

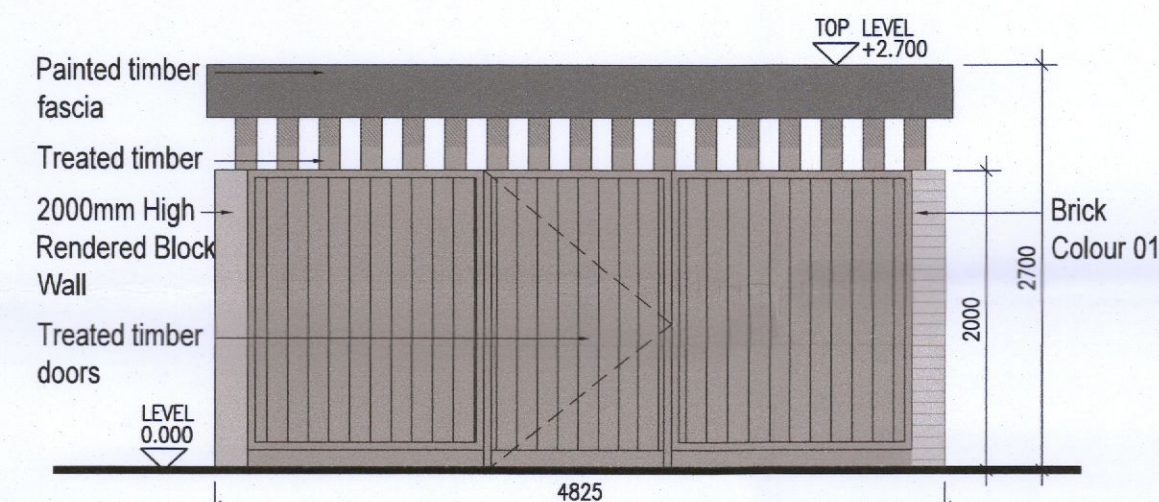


4 Bike Store Type 5 Rear Elevation
Scale 1:50

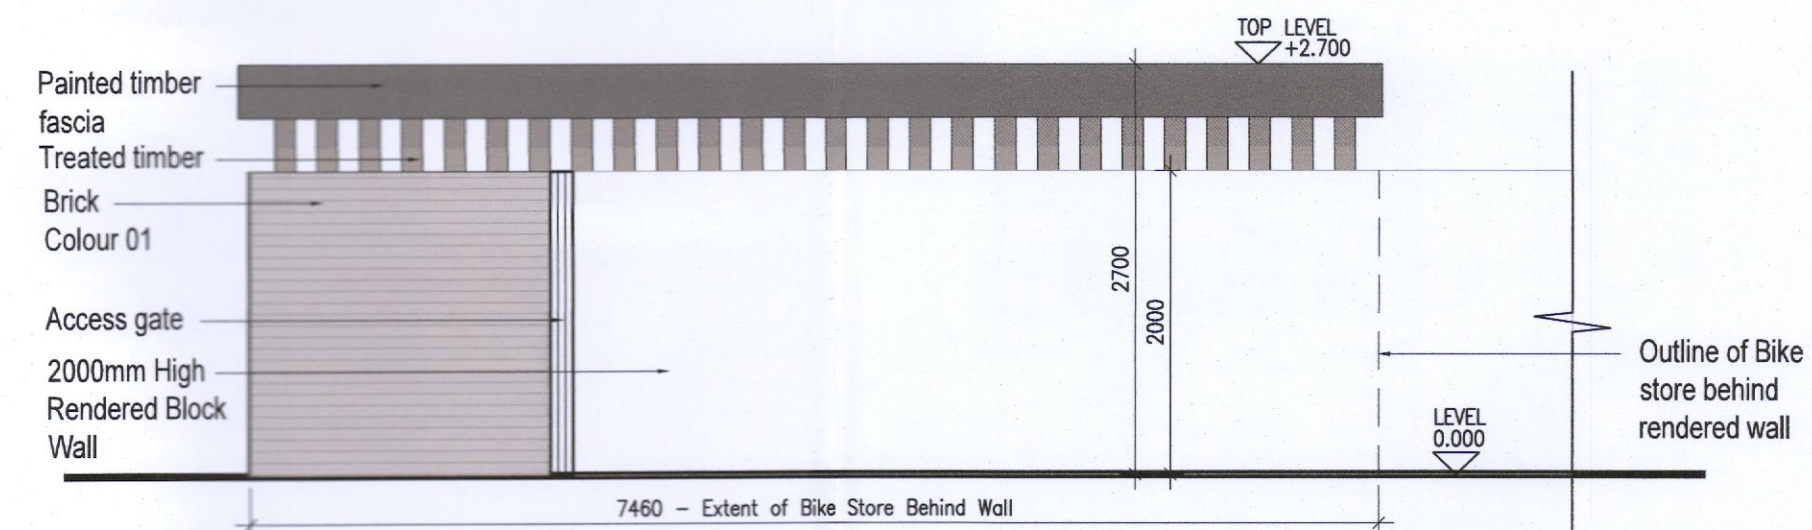

5 Bike Store Type 5 Side Elevation 02
Scale 1:50

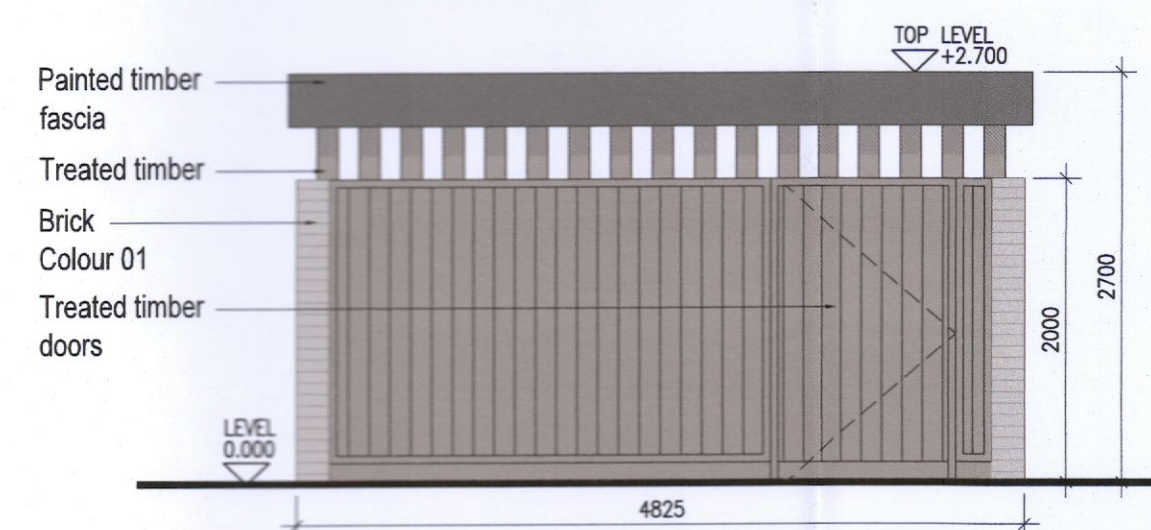


6 Bike Store Type 5 Front Elevation
Scale 1:50

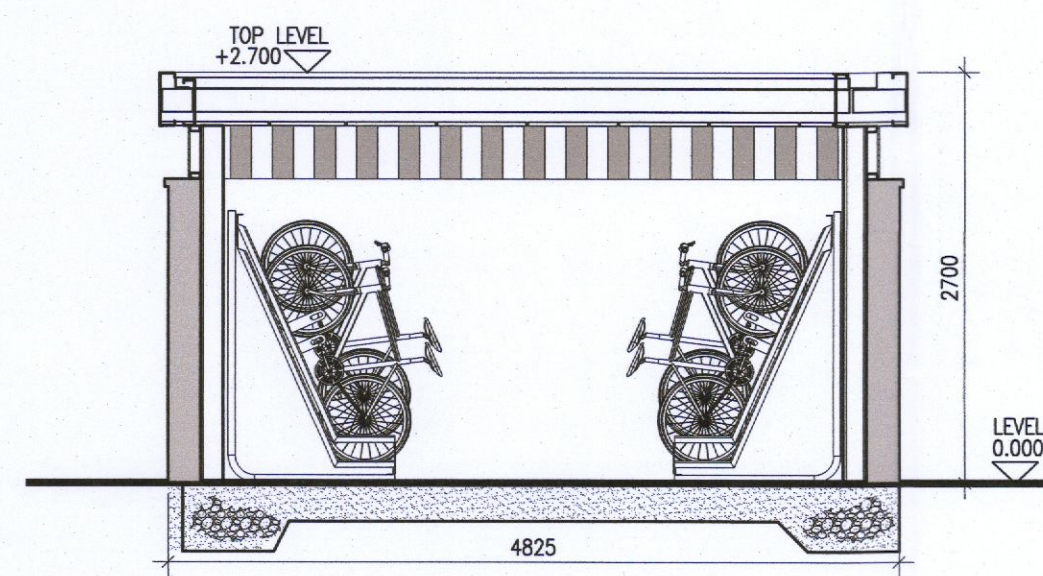

7 Bike Store Type 5 Section A
Scale 1:50

TYPE 5
Communal Bike Store

TYPE 5

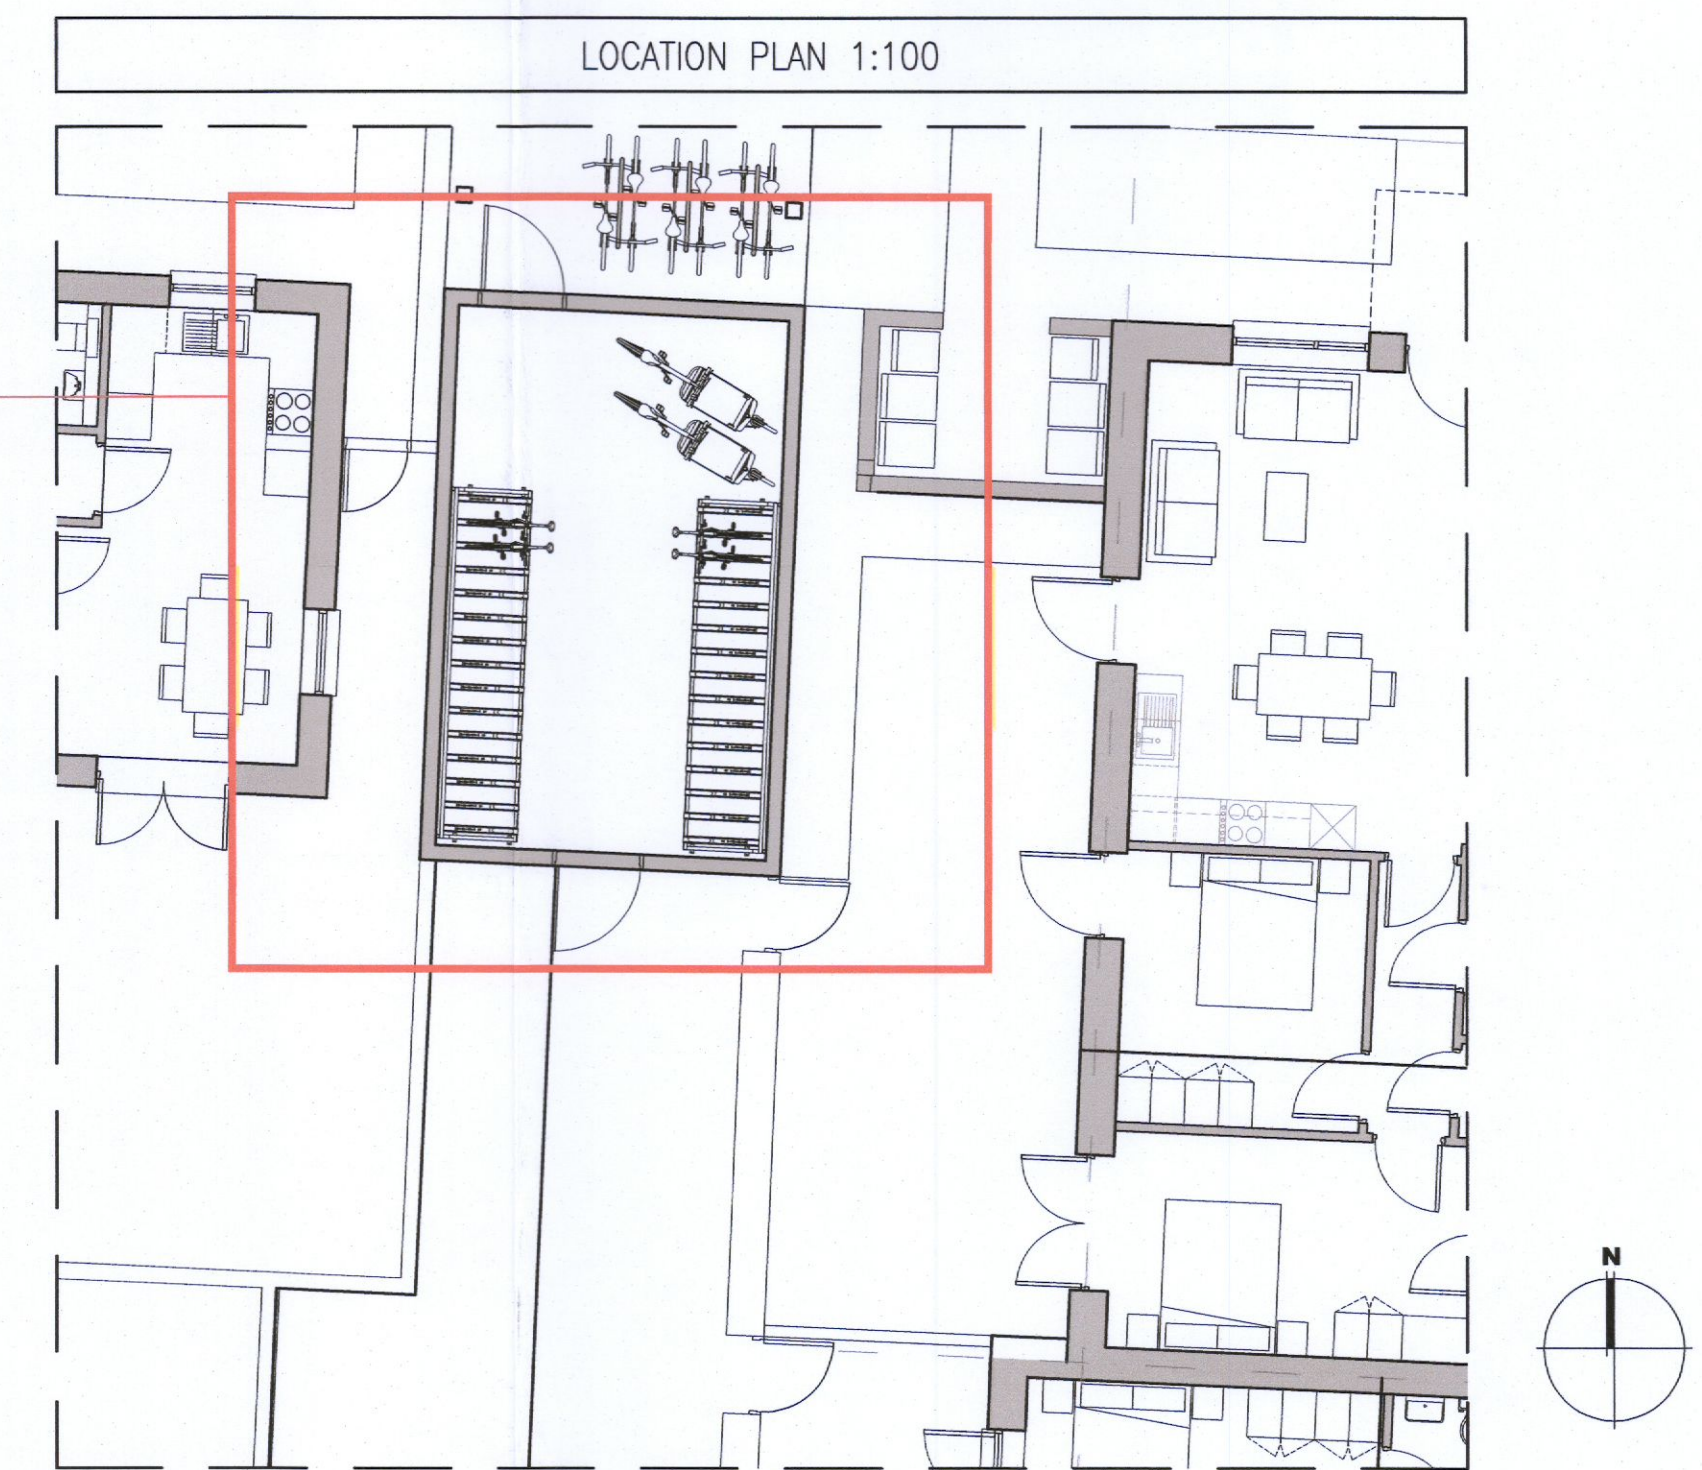

Notes		Issue Status		No.	Date	Revision	Initials
1. Copyright Reserved		Progress		01	10.10.2022	ISSUED FOR PLANNING	AM
2. Work to figured dimensions only. Do not scale drawing.		Planning Application					
3. The contractor is responsible for checking all levels and dimensions on site and shall refer all discrepancies to the Architect		Fire Cert					
4. Where appropriate, for details of i.e. structure, or mechanical and electrical details, see Engineers drawings		Disability Cert					
5. Proprietary items shall be fixed in strict accordance with manufacturers instructions.		Tender					
6. Sizes of proprietary items shall be checked with manufacturer.		Construction					
7. The contractor shall be responsible for the coordination of structure, finishes and services.		As Built					
		Information Only					

Project			
Aderrig Phase 3 Adamstown SDZ Residential Development			
Drawing Title: Bike Store Details Type 5			
Drawing No: 6259A-P-314			
Scale: 1:50 @A1	Rev: 01	Drawn: EPS	Date: OCT 2022

6-7 HARCOURT TERRACE, DUBLIN 2, IRELAND
 T +353 1 618 2400 F +353 1 676 7385
 architecture@bkd.ie
 www.bkd.ie

bkdarchitects
 BURKE-KENNEDY DOYLE