



NOTES:

- DO NOT SCALE. USE FIGURED DIMENSIONS ONLY.
- THIS DRAWING IS TO BE READ IN CONJUNCTION WITH ALL OTHER RELEVANT ARCHITECTURAL AND ENGINEERING DRAWINGS.
- IT IS THE CONTRACTOR'S RESPONSIBILITY TO ENSURE THAT ALL WORKS ARE CONSTRUCTED IN ACCORDANCE WITH THE IRISH WATER CODE OF PRACTICE AND STANDARD DETAILS. THE CODE OF PRACTICE AND STANDARD DETAILS ARE AVAILABLE TO DOWNLOAD FROM THE IRISH WATER WEBSITE AT WWW.WATER.IE/CONNECTIONS/DEVELOPER-SERVICES/ WHERE THE DETAILS CONTAINED ON THIS DRAWING DIFFER FROM THE IRISH WATER CODE OF PRACTICE OR STANDARD DETAILS THIS MUST BE BROUGHT TO THE ATTENTION OF THE ENGINEER IMMEDIATELY. IRISH WATER STANDARDS WILL TAKE PRECEDENCE.

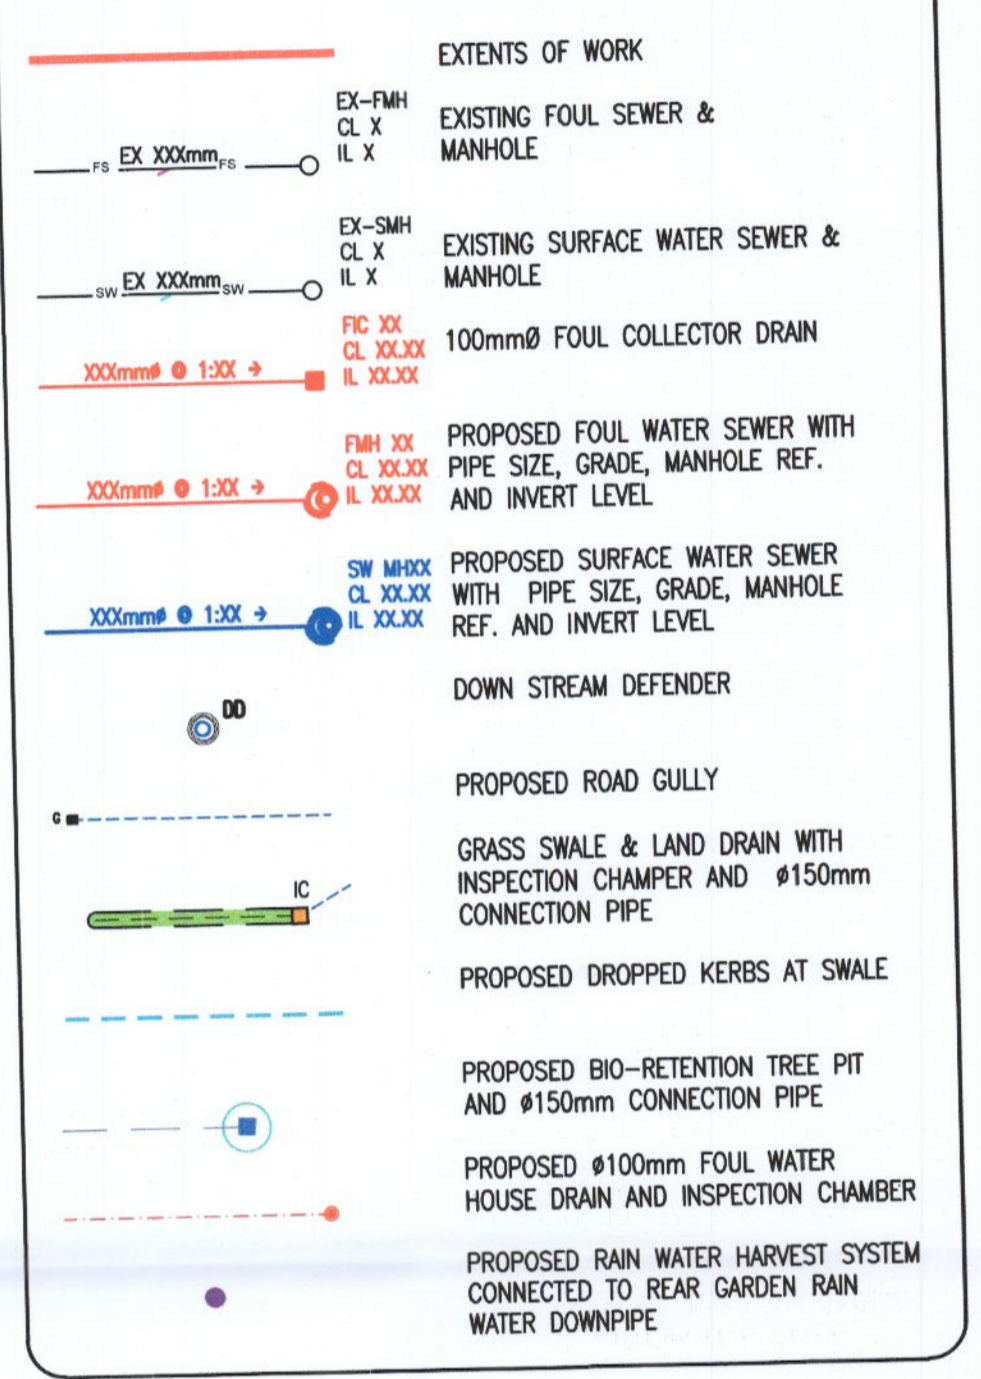

INSET A SCALE 1:500

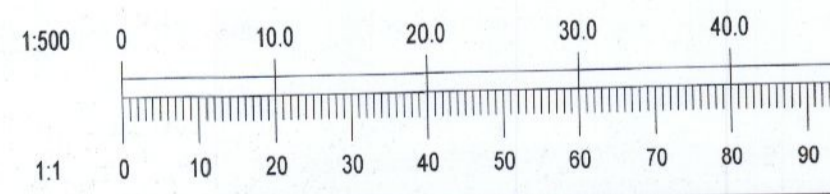

Ordnance Survey Ireland Licence No. EN 0006022 © Ordnance Survey Ireland/Government of Ireland.

07/10/22	ISSUED FOR PLANNING	MS
REV.	DATE	AMENDMENT

STATUS **FOR PLANNING ONLY NOT FOR CONSTRUCTION**

Waterman Moylan
Engineering Consultants
BLOCK 5, EASTPOINT BUSINESS PARK, ALFIE BYRNE ROAD
DUBLIN D03 H3F4 IRELAND
Tel: (01) 684 8900 Fax: (01) 661 3618
Email: info@waterman-moylan.ie www.waterman-moylan.ie

CLIENT	QUINTAN IRELAND
ARCHITECT	BKD ARCHITECTS
PROJECT	ADERRIG PHASE 3
TITLE	PROPOSED DRAINAGE LAYOUT

DRAWN	DESIGNED	APPROVED	DATE
MS	KO	IW	OCT. 2022
SCALE	JOB NO.	DRG. NO.	REVISION
1:500 @ A1	22-023	P200	

© 2016. This drawing is copyright. No part of this document may be reproduced or transmitted in any form or by any means without the written permission of the copyright holder. All rights reserved. This document was originally issued.