




Side Elevation.  
Scale @ 1:25

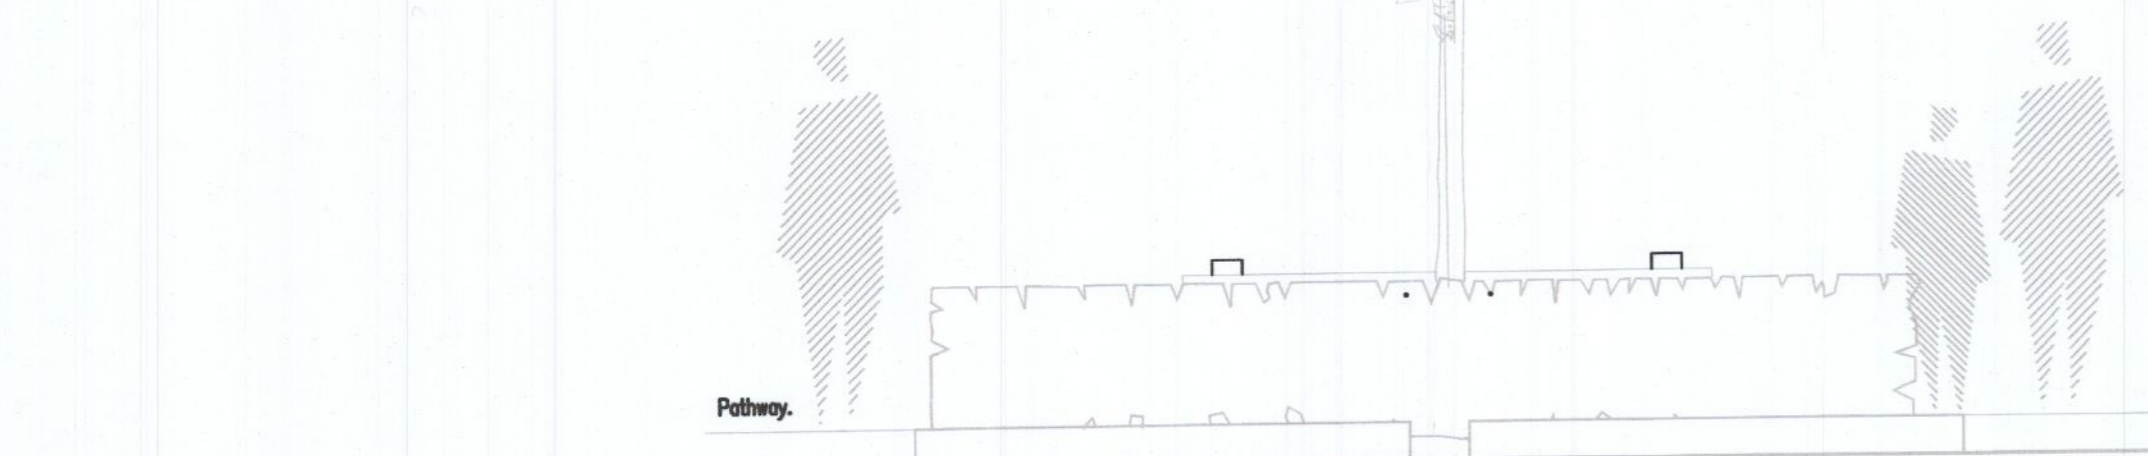


Front Elevation.  
Scale @ 1:25

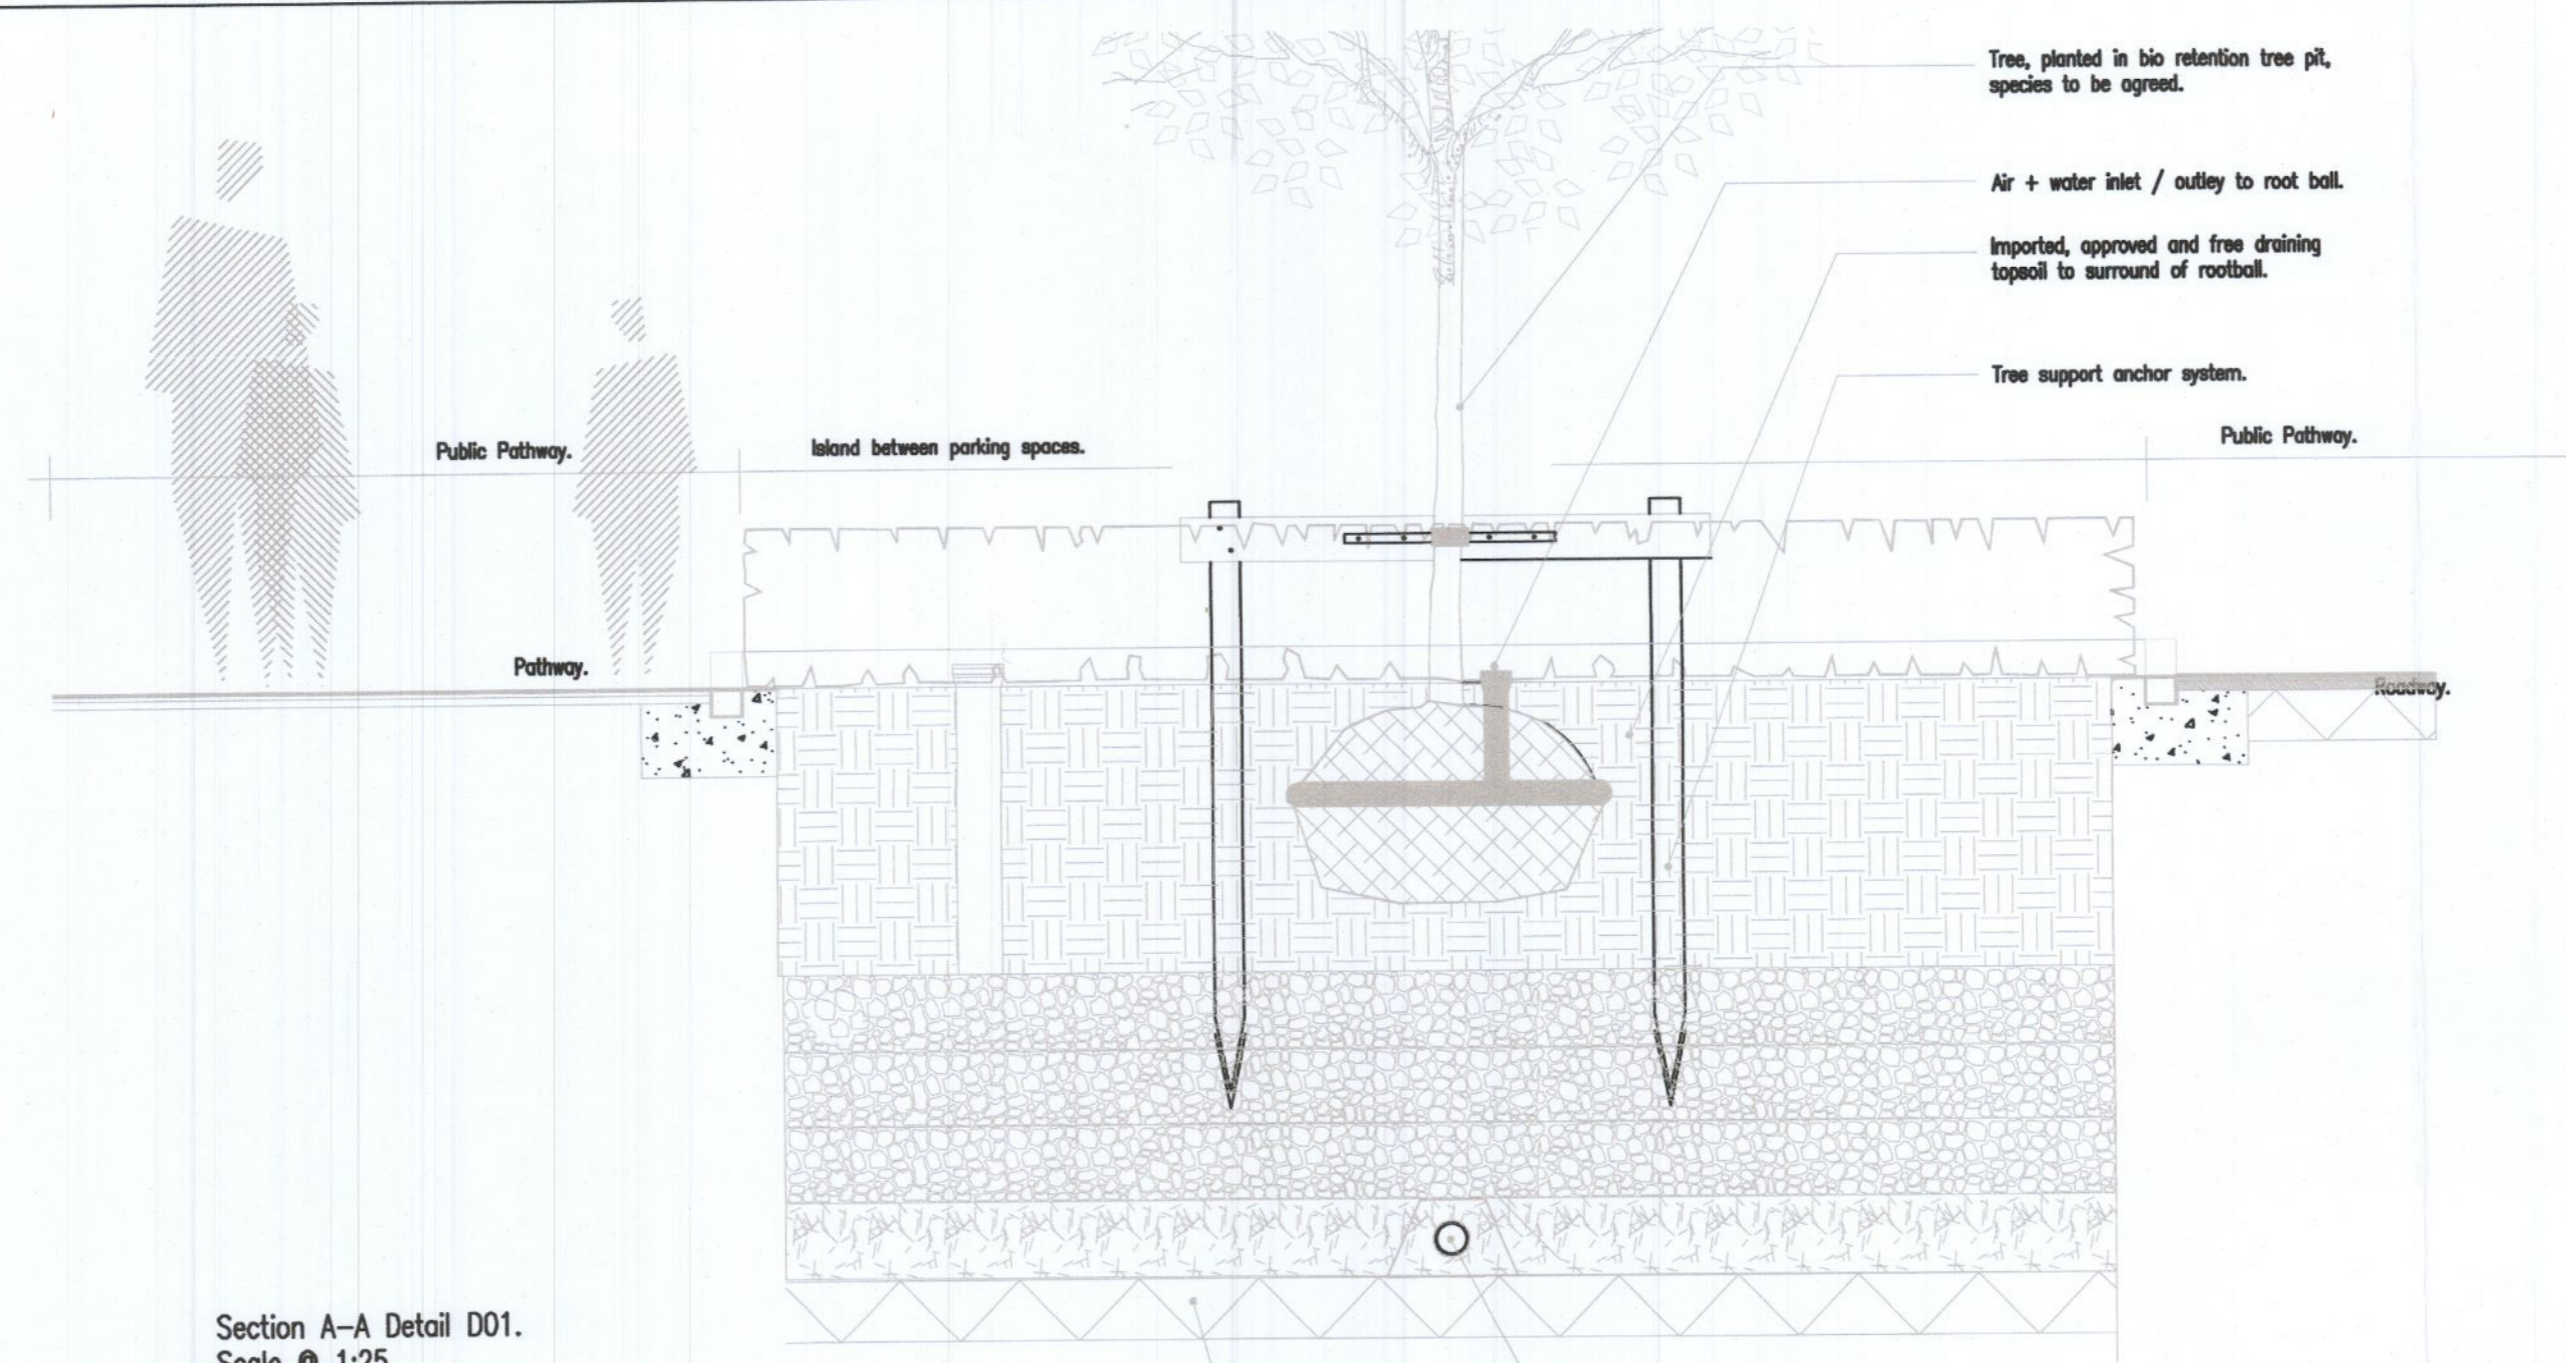


Section A-A Detail D01.  
Scale @ 1:25

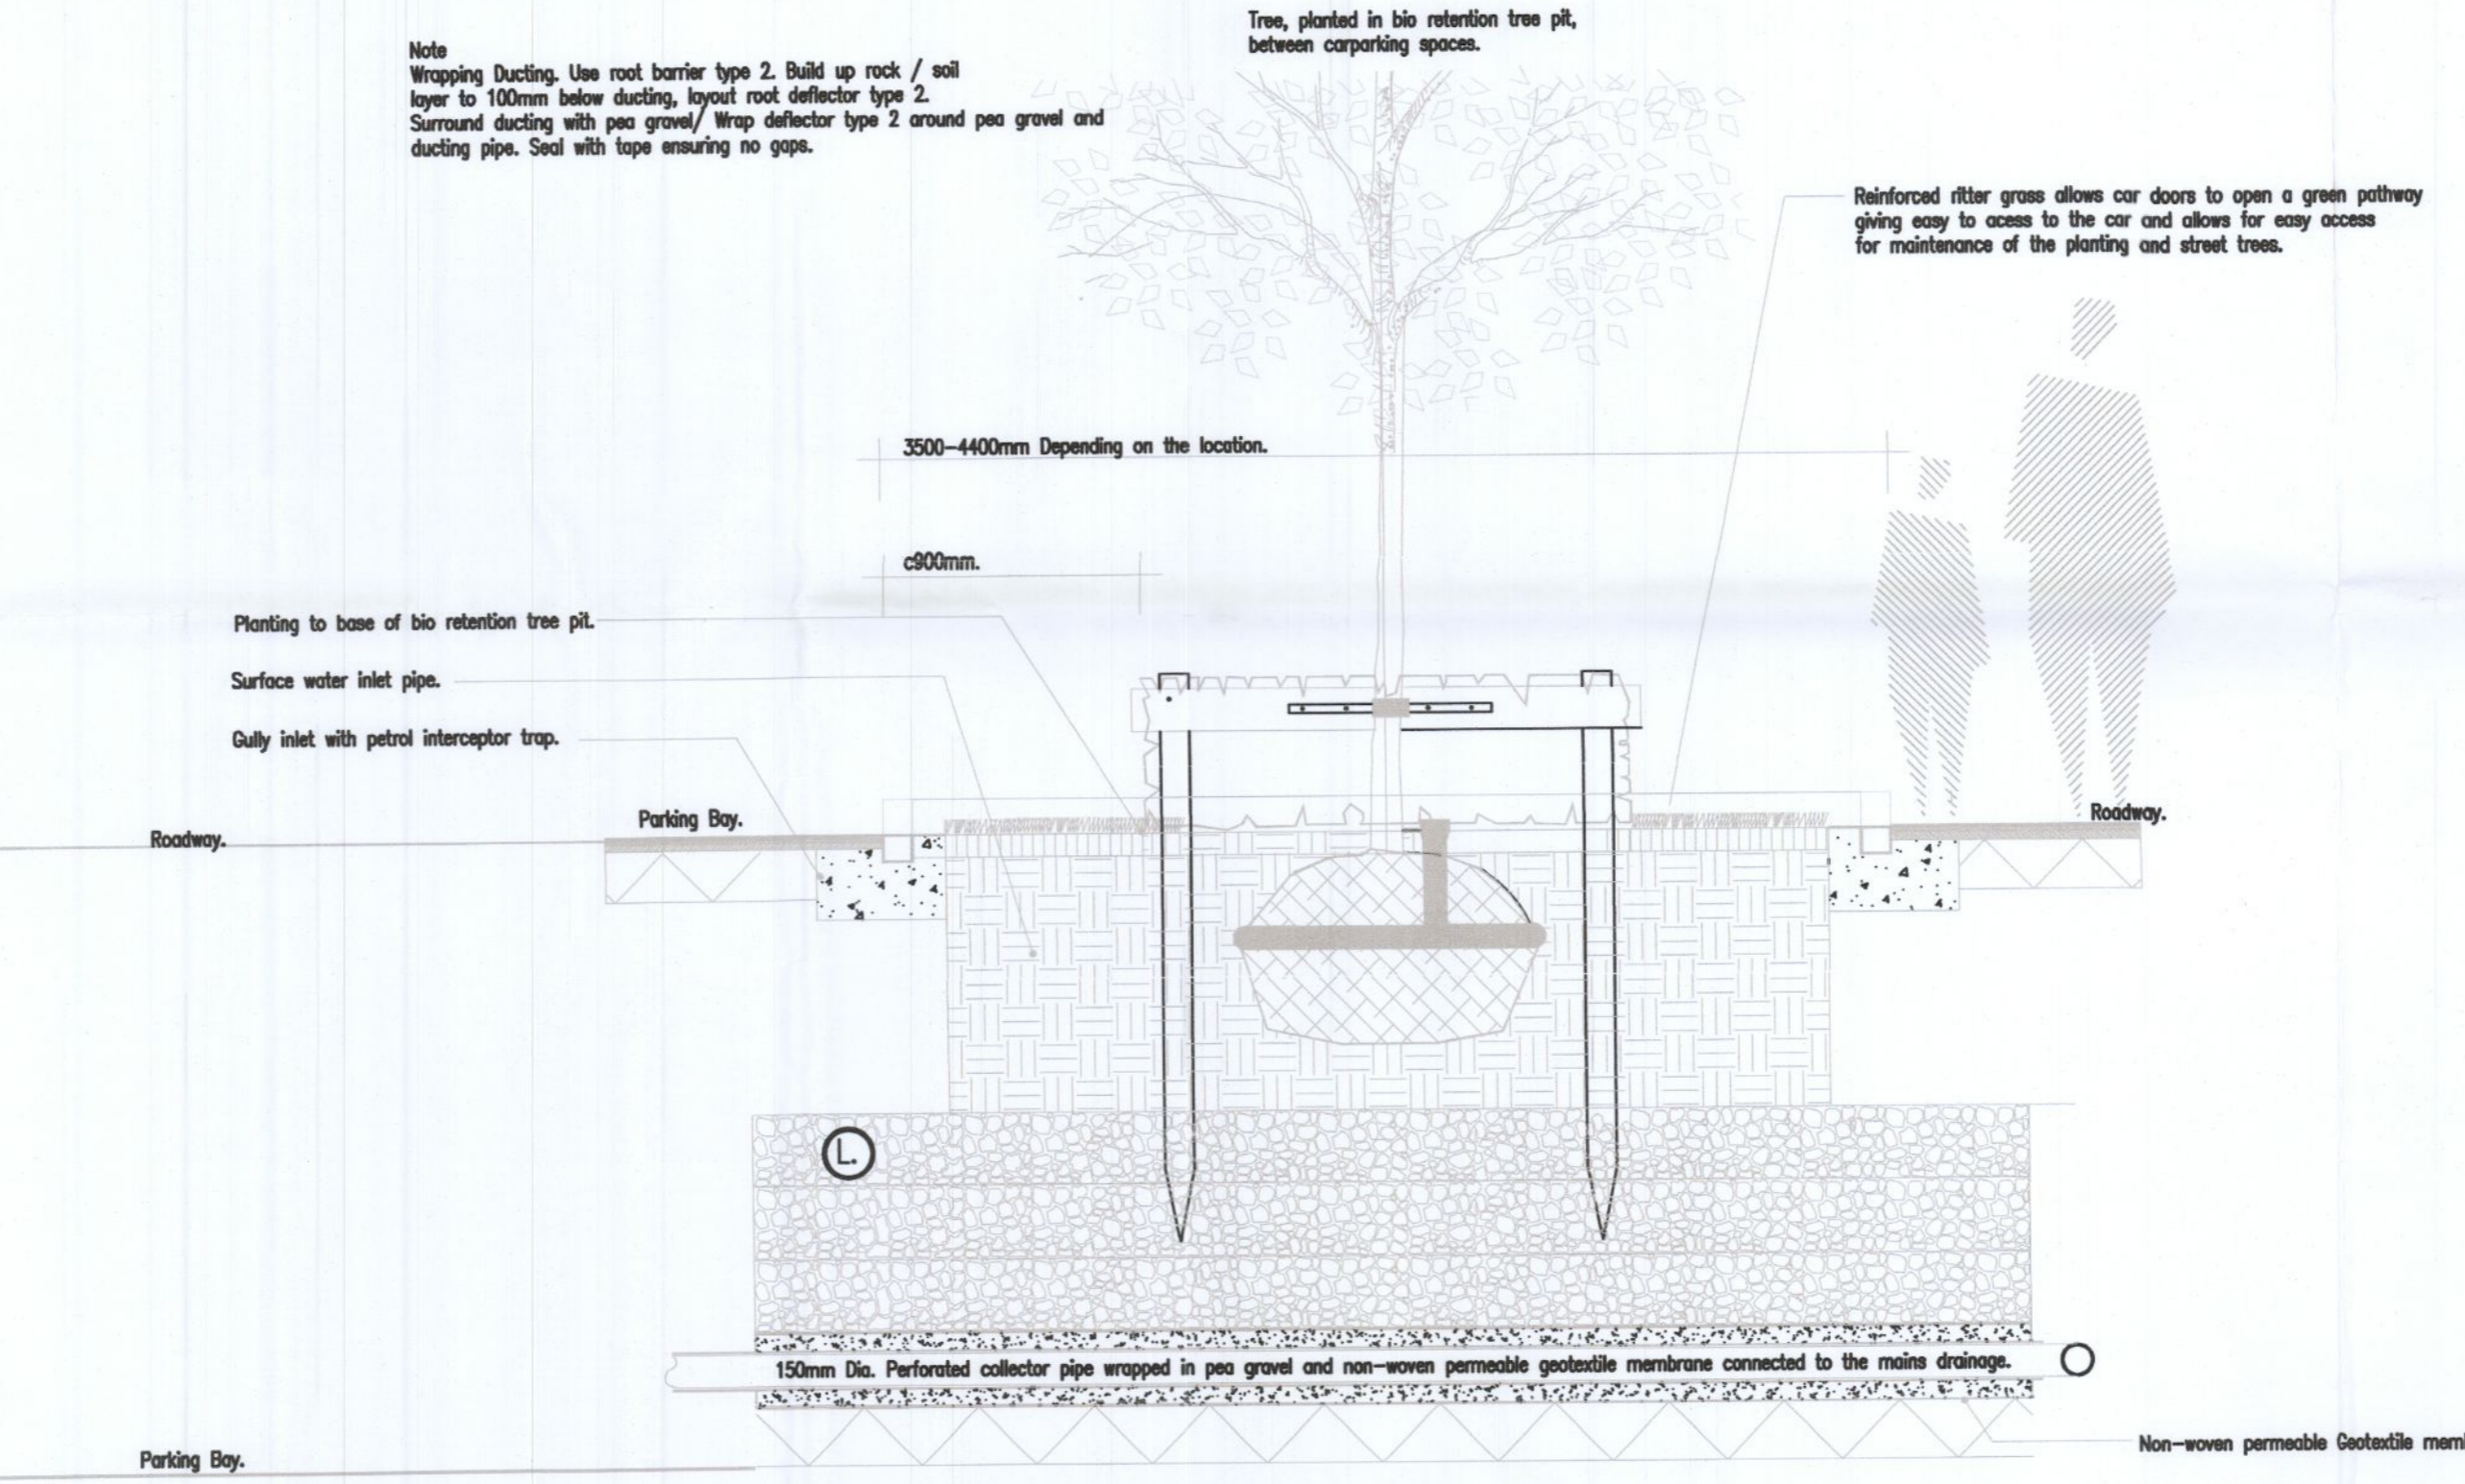

Section B-B Detail D01.  
Scale @ 1:25

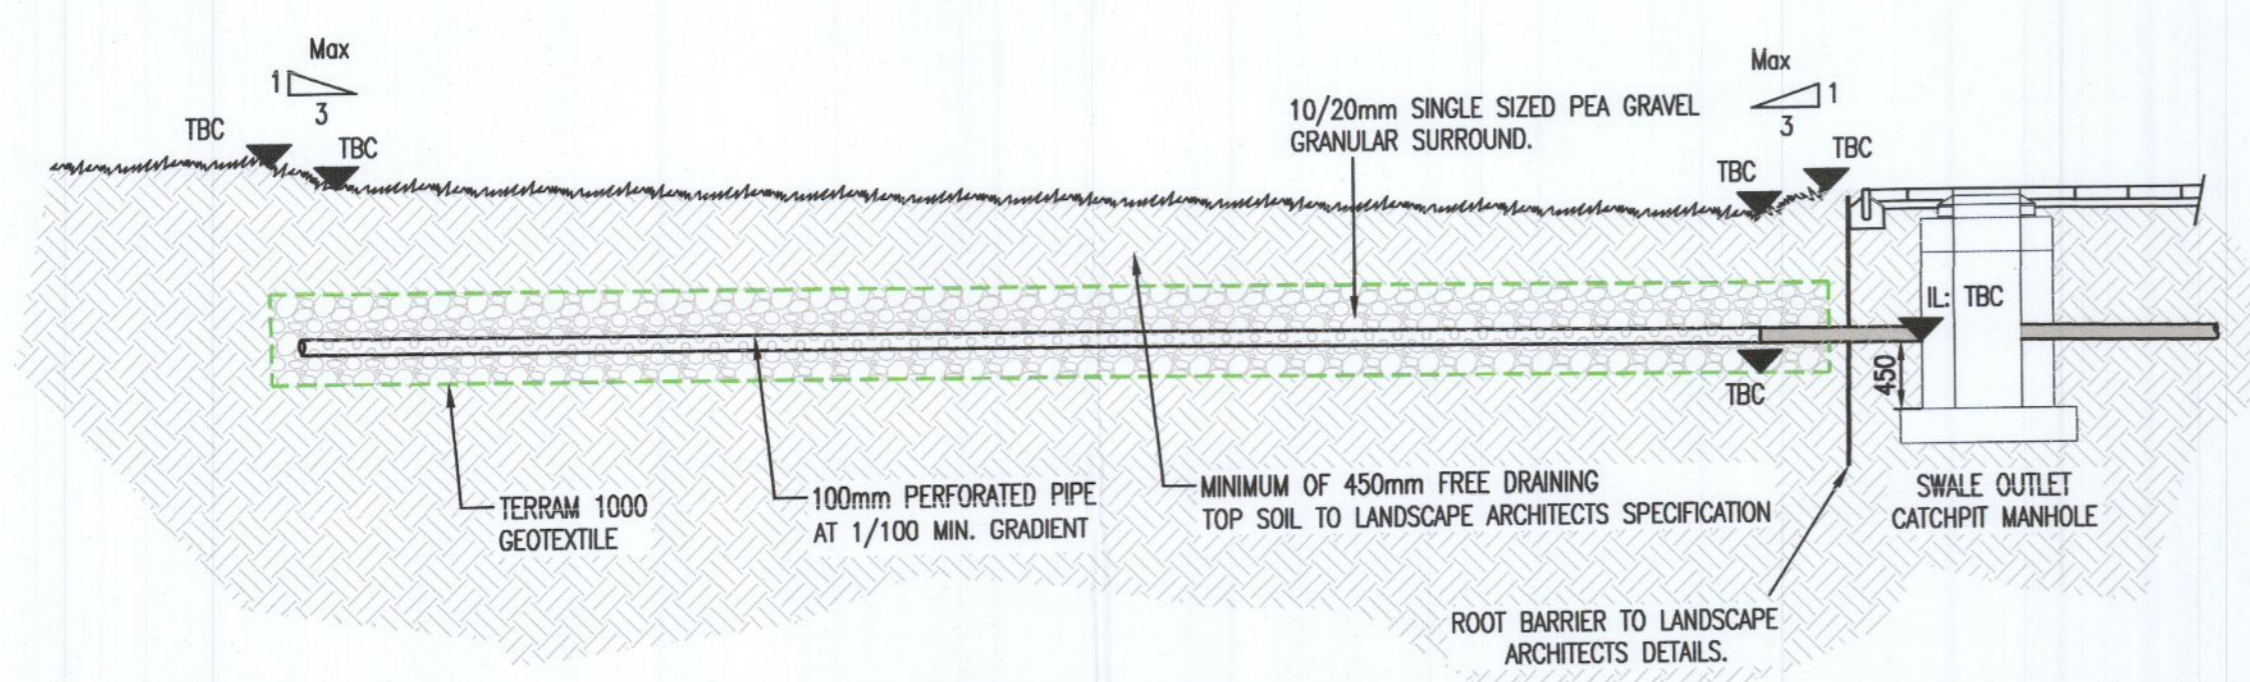





TYPICAL SWALE CROSS SECTION  
SCALE 1:50 @A1

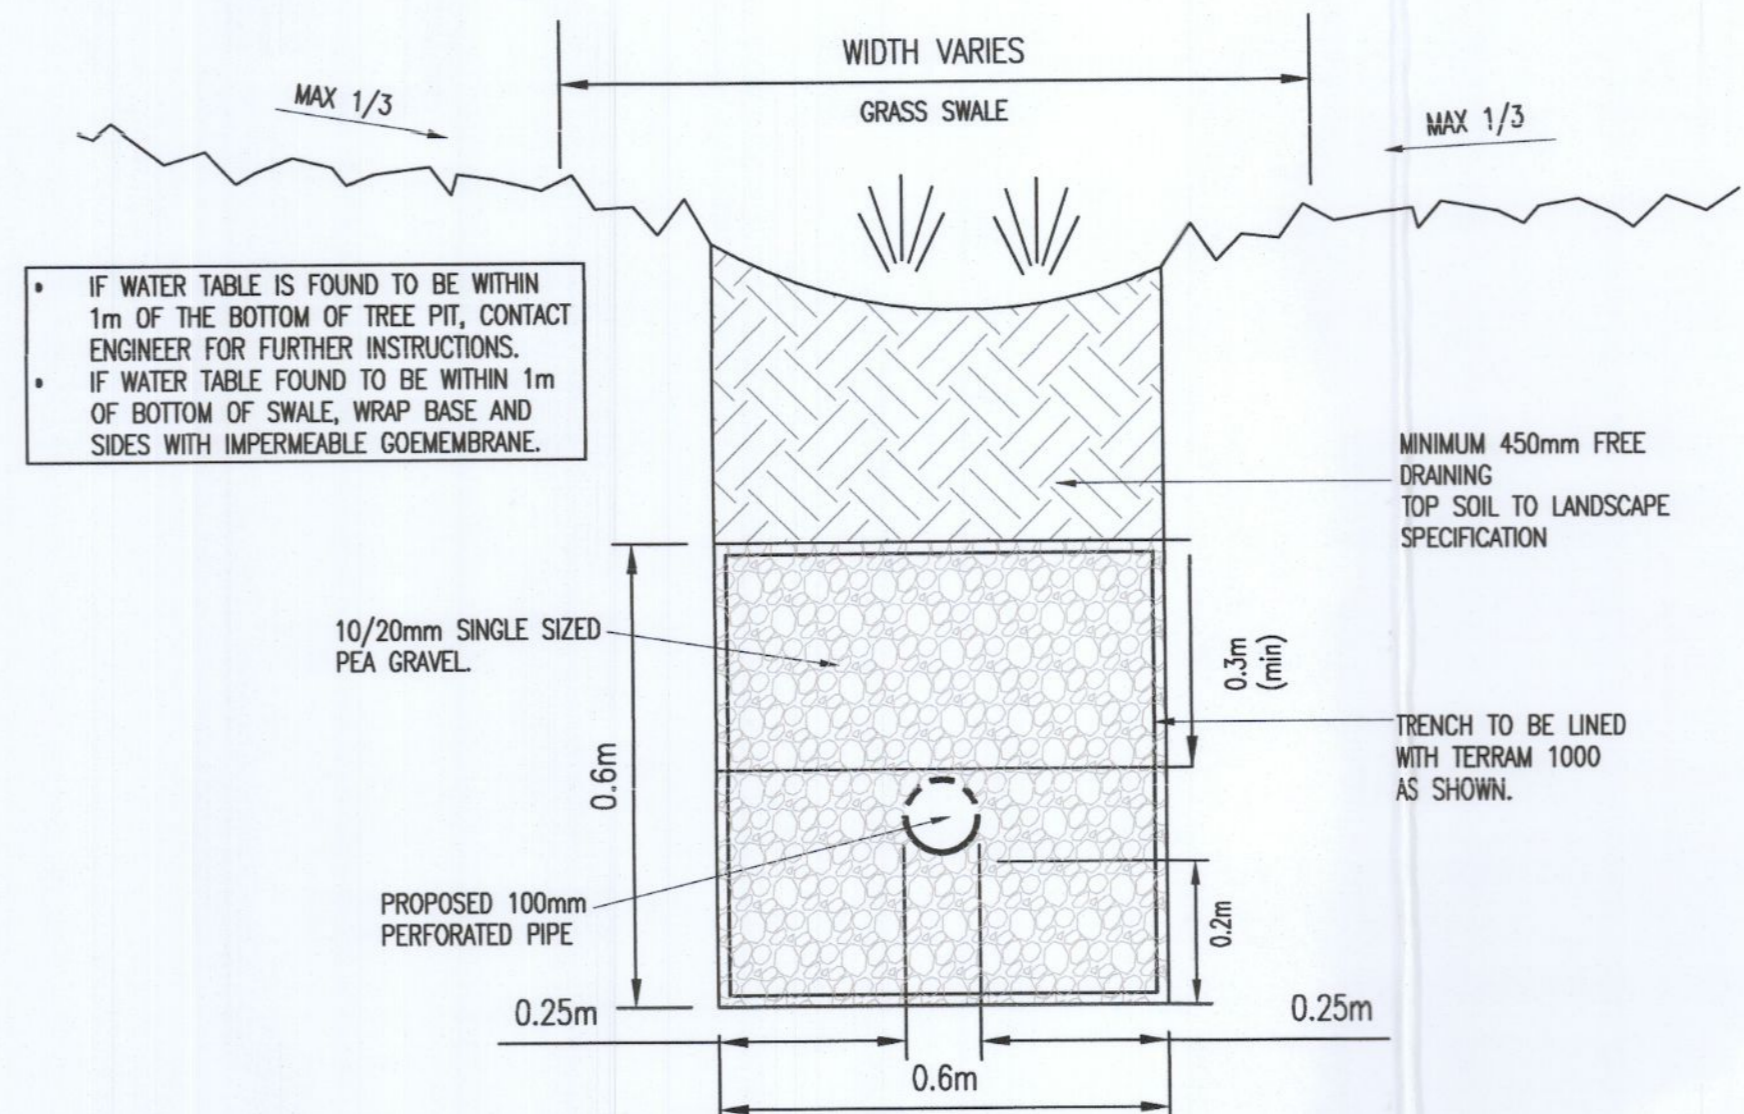

TYPICAL SECTION THROUGH PROPOSED SWALES  
SCALE 1:10 @A1

NOTES:

- DO NOT SCALE. USE FIGURED DIMENSIONS ONLY.
- THIS DRAWING IS TO BE READ IN CONJUNCTION WITH ALL OTHER RELEVANT ARCHITECTURAL AND ENGINEERING DRAWINGS.
- MINIMUM DEPTH OF 1m ABOVE CROWN OF PRIVATE SURFACE WATER/GULLY PIPE TO ALLOW FOR SERVICES IN FOOTPATH.
- ALL SURFACE WATER STRUCTURES AND PIPES TO BE INSTALLED IN ACCORDANCE WITH THE GOSDS AND PART H GUIDELINES.
- SEE LANDSCAPE ARCHITECT LAYOUT AND DETAILS.

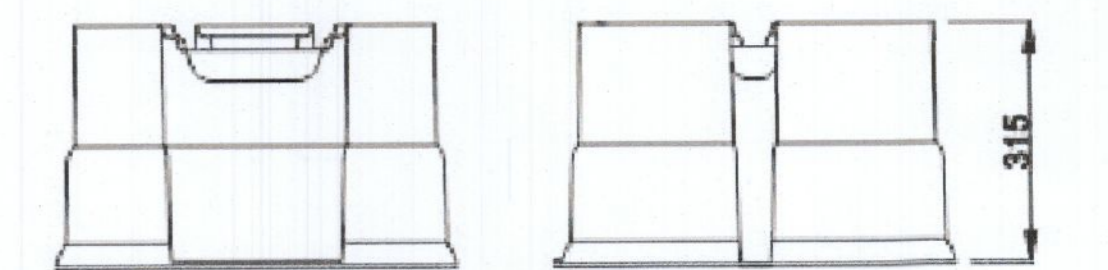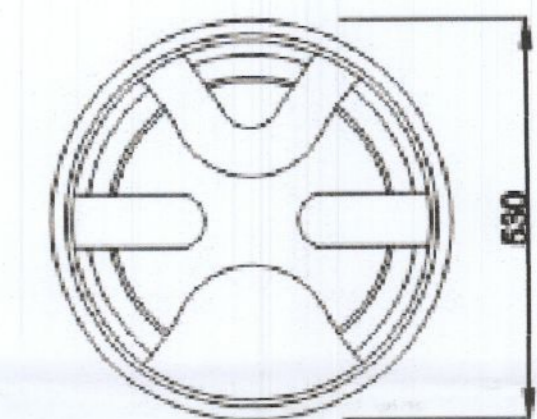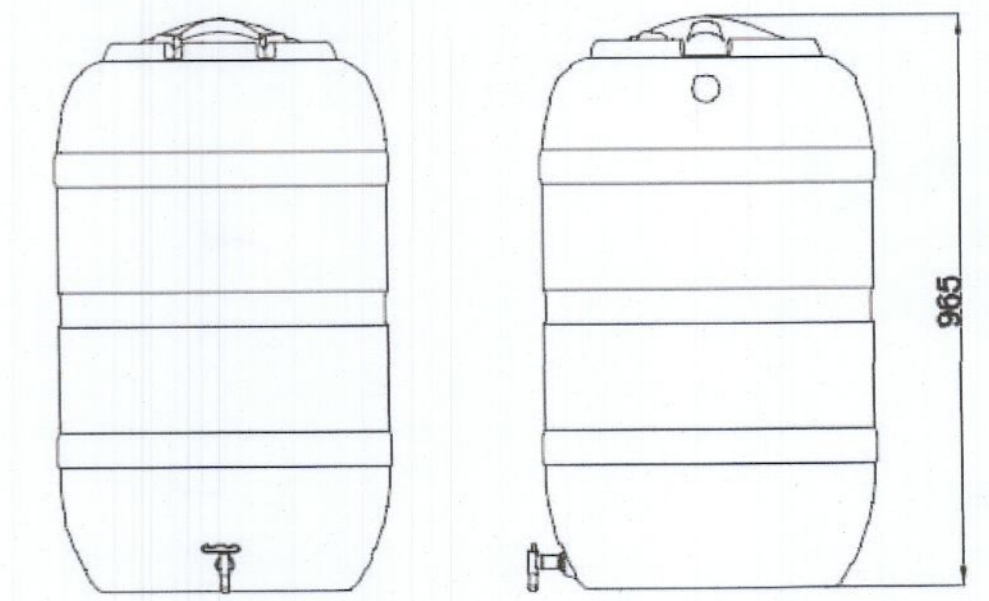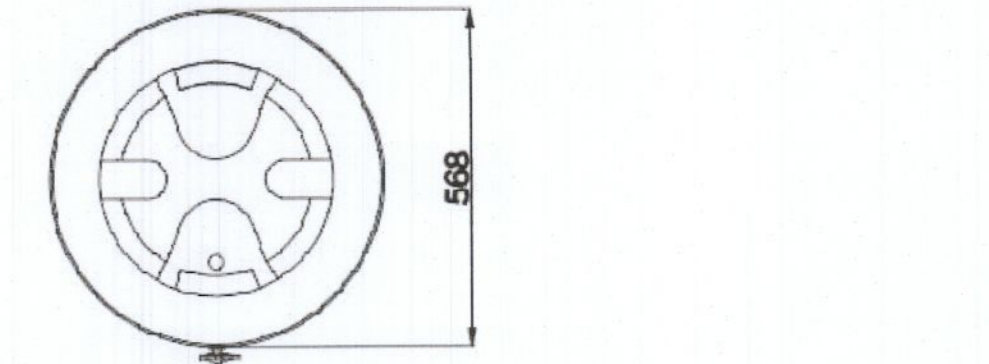

210L STANDARD WATER BUTT  
NTS

- 1 NO. WATER BUTT TO BE INSTALLED IN EACH UNIT'S REAR GARDEN  
- REFER TO THE RELEVANT ARCHITECT DRAWING FOR POSITION AND SPECIFICATION.

REV.	DATE	ISSUED FOR PLANNING	MS	IW
	07/10/22	AMENDMENT	DRN	APPD

STATUS **FOR PLANNING ONLY**  
**NOT FOR CONSTRUCTION**

**Waterman Moylan**  
Engineering Consultants  
BLOCK 5, EASTPOINT BUSINESS PARK, ALFIE BYRNE ROAD,  
DUBLIN D03 H3F4 IRELAND. Tel: (01) 664 8900  
Email: info@waterman-moylan.ie www.waterman-moylan.ie

CLIENT	QUINTAIN IRELAND
ARCHITECT	BKD ARCHITECTS
PROJECT	ADERRIG PHASE 3
TITLE	PROPOSED SuDS DETAILS

DRAWN	DESIGNED	APPROVED	DATE
MS	MS	IW	OCT. 2022
SCALE	JOB NO.	DRG. NO.	REVISION
AS SHOWN @A1	22-023	P206	-