


- DRAWINGS NOTES:**
1. LIGHTING TO BE SUPPLIED VIA A SOLAR TIME CLOCK WITHIN EACH PUBLIC LIGHTING MINI PILLAR.
 2. A MAXIMUM OF 60w LUMINAIRES PER CIRCUIT & 4no. CIRCUITS PER PUBLIC LIGHTING MINI PILLAR.
 3. LIGHT POLES HEIGHT AS PER THE LEGEND DESCRIPTION BELOW WITH A 1 METRE OUTREACH BRACKET & SETBACK 1 METRE FROM KERB.
 4. ALL COLUMNS TO BE HINGED & TO BE AT LEAST 1 METRE CLEAR OF ALL OVERHEAD HIGH VOLTAGE POWER LINES.
 5. FOR SCHEDULES OF EQUIPMENT SEE SPECIFICATION.
 6. THE COMPLETE INSTALLATION TO BE CO-ORDINATED WITH ALL OTHER SERVICES.
- LEGEND OF SYMBOLS:**
- B1 COLUMN 6M POLE MOUNTED ROAD LIGHT WITH 1M OUTREACH
MODEL: XSP1E H-TYPE 25H-50W-4K
 - A1 COLUMN 8M POLE MOUNTED ROAD LIGHT WITH 1M OUTREACH
MODEL: XSP1E E-TYPE 25H-65W-4K
 - C1 DECORATIVE POST-TOP LANTERN WITH SYMMETRIC DISTRIBUTION
MODEL: AWP 38/55/740 RS CL BPS CL3 CON-ANT-190
 - 60x60mm CABLE DRAW PIT/MANHOLE
 - PUBLIC LIGHTING MINI PILLAR
 - PL PUBLIC LIGHTING DUCT

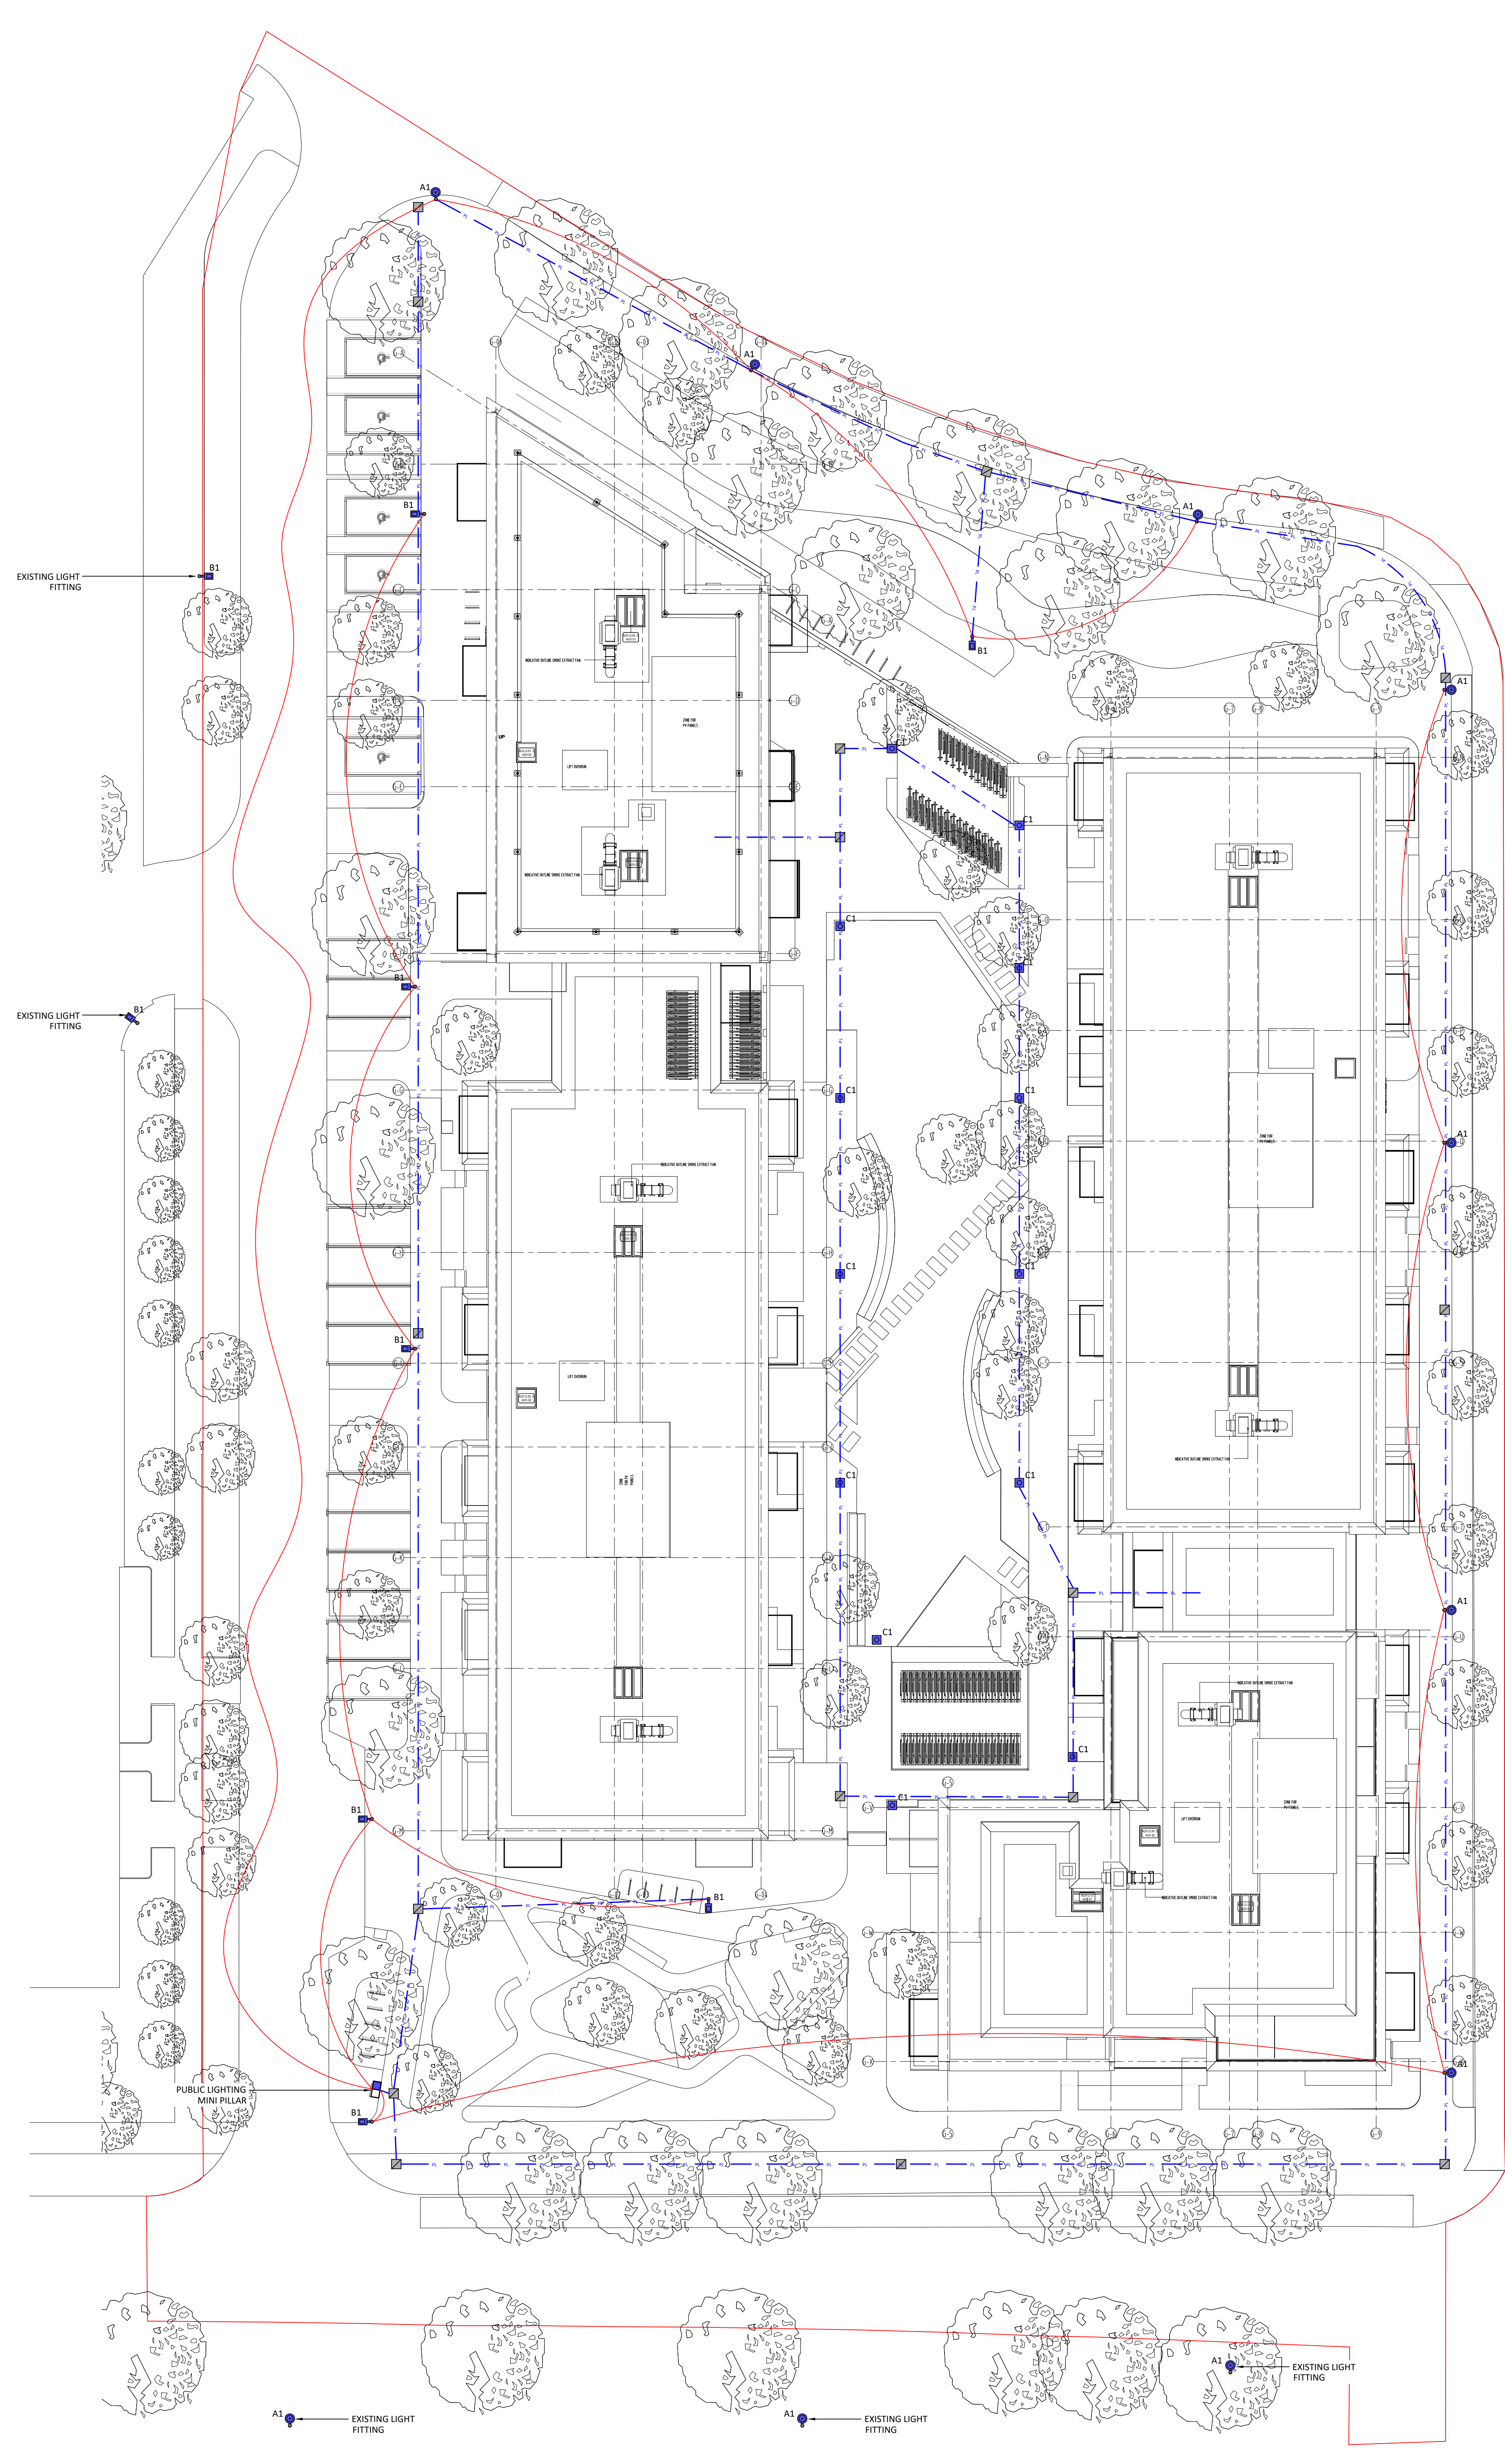

FOR SETTING OUT REFER TO ARCHITECT'S DRAWINGS.
 THIS DRAWING TO BE READ IN CONJUNCTION WITH ALL OTHER ARCHITECTURAL AND ENGINEERING DRAWINGS AND ALL OTHER RELEVANT DRAWINGS AND SPECIFICATIONS.
 DO NOT SCALE THIS DRAWING. USE FIGURED DIMENSIONS ONLY.
 NO PART OF THIS DOCUMENT MAY BE REPRODUCED OR TRANSMITTED IN ANY FORM OR STORED IN ANY RETRIEVAL SYSTEM OF ANY NATURE WITHOUT THE WRITTEN PERMISSION OF O'CONNOR SUTTON CROININ AS COPYRIGHT HOLDER EXCEPT AS AGREED FOR USE ON THE PROJECT FOR WHICH THE DOCUMENT WAS ORIGINALLY ISSUED.

Rev No.	Date	Revision Note	Drn by	Chkd by
P01	11.02.22	SUITABLE FOR TENDER.	I.F.	C.K.

Rev No.	Date	Revision Note	Drn by	Chkd by



Head Office,
 59 Prussia Street,
 Dublin 7,
 D07 KTS7

TEL +353 (0)1 8682000
 e: contactus@ocsc.ie
 w: www.ocsc.ie

Dublin London Belfast Galway Cork Birmingham



Client: QUINTAIN IRELAND LTD.
 Project: ADAMSTOWN STATION
 Co. DUBLIN
 Electrical
 SITE LIGHTING LAYOUT - BLOCK G
 LEVEL 00 - GROUND FLOOR PLAN

Code: [Originator] Zone | Level | Type | Role | Number | Status | Revision
 Q066 OCSC - BG - XX - DR - E - 0001 | D2 | P01

Date: 03.11.21 Scale: 1:200 @ A0 Drn by: I.F. Chkd by: C.K. Aprvd by: E.O.