

Project Title:
 Site Suitability Assessment at
 Redgap, Rathcoole, Co. Dublin

Client: Pearse Mckleaman


Client Address:
 Patrick Joyce Associates
 2 Prospect Grove
 Shocking Lane
 Rathfarnham
 Dublin 16
 Tel: 087 2476375

Drawing Title:
 Drainage Layout Plan


Drawn by: Patrick Joyce
 Scale: 1:500 @ A3
 Date: September 2022

Drawing No.:
 D-2213-01


Drawing Issue:
 PLANNING

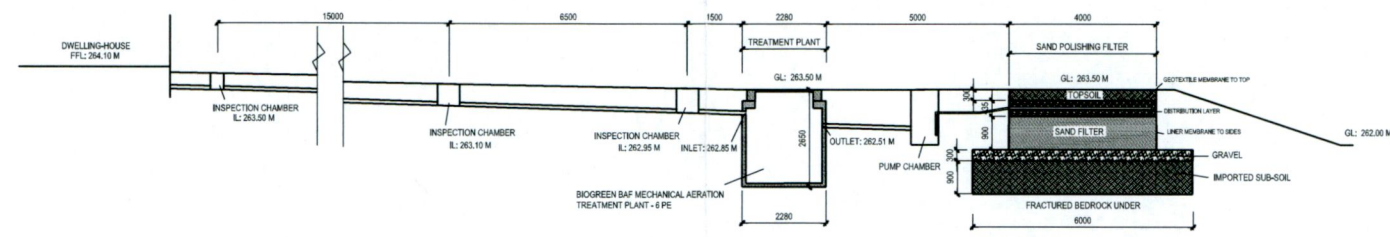


SECTION THROUGH WASTE WATER TREATMENT SYSTEM SCALE 1:100 (A1)

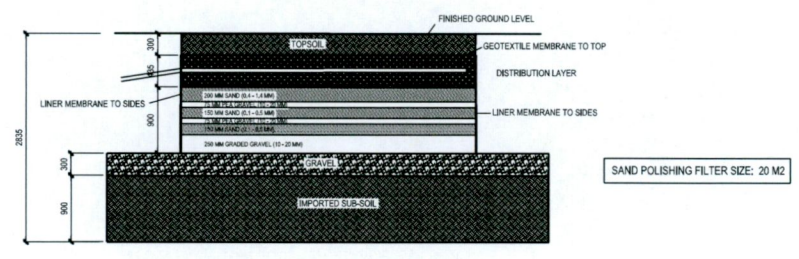

SAND POLISHING FILTER - SECTION SCALE 1:50 (A1)

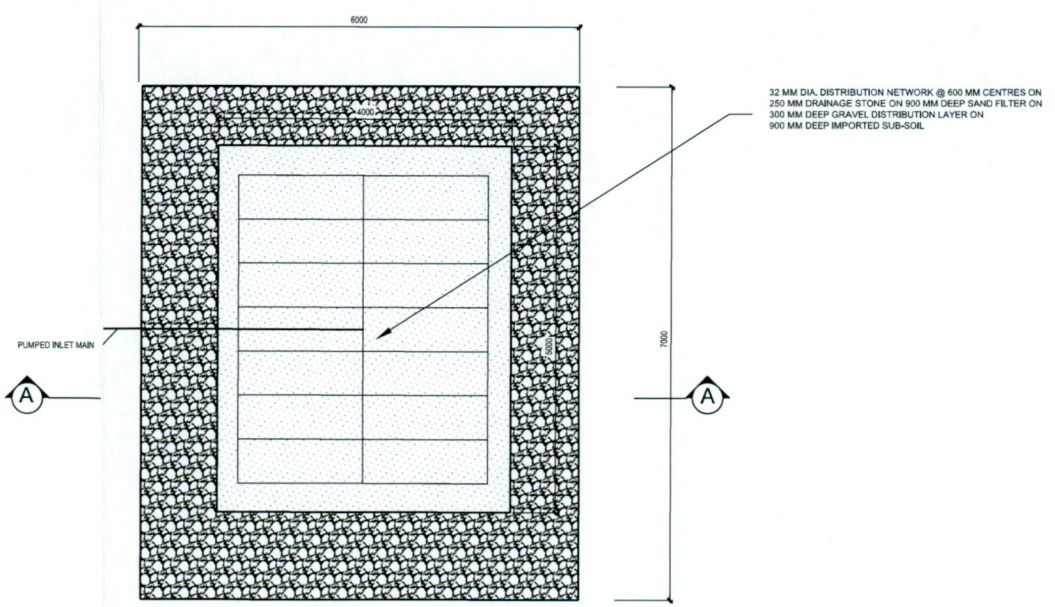

SAND POLISHING FILTER - PLAN SCALE 1:50 (A1)

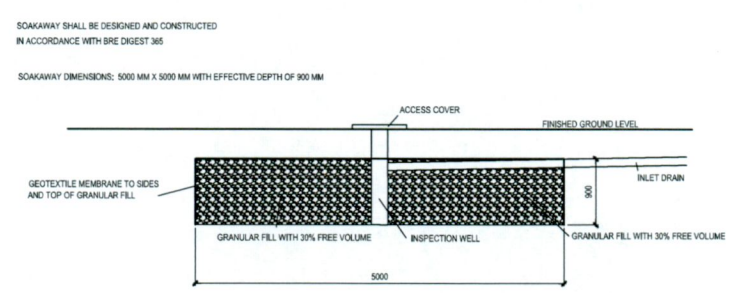

SURFACE WATER SOAKAWAY - SECTION SCALE 1:50 (A1)

SOAKAWAY SHALL BE DESIGNED AND CONSTRUCTED IN ACCORDANCE WITH BRE DIGEST 365
SOAKAWAY DIMENSIONS: 5000 MM X 5000 MM WITH EFFECTIVE DEPTH OF 900 MM

B	ISSUED FOR PLANNING PERMISSION PURPOSES	P.J.	P.J.	14.09.22
A	ISSUED FOR APPROVAL	P.J.	P.J.	15.03.21
REV	DESCRIPTION	BY	APPR	DATE
CLIENT				
MR. PEARSE McKIERNAN				
PROJECT				
PROPOSED DWELLING-HOUSE AT REDGAP, RATHCOOLE, CO. DUBLIN				
TITLE				
WASTE WATER TREATMENT SYSTEM & SURFACE WATER SOAKAWAY DETAILS				
FIRM				
PATRICK JOYCE ASSOCIATES CONSULTING ENGINEERS				
2 Prospect Grove Stocking Lane Rathfarnham Dublin 16		Telephone: (01) 494 6745 E-Mail: patrickjoyceassociates@gmail.com		
DESIGNED:	P.J.	CHECKED:	P.J.	APPRD:
DRAWN:	P.J.	DATE:	MARCH-2021	SCALE:
				AS-SHOWN
DRG.No. D-2213-02				REV.
				B