

SITE LAYOUT PLAN
SCALE 1:500 (A3)


Project Title:
Site Suitability Assessment at
Redgap, Rathcoole, Co. Dublin

Client: Pearse McKiernan
Patrick Joyce Associates
2 Prospect Grove
Stocking Lane
Rathbarney
Dublin 16
Tel: 087 2476375


Drawing Title:
Drainage Layout Plan

Drawn by: Patrick Joyce
Scale: 1:500 @ A3
Date: September 2022


Drawing No: D-2213-01
Drawing Issue: PLANNING

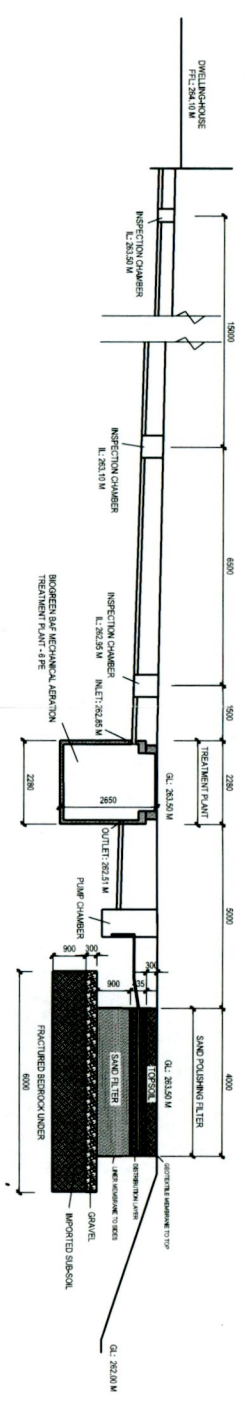


SECTION THROUGH WASTE WATER TREATMENT SYSTEM SCALE 1:100 (A1)

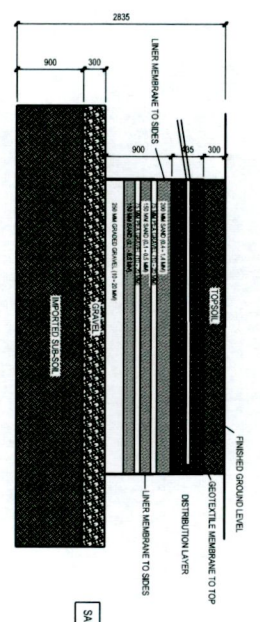

SAND POLISHING FILTER - SECTION SCALE 1:50 (A1)

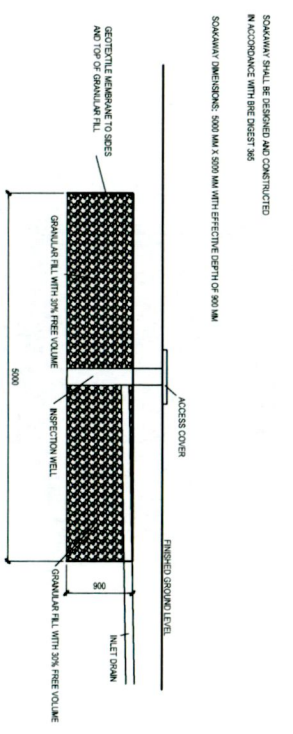

SURFACE WATER SOAKAWAY - SECTION SCALE 1:50 (A1)

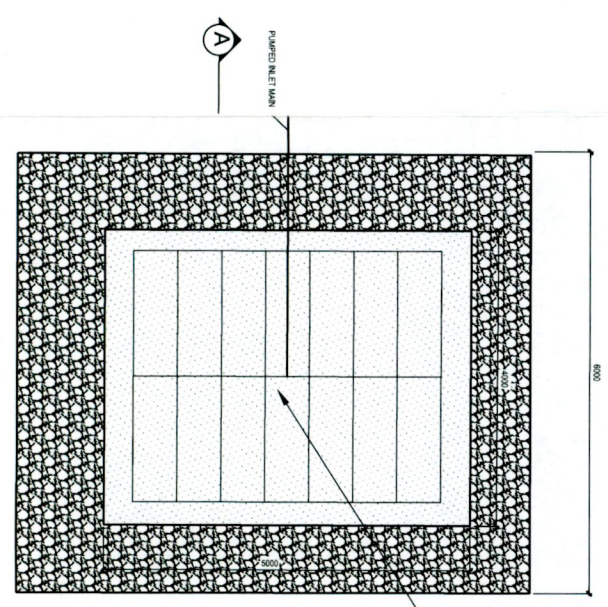

SAND POLISHING FILTER - PLAN SCALE 1:50 (A1)

PROJECT			
PROPOSED DWELLING-HOUSE AT REDGAP, RATHCOOLE, CO. DUBLIN			
PATRICK JOYCE ASSOCIATES CONSULTING ENGINEERS			
TITLE: WASTE WATER TREATMENT SYSTEM & SURFACE WATER SOAKAWAY DETAILS			
CLIENT: MR. PEARSE MCKIERNAN			
REV	DESCRIPTION	P.J.	DATE
B	ISSUED FOR TENDER/REVISION PURPOSES	P.J.	14.03.22
A	ISSUED FOR APPROVAL	P.J.	13.03.21
REV	DESCRIPTION	BY	DATE
DRAWN: P.J.			
CHECKED: P.J.			
DATE: MARCH-2021			
SCALE: AS-SHOWN			
DRC. No. D-2213-02			