


USE FIGURED DIMENSIONS ONLY

ALL DIMENSIONS TO BE CHECKED BY THE CONTRACTOR ON SITE. ANY ERRORS OR DISCREPANCIES TO BE REPORTED TO THE ENGINEER IN CHARGE.

NOTES

1. Drawings to be read in conjunction with all relevant Architects, Engineers and specialists drawings.
2. Do not scale, use given dimensions only. All dimensions are in millimeters except where shown.
3. Inform the Engineer of any discrepancies prior to proceeding with works.
4. This drawing should be printed in colour for clarity.
5. All levels to ordinance datum.
6. All connections, bedding etc is to be done strictly in accordance with Irish Water specifications & details.
7. For addition notes see drawing XXXX-MCE-00-XX-C-0000_Standard Notes

SURFACE WATER LEGEND

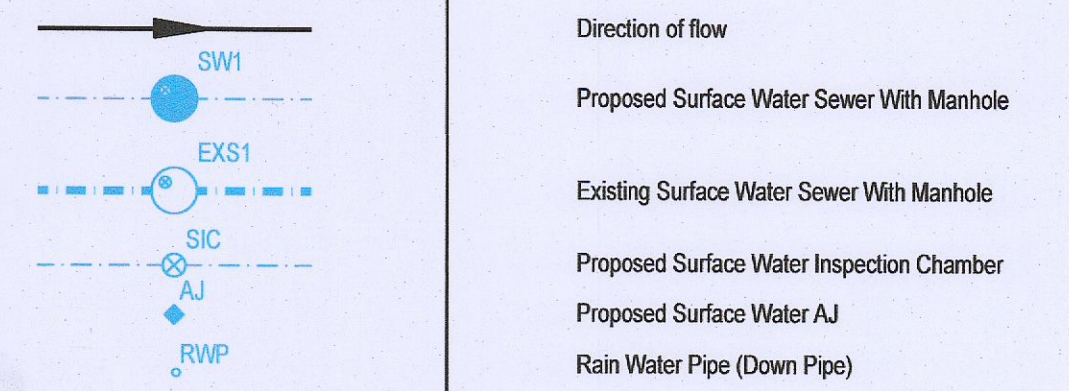

Rev.	Date	Description	By	Check
P2	12.05.2022		LOB	RMC
P1	05.10.2021	ISSUED FOR INFORMATION	LOB	RMC

THIS DRAWING IS COPYRIGHT ©
NO PART OF THIS DRAWING MAY BE REPRODUCED IN ANY FORM OR STORED IN ANY RETRIEVAL SYSTEM OF ANY NATURE WITHOUT THE WRITTEN PERMISSION OF MCE CONSULTING ENGINEERS UNLESS AS AGREED FOR USE ON THE PROJECT FOR WHICH THE DRAWING WAS ORIGINALLY ISSUED.

PLANNING APPLICATION

Project Name: LYNBROOK HOUSES
 Drawing Title: SURFACE WATER DRAINAGE LAYOUT
 Architect: BROCK FINUCANE ARCHITECTS

Drawn: LOB
 Checked: NOB
 Approved: RMC
 Scale: 1:200 @ A1

Project No:	Originator:	Volume:	Level:	Type:	Role:	Number:	Rev:
5558	MCE	00	XX	DR	C	0003	P1

Surface Water Drainage Layout
SCALE 1:200