


All dimensions to be checked on site. Figured dimensions take preference over scaled dimensions. Any errors or discrepancies to be reported to the Architects. This drawing may not be edited or modified by the recipient.

Copyright and ownership of this drawing is vested in RKD Architects, whose prior written consent is required for its use, reproduction or for publication to any third party. All rights reserved by the law of copyright and by international copyright conventions are reserved to RKD Architects and may be protected by court proceedings for damages and/or injunctions and costs.

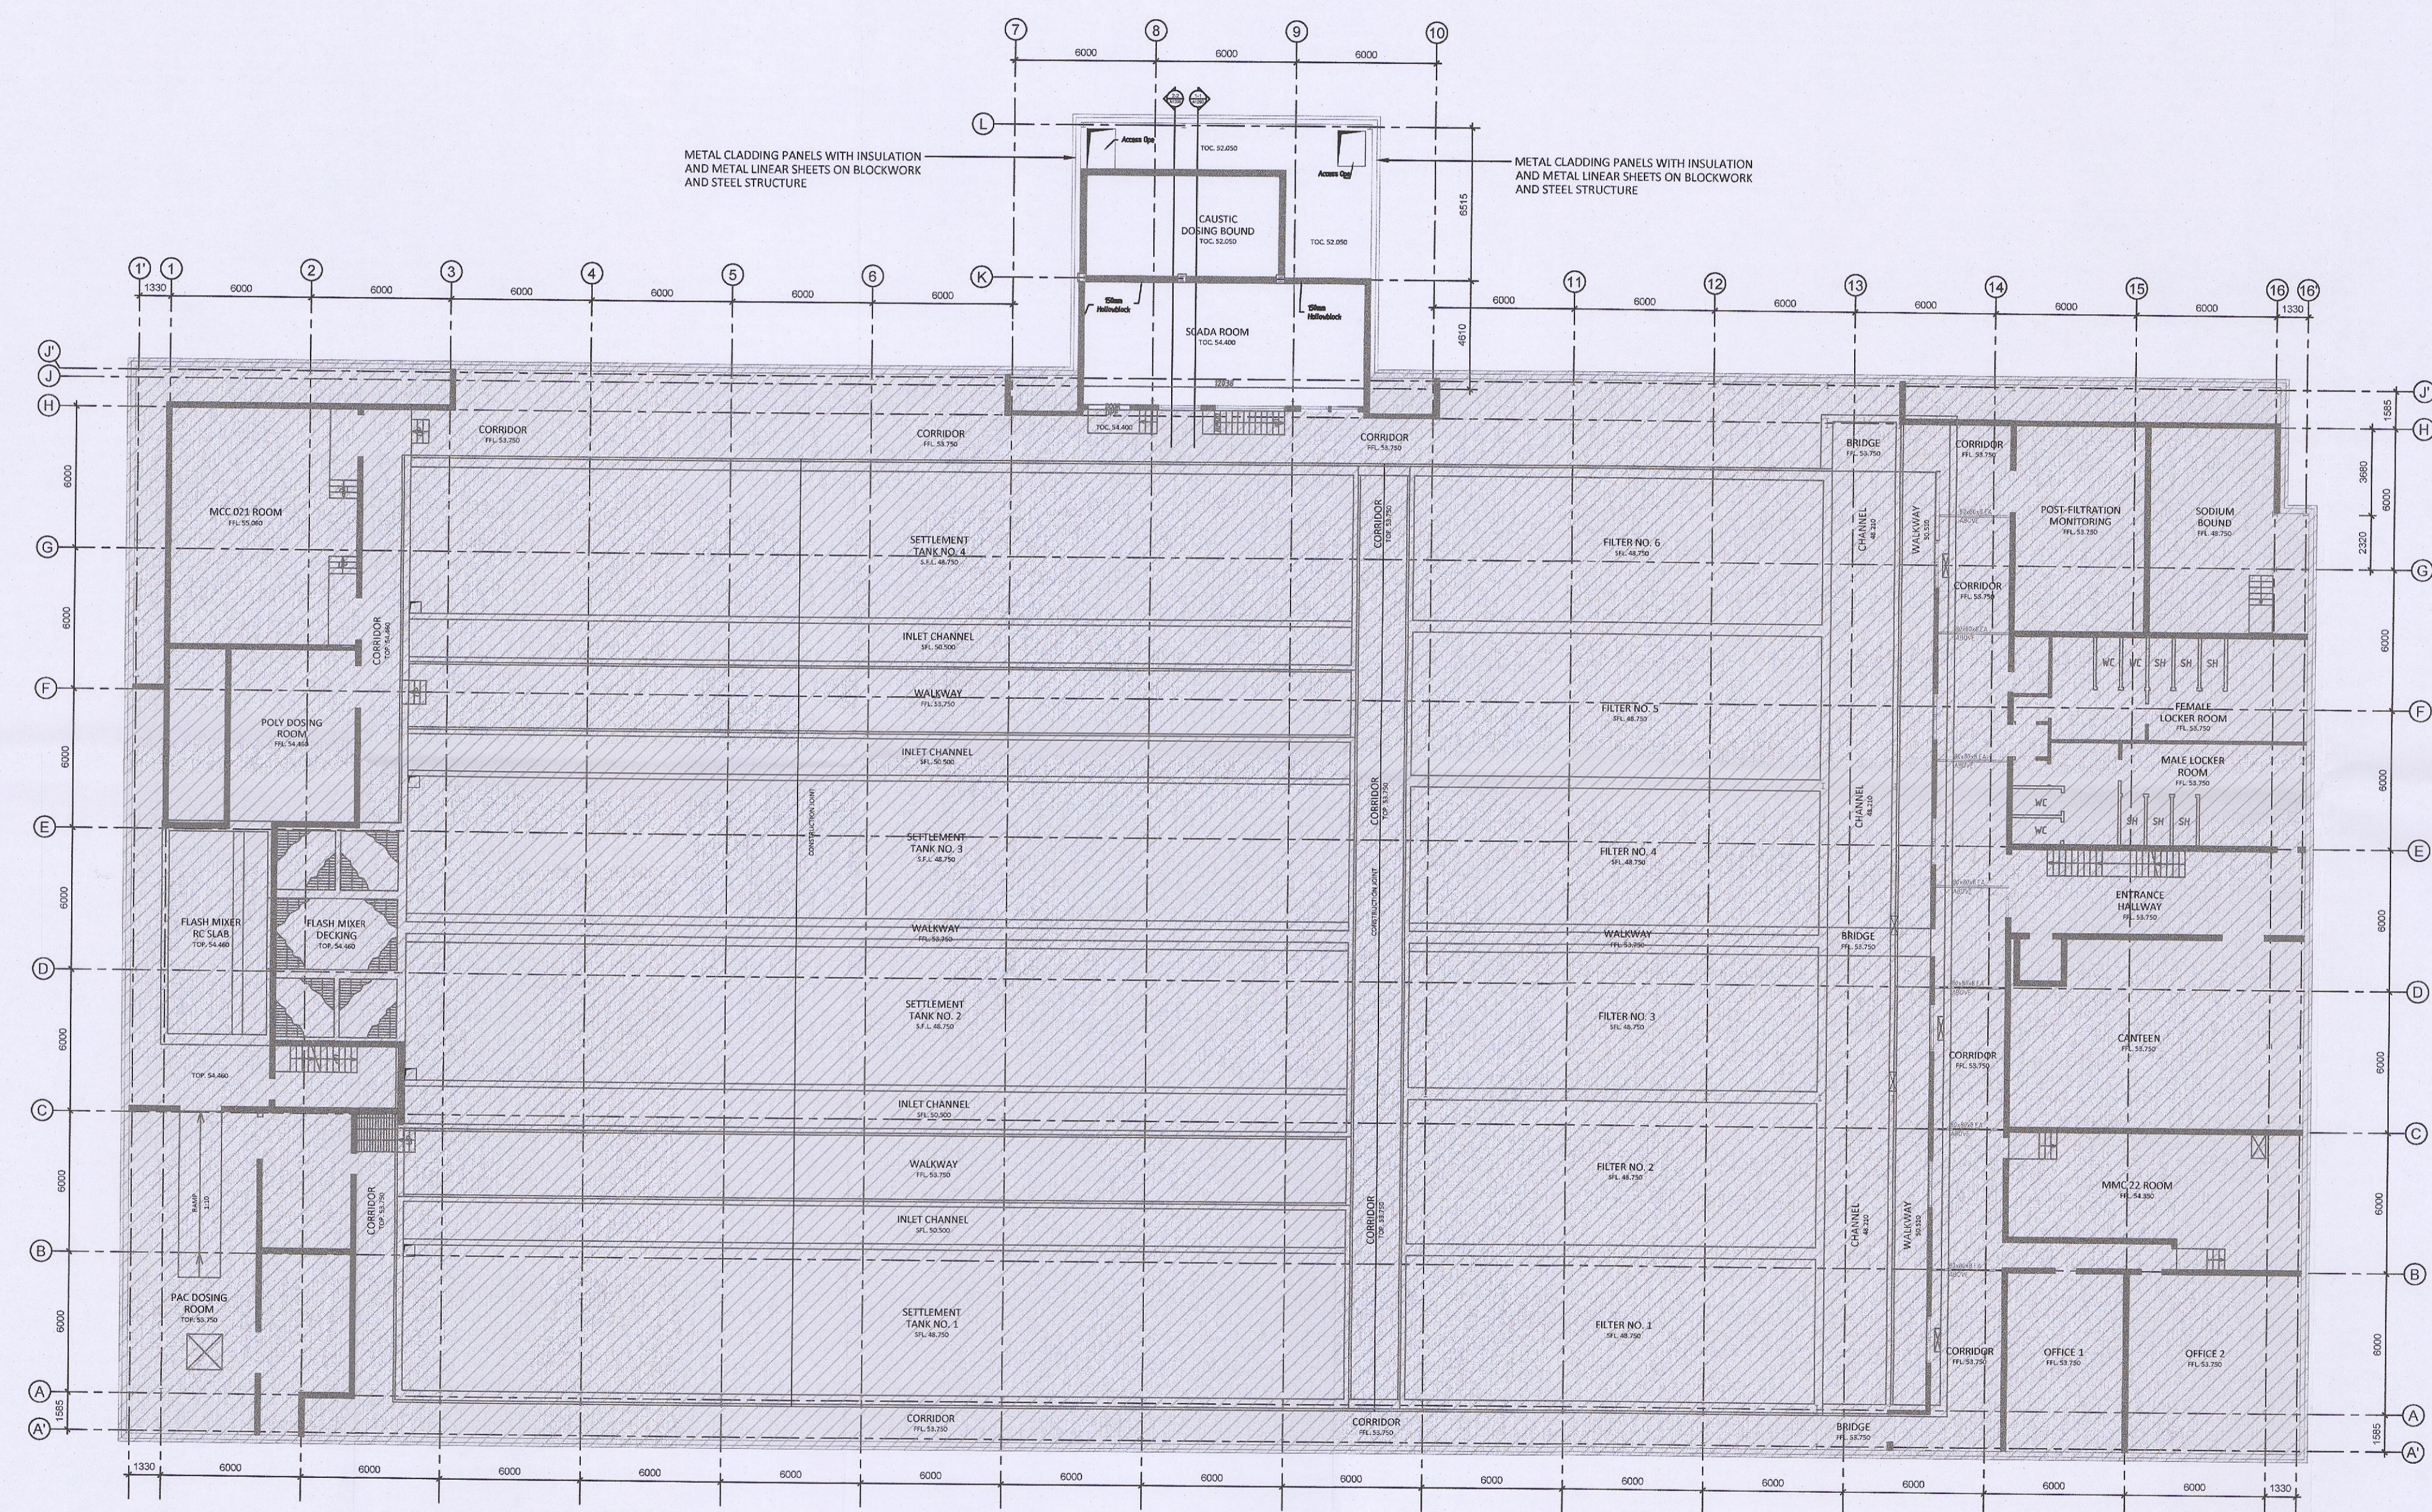

01  
A1101 EXISTING FIRST FLOOR PLAN  
SCALE: 1:200@A1

REV	DATE	CHK BY	DESCRIPTION
P01	07.11.22	MMC	ISSUED FOR PLANNING

STATUS	<b>PLANNING</b>
PROJECT	Irish Water Leixlip Water Treatment Plant
PROJECT ADDRESS	Leixlip, Lucan Demesne Co. Dublin
DWG TITLE	Existing First Floor Plan

DWG NO	A1101	REV	P01
--------	-------	-----	-----

JOB NO	22116	SCALE @ A1	1:200 @ A1
DATE	25.07.22	DRN	MMC

**RKD ARCHITECTS**  
 Project Managers Interior Designers  
 59 Northumberland Road  
 Ballybride  
 Dublin 4  
 Tel +353 1 668 1055  
 Fax +353 1 668 9099  
 W www.rkdarchitects.com  
 E info@rkdarchitects.com