



All dimensions to be checked on site. Figured dimensions take preference over scaled dimensions. Any errors or discrepancies to be reported to the Architects. This drawing may not be edited or modified by the recipient.

"Copyright and ownership of this drawing is vested in RKD Architects, whose prior written consent is required for its use, reproduction or for publication to any third party. All rights reserved by the law of copyright and by international copyright conventions are reserved to RKD Architects and may be protected by court proceedings for damages and/or injunctions and costs."


Notes

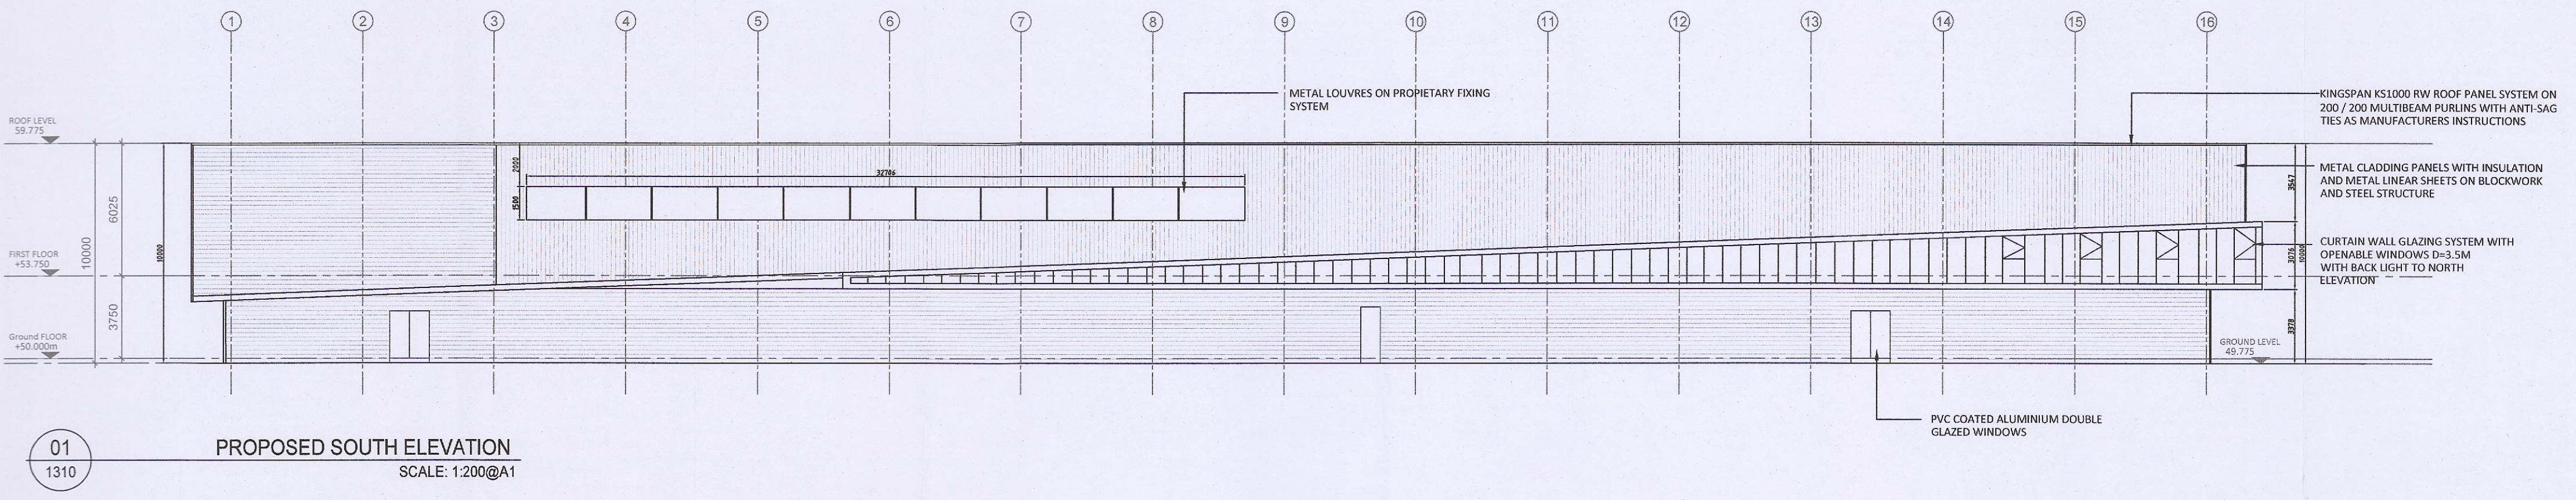


01 PROPOSED SOUTH ELEVATION  
SCALE: 1:200@A1

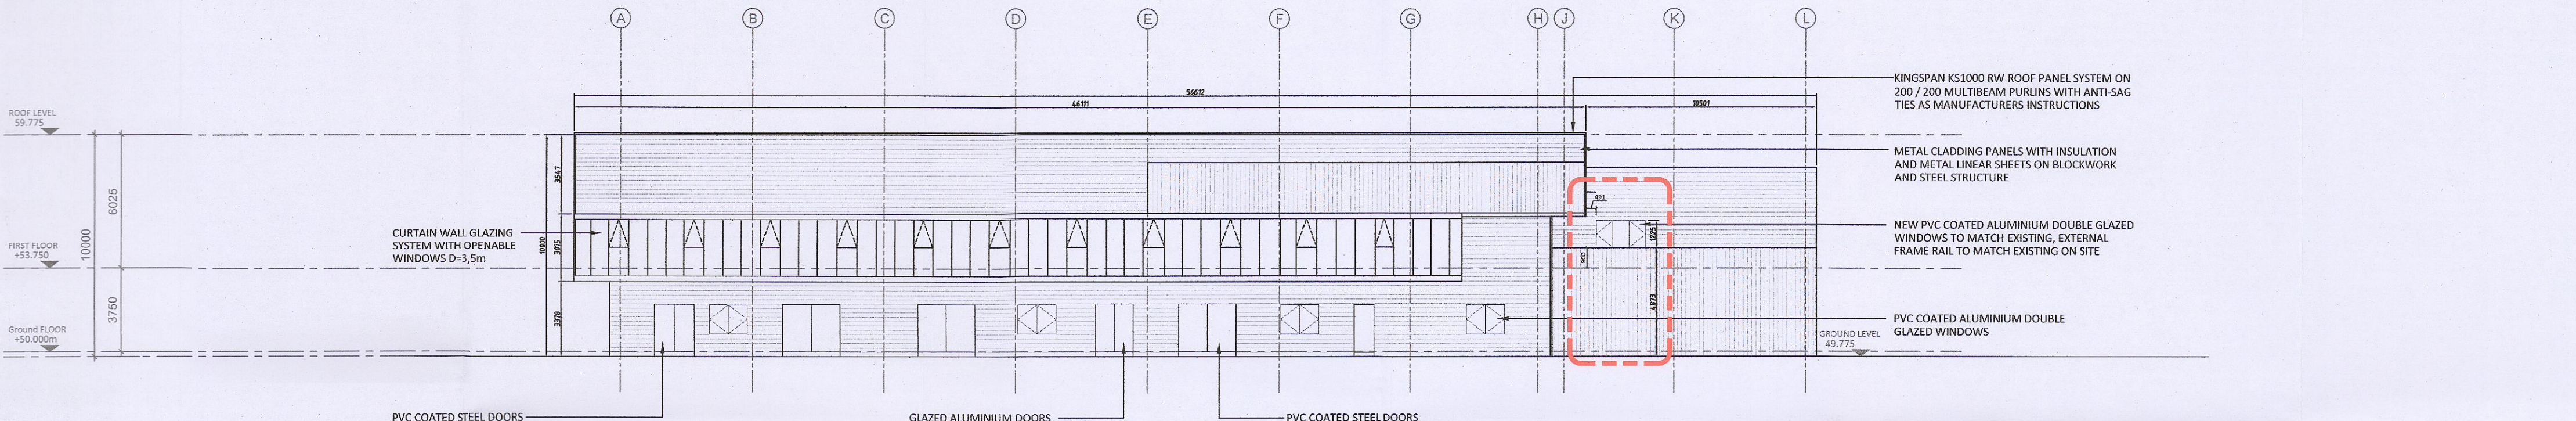

02 PROPOSED EAST ELEVATION  
SCALE: 1:200@A1

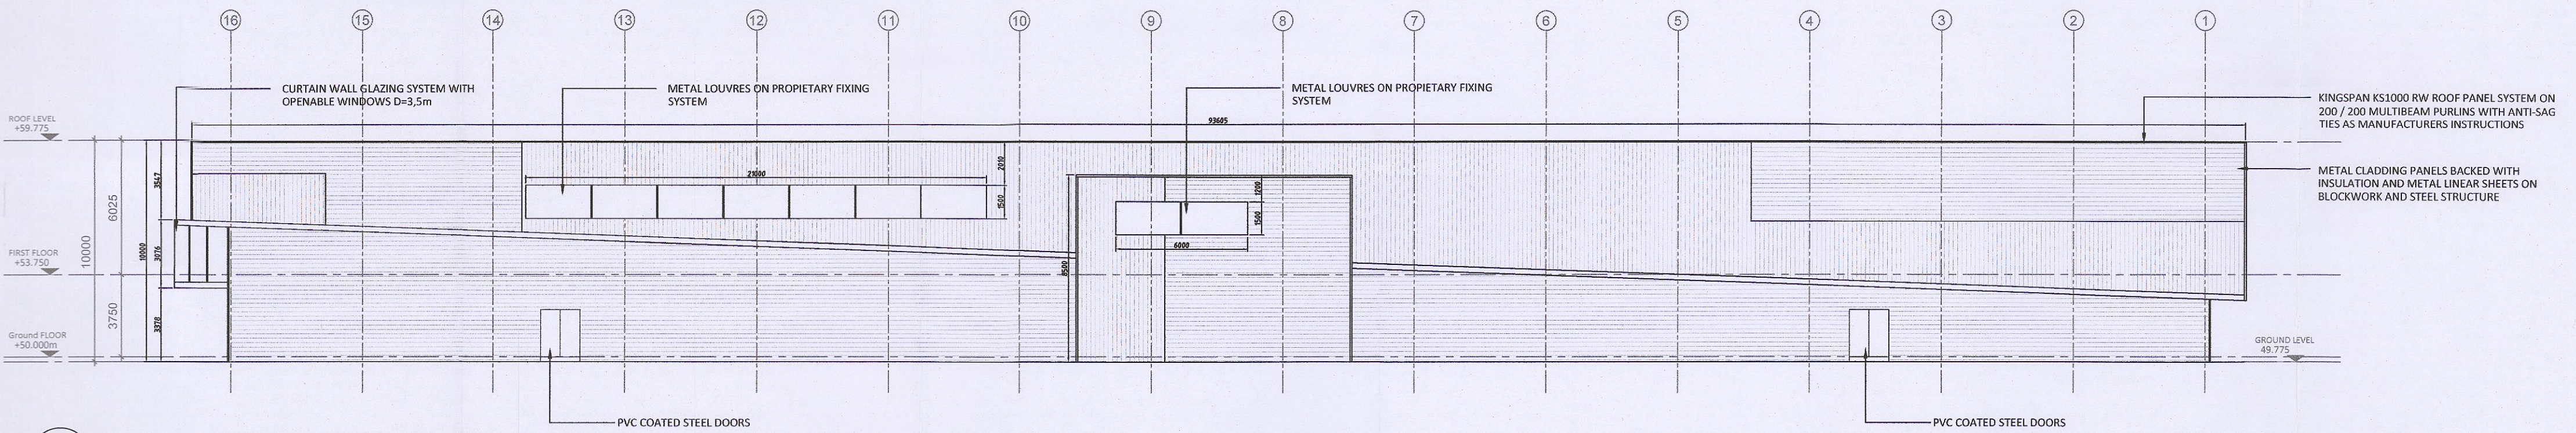

03 PROPOSED NORTH ELEVATION  
SCALE: 1:200@A1

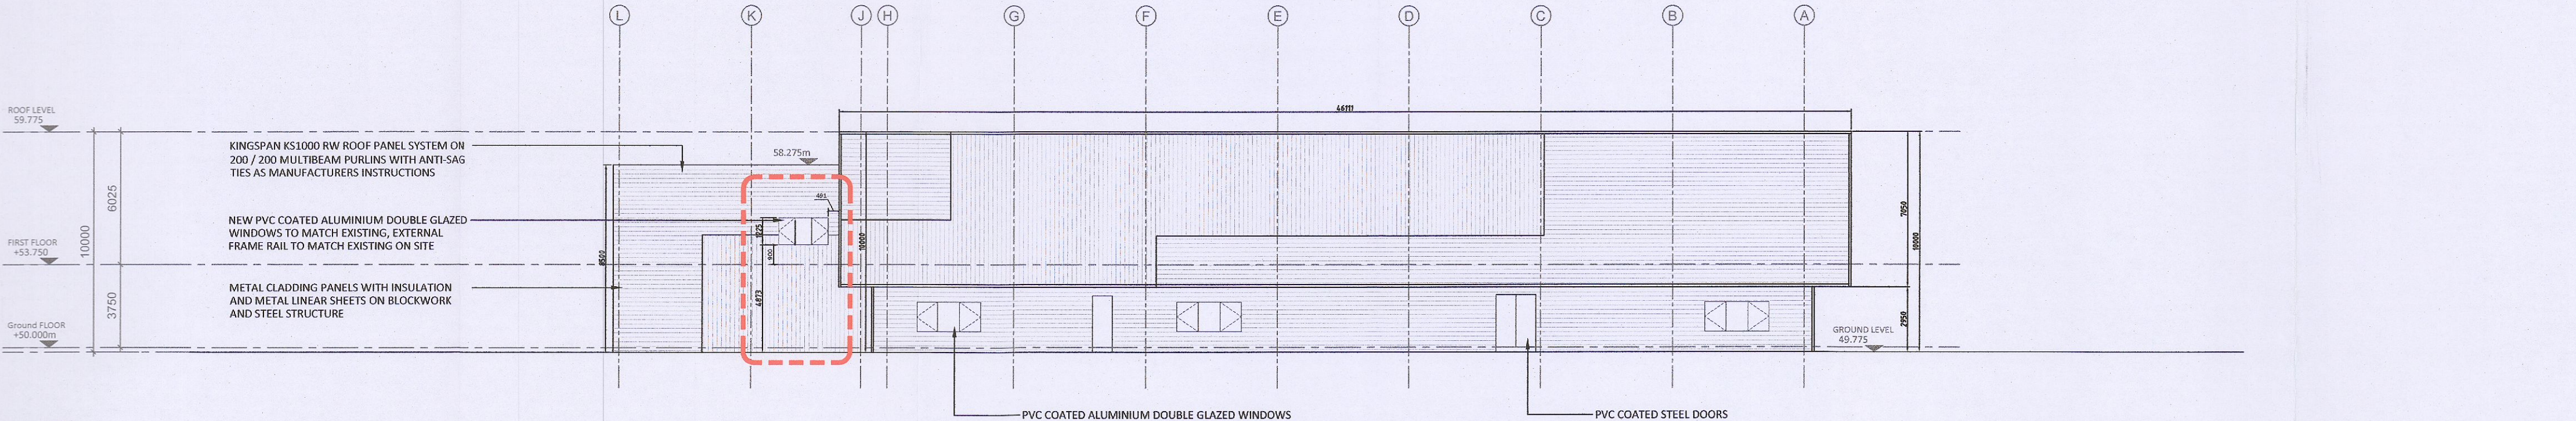

04 PROPOSED WEST ELEVATION  
SCALE: 1:200@A1

REV	DATE	CHK BY	DESCRIPTION
P01	07.11.22	MMC	ISSUED FOR PLANNING

STATUS
PLANNING

PROJECT	Irish Water Leixlip Water Treatment Plant		
PROJECT ADDRESS	Leixlip, Lucan Demesne Co. Dublin		
DWG TITLE	Elevations Proposed		
DWG NO	A1310	REV	P01
JOB NO	22116	SCALE @ A1	1:200 @ A1
DATE	25.07.22	DRN	MMC

RKD Architects  
Project Managers Interior Designers  
59 Northumberland Road  
Rathdangan  
Dublin 4  
Tel: +353 1 668 1055  
Fax: +353 1 668 3699  
W: www.rkdarchitects.com  
E: info@rkdarchitects.com

