


REVISION SCHEDULE

REV. NO.	REV. DESCRIPTION	REV. DATE	DRAWN	CHECKED
P01	ISSUED FOR PLANNING	16/06/2022	CG	JMM
P02	IRISH WATER APPLICATION	21/09/2022	CG	JMM
P03	ISSUED FOR PLANNING	30/11/2022	JOB	JMM
P04	ISSUED FOR PLANNING	07/12/2022	JOB	JMM

DRAINAGE LEGEND

- FS FOUL SEWER (EXISTING)
- FS FOUL SEWER (NEW)
- FS FOUL SEWER (SLUNG FROM GROUND FLOOR SLAB)
- SW SURFACE WATER SEWER (EXISTING)
- SW SURFACE WATER SEWER (NEW)
- SW SURFACE WATER (SLUNG FROM GROUND FLOOR SLAB)
- GWS GREY WATER SEWER (EXISTING)
- GWS GREY WATER SEWER (NEW)
- FSRM FOUL SEWER RISING MAIN
- SWRM SURFACE WATER RISING MAIN
- GRWM GREY WATER RISING MAIN
- EXISTING SEWER TO BE DECOMMISSIONED
- EXISTING WATER MAIN
- PROPOSED WATER MAIN
- PROPOSED FLOOD PIPES
- FSMH (NEW FOUL SEWER MANHOLE)
- SWMH (NEW SURFACE WATER MANHOLE)
- FIRE HYDRANT

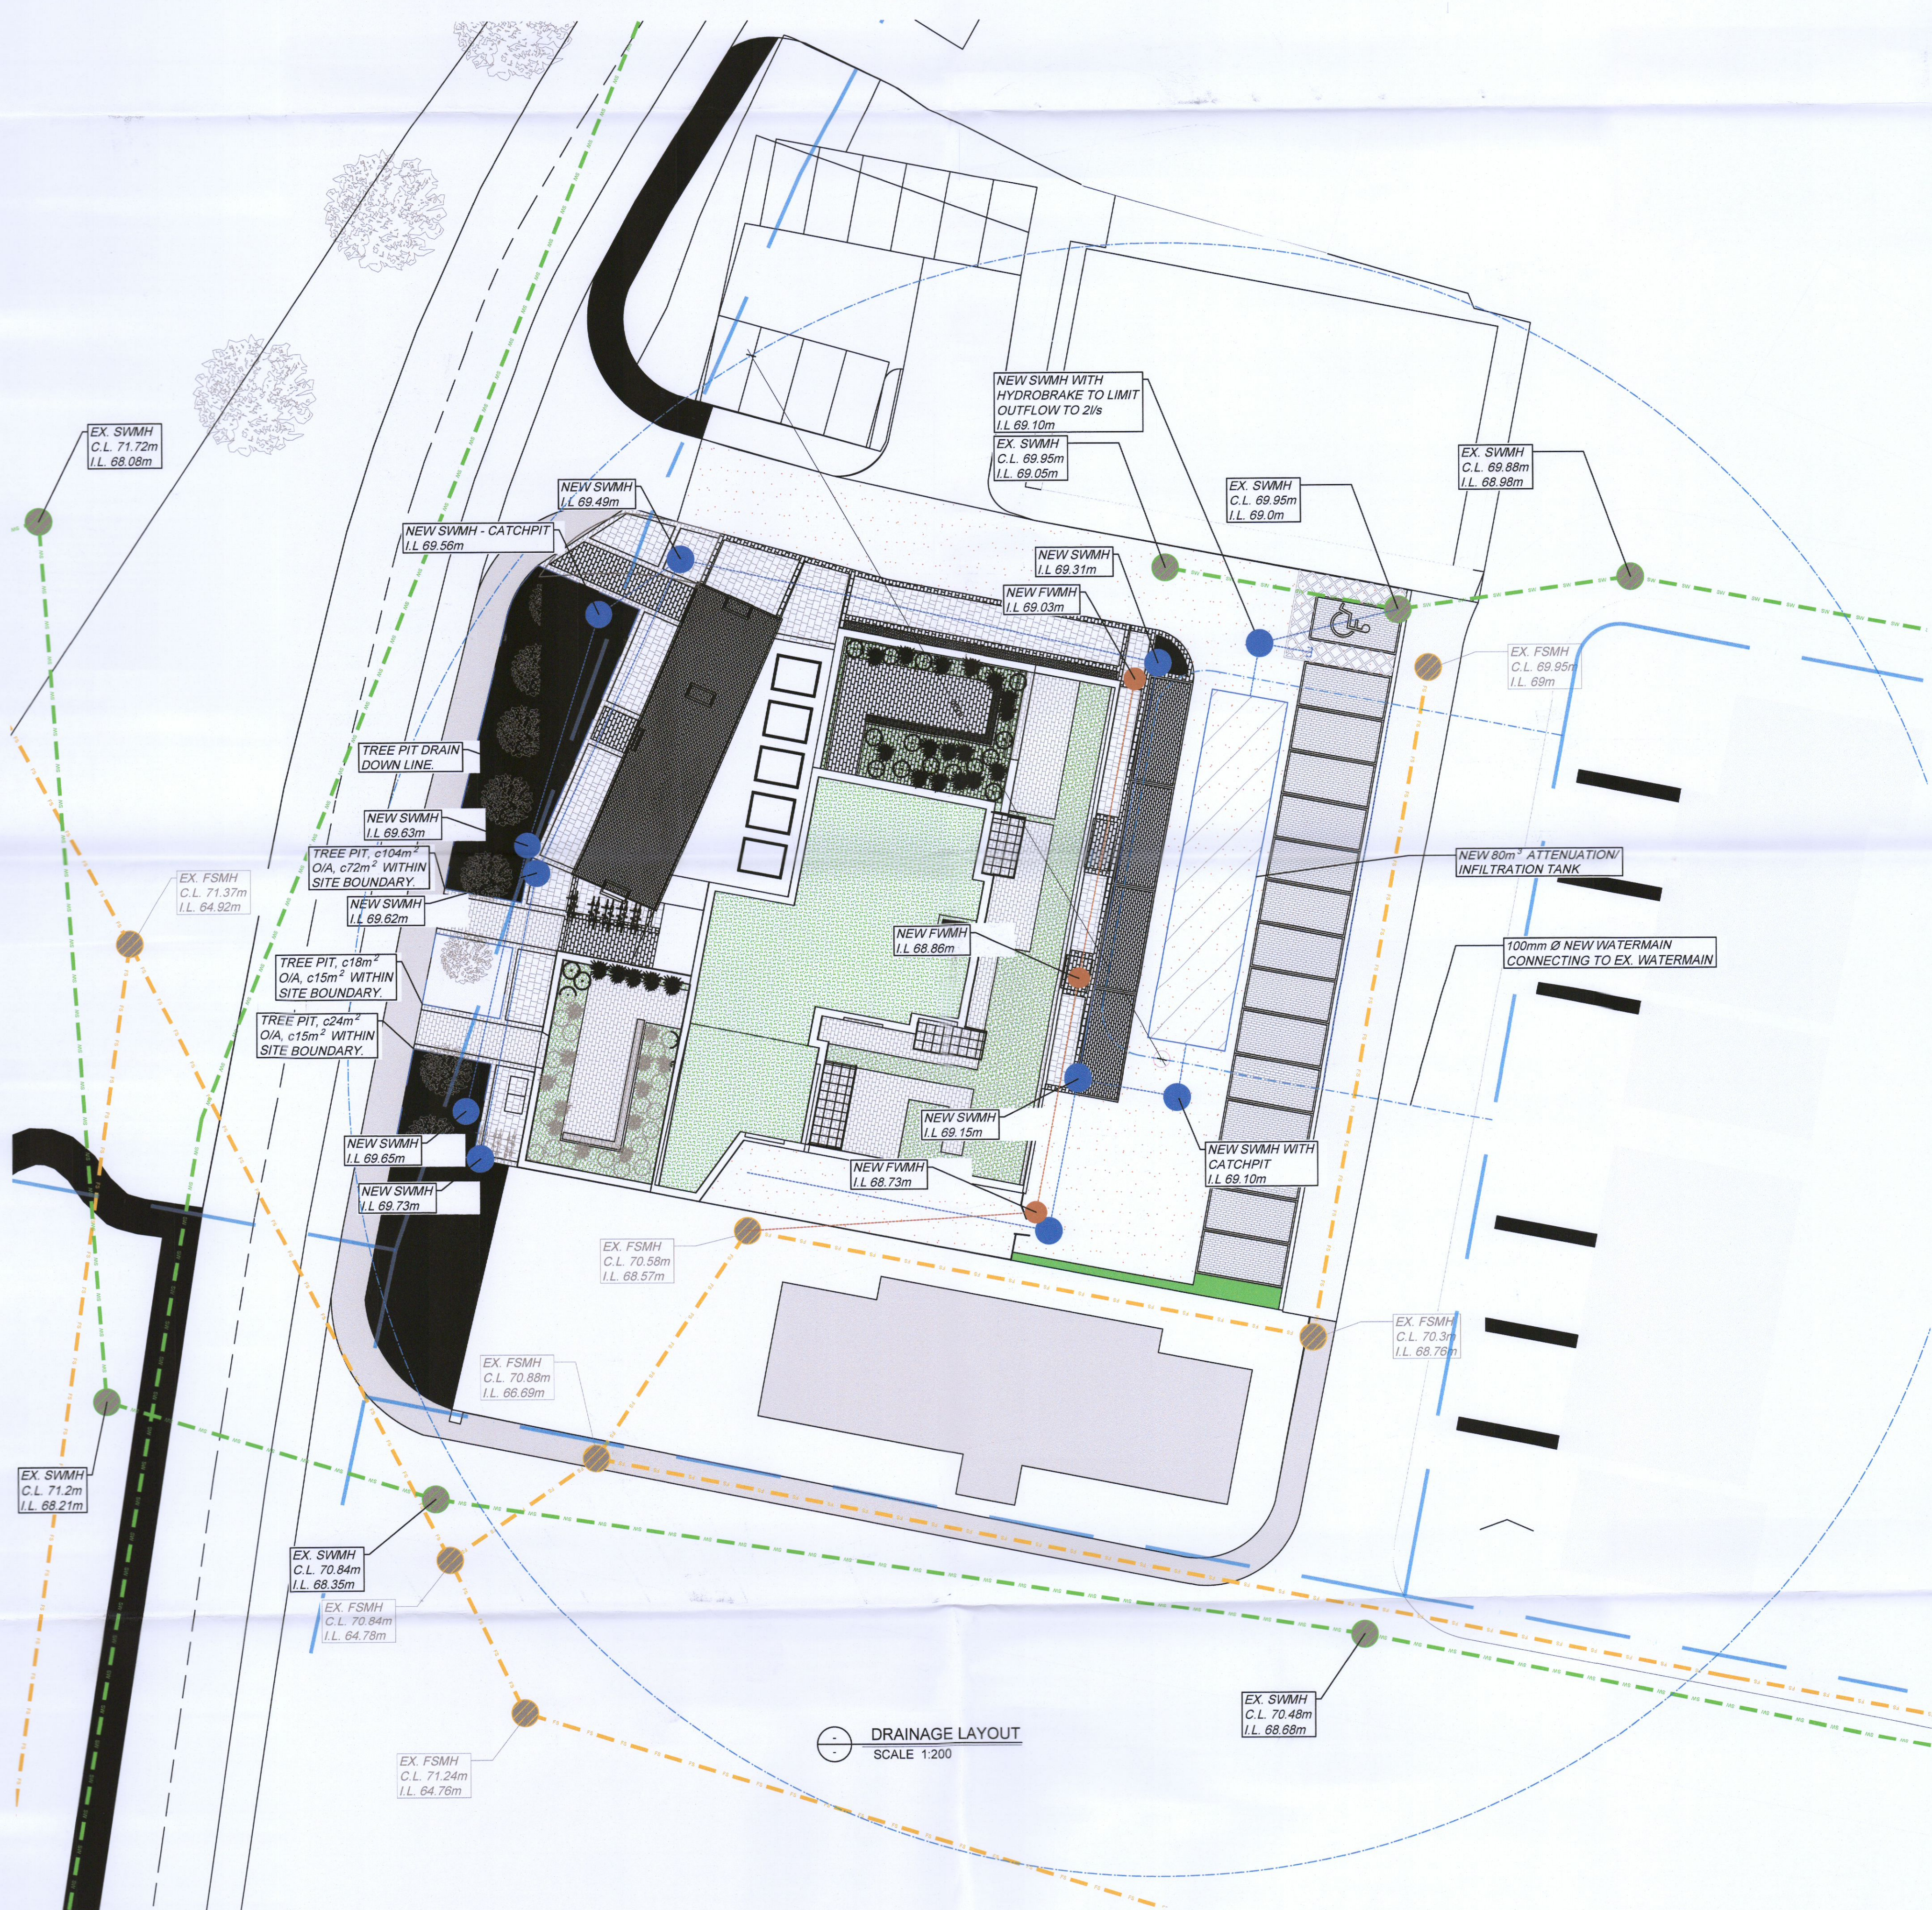

DRAINAGE LAYOUT
SCALE 1:200

Drawing Stage: PLANNING	Project Details:		Drawn by:	Checked by:	Approved by:	Date:	CORA CONSULTING ENGINEERS	Behan House, 10 Lower Mount Street, Dublin 2, D02 HT71 Tel: +353 (0)1 661 1100 e-mail: info@cora.ie Web: www.cora.ie					
	Site Address: CUCKOO'S NEST, GREENHILLS ROAD, KILNAMANAGH, DUBLIN24		CG	JMM	JMM	16/06/2022							
	Client: -		Project Name: CUCKOO'S NEST			Scale: 1:200						Project Number: 21816	
	Architect: DAVEY SMITH ARCHITECTS		Drawing Title: PROPOSED DRAINAGE LAYOUT PLAN			Project: 21816						Originator: CORA	Zone: ZZ
M&E Designer: -		Contractor: -											