


Proposed Block Plan & Drainage Layout
SCALE 1:200

DRAINAGE LEGEND

- PROPOSED 1500 Ø UPVC SURFACE WATER PIPE
- PROPOSED 1500 Ø UPVC FOUL SEWER PIPE
- EXISTING SURFACE WATER PIPE
- EXISTING FOUL SEWER PIPE

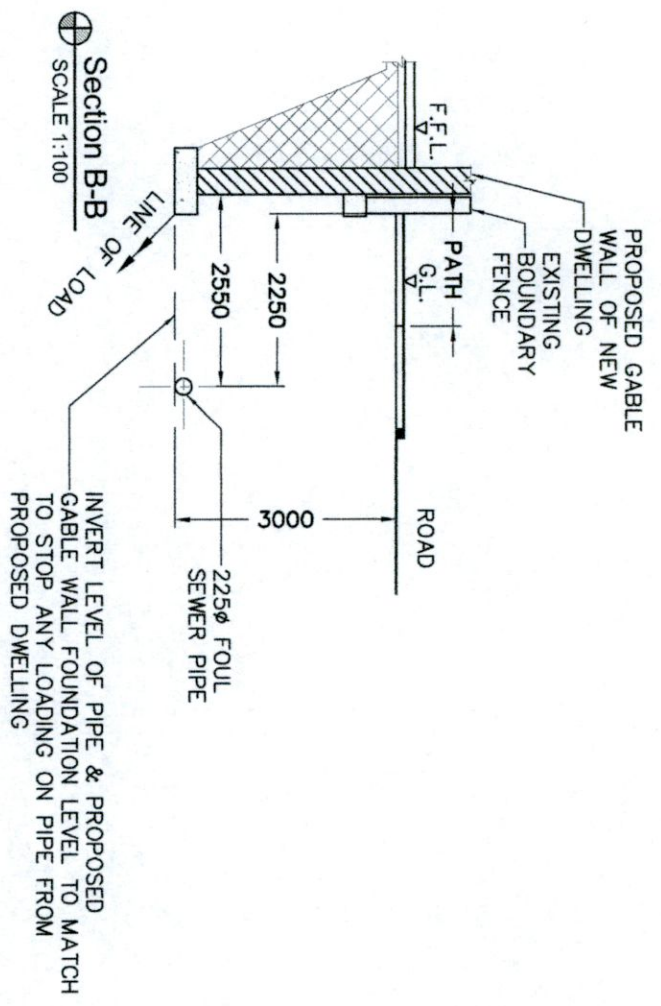

P	ISSUED FOR PLANNING	ND	DEC' 2022
REV:	REVISION TITLE:	DRN:	CHO:
		DATE:	

AA Architecture

4 CARRIGMORE CLOSE, AYLESBURY,
Dublin 24 - Ph: 01 4148358

Issued for Planning

CLIENT: **PAUL & REBECCA CONNOR**
JOB TITLE: **PROPOSED WORKS AT 114A TEMPLEOGUE WOOD, TEMPLEOGUE, DUBLIN 6W**

TITLE: **PROPOSED BLOCK PLAN, DRAINAGE LAYOUT & SECTION**

SCALE: 1:200	INITIALS: ND	DATE: NOV' 2022
JOB No: S284	DRAWING No: 003	

THIS DRAWING IS ISSUED FOR PLANNING PERMISSION ONLY, AND IS NOT A CONSTRUCTION DRAWING

NOTES:

This drawing is to be read in conjunction with all relevant Engineers drawings.
Do not scale use figured dimensions ONLY.
All dimensions in millimeters unless otherwise stated.
All dimensions to be checked on site.
All building works to comply with current building regulations & in accordance with Homebond Standards.