


PREVAILING WIND (SW)

103.128
INDICATES LOCAL LEVEL IN ACCORDANCE WITH ORDINANCE DATUM

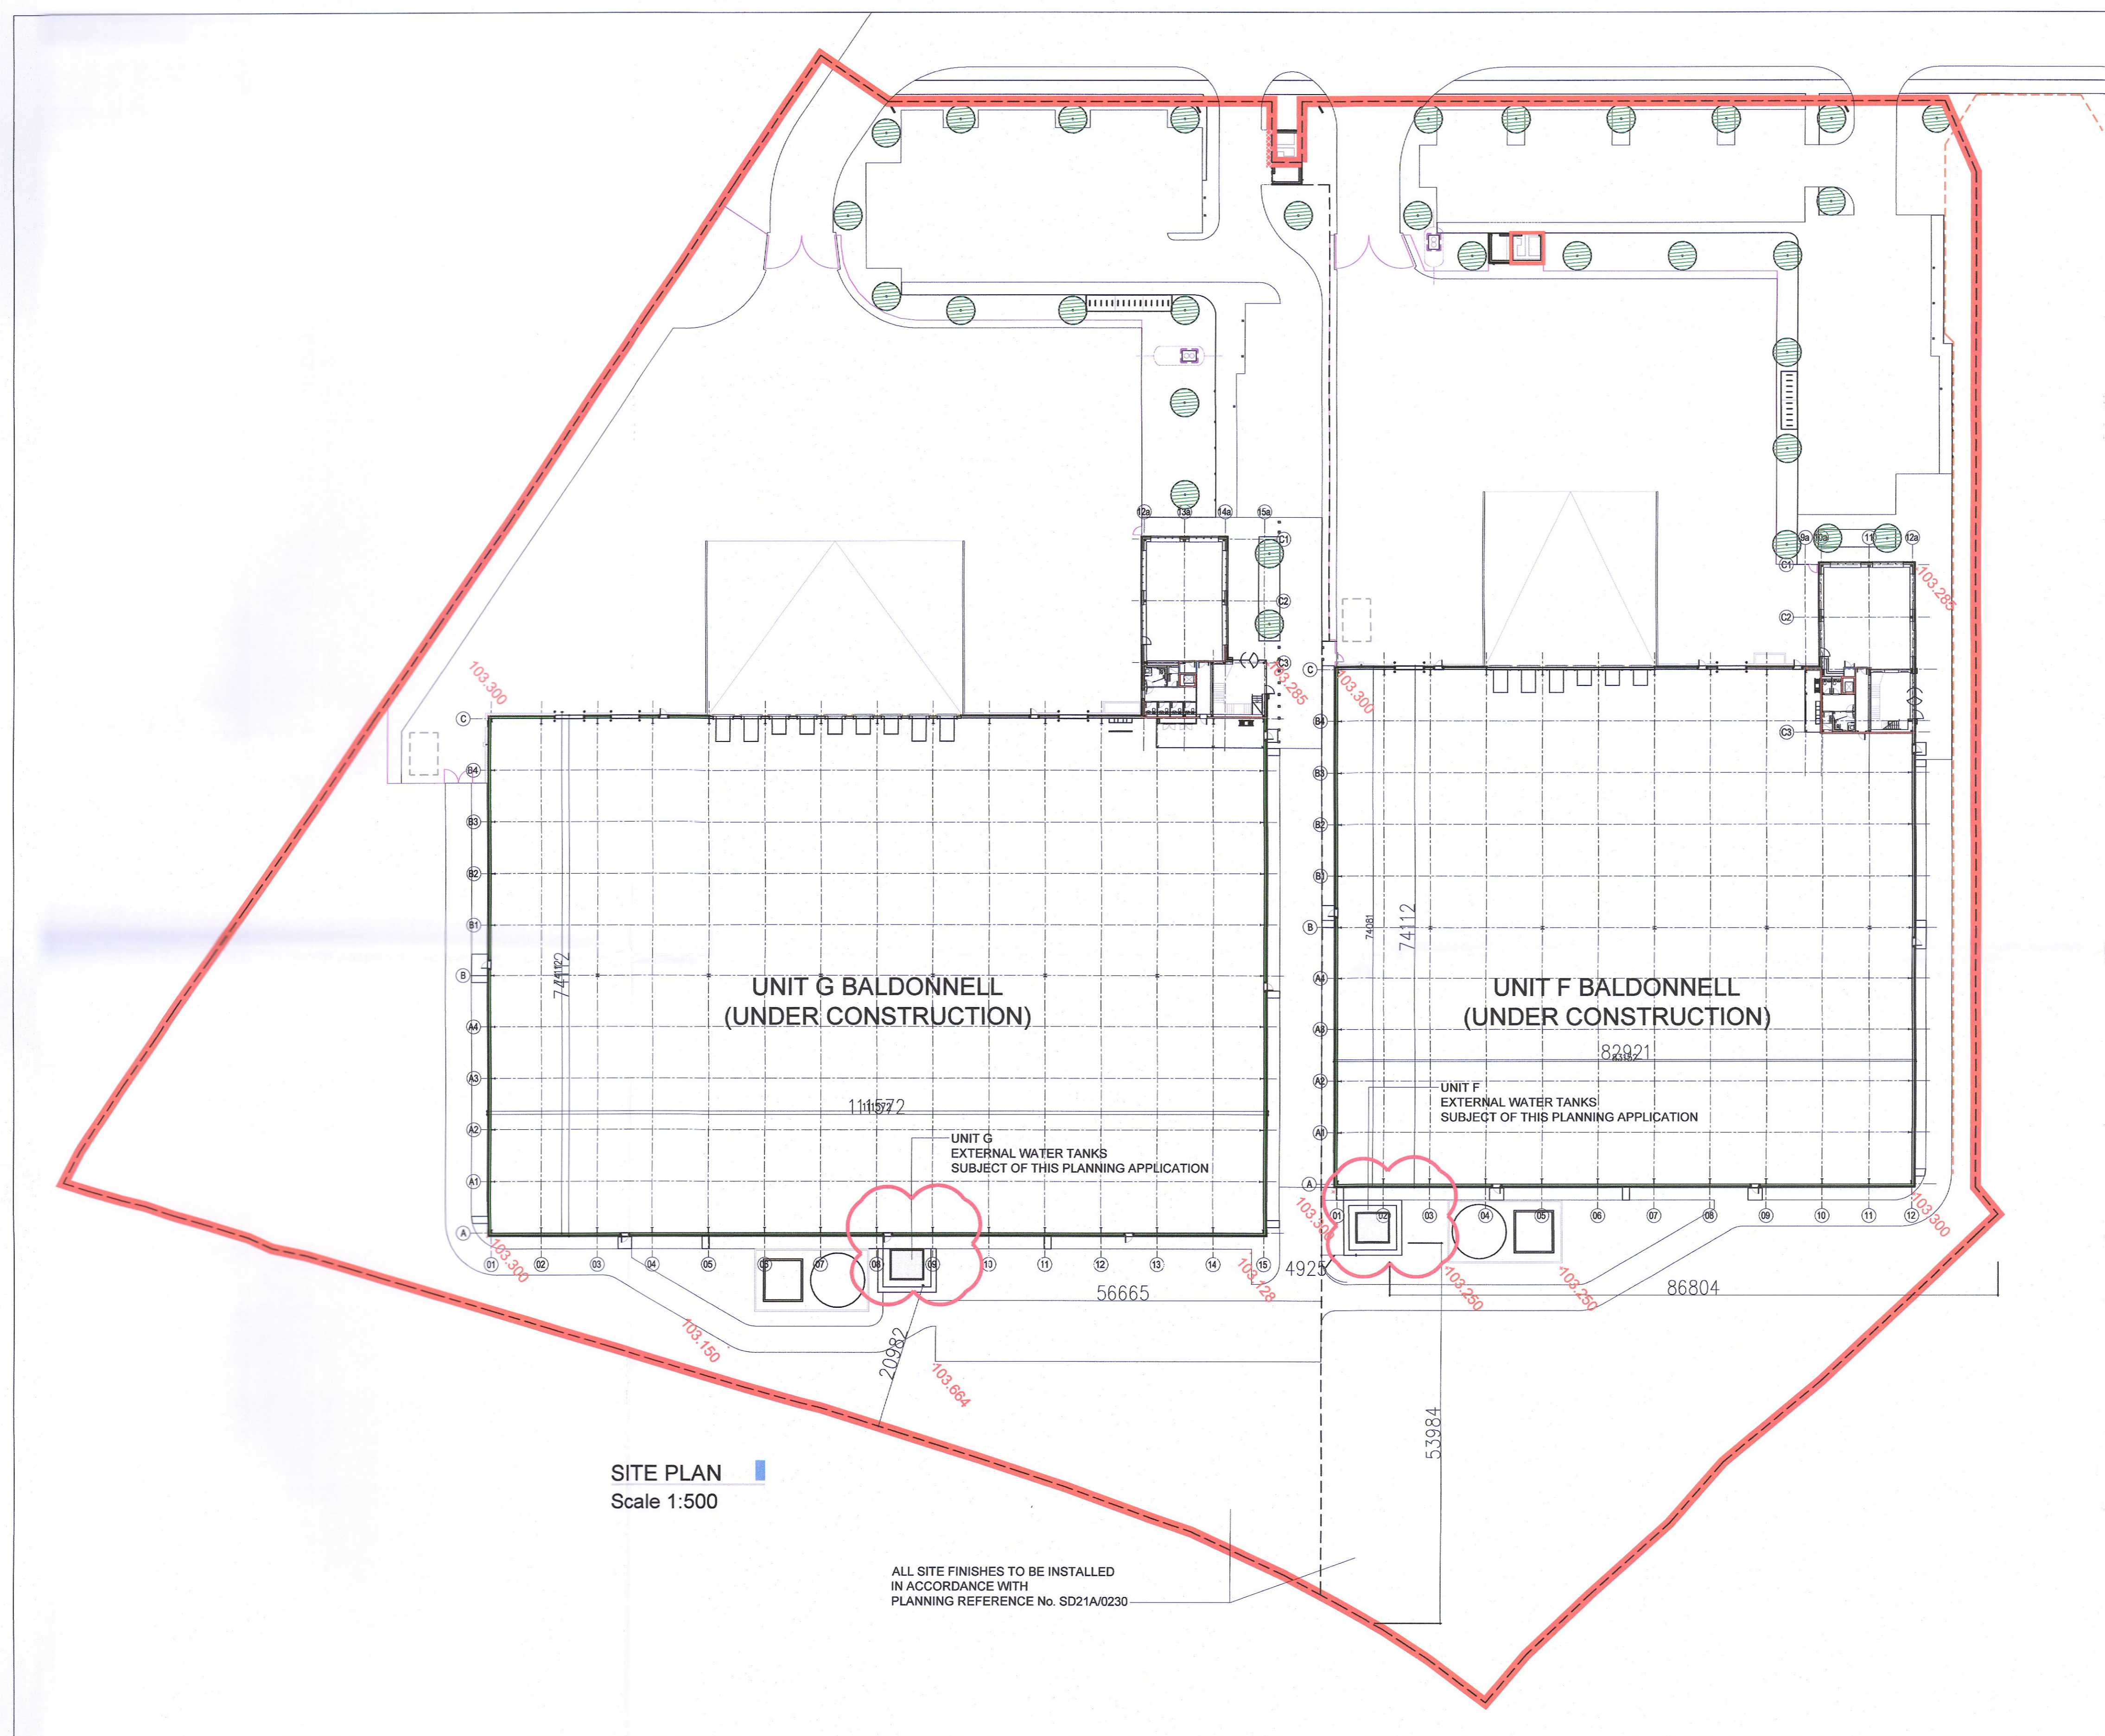

SITE PLAN
Scale 1:500

PLANNING ISSUE

J S A Architects
CHARTERED ARCHITECTS 10 Booterstown Avenue,
BLACKROCK, CO. DUBLIN. TEL: (01) 2882661 FAX: (01) 2835143
E-MAIL: jsa@jsarch.ie WEB: www.jsarch.ie



Client:	MLEU Dublin 3 Ltd								
Project:	MOUNTPARK, BALDONNELL BUSINESS PARK. UNIT F & G EXTERNAL WATER TANKS								
Description:	SITE LAYOUT PLAN								
Date:	22.11.2022	Sheet:	A1	Scale:	1/500	By:	JSJ	Rev:	A
Job No:	1621	Stage:	PLANNING	Org. No:	RET004-JSA-ZZ-XX-DR-A-0010				

Notes:
This Drawing is Copyright.
Do Not Scale - Use Figured Dimensions Only.
Refer to Structural Engineers Drawings and Specifications for all Structural Work.
Drawings to be read in conjunction with all other Consultants Drawings and Specifications.

Revision	Initials	Date	Description
REV A:	JSJ	22.11.2022	ISSUED FOR PLANNING APPLICATION (WATER TANKS)
REV B:			
REV C:			
REV D:			
REV E:			
REV F:			
REV G:			
REV H:			
REV I:			
REV J:			

Revision	Initials	Date	Description
REV K:			
REV L:			
REV M:			
REV N:			
REV O:			
REV P:			
REV Q:			
REV R:			
REV S:			
REV T:			

Revision	Initials	Date	Description
REV U:			
REV V:			
REV W:			
REV X:			
REV Y:			
REV Z:			
REV AA:			
REV BB:			
REV CC:			
REV DD:			