
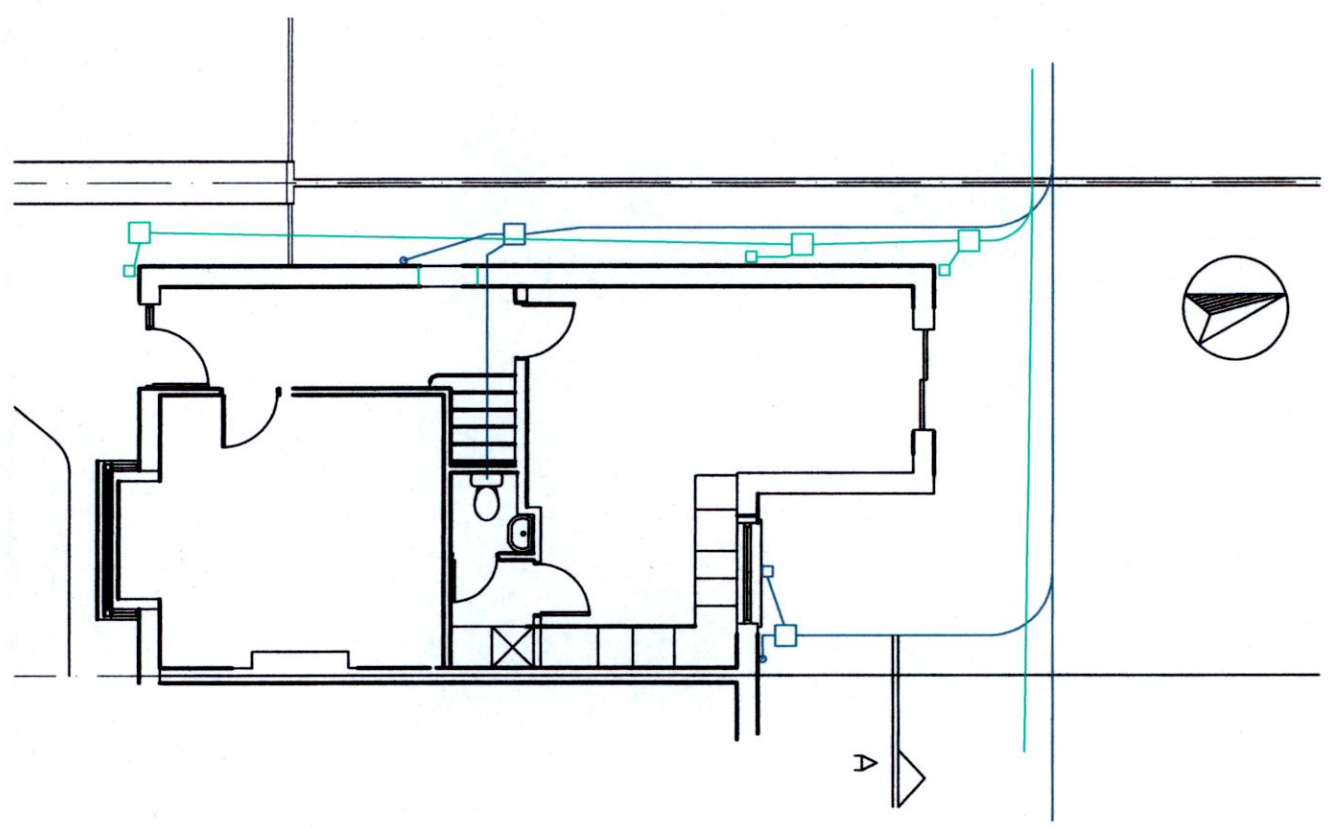


RevNo	Revision note	Date	Signature	Checked
-------	---------------	------	-----------	---------

NOTE: Drawings for planning permission only  
 NOTE: Do not scale off drawings, check all drawing dimensions on site

NOTE:  
 Locate existing foul and surface water sewers and encase in concrete where they pass under new extension. Bridge above where they pass through rising foundation walls.  
 Provide new manhole above main sewer in side passage area and redirect all foul waste to it.

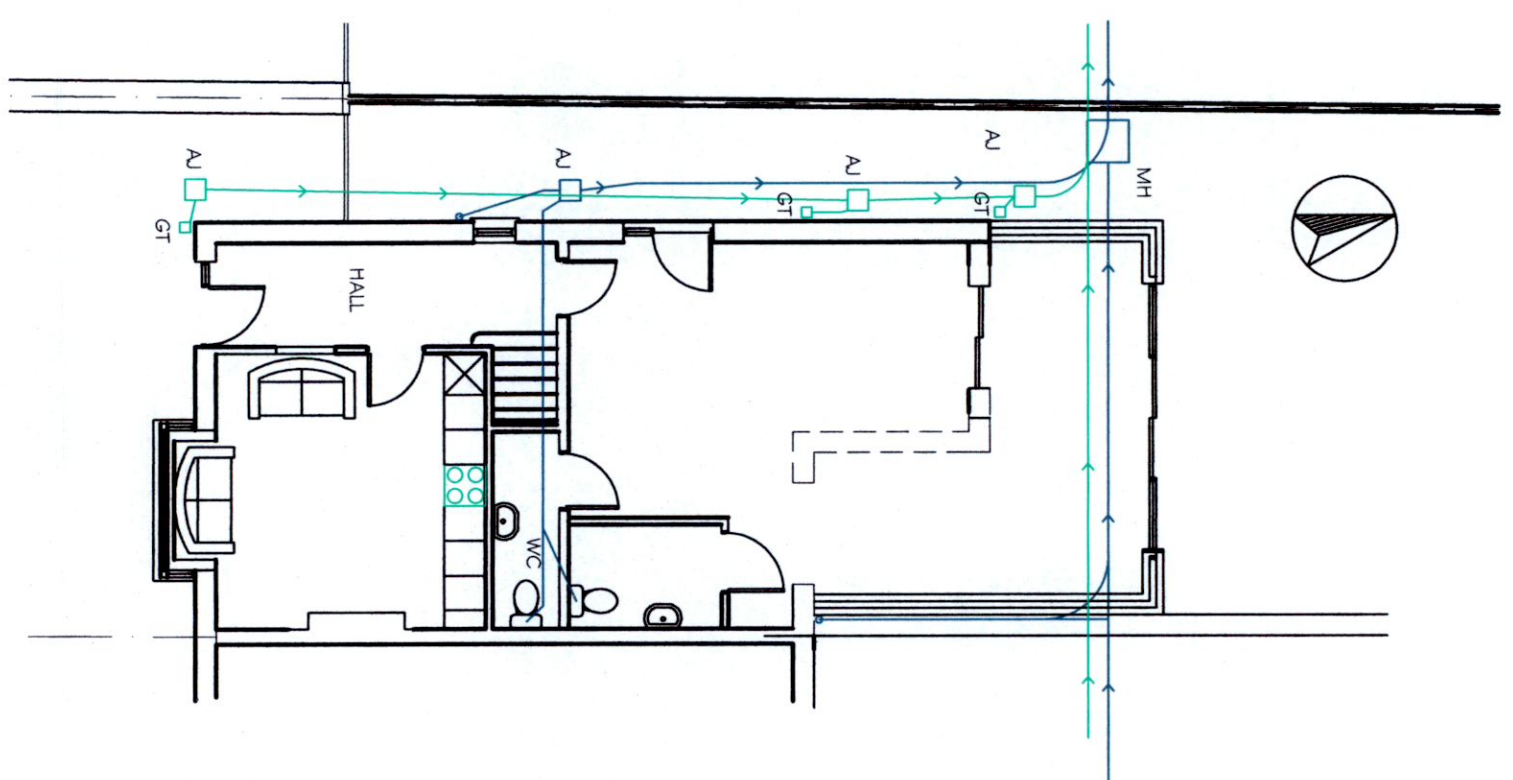

EXISTING DRAINAGE PLAN

PROPOSED DRAINAGE PLAN

Itemref	Quantity	Title/Name, designation, material, dimension etc	Article No./Reference
Designed by J ROCHFORD	Checked by JR	Approved by - date 25/11/22	Scale 1:100
JOHN ROCHFORD JARRETSTOWN CROSS DUNBOYNE CO MEATH TEL: 01 8015149		File name Mndul Sharma	Date 25/11/22
MRIDUL SHARMA 4 GRIFFEEEN GLEN DRIVE LUCAN CO DUBLIN		Edition 0	Sheet 10