


Proposed Block Plan & Drainage Layout  
SCALE 1:200

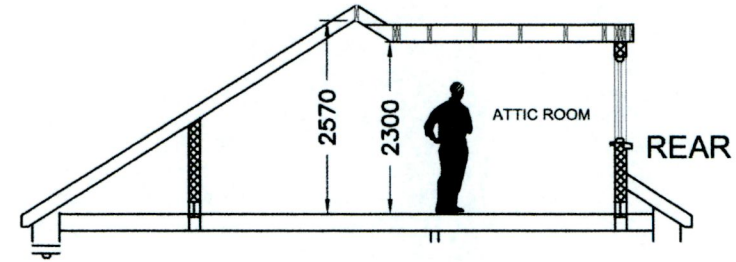

Section A-A  
SCALE 1:100

DRAINAGE LEGEND

---	EXISTING SURFACE WATER PIPE
---	EXISTING FOUL SEWER PIPE

P	ISSUED FOR PLANNING	ND	dec' 2022
REV:	REVISION TITLE:	DRN:	CHD: DATE:

THIS DRAWING IS ISSUED FOR PLANNING PERMISSION ONLY, AND IS NOT A CONSTRUCTION DRAWING

**AA ARCHITECTURE**

4 CARRIGMORE CLOSE, AYLESBURY,  
Dublin 24 - Ph: 01 4148358

CLIENT: **CONOR & JENNIFER STEVENS**  
JOB TITLE: Proposed Works at 5 Kiltipper Rise, Kiltipper Gate, Tallaght, Dublin 24

TITLE: Proposed Block Plan, Drainage Layout & Section A-A

SCALE: as shown INITIALS: ND DATE: Dec' 2022

JOB No: S518 DRAWING No: 004 REV: P

NOTES:

This drawing is to be read in conjunction with all relevant Engineers drawings.  
Do not scale use figured dimensions ONLY.  
All dimensions in millimeters unless otherwise stated.  
All dimensions to be checked on site.  
All building works to comply with current building regulations & in accordance with Homebond Standards.