


Rafter insulation Kingspan K7 100mm between rafters with Kingspan K18 37.5mm plasterboard backed.

Dormer wall insulation Kingspan K8 80mm wall between timbers & K18 37.5mm plasterboard backed.

Dormer roof insulation Kingspan K7 100mm in joists & K18 37.5mm plasterboard backed.

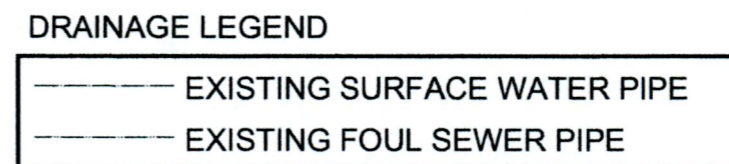

Proposed Block Plan & Drainage Layout
SCALE 1:200

P	ISSUED FOR PLANNING	TW	DEC'2022
REV:	REVISION TITLE:	DRN:	CHD: DATE:

THIS DRAWING IS ISSUED FOR PLANNING PERMISSION ONLY, AND IS NOT A CONSTRUCTION DRAWING

Architectural Planning

4 CARRIGMORE CLOSE, AYLESBURY,
Dublin 24 - Ph: 01 4148358

CLIENT:
JAMES PRENDERGAST

JOB TITLE:
PROPOSED WORKS AT 17 WOODSTOWN PLACE, KNOCKLYON, DUBLIN 16

TITLE:
PROPOSED BLOCK PLAN,
DRAINAGE LAYOUT &
SECTION A-A

NOTES:
This drawing is to be read in conjunction with all relevant Engineers drawings.
Do not scale use figured dimensions ONLY.
All dimensions in millimeters unless otherwise stated.
All dimensions to be checked on site.
All building works to comply with current building regulations & in accordance with Homebond Standards.

SCALE: As shown	INITIALS: TW	DATE: DEC' 2022
JOB No: S573	DRAWING No: 004	REV: P