




CALMOUNT ROAD

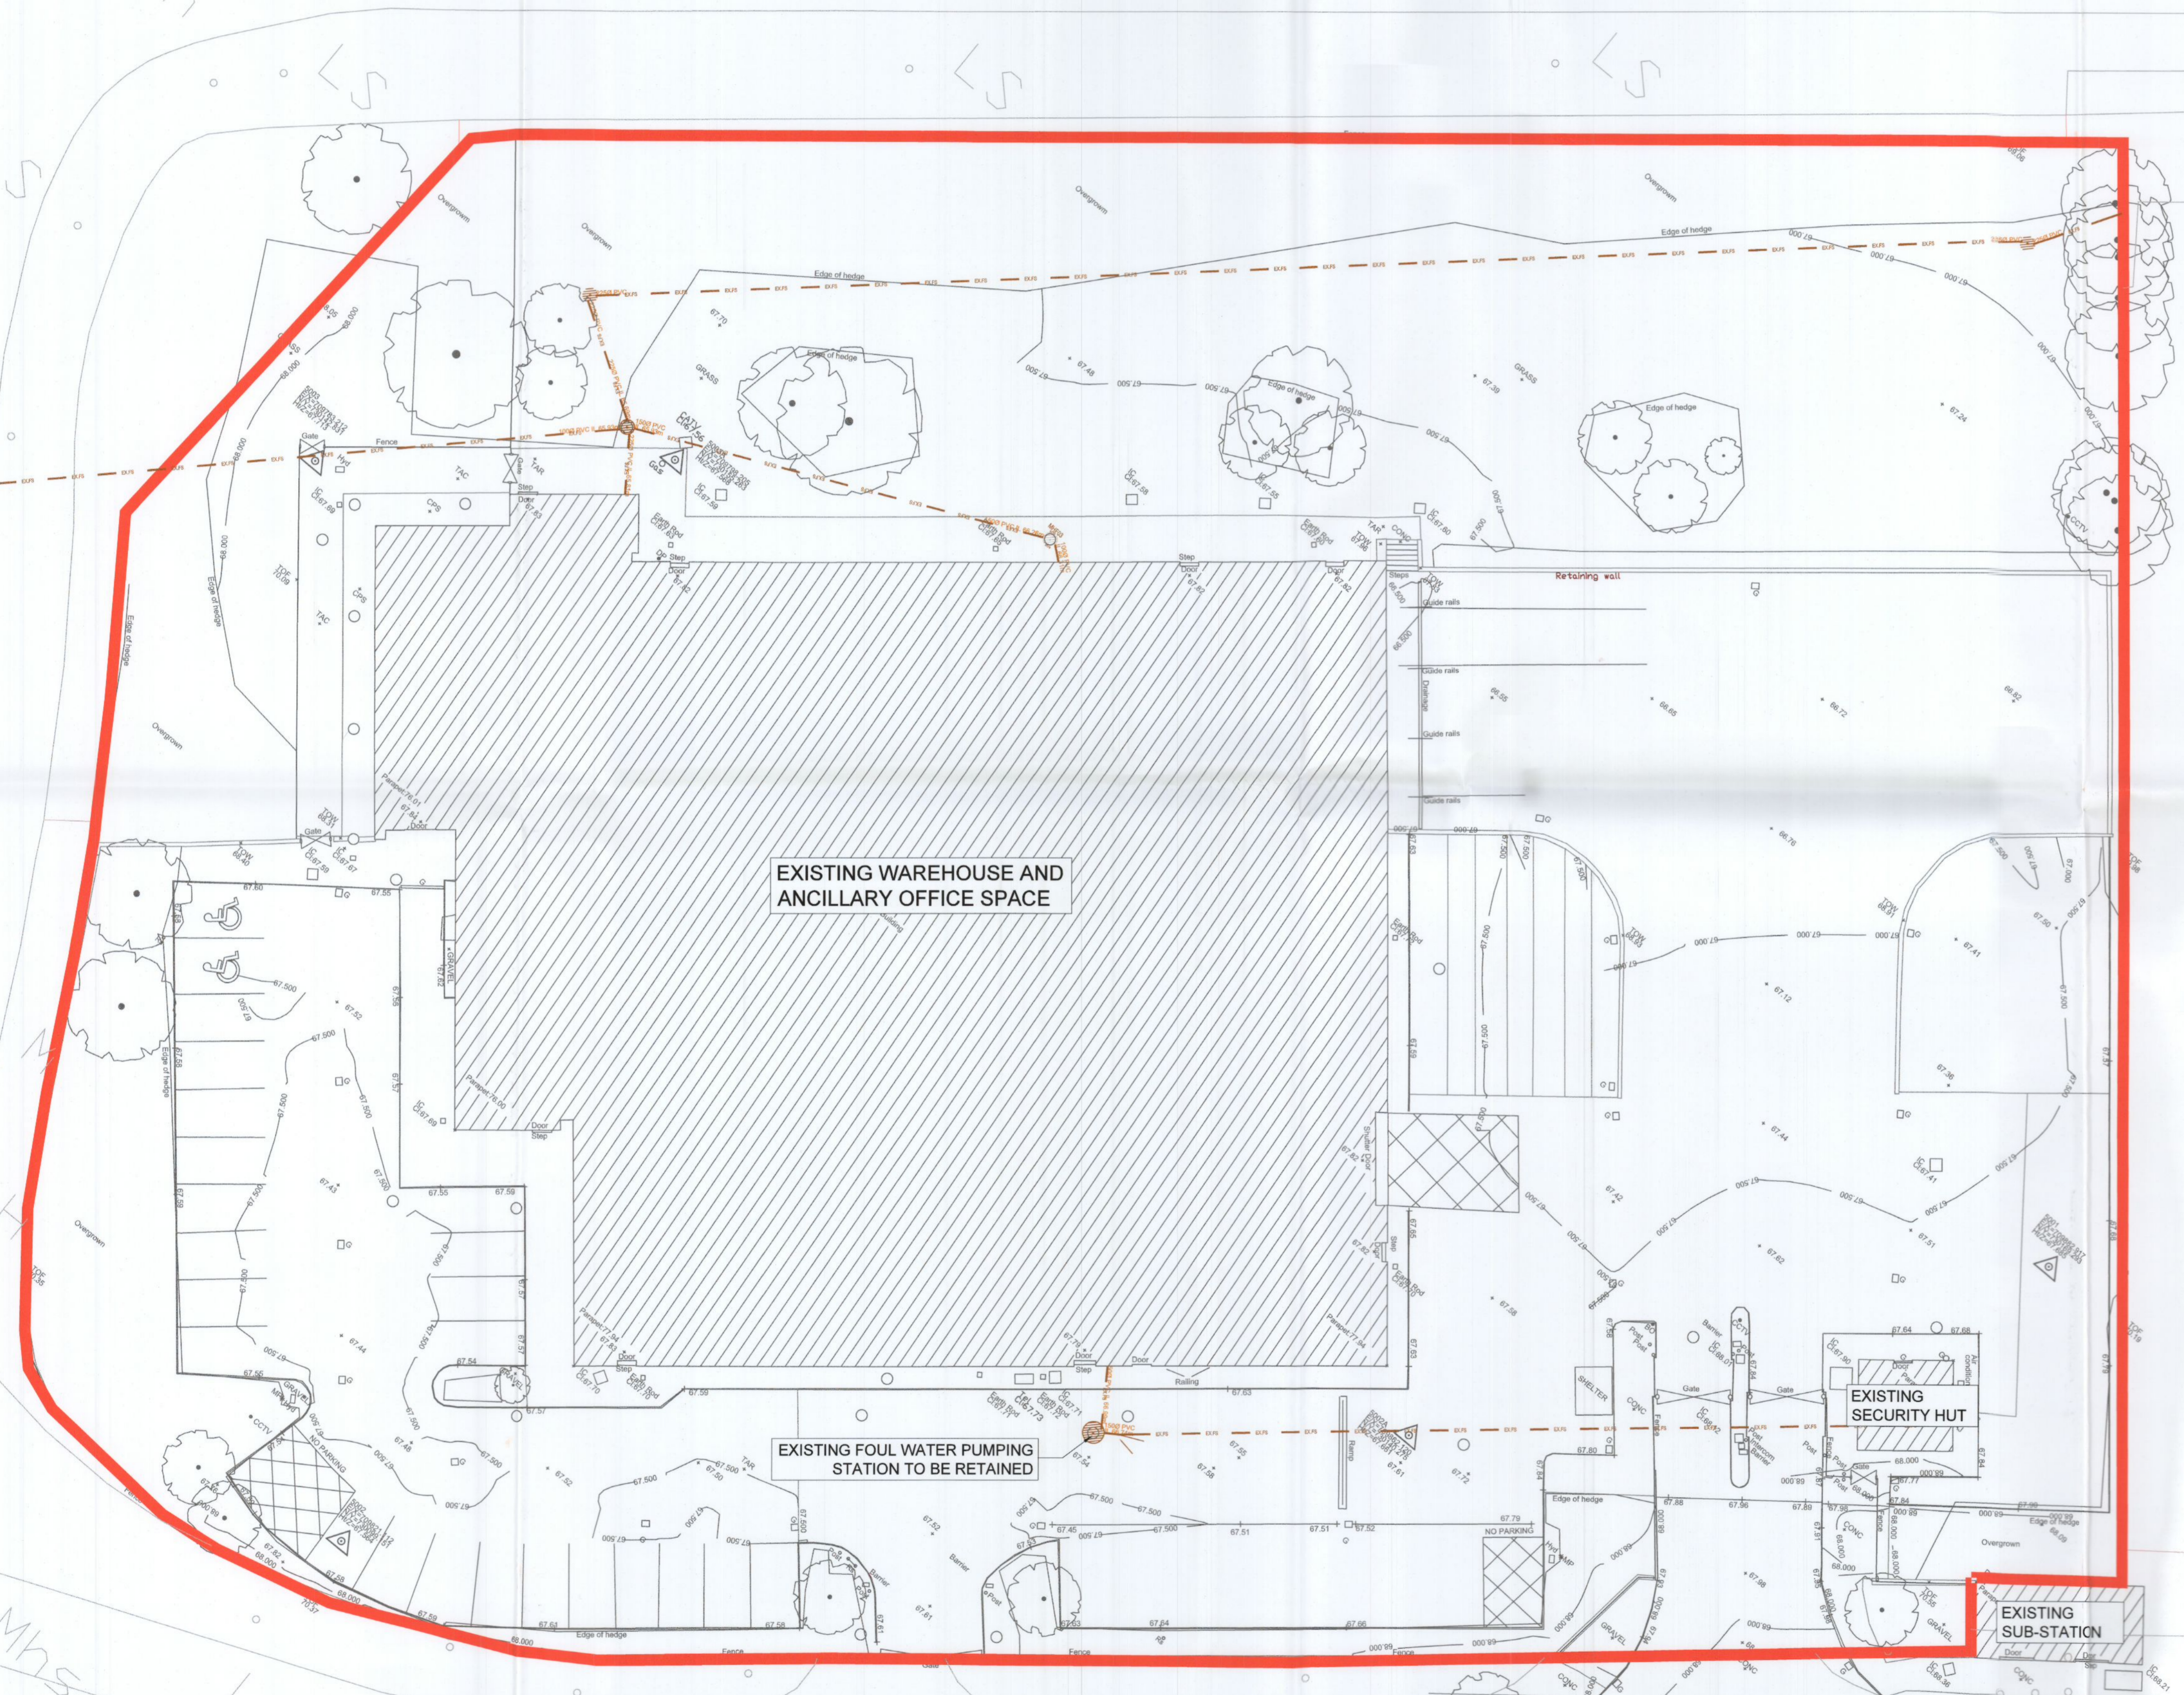

NOTES

NOTE:
EXISTING SERVICES INFORMATION IS BASED ON PAUL CORRIGAN & ASSOCIATES DRAWING NO. PUM-11008-U-DR-0001-3D-01 BALLYMOUNT UTILITY-SURVEY SHEET-10F1 DATED 26TH JULY 2022

KEYNOTES

LEGEND

- OUTLINE OF THE SITE SUBJECT TO THIS APPLICATION**
- EXISTING FOUL SEWER PIPE**
- EXISTING FOUL MANHOLE**

EXISTING WAREHOUSE AND ANCILLARY OFFICE SPACE

EXISTING FOUL WATER PUMPING STATION TO BE RETAINED

EXISTING SECURITY HUT

EXISTING SUB-STATION

REV.	DATE	DESCRIPTION	DRN	ENG	CHK	APP
P03	09/12/22	PLANNING ISSUE	LT	CD	CD	HF
P02	14/10/22	PLANNING ISSUE	LT	CD	CD	HF
P01	02/09/22	DRAFT PLANNING ISSUE	LT	CD	CD	HF

ANY UNAUTHORIZED USE OR REPRODUCTION OF THIS DOCUMENT IN WHOLE OR IN PART IS PROHIBITED. DELETE THIS DOCUMENT IF YOU HAVE RECEIVED IT IN ERROR

MECHANICAL & ELECTRICAL ENGINEER CIVIL & STRUCTURAL ENGINEER

Clifton Scannell Emerson Associates
Clifton Scannell Emerson Associates Limited
 Consulting Engineers, 3rd Floor The Hub, Station Road, Finglas, Dublin 11, Ireland, A68 1X20
 T: +353 1 2360000 FAX: +353 1 2360001 E: info@scemerson.com, W: www.scemerson.com

ARCHITECT **KAVANAGH TUITE ARCHITECTS**
TERMINUS HILLS, CLOMESHAM ROAD, DUN DEUT, BELMONT, DUBLIN, D08 V102
 T: +353 1 2360000 FAX: +353 1 2360001 E: info@kavanaghtuite.ie, W: www.kavanaghtuite.ie

FIRE ENGINEER **BB7**
BB7 Fire & Security Consulting
 Dublin, D08 V102
 T: +353 1 2360000 E: info@bb7fire.com, W: www.bb7fire.com

SECURITY ENGINEER **CUNDALL**
Cundall Engineering Limited
 7 St Stephen's Green, Dublin, D02 RY27, Ireland
 T: +353 1 2360000 E: info@cundall.com, W: www.cundall.com

OTHER ENGINEER

PROJECT: Unit 1, M50 Business Park

TITLE: EXISTING FOUL WASTEWATER DRAINAGE LAYOUT PLAN

DRAWING NO.: 22_112-CSE-00-XX-DR-C-2200

SCALE: A1 1:200

AGILE No.:

REV: P03