
 
 

 
 
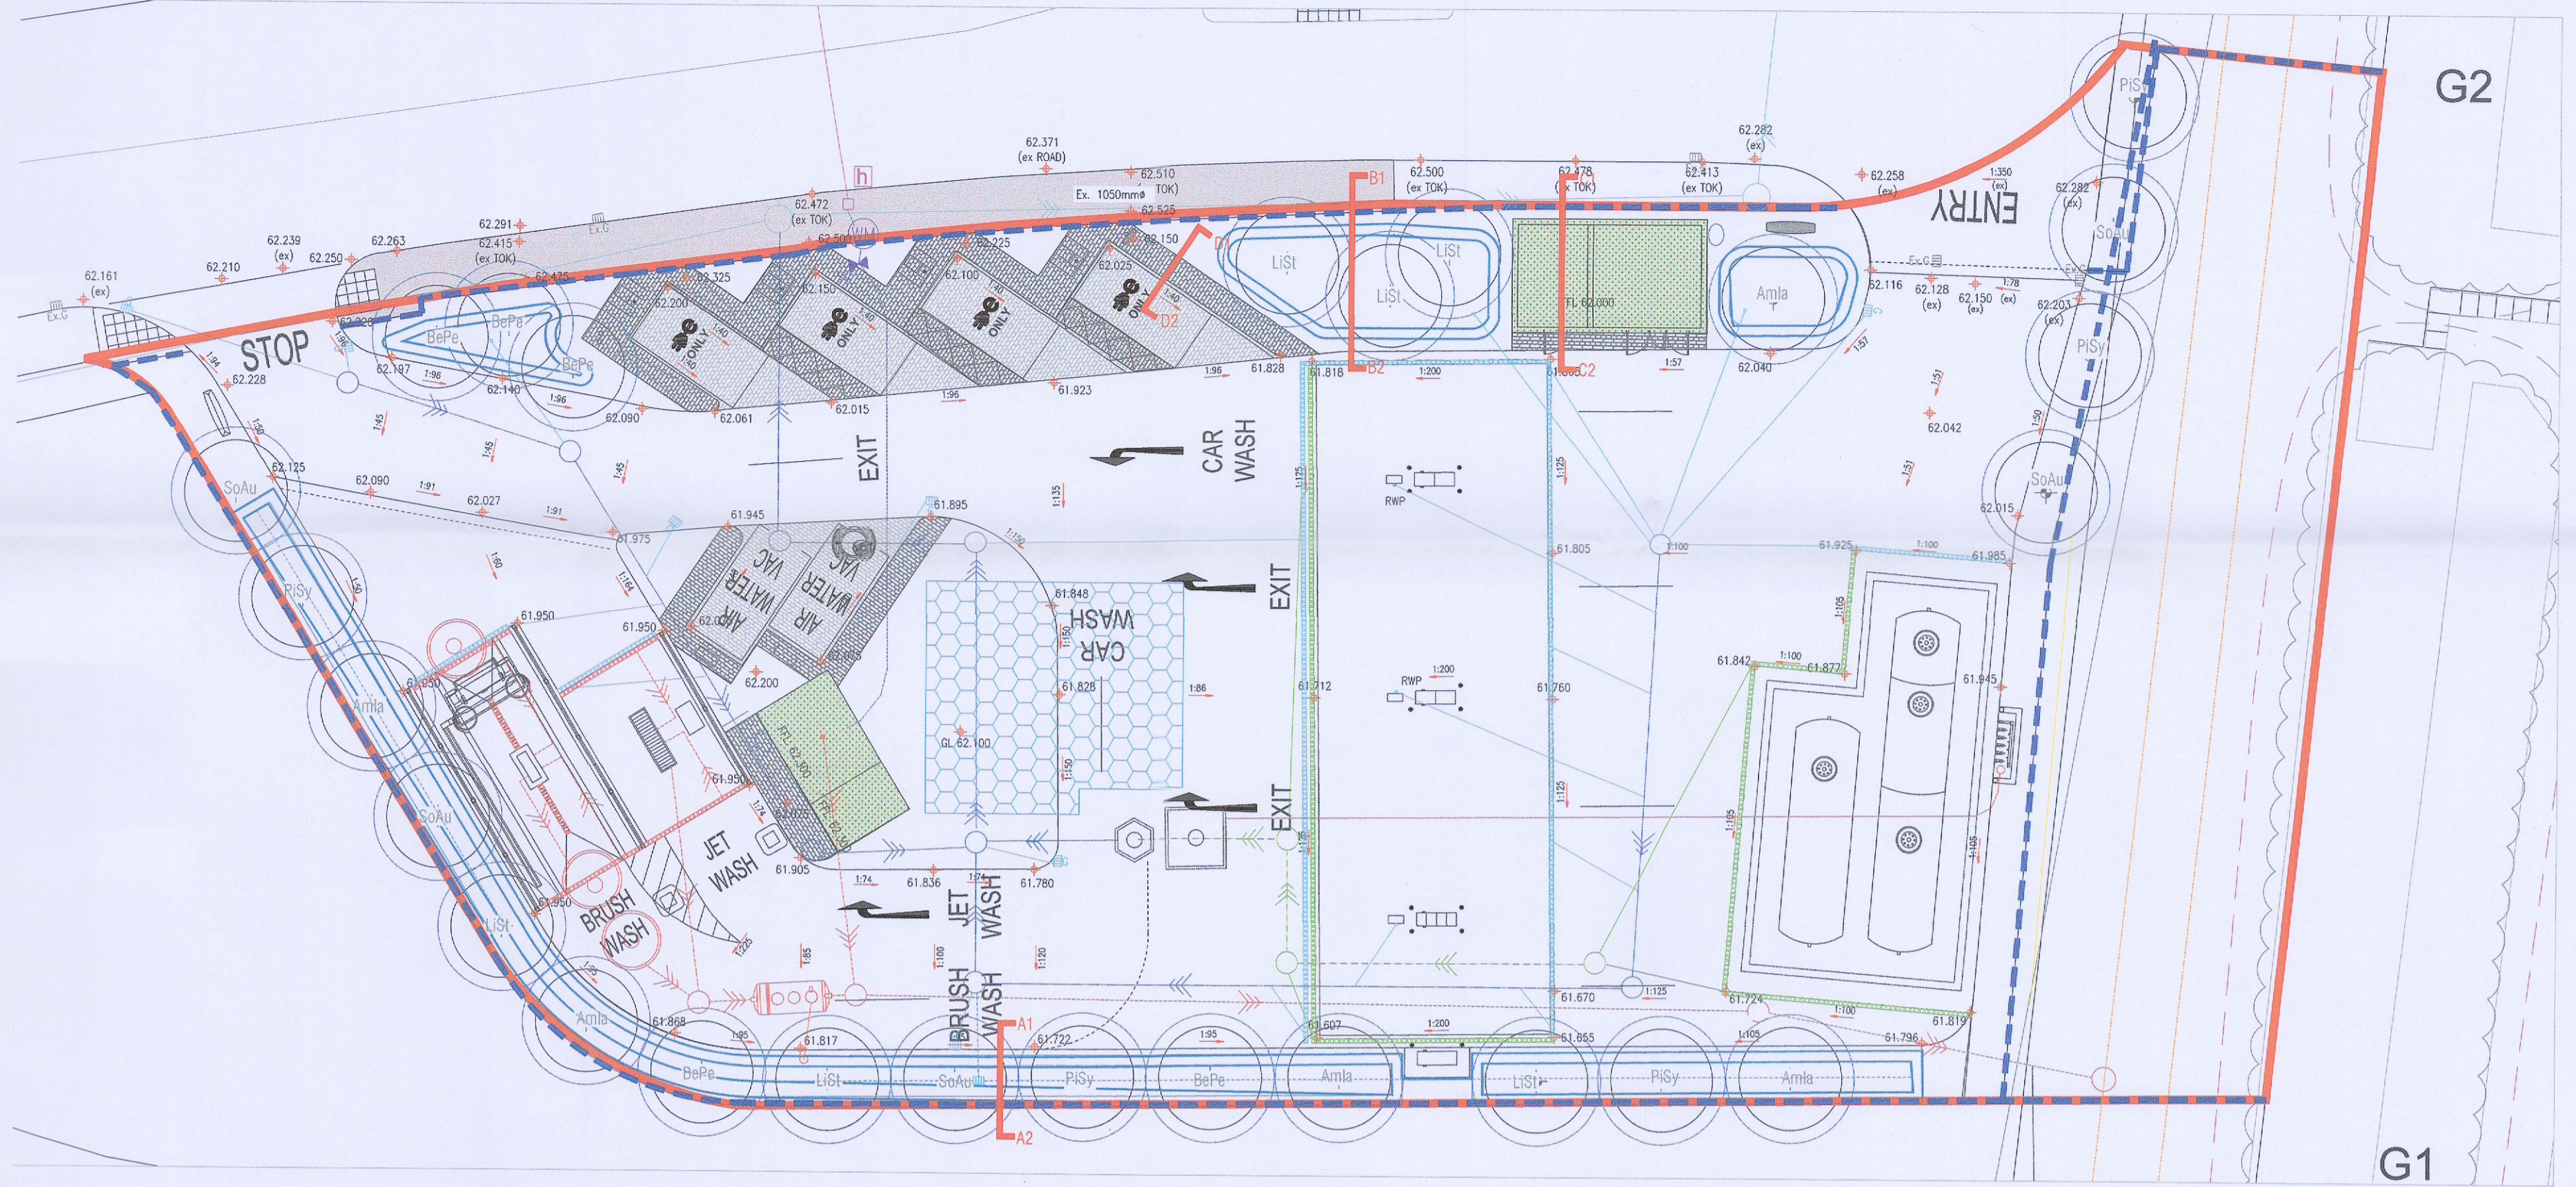



Landscape Tree and Service Plan

Legend:


-  7. Suds Rain Garden/ bio-Swales
-  2.5m radius clearance from tree center
-  Proposed services refer to McArdle Doyle drawing P1956.C04 for detail specification on drainage layouts
-  Green roof refer to McArdle Doyle drawing P1956.C32 for detail specification on green roofs
-  Permeable paving refer to McArdle Doyle drawing P1956.C11 for detail specification on permeable paving
-  Knee high timber rail



Section detail A;
Scale 1: 50 @ A3

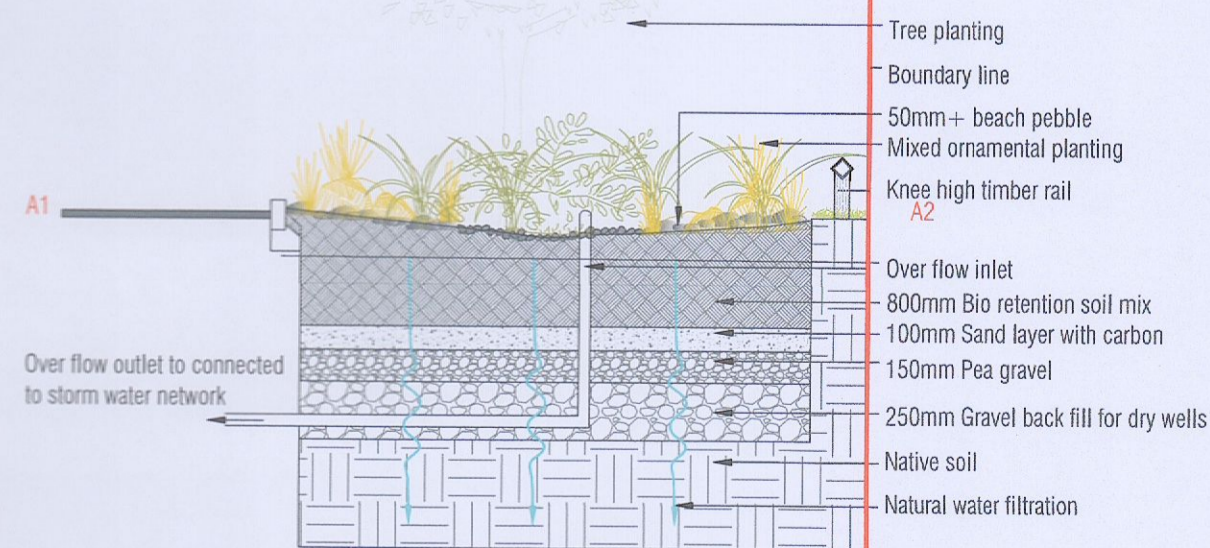


Section detail A; Plan View
Scale 1: 50 @ A3

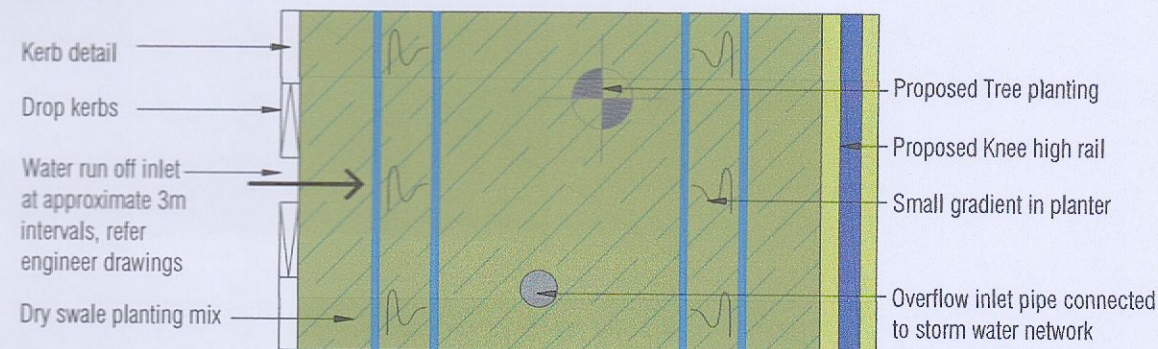


Refer to McArdle Doyle drawing no. P1956.C32 for detailed specification and design of rain garden bio-swale


Section detail B;
Scale 1: 50 @ A3

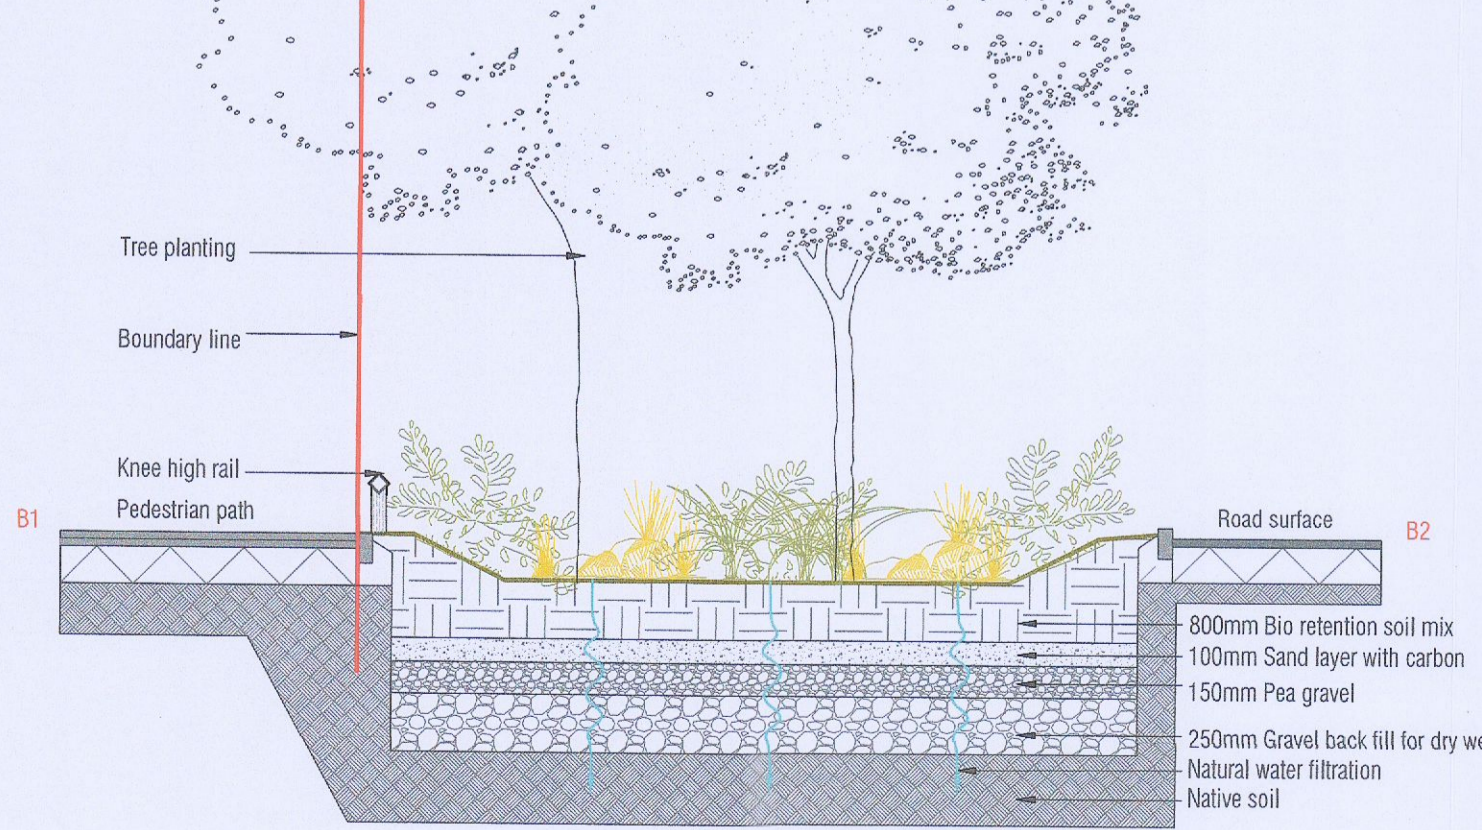

Detail C; Typical Green roof detail
Scale 1: 20 @ A3

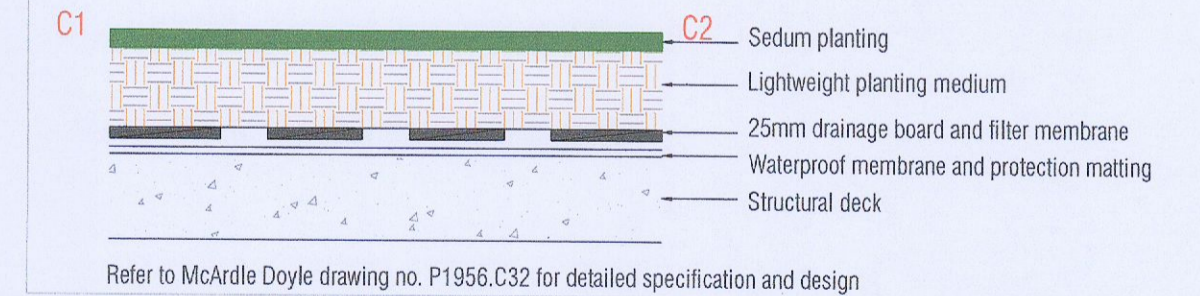

Detail D; Permeable paving
Scale 1: 20 @ A3

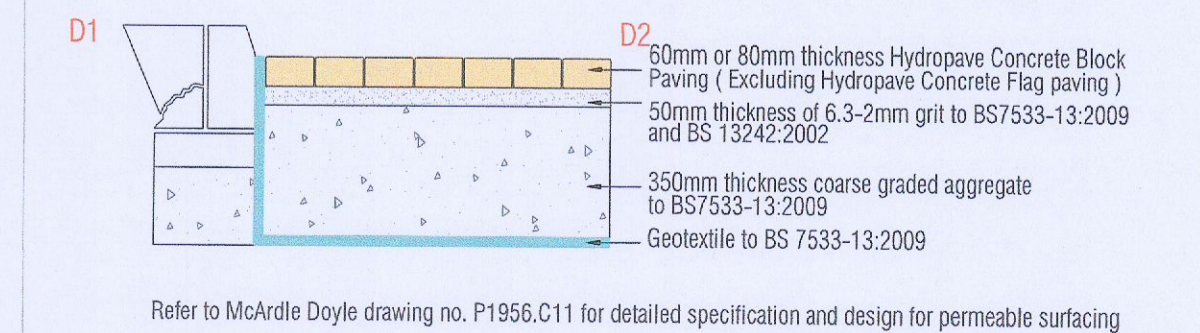

JANE MCCORKELL DESIGN Architects, Co. Meath, Ph: 087 682920 Email: jane@mccorkell.com	Registered Landscape Architect The Irish Landscape Institute 2022 - 2023	Title: Tree and services plan with sections	Dwg ref: PP397-03-01
		Client: Certas Energy Ireland Limited	Scale: 1:200 Size: A2
		Date: JAN 2023	Drawn by: SH
		Project: Fonthill Road, Liffey Valley	Checked by: JMC
			Rev:

This drawing is the copyright of Jane McCorkell Landscape & Garden Design has been produced for the client and project as stated above. The drawing may not be reproduced or amended, except by the written permission of Jane McCorkell Landscape & Garden Design. No liability will be accepted for any amendments made by other persons. ©