


NOTES


1. ALL WASTEWATER INFRASTRUCTURE TO BE INSTALLED IN ACCORDANCE WITH IRISH WATER CODE OF PRACTICE FOR WASTEWATER INFRASTRUCTURE AND STANDARD DETAILS
2. ALL SURFACE WATER INFRASTRUCTURE TO BE INSTALLED IN ACCORDANCE WITH THE GDSDS AND THE GREATER DUBLIN REGION CODE OF FOR DRAINAGE WORKS.

REFERENCE NOTE


REFER TO DWG. NO. B981-OCSC-XX-XX-DR-C-0505 FOR DRAINAGE LAYOUT

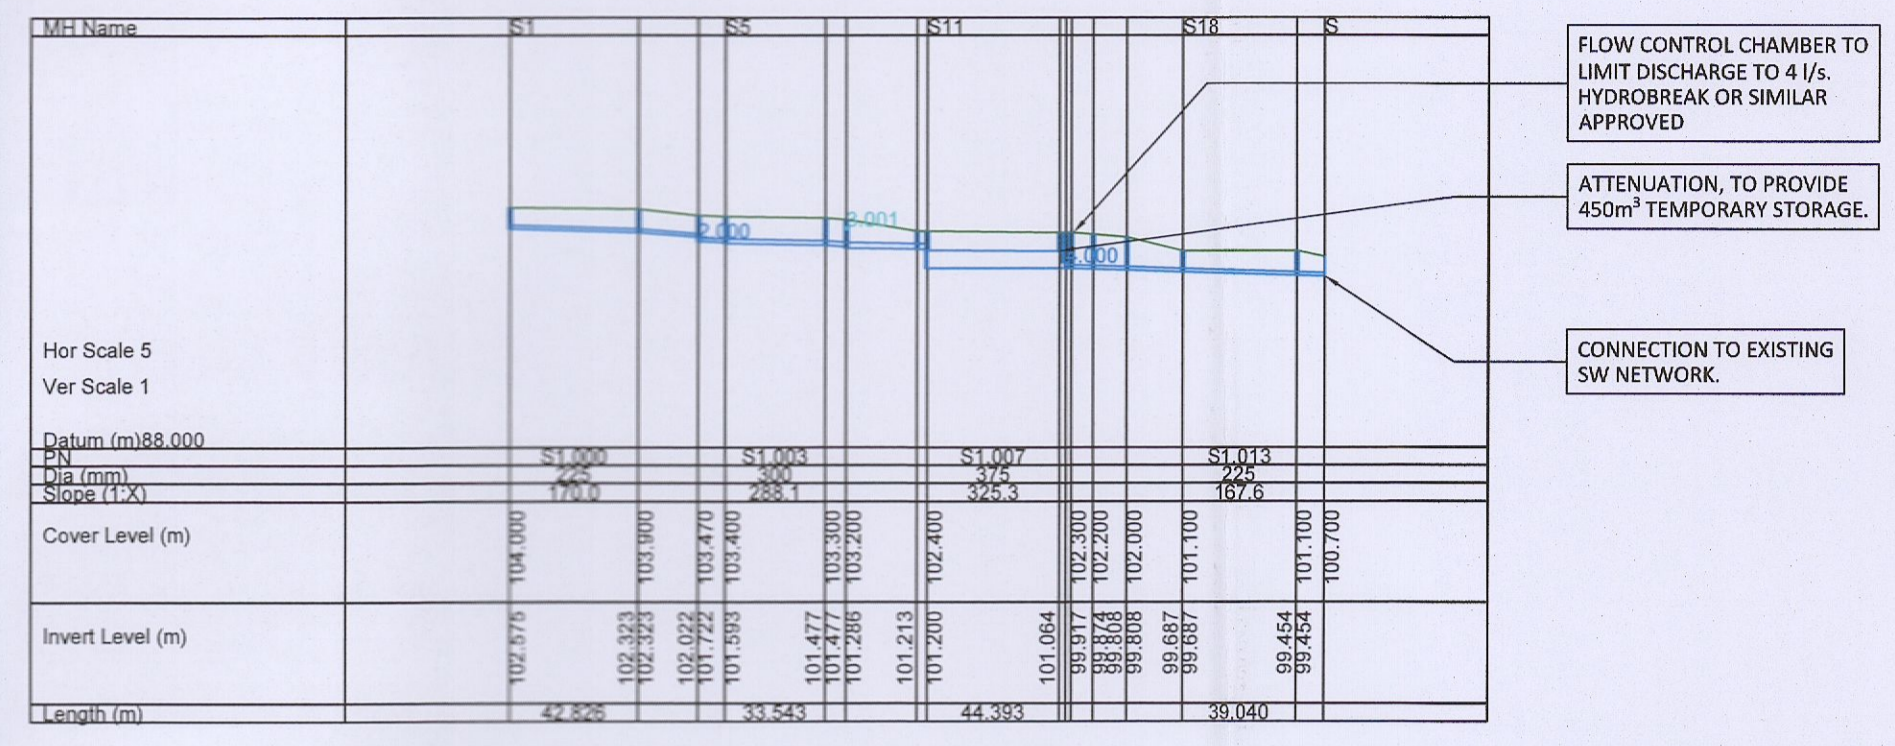


SURFACE WATER NETWORK S1.000 - S1.014

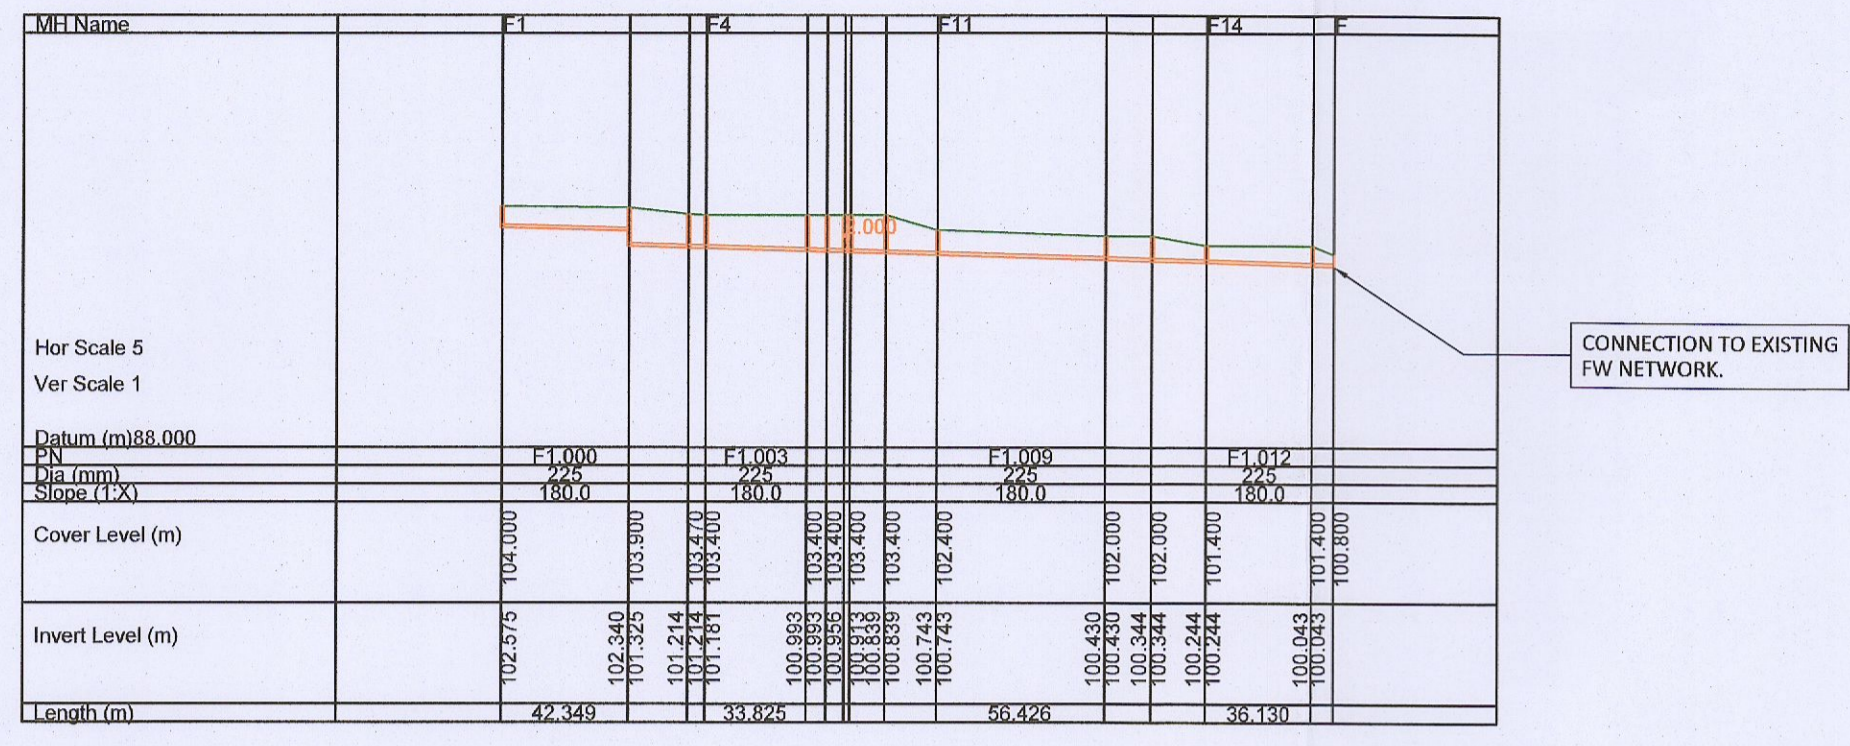


WASTE WATER NETWORK F1.000 - F1.013

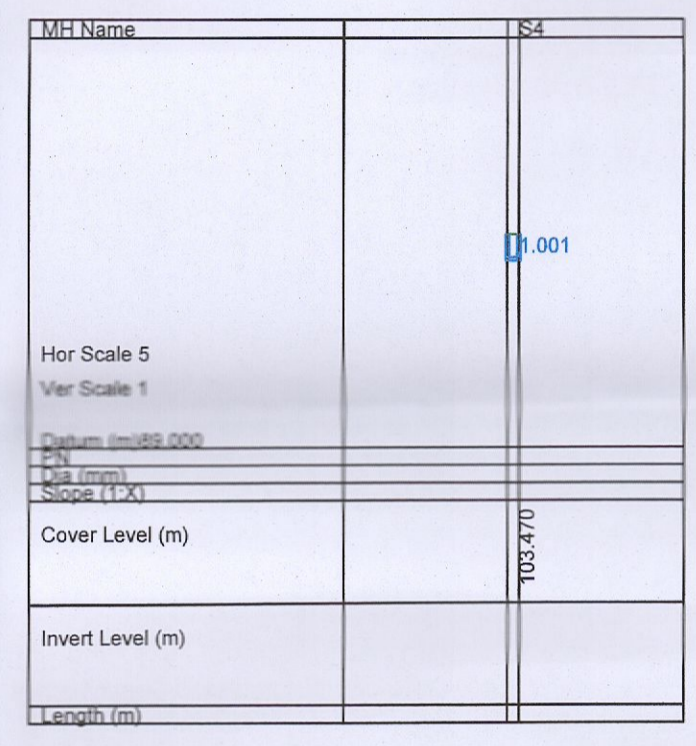


SURFACE WATER NETWORK S2.000

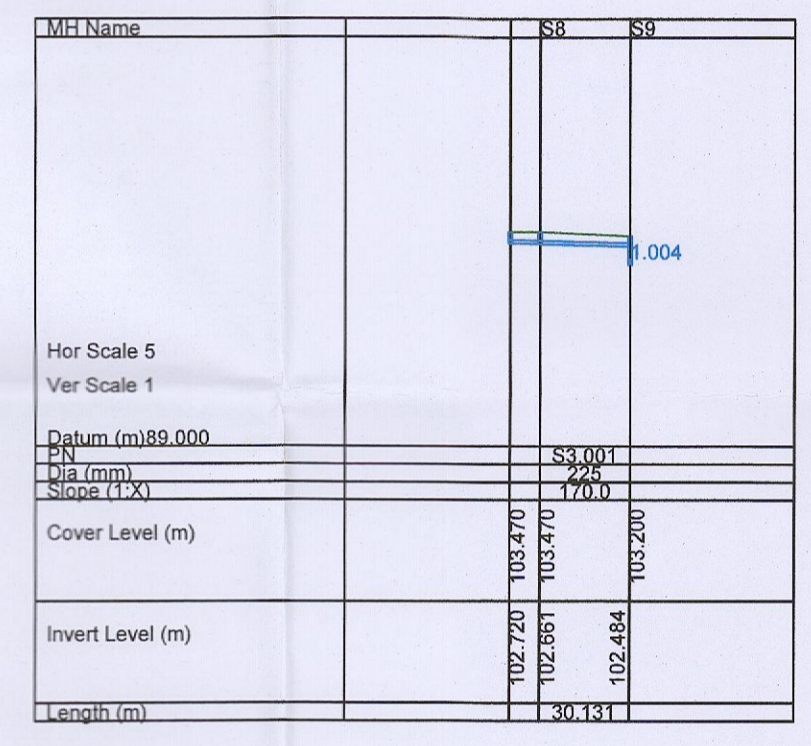

SURFACE WATER NETWORK S3.000 - S3.001

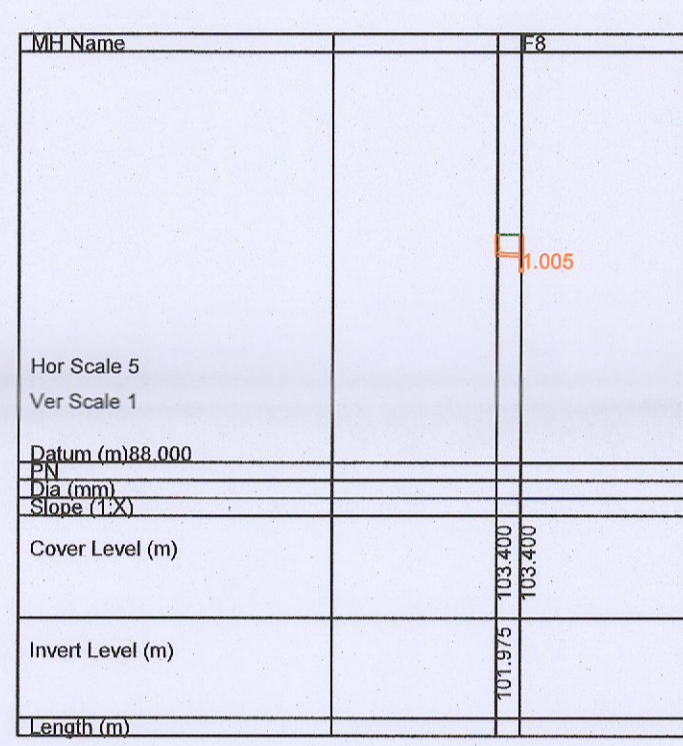

WASTE WATER NETWORK F5.000

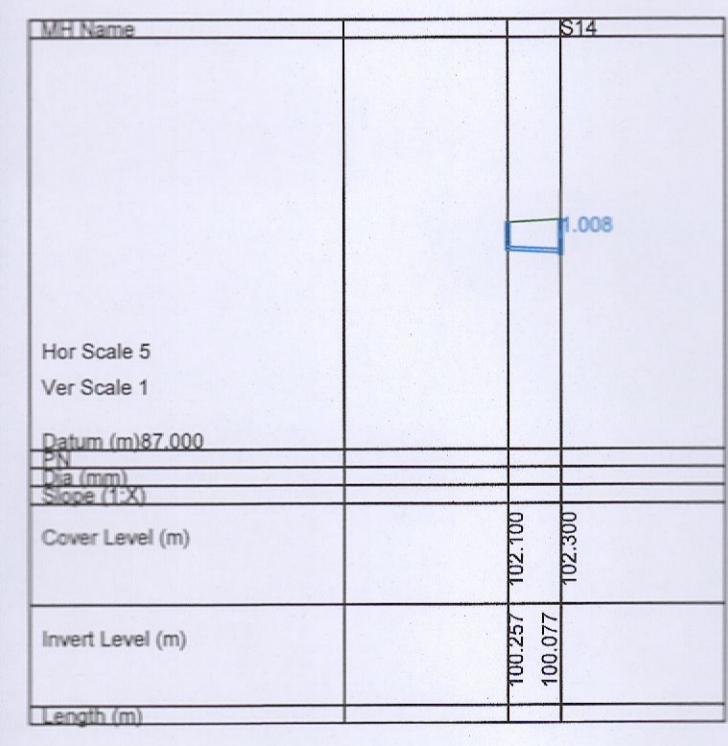

SURFACE WATER NETWORK S4.000

STORMWATER LONGSECTIONS
SCALE: 1:500


WASTEWATER LONGSECTIONS
SCALE: 1:500

PLANNING DRAWING.
NOT FOR CONSTRUCTION.
ALL LEVELS GIVEN ARE
RELATIVE TO ORDNANCE DATUM.
THIS DRAWING HAS BEEN ISSUED FOR INFORMATION
PURPOSES ONLY AND MUST NOT BE USED
FOR CONSTRUCTION UNDER ANY CIRCUMSTANCES

- FOR SETTING OUT REFER TO ARCHITECT'S DRAWINGS.
- THIS DRAWING TO BE READ IN CONJUNCTION WITH ALL OTHER ARCHITECTURAL AND ENGINEERING DRAWINGS AND ALL OTHER RELEVANT DRAWINGS AND SPECIFICATIONS.
- DO NOT SCALE THIS DRAWING. USE FIGURED DIMENSIONS ONLY.
- NO PART OF THIS DOCUMENT MAY BE REPRODUCED OR TRANSMITTED IN ANY FORM OR STORED IN ANY RETRIEVAL SYSTEM OF ANY NATURE WITHOUT THE WRITTEN PERMISSION OF O'CONNOR SUTTON CRONIN AS COPYRIGHT HOLDER EXCEPT AS AGREED FOR USE ON THE PROJECT FOR WHICH THE DOCUMENT WAS ORIGINALLY ISSUED.

Rev No.	Date	Revision Note	Drn by	Chkd by
P01	05.09.22	SUITABLE FOR INFORMATION	COR	PR
P02	14.09.22	SUITABLE FOR PLANNING	COR	PR
P03	20.01.23	SUITABLE FOR PLANNING	COR	PR

Rev No.	Date	Revision Note	Drn by	Chkd by

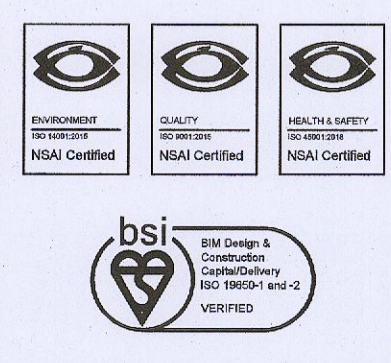

Head Office,
9 Prussia Street,
Dublin 7,
D07 KT57

TEL +353 (0)1 8682000

e: contactus@ocsc.ie
w: www.ocsc.ie

Dublin | London | Belfast | Galway | Cork | Birmingham



Client: BARTRA PROPERTY COOKSTOWN LTD
Project: TRANSITIONAL CARE FACILITY
COOKSTOWN INDUSTRIAL ESTATE, DUBLIN 24
Title: DRAINAGE NETWORK LONGSECTIONS

Code | Originator | Zone | Level | Type | Role | Number | Status | Revision
B981-OCSC-XX-XX-DR-C-0506 | S4 | P03

Date: 05.09.22 Scale: SHWN @ A1 Drn by: COR Chkd by: EH Aprvd by: PR